

VICINITY MAP


SCALE: NONE

- #### SCOPE OF WORK
- FSW WILL RELOCATE OR ADD SPRINKLERS HEADS TO ACCOMMODATE THE NEW WALLS AND CEILINGS AT EXISTING SPACE.
- #### EXCLUSIONS
- OFF HOURS AND TAXES.
 - RELOCATION OF EXISTING PIPING.
 - GW/CUT AND PATCH.
 - PAINTING OF ANY KIND.
 - WIRING OF ANY KIND.
 - REPLACE, REPAIR, OR MODIFICATION OF CEILING TILES.
 - ABATEMENT OF ANY KIND.
 - STRUCTURAL VERIFICATION IF REQUIRED.

TENANT IMPROVEMENT

THIS PROJECT IS A TENANT IMPROVEMENT. THIS FACILITY HAS ALREADY BEEN PROTECTED BY A FIRE SPRINKLER SYSTEM. FIRE SYSTEMS WEST IS ADDING AND/OR RELOCATING SPRINKLER HEADS TO ACCOMMODATE THE NEW TENANT WALL, CEILING, LIGHTING AND HVAC LAYOUT. ALL WORK WILL BE DONE WITHOUT AFFECTING THE CAPABILITY OF THE EXISTING SYSTEM.

- #### SYMBOL LEGEND
- - DENOTES A SPRINKLER HEAD TO BE RELOCATED.
 - - DENOTES A SPRINKLER HEAD TO BE ADDED.
 - ⊗ - DENOTES EXISTING SPRINKLER HEAD TO BE DEMO OR PLUGGED.
 - ⊗ - INDICATES EXISTING SPRINKLER TO REMAIN.
 - MT - MECHANICAL TEE
 - - REPRESENTS EXISTING SPRINKLER PIPE.
 - - REPRESENTS NEW SPRINKLER PIPE.

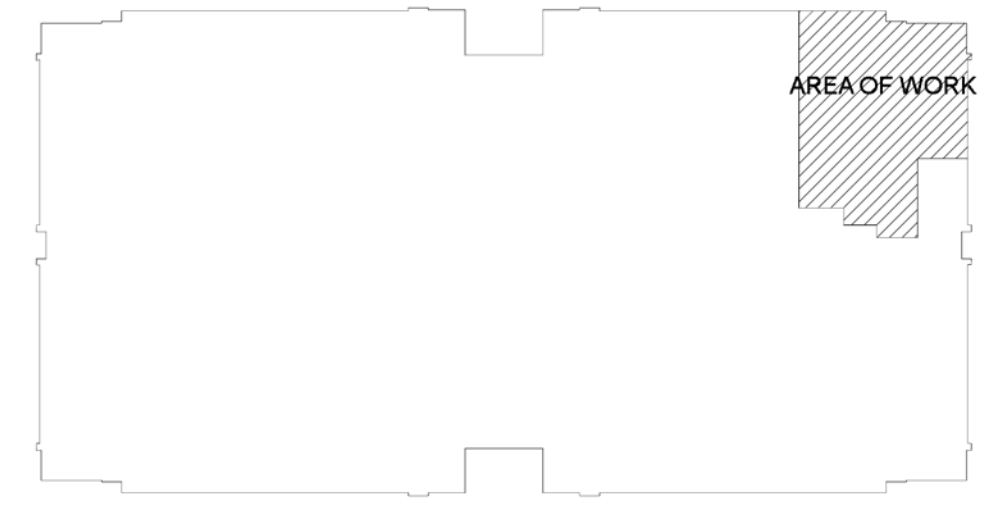


KEY PLAN

SCALE: NONE

PARTIAL 3RD FLOOR TI PLAN

SCALE: 1/4" = 1'-0"

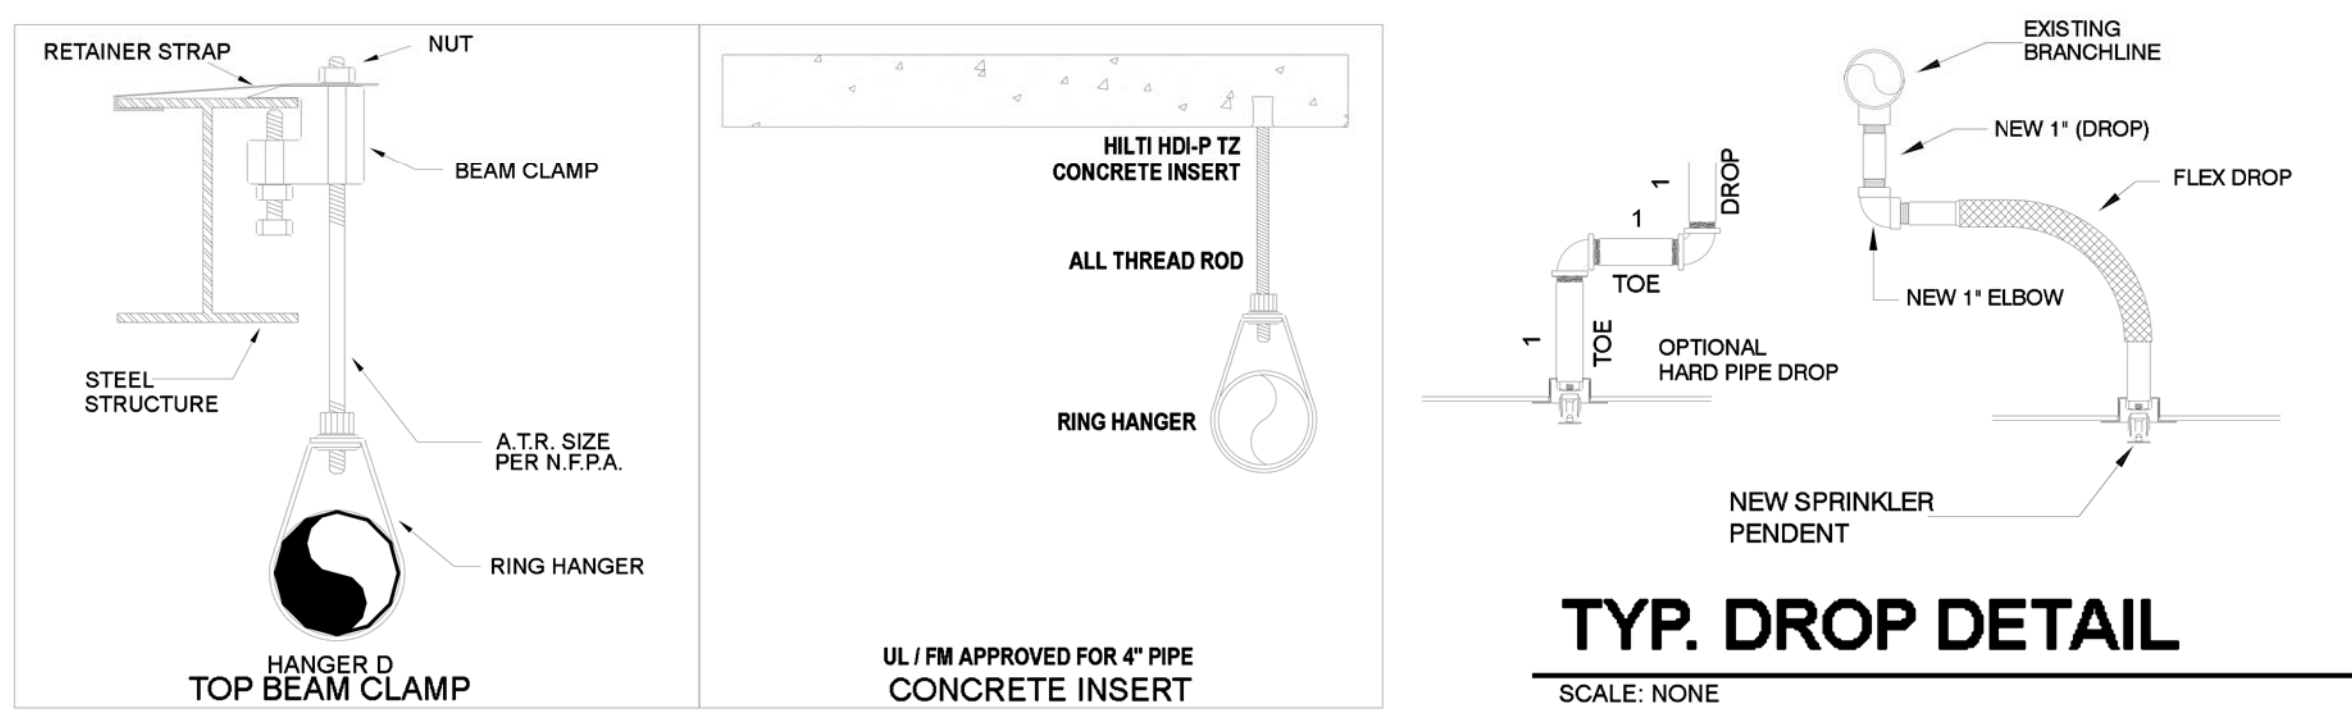

City of Puyallup
Fire
REVIEWED FOR COMPLIANCE
D. Drake
02/21/2023
8:00:14 AM

THE APPROVED CONSTRUCTION PLANS AND ALL ENGINEERING MUST BE POSTED ON THE JOB AT ALL INSPECTIONS IN A VISIBLE AND READILY ACCESSIBLE LOCATION.

Approval of submitted plans is not an approval of omissions or oversight by this office or noncompliance with any applicable regulations of local government. The contractor is responsible for making sure that the building complies with all applicable building codes and regulations of the local government.

City of Puyallup
Development & Permitting Services
ISSUED PERMIT

| | |
|-------------|--------------|
| Building | Planning |
| Engineering | Public Works |
| Fire | Traffic |

WASHINGTON STATE
CERTIFICATE OF COMPETENCY
FIRE PROTECTION SPRINKLER SYSTEMS
Craig A. Miller
9719-0108-C Level 3
Fire Systems West, Inc.
FRESW14061
Expires 12/31/22

FIRE SPRINKLER PLAN

| HANGER LEGEND | | SPRINKLER HEADS | | | | | | | | | REVISIONS | | |
|---------------|-------------------|-----------------|--------------------|---------|--------|------|--------|--------|-----|----|-----------|----|-------------|
| SYM | TYPE | MFG | MODEL | ORIFICE | THREAD | TEMP | FINISH | CANOPY | QTY | MK | DATE | BY | DESCRIPTION |
| A | U-HOOK | L | L-RD | | | | | | | | | | |
| B | SUPER SCREW | M | WASHER PLATE | | | | | | | | | | |
| C | CONCRETE INSERT | N | | | | | | | | | | | |
| D | TOP BEAM CLAMP | P | POWDER DRIVEN STUD | | | | | | | | | | |
| E | HOLD-P | TZ | SAMMY EXPRESS | | | | | | | | | | |
| F | HOLD-P | TZ | | | | | | | | | | | |
| G | CEILING FLANGE | U | | | | | | | | | | | |
| H | SIDE BEAM BRACKET | W | | | | | | | | | | | |
| J | SIDEWINDER | X | | | | | | | | | | | |
| K | SHORT CLIP | Y | | | | | | | | | | | |
| TOTAL | | | | | | | | | 16 | | | | |

APPROVALS REQUIRED:

| | | |
|-------------------|-------------------|---|
| AHJ | AHJ | 3 |
| OWNER / ARCHITECT | OWNER / ARCHITECT | 1 |
| FIRE SYSTEMS WEST | FIRE SYSTEMS WEST | 1 |

DESIGN CRITERIA AND NOTES

- ALL BRANCHLINE PIPING TO BE THREADED SCH 40 JOINED W/ CAST IRON FITTINGS (UNO).
- ALL NEW HANGERS TO BE PER HANGER DETAIL(S).
- ALL NEW HEADS AT ACoustICAL CEILING TO BE ON FLEX DROP FITTINGS.
- ALL NEW CONNECTIONS TO EXISTING PIPE TO BE MADE WITH MECHANICAL TEE (UNO).

GENERAL NOTES

- ALL MATERIAL AND EQUIPMENT TO BE NEW AND UNDERWRITERS APPROVED.
- PIPING DIMENSIONS ARE CENTER TO CENTER EXCEPT RISER & DIMENSIONS SHOWN THUSLY (1'-6") WHICH ARE END TO END.
- EARTHQUAKE BRACING SHALL BE PROVIDED IN ACCORDANCE WITH NFPA #13.
- PIPE HANGERS AND METHOD OF HANGING TO BE IN ACCORDANCE WITH NFPA #13.
- PIPING SHALL BE IN ACCORDANCE WITH NFPA #13.
- JOINING OF PIPE AND FITTINGS, THREADED AND WELDED SHALL BE IN ACCORDANCE WITH NFPA #13.
- OWNER TO PROVIDE ADEQUATE HEAT TO PREVENT WATER IN PIPES FROM FREEZING IN AREAS PROTECTED BY WET PIPE SPRINKLER SYSTEM.
- STRUCTURAL ADEQUACY OF THE BUILDING TO SUPPORT THE SPRINKLER PIPING IS THE RESPONSIBILITY OF THE OWNER OR HIS STRUCTURAL REPRESENTATIVE.

CONTRACT NAME:
MULTICARE WOMEN'S CLINIC
1450 5TH ST. SE
PUYALLUP, WA 98372

CONTACT WITH:
COLVUS CONSTRUCTION
711 COURT C
TACOMA, WA 98402
CONTACT: JASON WALKER
Phone: 253-844-4640 Fax:

Fire Systems West
206 Frontage Road North, Suite C
Pacific, WA. 98047
(253) 833-1248 Fax: (253) 735-0113

WA CL# FRESW14061

| | | | |
|-------------|----------|------------------|--------|
| DESIGNER | DATE | Q.C. INSTALL BY: | SHEET |
| KEVIN RIDER | 11/22/22 | 2-11-11992 | 1 OF 1 |

FILE:2-11-1992_Rev00_MultiCare Women's Clinic.dwg DATE:11/22/22 TIME:11:05:09