

PRCTI20230098

**MOUNTING HEIGHTS GENERAL NOTES**

1. ALL MOUNTING HEIGHTS APPLY THROUGHOUT UNO.
2. SEE SHEET A-002 FOR ACCESSIBILITY REQUIREMENTS
3. SEE SHEET A-002 FOR TOILET PAPER DISPENSER MOUNTING RANGE

**REQUIRED PLUMBING FIXTURES:**

384 OCCUPANTS / 2 = 192 MEN, 192 WOMEN

WATER CLOSETS REQUIRED: 4 MEN, 4 WOMEN  
 WATER CLOSETS PROVIDED: 3 MEN, 5 WOMEN, 4 UNISEX (12 TOTAL)  
 URINALS PROVIDED: 2

LAVATORIES REQUIRED: 4 MEN, 4 WOMEN  
 LAVATORIES PROVIDED: 2 MEN, 2 WOMEN, 4 UNISEX (8 TOTAL)

THE APPROVED CONSTRUCTION PLANS, DOCUMENTS AND ALL ENGINEERING MUST BE POSTED ON THE JOB AT ALL INSPECTIONS IN A VISIBLE AND READILY ACCESSIBLE LOCATION.

FULL SIZED LEDGIBLE COLOR PLANS ARE REQUIRED TO BE PROVIDED BY THE PERMITEE ON SITE FOR INSPECTION

**City of Puyallup Building APPROVED**

See permit for additional requirements.


JMontgomery  
 03/10/2023  
 3:10:37 PM

Approval of submitted plans is not an approval of omissions or oversights by this office or noncompliance with any applicable regulations of local government. The contractor is responsible for making sure that the building complies with all applicable codes and regulations of the local government.

Reviewed for compliance by David L  
 Comments reviewed by Janelle

**1 ENLARGED RESTROOM PLAN**

A-401 SCALE: 3/8" = 1'-0"

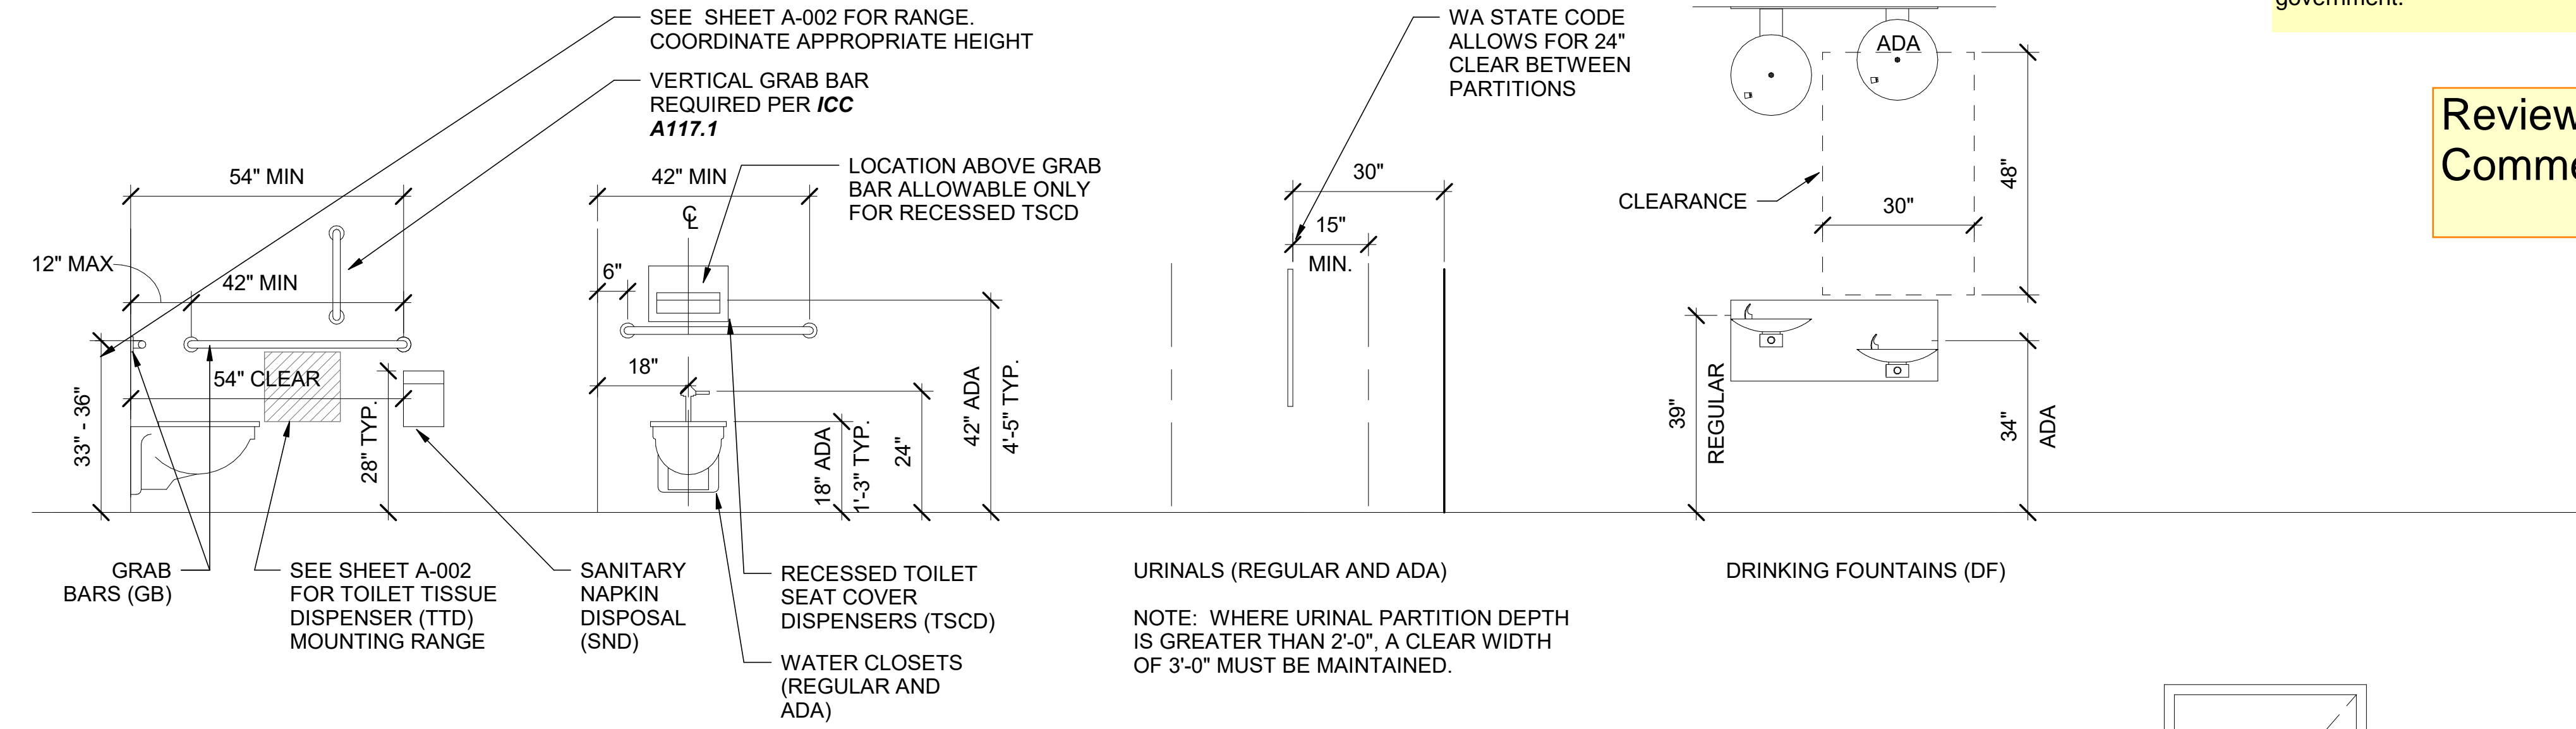

**MOUNTING HEIGHTS**

SCALE: 1/2" = 1'-0"

**City of Puyallup Development & Permitting Services ISSUED PERMIT**

Building Planning  
 Engineering Public Works  
 Fire Traffic

DESIGNER

**Md+m**

MARSHALL DESIGN + MANAGEMENT  
 12400 SE 38TH #50766  
 BELLEVUE, WA 98105

CLIENT AND PROJECT LOCATION

**Benaroya**

BENAROYA  
 SOUTH HILL BUSINESS AND TECHNOLOGY CENTER  
 1015 39TH AVE SE  
 PUYALLUP, WA 98374

PROJECT

CENTRAL PIERCE FIRE AND RESCUE  
 1015 39TH AVE SE, SUITE 120  
 PUYALLUP, WA 98374

ARCHITECT

WJA DESIGN-COLLABORATIVE  
 617 WESTERN AVE  
 SEATTLE, WA 98104

STAMP

ISSUANCE

ISSUE DATE	02/17/2023
DRAWN BY:	WJA
CHECKED BY:	WJA

REVISION LIST

NO.	DATE	DESCRIPTION	BY
1	01/30/23	PERMIT SET	
1	02/17/23	100% CONSTRUCTION DOCS	

KEY PLAN

SHEET TITLE

**ENLARGED RESTROOM PLAN AND MOUNTING HEIGHTS**

SHEET NUMBER

**A-401**

