


City of Puyallup
Development & Permitting Services
ISSUED PERMIT

Building	Planning
Engineering	Public Works
Fire	Traffic

City of Puyallup
Development
Engineering
APPROVED

See permit
for additional
requirements.

Linda Lian
03/29/2023
9:37:26 AM




PRCTI20230310

In accordance to City Standard 04.03.04 this project is required to install a sewer sampling tee on the existing sewer lateral. Building occupancy will not be granted until the installation is completed and a final approval granted.


PROJECT ADDRESS:
1601 INDUSTRIAL PARK WAY, SUITE #100
PUYALLUP, WA 98371

PARCEL NUMBER: 0420212076

Project no: 22.0243.00	Location: PUYALLUP 1	Issued to: CITY OF PUYALLUP	Revision: -	Date: 03.13.23
Title: PUYALLUP 1 SITE PLAN 1601 INDUSTRIAL PARK WAY, SUITE 100 PUYALLUP, WA 98371			Drawn by: MK	
			Scale: NTS	
			Sketch No.: SITE	

City of Puyallup Development & Permitting Services ISSUED PERMIT	
Building	Planning
Engineering	Public Works
Fire	Traffic

SIDE SEWER CONNECTION

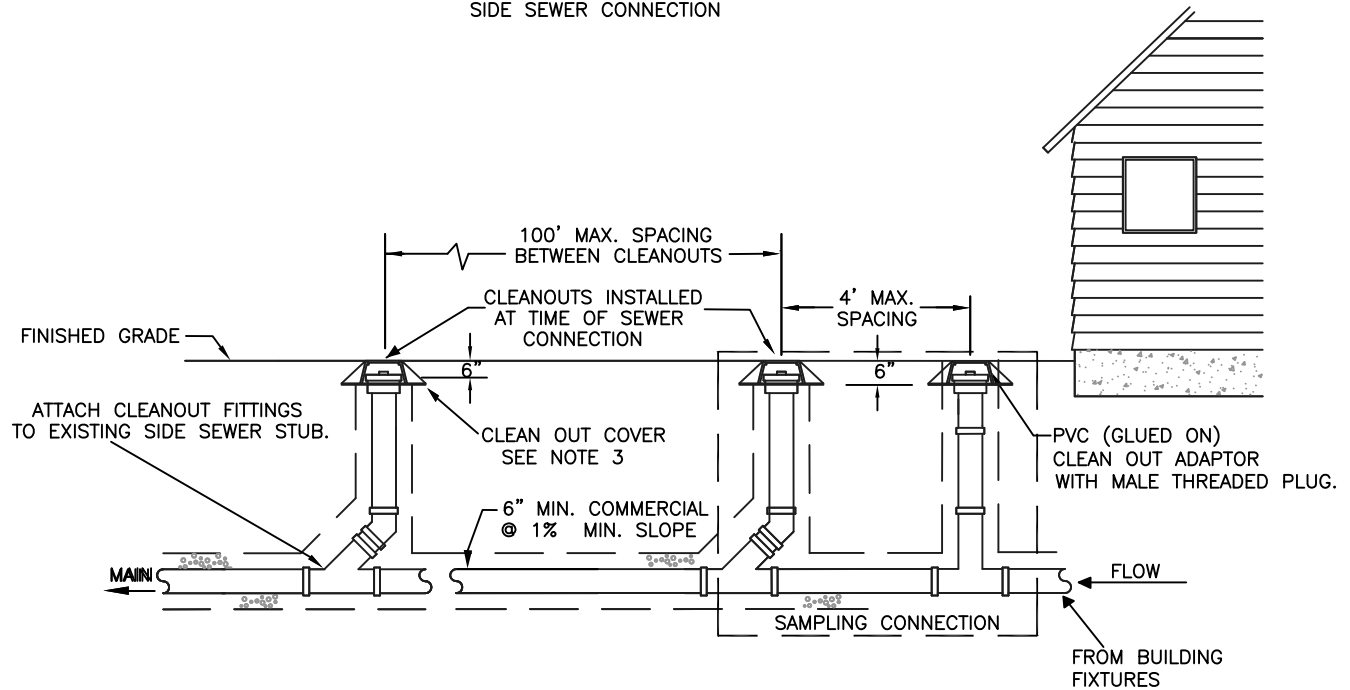

NOTES:

1. SAMPLING CONNECTION SHALL BE INSTALLED OUT SIDE WITH UNOBSTRUCTED ACCESS AT ALL TIMES.
2. A SAMPLING CONNECTION SHALL BE INSTALLED FOR EACH COMMERCIAL / RETAIL UNIT OR SPACE.
3. CLEAN OUT AND SAMPLING CONNECTION COVERS:
 - A) FOR NON-VEHICULAR TRAFFIC INSTALLATIONS USE "CARSON" MODEL 910 GREEN YARD BOX WITH BOLT DOWN LID MARKED SEWER OR APPROVED EQUAL.
 - B) FOR ASPHALT, GRAVEL, OR TRAFFIC INSTALLATIONS SEE CITY STANDARD DETAIL NO. 04.03.05 FRAME AND COVER SECTION.
4. EACH CLEANOUT ASSEMBLY SHALL CONSIST OF: ONE CLEANOUT ADAPTER, HUB x FEMALE, FIPT, PVC SI AND ONE CLEANOUT PLUG, MOPT WITH RAISED NUT, PVC SDR35.

CITY OF
PUYALLUPDEVELOPMENT ENGINEERING and
PUBLIC WORKS DEPARTMENTSCOMMERCIAL SIDE SEWER CONNECTION
WITH SAMPLING CONNECTIONDRAWN BY
JIM ERWIN-SVOBODACHECKED BY
LINDA LIANAPPROVED BY
COLLEEN HARRISREVISED BY
LINDA LIANCITY
STANDARDFILE NAME
F:\DWG\COMMON\STDS\CITY\2009\04_SS\04.03\04.03.04DATE APPROVED
07/01/2009DATE REVISED
03/21/11SCALE
1:4

04.03.04