

City of Puyallup
Development & Permitting Services
ISSUED PERMIT

Building	Planning
Engineering	Public Works
Fire	Traffic


City of Puyallup
Fire
REVIEWED
FOR
COMPLIANCE

DDrake
06/15/2023
10:22:40 AM






THE APPROVED CONSTRUCTION
PLANS AND ALL ENGINEERING
MUST BE POSTED ON THE JOB AT
ALL INSPECTIONS IN A VISIBLE AND
READILY ACCESSIBLE LOCATION.

Approval of submitted plans is not an
approval of omissions or oversight by this
office or noncompliance with any
applicable regulations of local government.
The contractor is responsible for making
sure that the building complies with all
applicable building codes and regulations of
the local government.

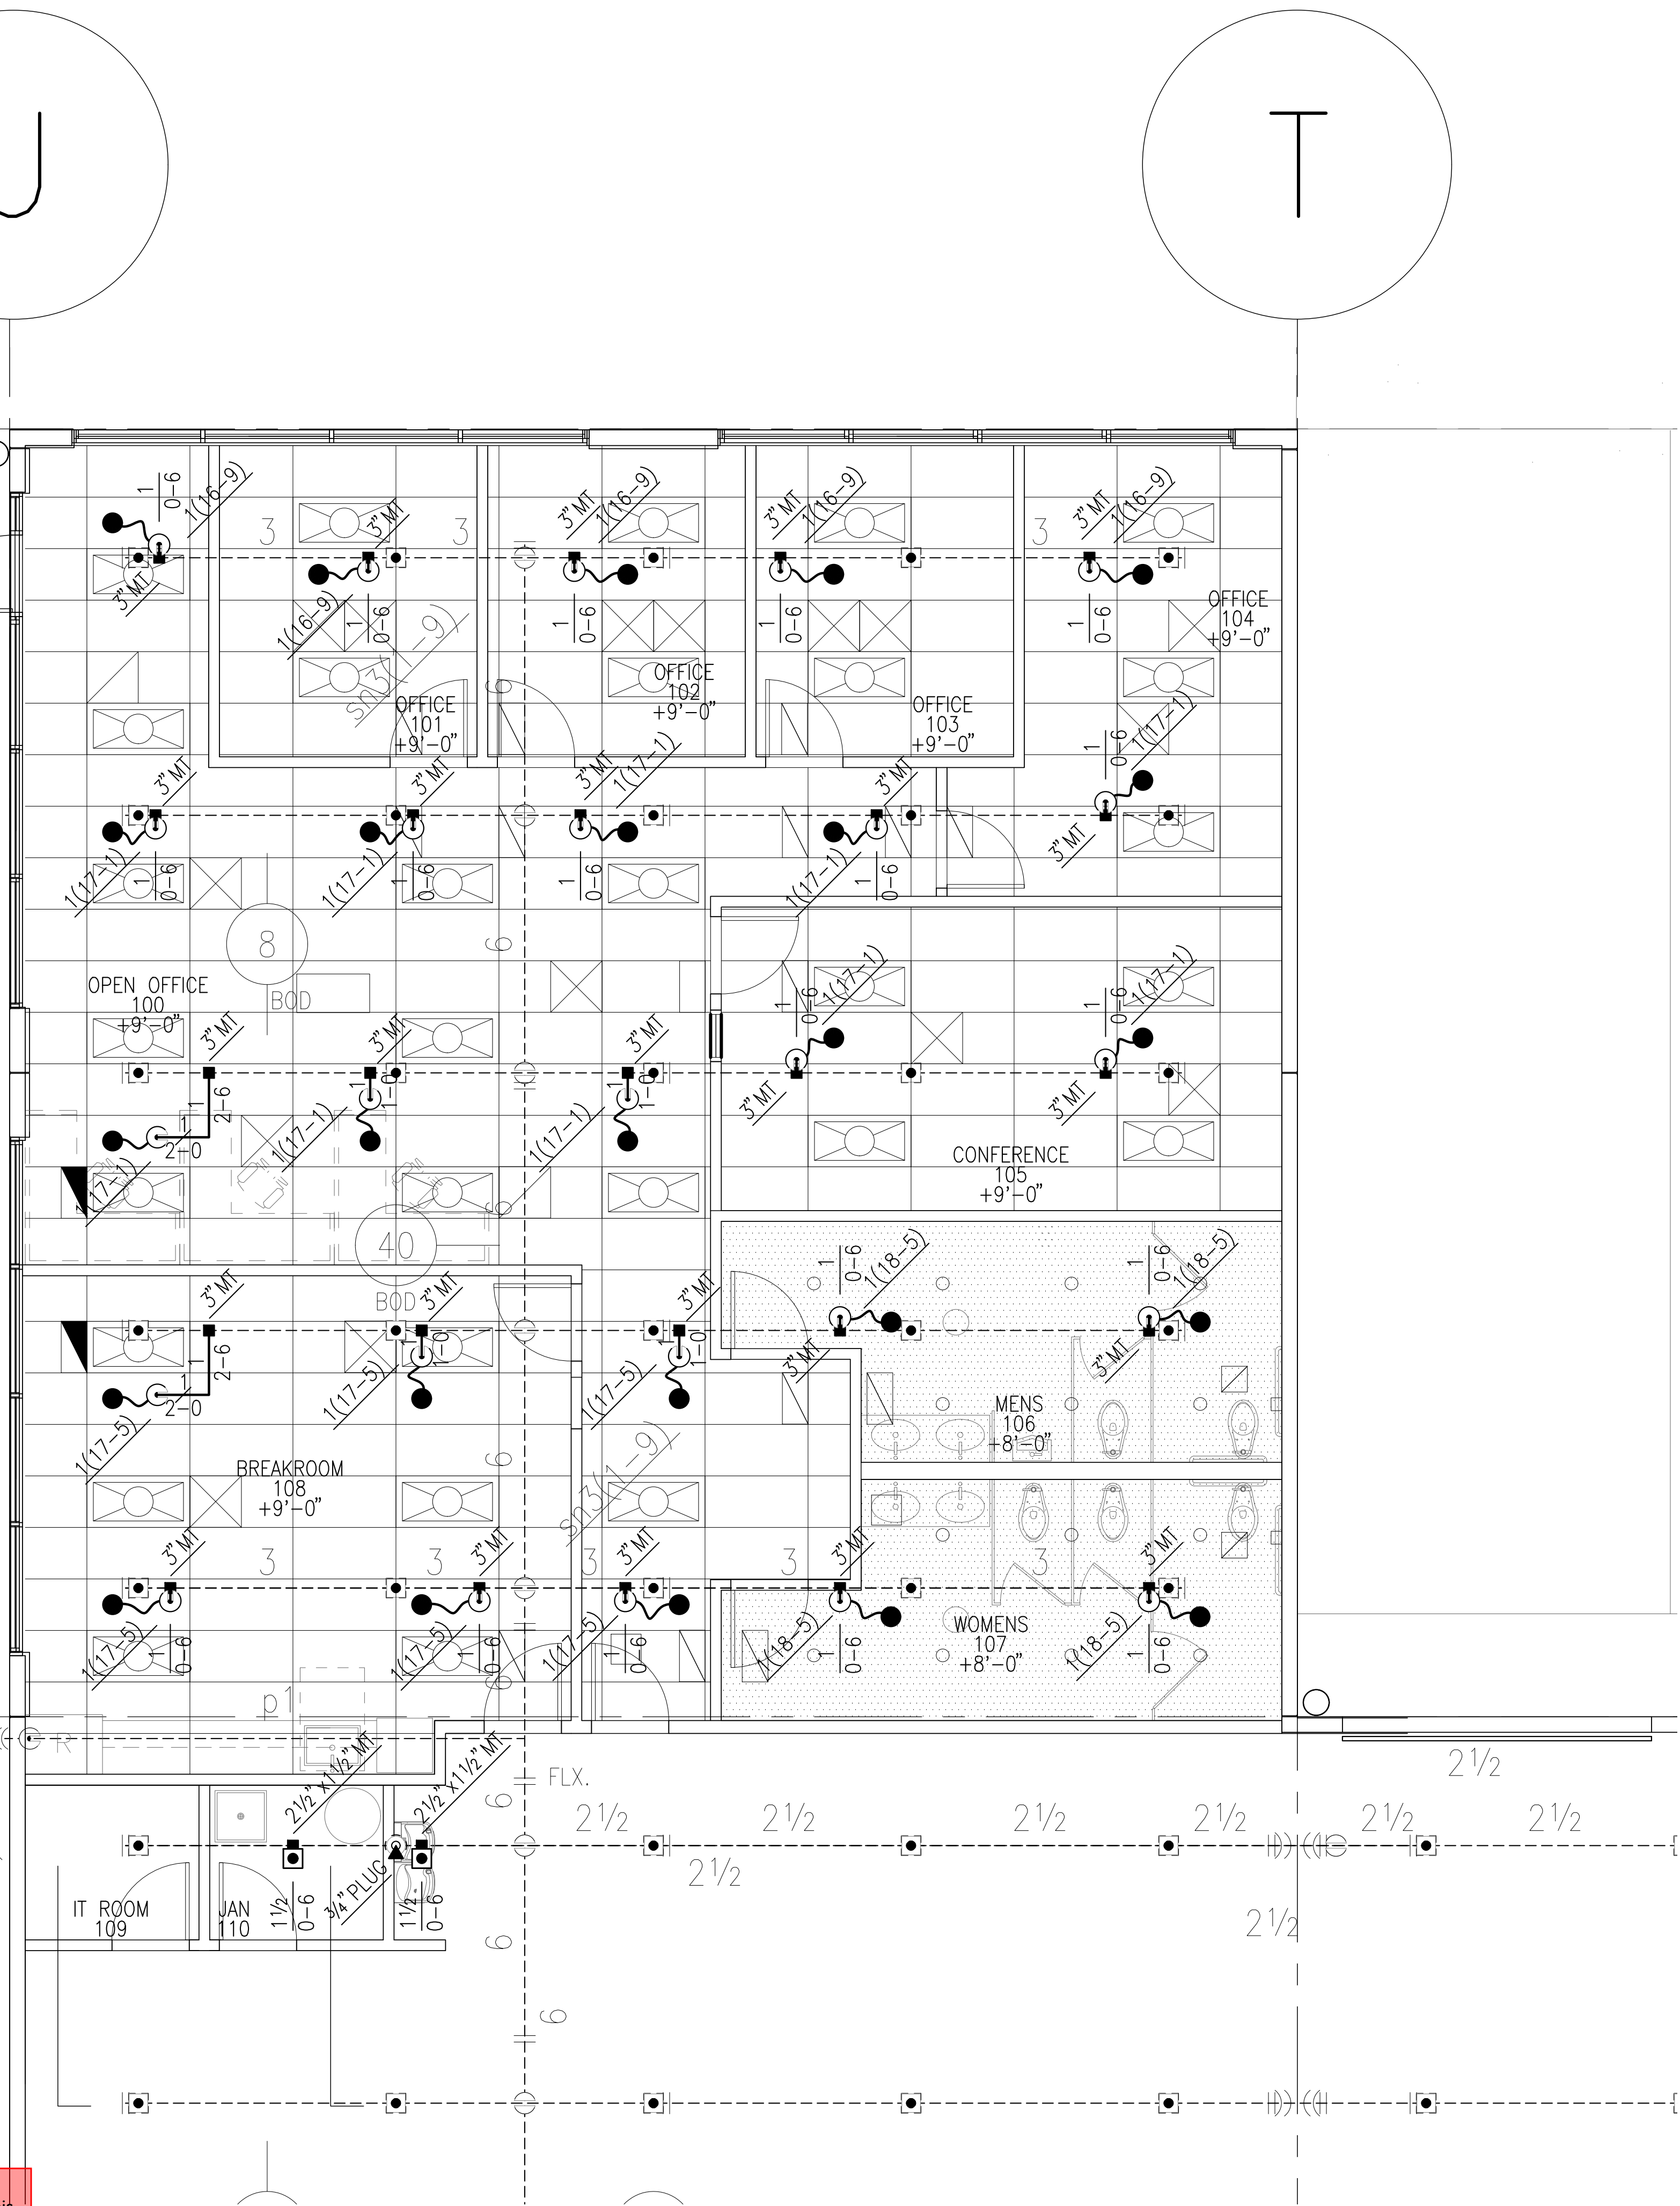

SYSTEM #1 FIRE SPRINKLER PLAN
SCALE: 1/4"=1'-0"

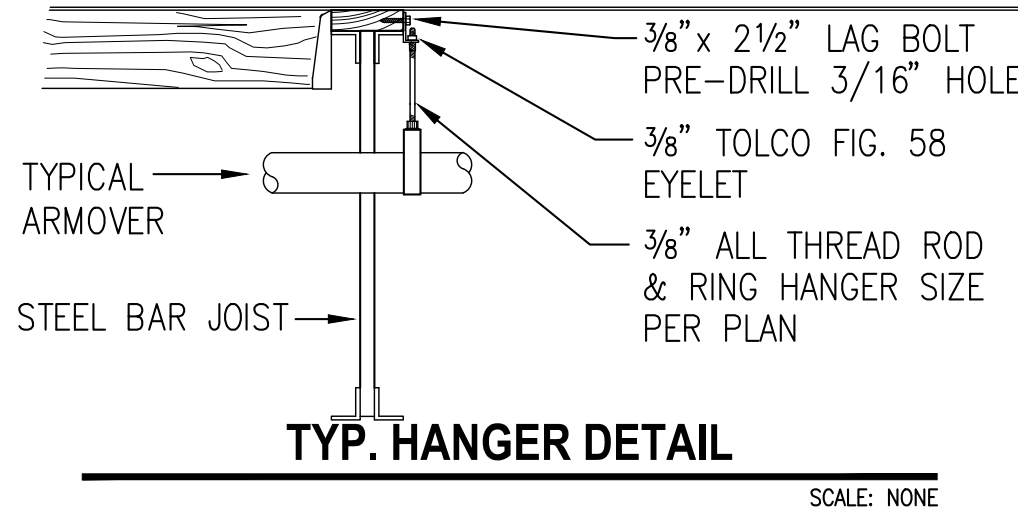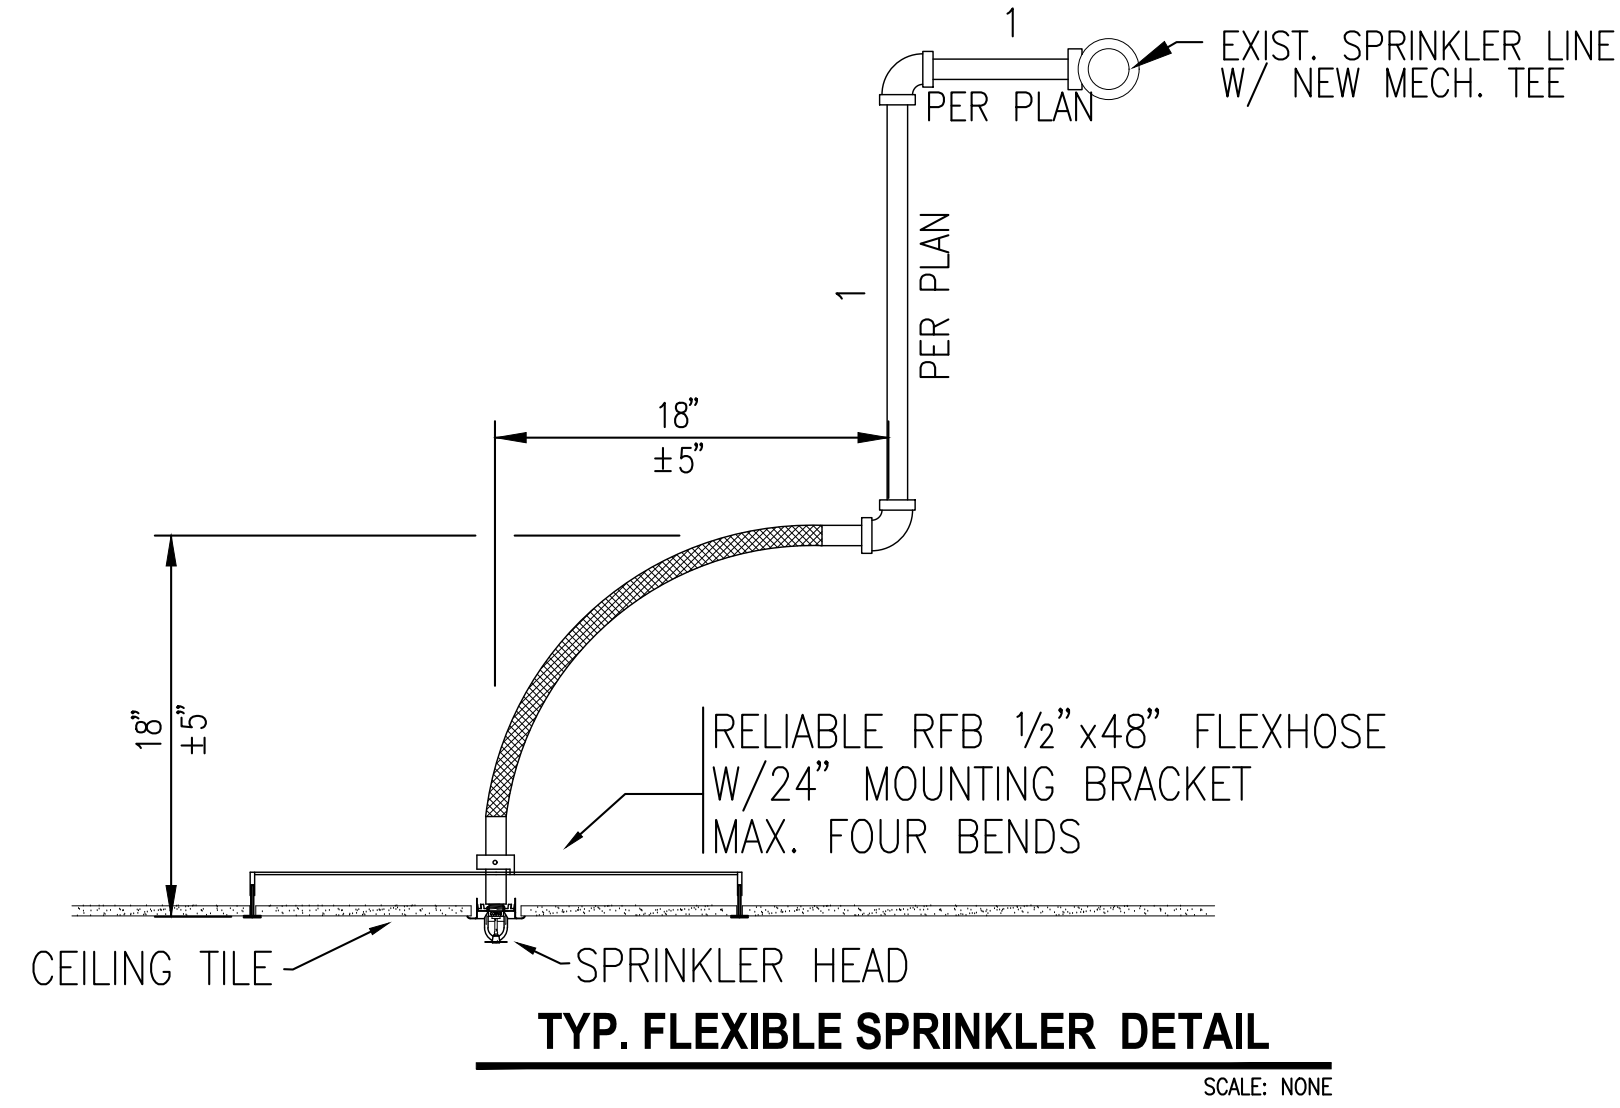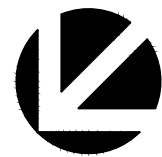

GENERAL NOTES


1. --- DENOTES EXISTING FIRE SPRINKLER PIPING.
2. --- DENOTES NEW FIRE SPRINKLER PIPING.
3. □ DENOTES EXISTING SPRINKLER ESFR TO REMAIN.
4. ⊕ DENOTES EXISTING SPRINKLER TO RELOCATE.

SCOPE OF WORK

1. ADD AND RELOCATE SPRINKLERS FOR TI WALLS AND CEILINGS.



VICINITY MAP

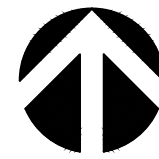

HANGER LEGEND			
A	1/4" HOOK		
B	COACH SCREW ROD		
D	BM. CLAMP W/8"STRAP		
E	EYELET		
F	HDIP		
G	CEILING FLANGE		
H	SIDE BEAM BRACKET		
K	HDI-P DROP IN ANCHOR		
M	ALL THREAD ROD		
N	TOGGLE NUT		
P	PIPE STAND		
R	EXPANSION BOLT		
S	PIPE SPIKE		
T			
U			
V			
W			
X			
Y			
Z			

STATE CERTIFICATION		SPRINKLER LEGEND				
WASHINGTON STATE CERTIFICATE OF COMPETENCY FIRE PROTECTION SPRINKLER SYSTEMS Matthew Greene 9819-0311-C Level 3 Patriot Fire Protection, Inc. PATRIFP099CF 		SPRINKLER ORIFICE SIZES AND TYPE		UPRIGHT	PENDENT	TEE
1/2"	5/16 3/8 7/16 1/2	SPRAY		1/2"	1/2"	
3/4"	1/2 3/4	SPRAY		1"	1"	
1"	3/4 7/8 1"	SIDEWALL		1/2"	1"	
1 1/2"	1" 1 1/2"	DRY TYPE		1"	1"	
2 - WAY EARTHQUAKE BRACE 		TEMP. RATING		SPRINKLER UP AND DOWN		
4 - WAY EARTHQUAKE BRACE 		155°		UP		
STRUCTURE TO CENTER LINE OF PIPE IN INCHES 		212°		DOWN		
FITTING LEGEND		286°		1/2"		
P RIPING ON LEFT		350°		1"		
		500°		1 1/2"		