


City of Puyallup Development & Permitting Services ISSUED PERMIT	
Building	Planning
Engineering	Public Works
Fire	Traffic

 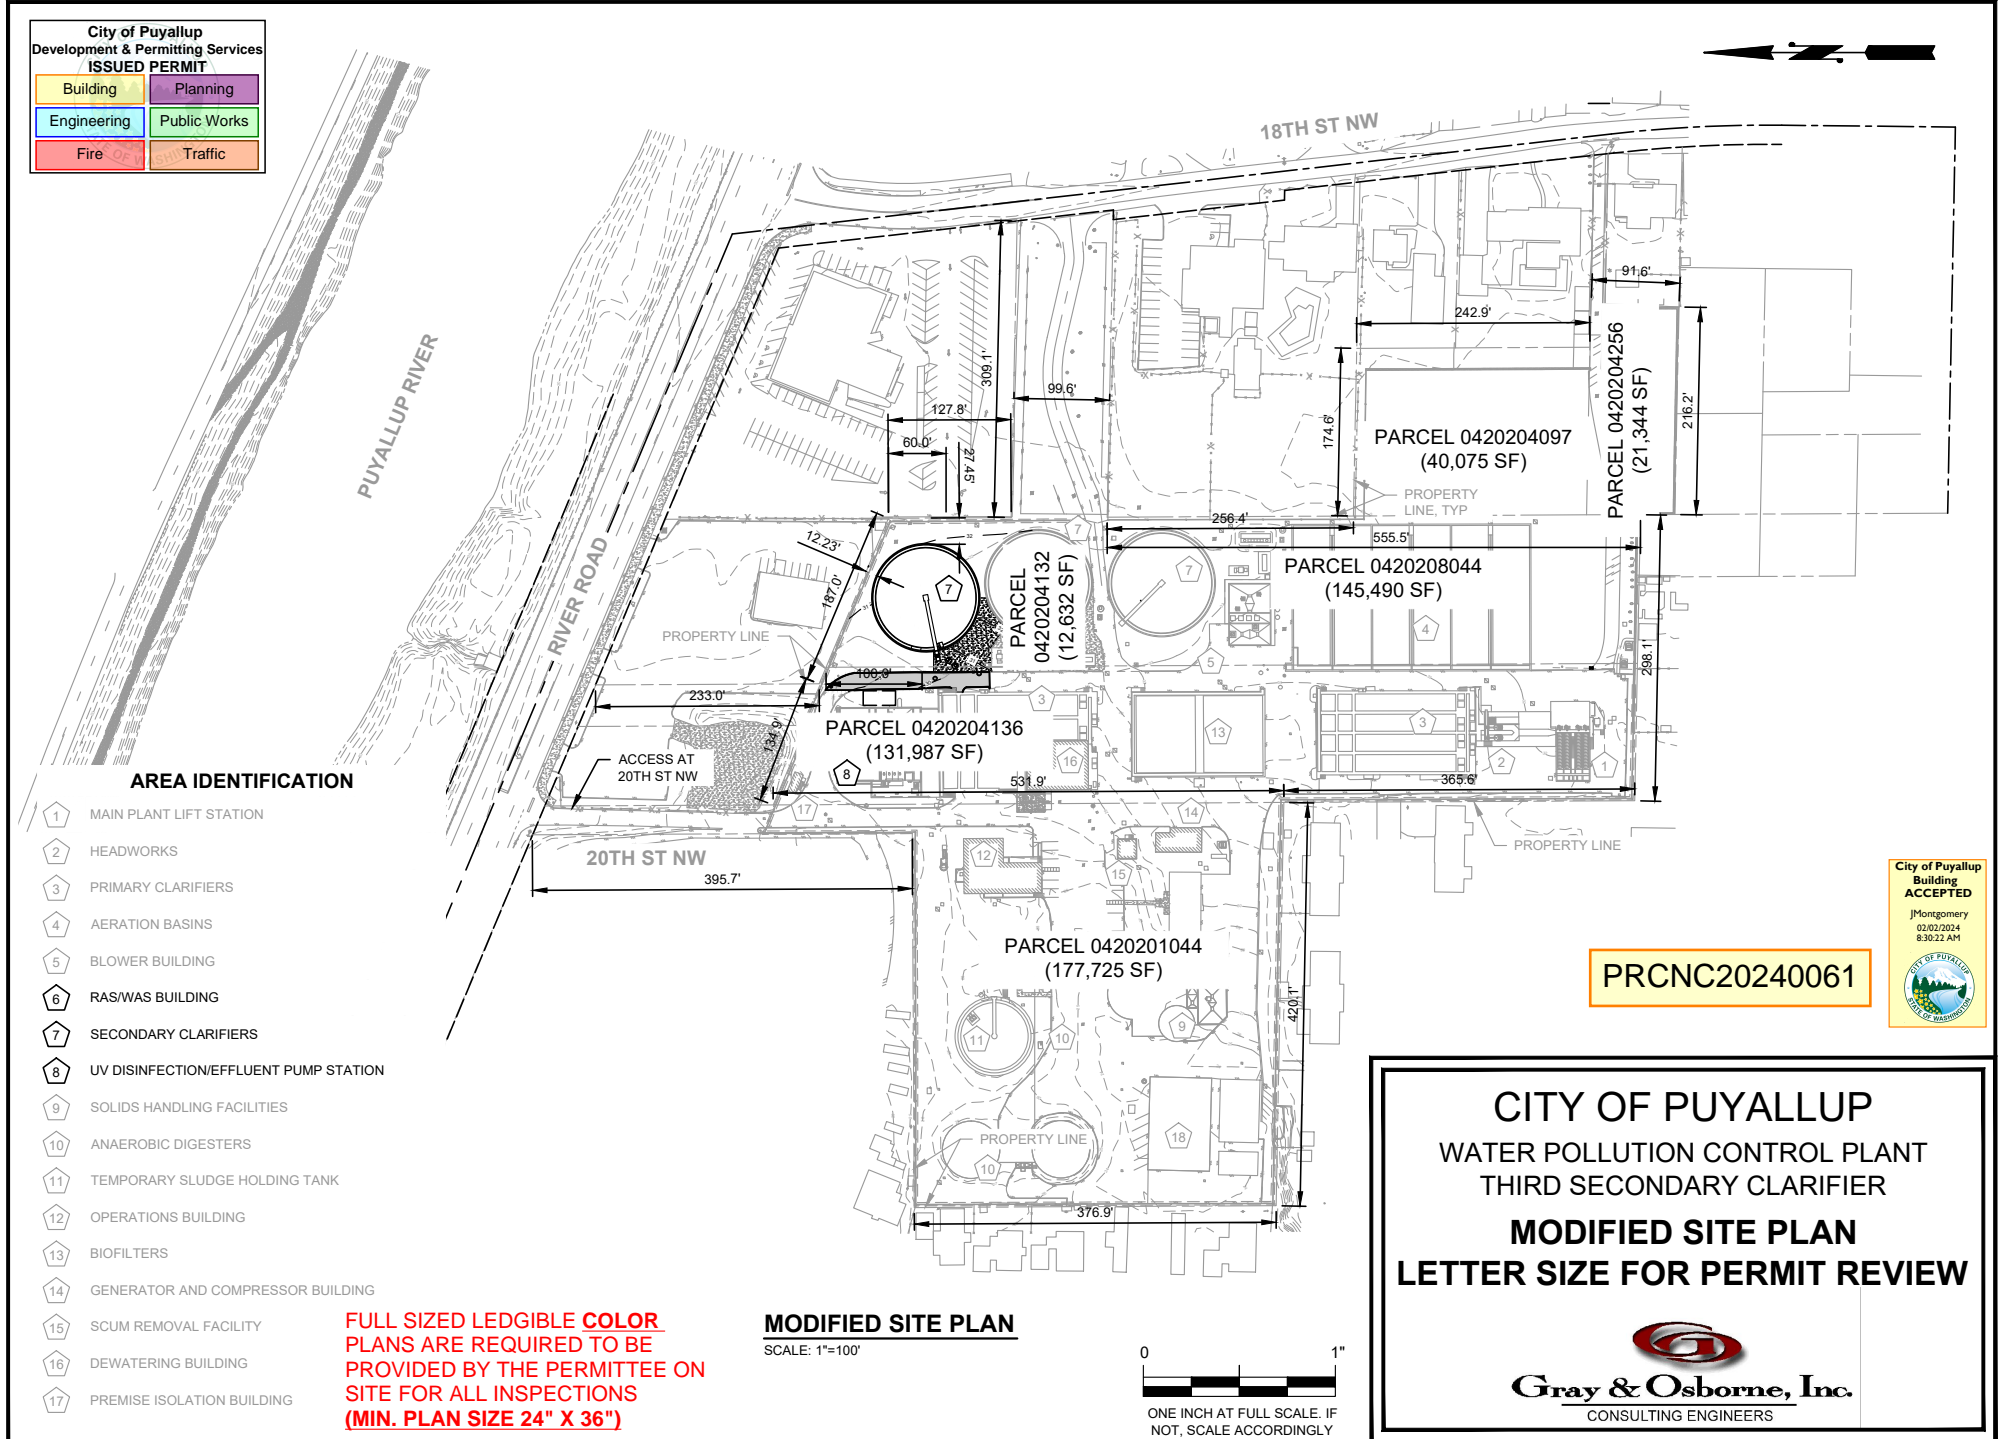


AREA IDENTIFICATION

- 1 MAIN PLANT LIFT STATION
- 2 HEADWORKS
- 3 PRIMARY CLARIFIERS
- 4 AERATION BASINS
- 5 BLOWER BUILDING
- 6 RAS/WAS BUILDING
- 7 SECONDARY CLARIFIERS
- 8 UV DISINFECTION/EFFLUENT PUMP STATION
- 9 SOLIDS HANDLING FACILITIES
- 10 ANAEROBIC DIGESTERS
- 11 TEMPORARY SLUDGE HOLDING TANK
- 12 OPERATIONS BUILDING
- 13 BIOFILTERS
- 14 GENERATOR AND COMPRESSOR BUILDING
- 15 SCUM REMOVAL FACILITY
- 16 DEWATERING BUILDING
- 17 PREMISE ISOLATION BUILDING

FULL SIZED LEDGIBLE COLOR PLANS ARE REQUIRED TO BE PROVIDED BY THE PERMITTEE ON SITE FOR ALL INSPECTIONS (MIN. PLAN SIZE 24" X 36")

MODIFIED SITE PLAN
SCALE: 1"=100'



PRCNC20240061

CITY OF PUYALLUP
WATER POLLUTION CONTROL PLANT
THIRD SECONDARY CLARIFIER
MODIFIED SITE PLAN
LETTER SIZE FOR PERMIT REVIEW

Gray & Osborne, Inc.
CONSULTING ENGINEERS