

The combined square footage of signs A and B exceed the maximum allowed square footage for facade signs in the UCX zones. Per PMC 20.60.047, the maximum square footage for facade signs is 1 square foot for each lineal foot of the building wall from which the sign is attached. The total combined square footage of signs A and B is about 30 square feet over the maximum allowed area. [plan set, pg.1]

**A B** NORTH ELEVATION FACADE  
FIELD VERIFY BUILDING MEASUREMENTS.

\*VINYL GRAPHICS BY OTHERS  
SCALE: 1/8" = 1'-0"



**A B** SIMULATED NIGHT VIEW - NORTH ELEVATION FACADE

SCALE: 1/8" = 1'-0"

# HEATH NORTHWEST

Distinctive Electrical Advertising Since 1967

## SEATTLE

12830 Interurban Ave S.  
Seattle WA 98168  
206-623-3100  
heathnorthwest.com

CLIENT:  
4505 S MERIDIAN  
PUYALLUP, WA 98373

## PRODUCTION PRINT

ACCOUNT EXECUTIVE:  
MP

PROJECT MANAGER  
X

DESIGNER: BK	PEER REVIEW: N/A	DIRECTOR: KN
DATE: 8/2/2024	DATE: N/A	DATE: 8/2/2024

HEATH NORTHWEST  
IS A UL RECOGNIZED  
MANUFACTURER

© 2024 by Heath Northwest

These plans are the exclusive property of Heath Northwest, Inc. the original work of its design team. They are submitted to your company for the sole purpose of your consideration of whether to purchase these plans or to purchase from Heath Northwest a sign manufactured according to these plans. Distribution or exhibition of these plans to anyone other than employees of your company, or use of these plans to construct a sign similar to the one embodied herein, is expressly forbidden. In the event that such exhibition occurs, Heath Northwest expects to be reimbursed 15% of the total project value in compensation for time and effort entailed in creating these plans.

L73 Grounding and Bonding Statement for each permanently connected sign the following statement or equivalent "This sign is intended to be installed in the accordance with the requirements of Article 600 of the National Electrical Code and/or other applicable local codes. This includes proper grounding and bonding of the sign" should be either directly marked on the sign or label attached to the sign, included in the installation instructions, or provided on a separate sheet or tag shipped with the sign. The location of the disconnect switch after installation shall comply with Article 600.6 (A) (1) of the National Electrical code.

APPROVAL:  
ACCOUNT EXECUTIVE


CLIENT

LANDLORD

DESIGN NUMBER:  
24-872-R3-P

REVISION NUMBER:  
(P) 10/10/2024 BK

PAGE # 1 OF 6

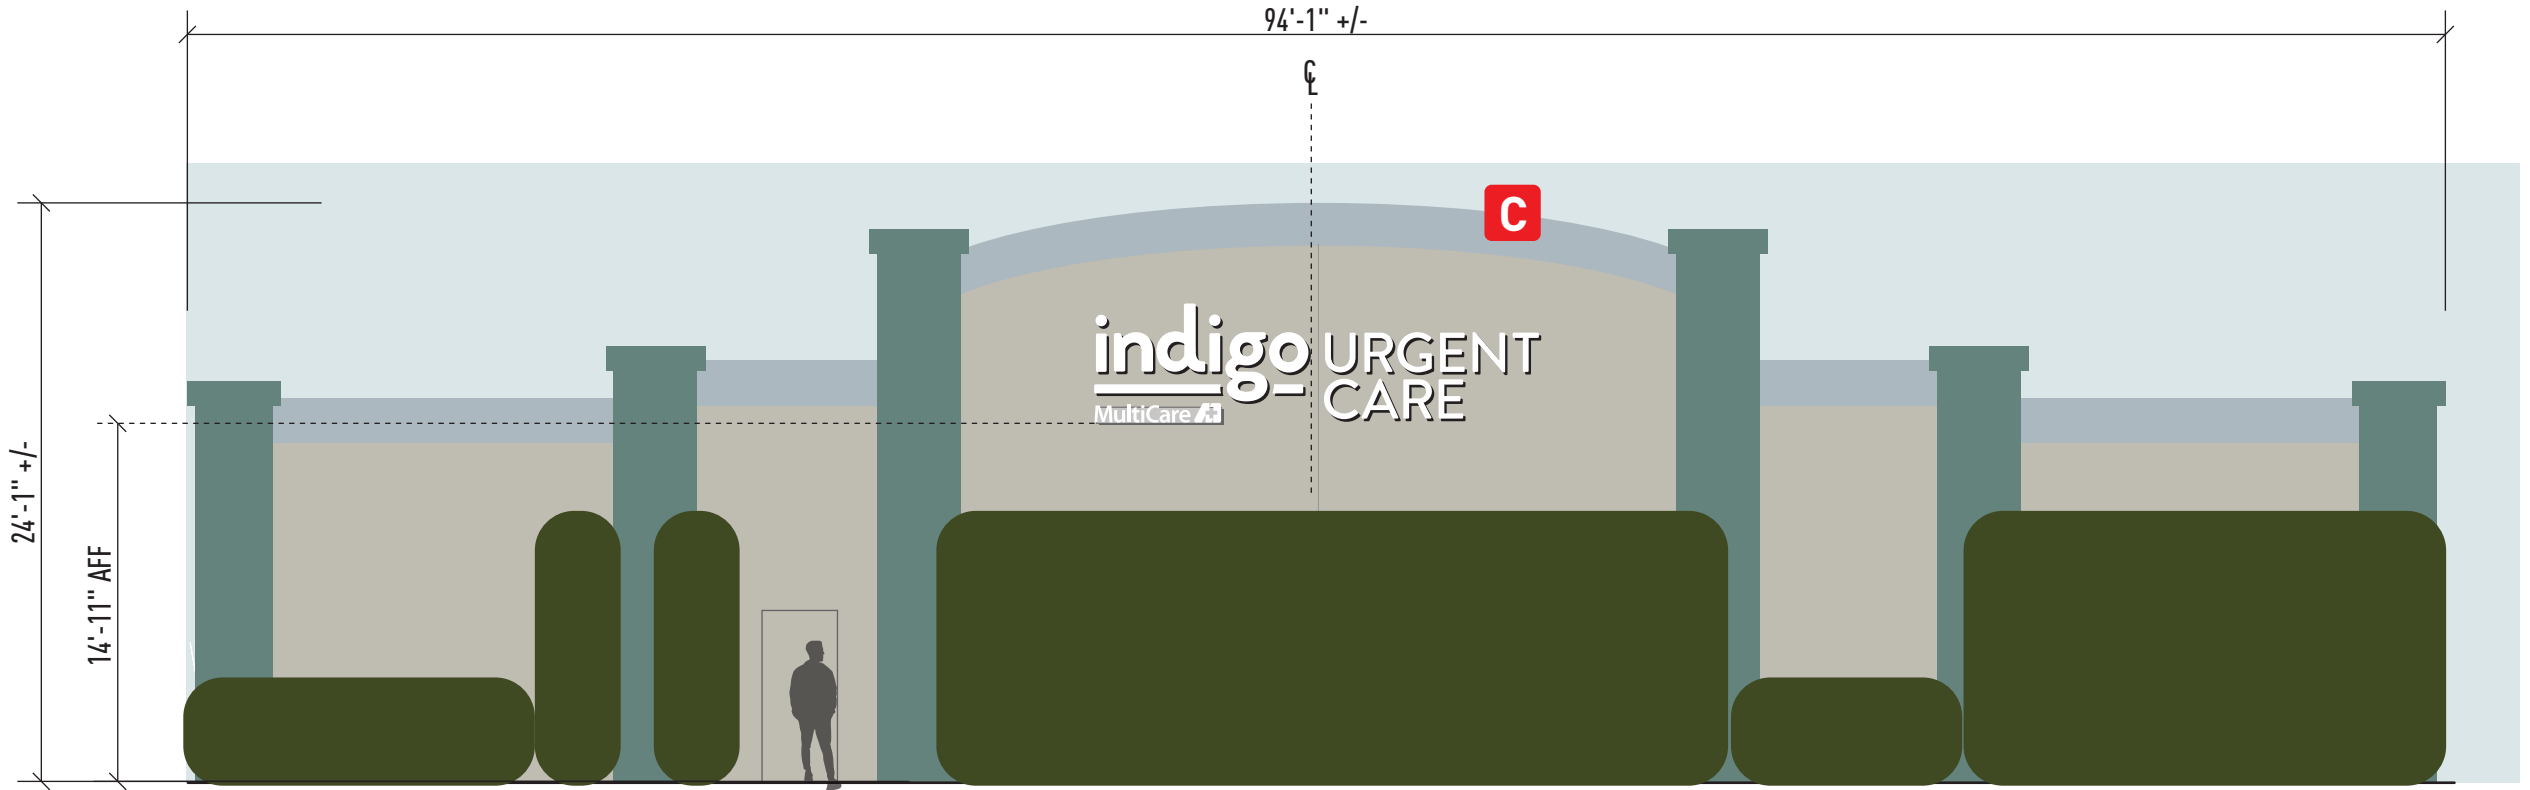

**C** BACK ELEVATION FACADE  
*FIELD VERIFY BUILDING MEASUREMENTS.*

SCALE: 1/8" = 1'-0"



**C** SIMULATED NIGHT VIEW - BACK ELEVATION FACADE

SCALE: 1/8" = 1'-0"

# HEATH NORTHWEST

Distinctive Electrical Advertising Since 1967

## SEATTLE

12830 Interurban Ave S.  
Seattle WA 98168  
206-623-3100  
heathnorthwest.com



CLIENT:  
4505 S MERIDIAN  
PUYALLUP, WA 98373

## PRODUCTION PRINT

ACCOUNT EXECUTIVE:  
MP

PROJECT MANAGER  
X

DESIGNER:	PEER REVIEW:	DIRECTOR:
BK	N/A	KN
DATE:	DATE:	DATE:
8/2/2024	N/A	8/2/2024



HEATH NORTHWEST  
IS A UL RECOGNIZED  
MANUFACTURER



© 2024 by Heath Northwest

These plans are the exclusive property of Heath Northwest, Inc. the original work of its design team. They are submitted to your company for the sole purpose of your consideration of whether to purchase these plans or to purchase from Heath Northwest a sign manufactured according to these plans. Distribution or exhibition of these plans to anyone other than employees of your company, or use of these plans to construct a sign similar to the one embodied herein, is expressly forbidden. In the event that such exhibition occurs, Heath Northwest expects to be reimbursed 15% of the total project value in compensation for time and effort entailed in creating these plans.

L73 Grounding and Bonding Statement for each permanently connected sign the following statement or equivalent "This sign is intended to be installed in the accordance with the requirements of Article 600 of the National Electrical Code and/or other applicable local codes. This includes proper grounding and bonding of the sign" should be either directly marked on the sign or label attached to the sign, included in the installation instructions, or provided on a separate sheet or tag shipped with the sign. The location of the disconnect switch after installation shall comply with Article 600.6 (A) (1) of the National Electrical code.

APPROVAL:  
ACCOUNT EXECUTIVE


CLIENT

LANDLORD

DESIGN NUMBER:  
24-872-R3-P

REVISION NUMBER:  
(P) 10/10/2024 BK

PAGE # 2 OF 6

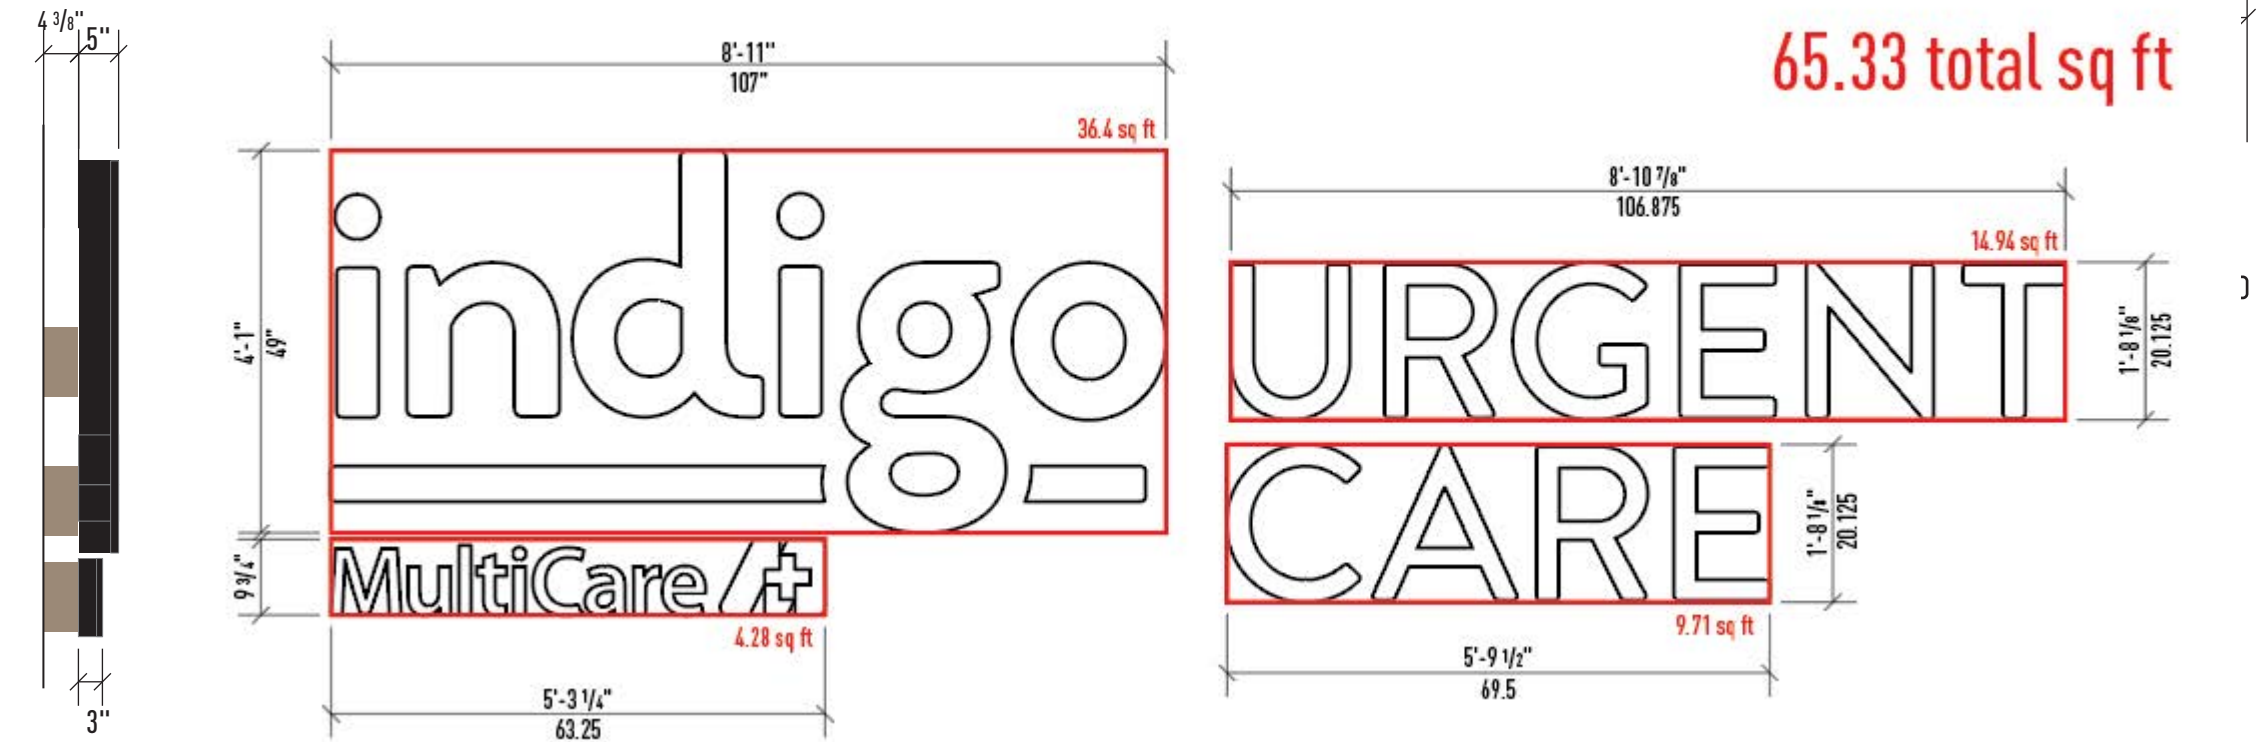

END VIEW  
SCALE: 1/2" = 1'-0"

**A C** FACELIT CHANNEL LETTERSET w/ LOWER COPY MOUNTED TO RACEWAYS  
QUANTITY: 2 SETS MANUFACTURE & INSTALL

SCALE: 1/2" =  
1'-0"

FABRICATION SPECIFICATIONS			
1	PAN CHANNEL	LIGHTING	6500K WHITE LED
		FACE COLOR	#2447 WHITE ACRYLIC
		TRIM CAP	1", BLACK
		TRIM CAP SIZE	1"
		RETURN COLOR	PRE-PAINTED BLACK
		RETURN DEPTH	5"
2	PAN CHANNEL	LIGHTING	6500K WHITE LED
	"MULTICARE"	FACE COLOR	#2447 WHITE ACRYLIC
		VINYL COLOR	PER COLOR KEY
		TRIM CAP	3/4", BLACK
		RETURN COLOR	PRE-PAINTED BLACK
		RETURN DEPTH	3"
3	RACEWAYS	CONSTRUCTION	SIGNCOMP 8" NARROW
		PAINT COLOR	MATCH WALL COLOR
		SIZE	8-11/16" X 4-3/8"
4	MOUNTING	METHOD	FASTENERS AS REQUIRED PER SURVEY (PENDING)

GENERAL NOTES	
MANUFACTURE AND INSTALL TWO (2) SETS OF FACELIT CHANNEL LETTERS & LOGO w/ LOWER COPY MOUNTED TO RACEWAYS. SURVEY REQUIRED.	

COLOR KEY	
P1	PAINT / MATCH SW 2855 SYCAMORE TAN
NOTE: THE COLORS DEPICTED ON THIS RENDERING REPRESENT COLOR INTENT ONLY AND MAY NOT MATCH ACTUAL COLORS ON FINISHED PRODUCT. PLEASE REFER TO COLOR CALL-OUTS AND SPECIFIED VENDOR SAMPLES FOR APPROVED COLOR SPECIFICATIONS.	

# HEATH NORTHWEST

Distinctive Electrical Advertising Since 1967

SEATTLE  
12830 Interurban Ave S.  
Seattle WA 98168  
206-623-3100  
heathnorthwest.com



CLIENT:  
4505 S MERIDIAN  
PUYALLUP, WA 98373

PRODUCTION PRINT

ACCOUNT EXECUTIVE: MP		
PROJECT MANAGER X		
DESIGNER: BK	PEER REVIEW: N/A	DIRECTOR: KN
DATE: 8/2/2024	DATE: N/A	DATE: 8/2/2024



© 2024 by Heath Northwest

These plans are the exclusive property of Heath Northwest, Inc. the original work of its design team. They are submitted to your company for the sole purpose of your consideration of whether to purchase these plans or to purchase from Heath Northwest a sign manufactured according to these plans. Distribution or exhibition of these plans to anyone other than employees of your company, or use of these plans to construct a sign similar to the one embodied herein, is expressly forbidden. In the event that such exhibition occurs, Heath Northwest expects to be reimbursed 15% of the total project value in compensation for time and effort entailed in creating these plans.

L73 Grounding and Bonding Statement for each permanently connected sign the following statement or equivalent "This sign is intended to be installed in the accordance with the requirements of Article 600 of the National Electrical Code and/or other applicable local codes. This includes proper grounding and bonding of the sign" should be either directly marked on the sign or label attached to the sign, included in the installation instructions, or provided on a separate sheet or tag shipped with the sign. The location of the disconnect switch after installation shall comply with Article 600.6 (A) (1) of the National Electrical code.

APPROVAL:  
ACCOUNT EXECUTIVE

CLIENT

LANDLORD

DESIGN NUMBER:  
24-872-R3-P

REVISION NUMBER:  
(P) 10/10/2024 BK



END VIEW  
SCALE: 3/4" = 1'-0"

**B** FACELIT WALL CABINET SIGN w/ PUSH THRU GRAPHICS  
QUANTITY: 1 MANUFACTURE & INSTALL  
**28.54 SQ FT**  
SCALE: 3/4" = 1'-0"

FABRICATION SPECIFICATIONS		
1	CABINET	CONSTRUCTION
		TYPE
		ILLUMINATION
		PAINT COLOR
2	FACE/GRAPHICS	6" DEEP FABRICATED ALUMINUM
		S/F ILLUMINATED
		6500k WHITE LED
		PER COLOR KEY
2	FACE/GRAPHICS	TYPE
		MATERIAL
		DIFFUSER
		PAINT COLOR
3	MOUNTING	ROUT-OUT & PUSH-THRU
		1" CLEAR ACRYLIC
		WHITE TRANS VINYL ON 2ND SUR
		PER COLOR KEY
3	MOUNTING	METHOD
		FASTENERS AS REQUIRED PER SURVEY (PENDING)

**GENERAL NOTES**

MANUFACTURE AND INSTALL ONE (1) FACELIT CABINET SIGN w/ PUSH THRU GRAPHICS MOUNTED FLUSH TO FASCIA.

SURVEY REQUIRED.

COLOR KEY	
P1	PAINT < BLUE (VERIFY)
NOTE: THE COLORS DEPICTED ON THIS RENDERING REPRESENT COLOR INTENT ONLY AND MAY NOT MATCH ACTUAL COLORS ON FINISHED PRODUCT. PLEASE REFER TO COLOR CALL-OUTS AND SPECIFIED VENDOR SAMPLES FOR APPROVED COLOR SPECIFICATIONS.	

**SEATTLE**  
12830 Interurban Ave S.  
Seattle WA 98168  
206-623-3100  
heathnorthwest.com



CLIENT:  
4505 S MERIDIAN  
PUYALLUP, WA 98373

PRODUCTION PRINT

ACCOUNT EXECUTIVE: MP		
PROJECT MANAGER X		
DESIGNER: BK	PEER REVIEW: N/A	DIRECTOR: KN
DATE: 8/2/2024	DATE: N/A	DATE: 8/2/2024



© 2024 by Heath Northwest

These plans are the exclusive property of Heath Northwest, Inc. the original work of its design team. They are submitted to your company for the sole purpose of your consideration of whether to purchase these plans or to purchase from Heath Northwest a sign manufactured according to these plans. Distribution or exhibition of these plans to anyone other than employees of your company, or use of these plans to construct a sign similar to the one embodied herein, is expressly forbidden. In the event that such exhibition occurs, Heath Northwest expects to be reimbursed 15% of the total project value in compensation for time and effort entailed in creating these plans.

L73 Grounding and Bonding Statement for each permanently connected sign the following statement or equivalent "This sign is intended to be installed in the accordance with the requirements of Article 600 of the National Electrical Code and/or other applicable ocal codes. This includes proper grounding and bonding of the sign" should be either directly marked on the sign or label attached to the sign, included in the installation instructions, or provided on a separate sheet or tag shipped with the sign. The location of the disconnect switch after installation shall comply with Article 600.6 (A) (1) of the National Electrical code.


APPROVAL:  
ACCOUNT EXECUTIVE

CLIENT

LANDLORD

DESIGN NUMBER:  
**24-872-R3-P**


REVISION NUMBER:  
**(P) 10/10/2024 BK**

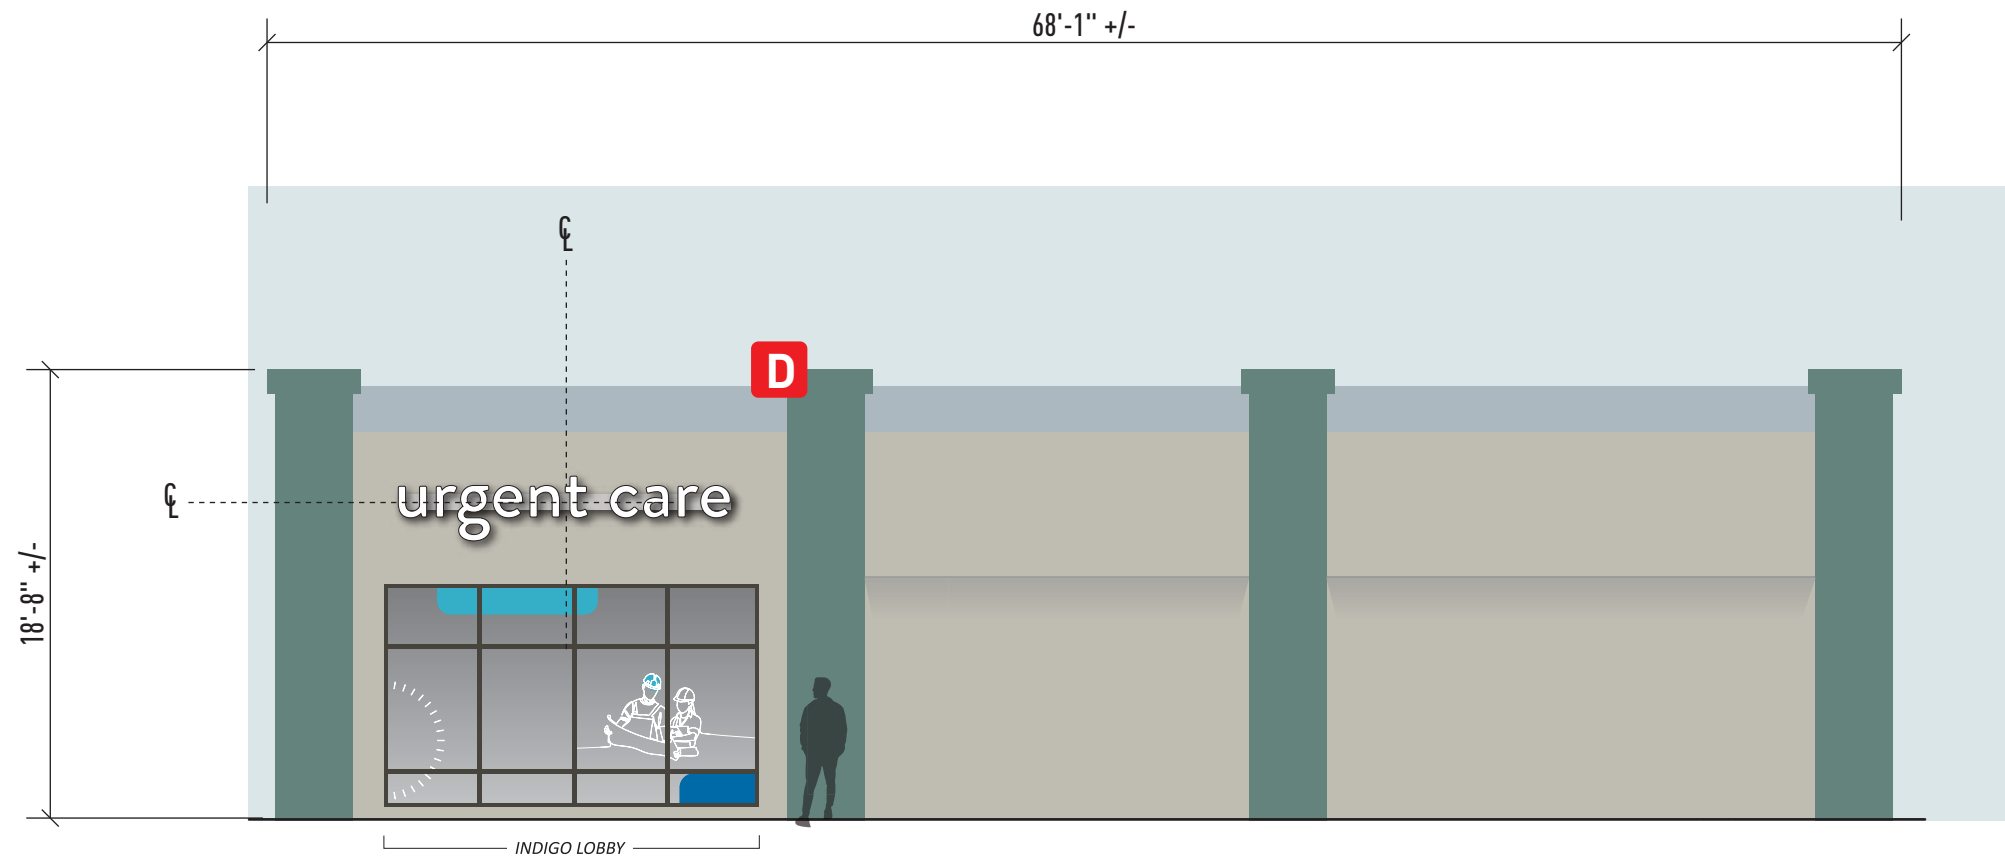

**D** SIDE ELEVATION FACADE  
FIELD VERIFY BUILDING MEASUREMENTS.


\*VINYL GRAPHICS BY OTHERS

SCALE: 1/8" = 1'-0"

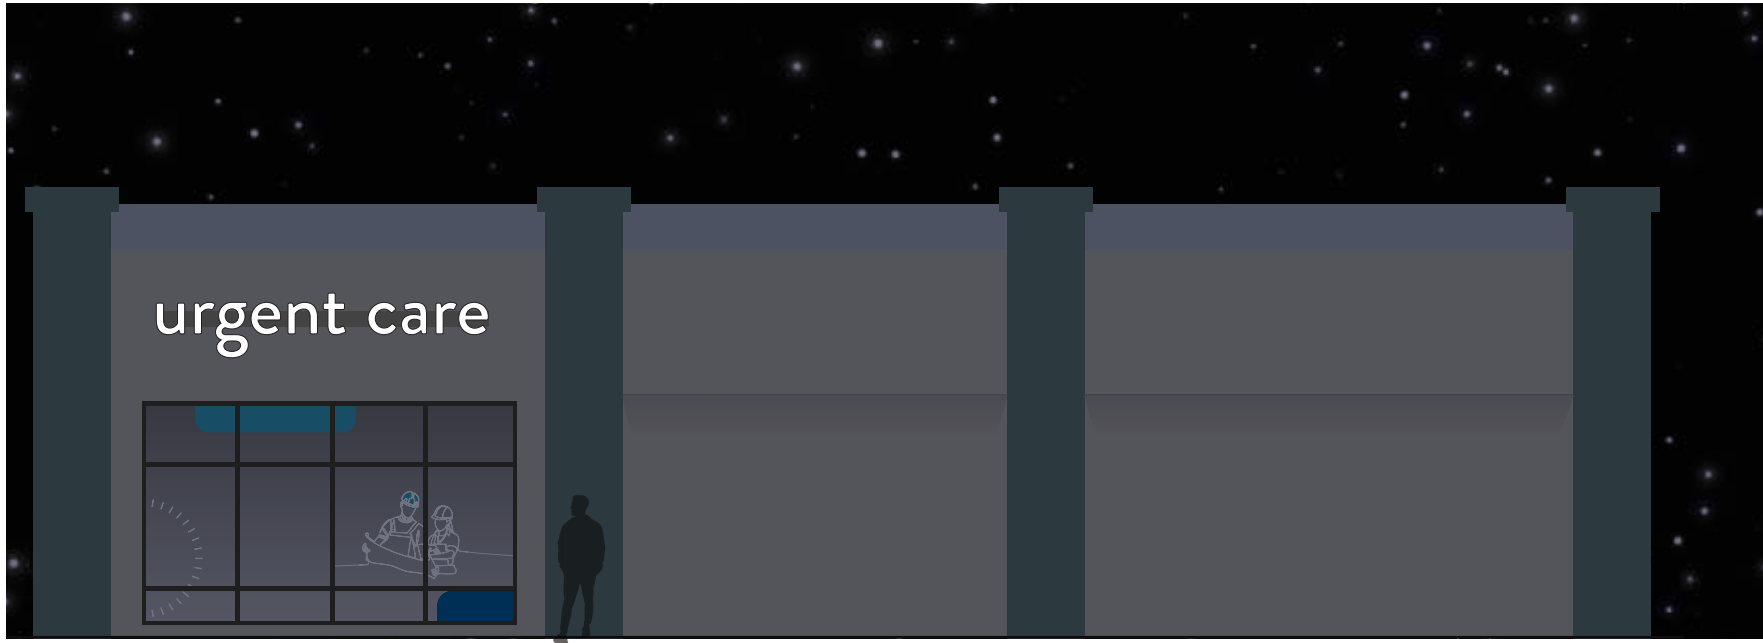

**D** SIMULATED NIGHT VIEW - SIDE ELEVATION FACADE

SCALE: 1/8" = 1'-0"

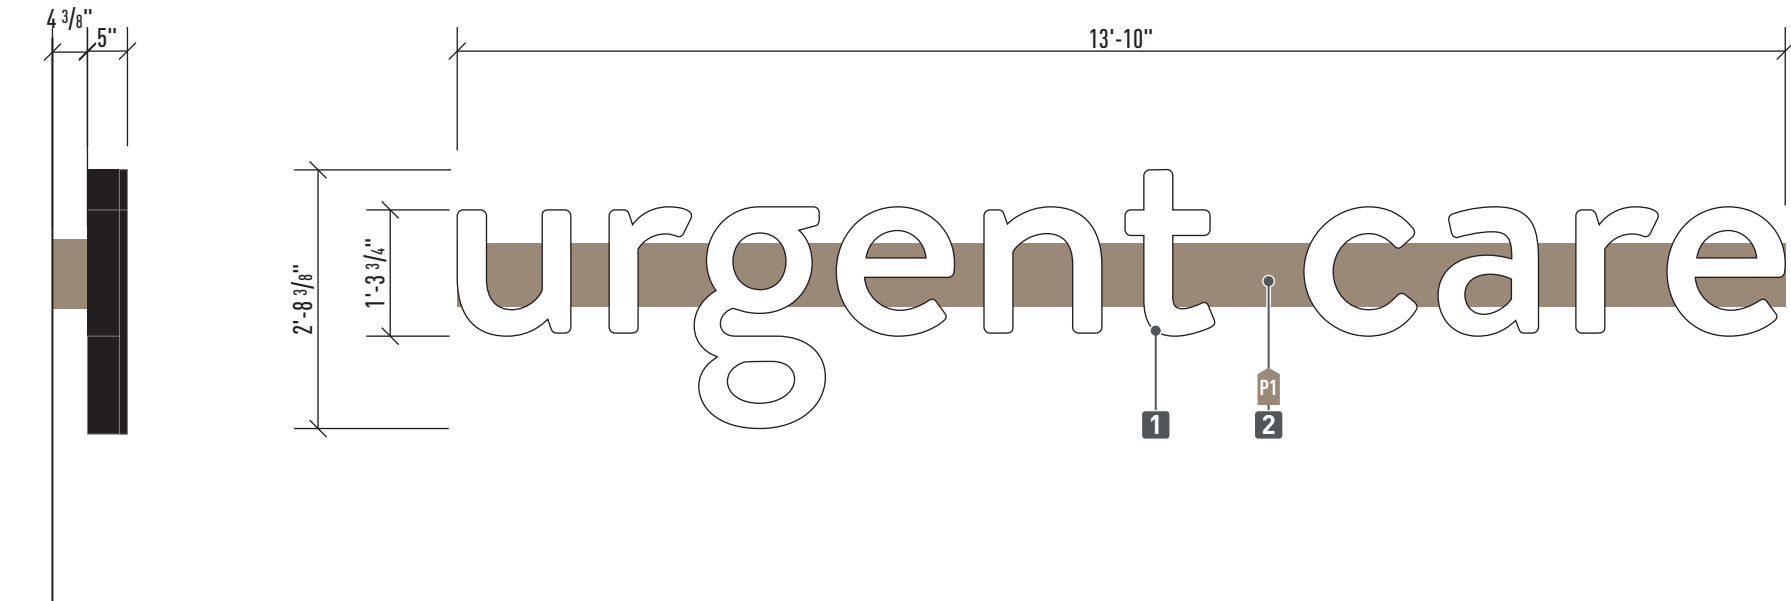

END VIEW  
SCALE: 1/2" = 1'-0"

**D** FACELIT CHANNEL LETTERSET MOUNTED TO RACEWAY  
QUANTITY: 1 SET MANUFACTURE & INSTALL  
37.32 SQ FT  
SCALE: 1/2" = 1'-0"

FABRICATION SPECIFICATIONS		
1	PAN CHANNEL	LIGHTING
		6500K WHITE LED
		FACE COLOR
		#2447 WHITE ACRYLIC
		TRIM CAP
		1", BLACK
2	RACEWAYS	TRIM CAP SIZE
		1"
		RETURN COLOR
		PRE-PAINTED BLACK
		RETURN DEPTH
		5"
3	MOUNTING	CONSTRUCTION
		SIGNCOMP 8" NARROW
		PAINT COLOR
		MATCH WALL COLOR
		SIZE
		8-11/16" X 4-3/8"
3	MOUNTING	METHOD
		FASTENERS AS REQUIRED PER SURVEY (PENDING)

GENERAL NOTES

MANUFACTURE AND INSTALL ONE (1) SET OF FACELIT CHANNEL LETTERS MOUNTED TO RACEWAY

COLOR KEY	
P1	PAINT < MATCH SW 2855 SYCAMORE TAN
NOTE: THE COLORS DEPICTED ON THIS RENDERING REPRESENT COLOR INTENT ONLY AND MAY NOT MATCH ACTUAL COLORS ON FINISHED PRODUCT. PLEASE REFER TO COLOR CALL-OUTS AND SPECIFIED VENDOR SAMPLES FOR APPROVED COLOR SPECIFICATIONS.	

HEATH NORTHWEST

Distinctive Electrical Advertising Since 1967

SEATTLE

12830 Interurban Ave S.

Seattle WA 98168

206-623-3100

heathnorthwest.com



CLIENT:

4505 S MERIDIAN

PUYALLUP, WA 98373

PRODUCTION PRINT

ACCOUNT EXECUTIVE:		
MP		
PROJECT MANAGER		
X		
DESIGNER:	PEER REVIEW:	DIRECTOR:
BK	N/A	KN
DATE:	DATE:	DATE:
8/2/2024	N/A	8/2/2024



© 2024 by Heath Northwest

These plans are the exclusive property of Heath Northwest, Inc. the original work of its design team. They are submitted to your company for the sole purpose of your consideration of whether to purchase these plans or to purchase from Heath Northwest a sign manufactured according to these plans. Distribution or exhibition of these plans to anyone other than employees of your company, or use of these plans to construct a sign similar to the one embodied herein, is expressly forbidden. In the event that such exhibition occurs, Heath Northwest expects to be reimbursed 15% of the otal project value in compensation for time and effort entailed in creating these plans.

L73 Grounding and Bonding Statement for each permanently connected sign the following statement or equivalent "This sign is intended to be installed in the accordance with the requirements of Article 600 of the National Electrical Code and/or other applicable ocal codes. This includes proper grounding and bonding of the sign" should be either directly marked on the sign or label attached to the sign, included in the installation instructions, or provided on a separate sheet or tag shipped with the sign. The location of the disconnect switch after installation shall comply with Article 600.6 (A) (1) of the National Electrical code.

APPROVAL:
ACCOUNT EXECUTIVE
CLIENT
LANDLORD
DESIGN NUMBER:
24-872-R3-P
REVISION NUMBER:
(P) 10/10/2024 BK