
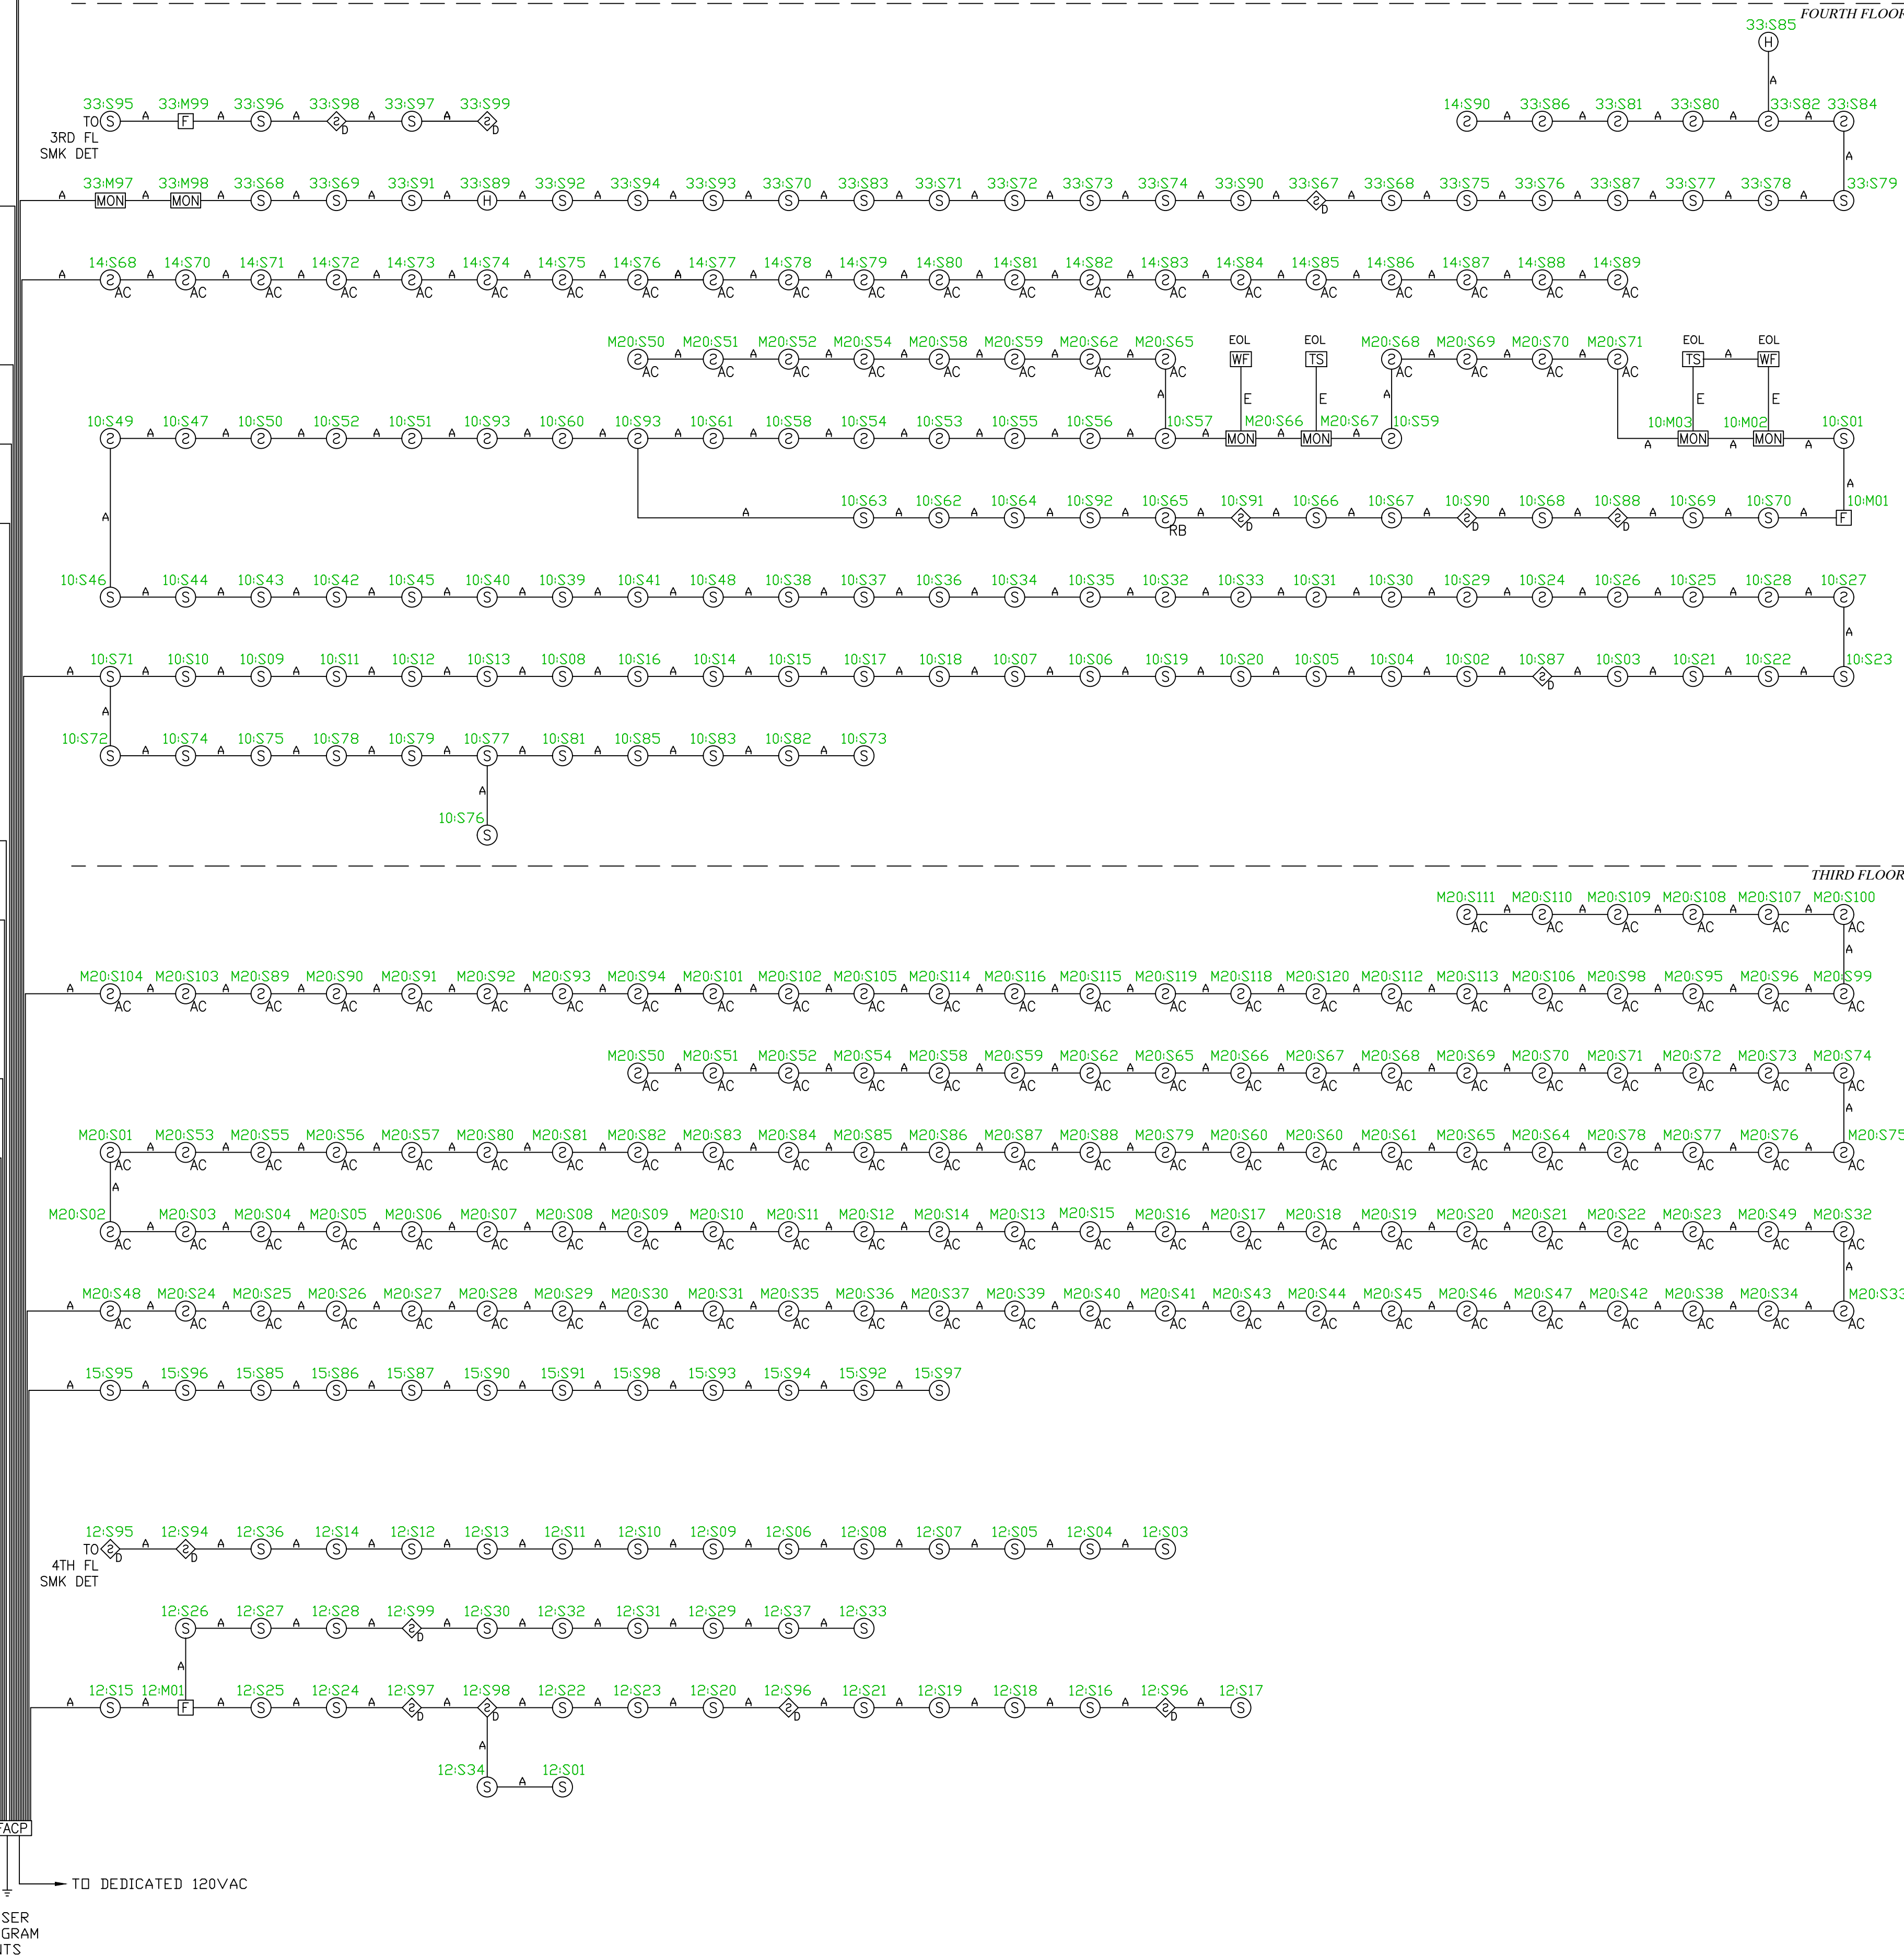


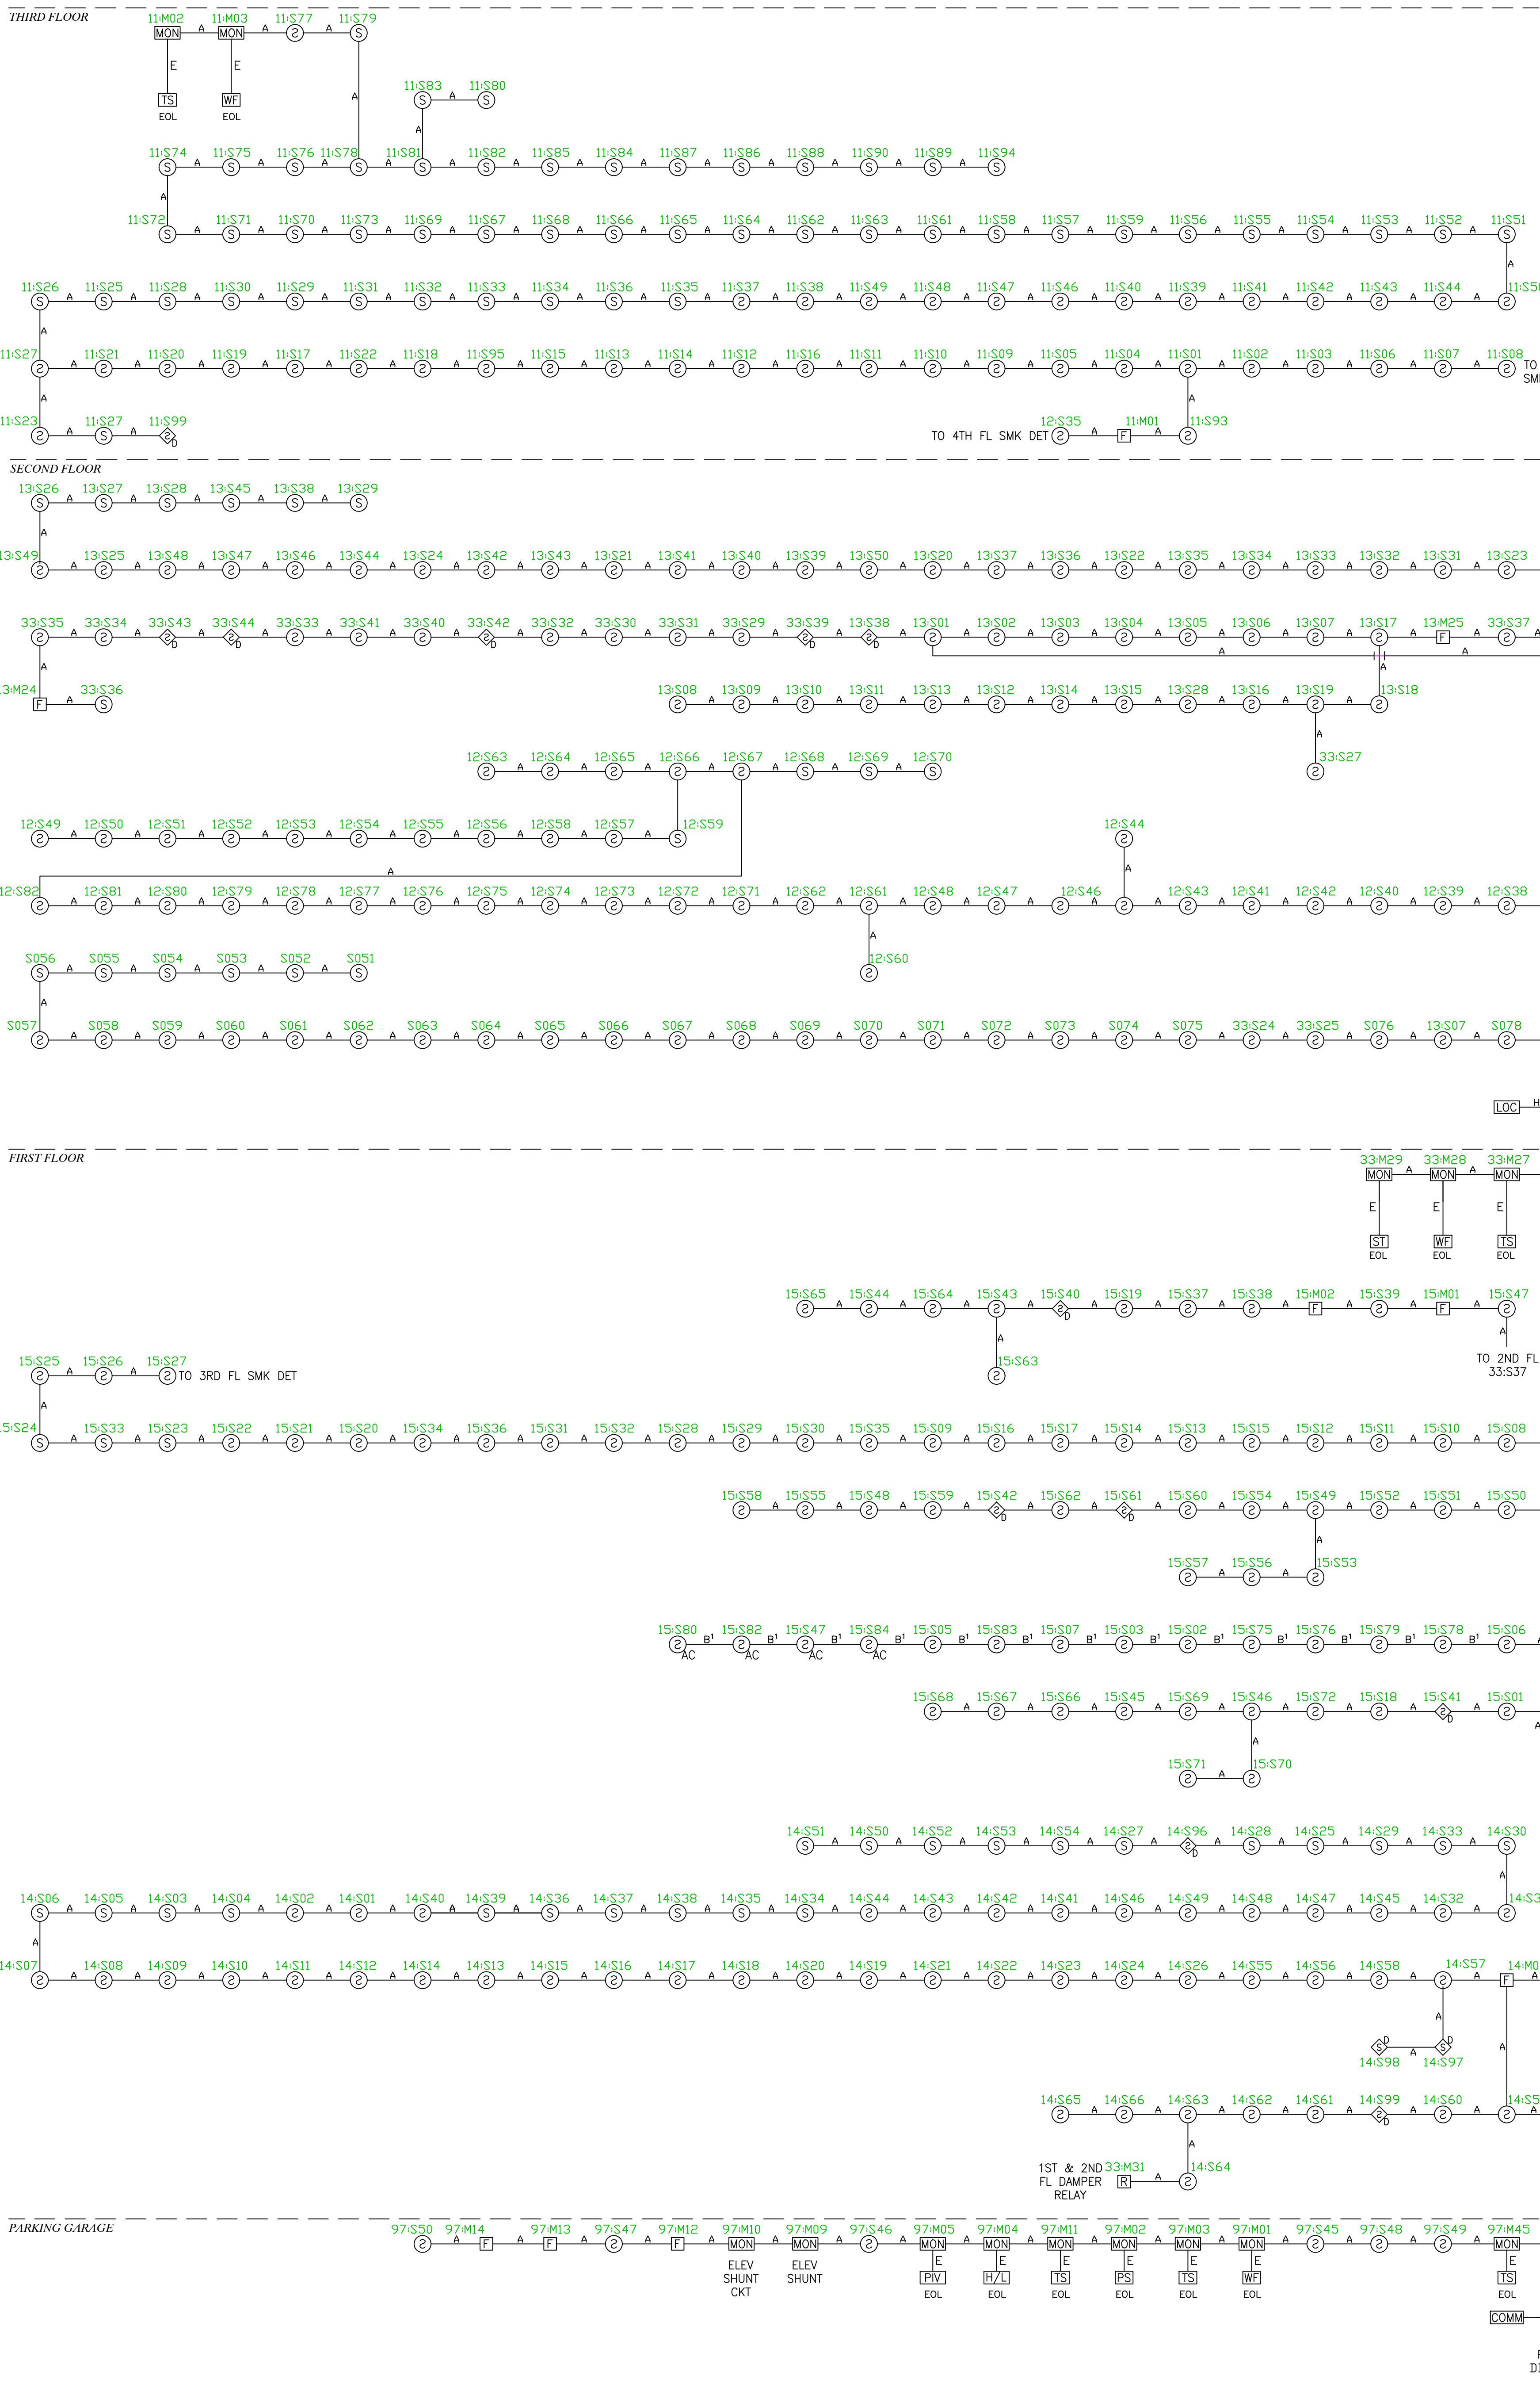

FIRE ALARM SYSTEM
MULTICARE GSMOB
BUILDING FIRE ALARM DRAWING
1450 - 5TH STREET SE
PUYALLUP, WASHINGTON 98372

City of Puyallup Development & Permitting Services ISSUED PERMIT	
Building	Planning
Engineering	Public Works
Fire	Traffic


REVISIONS		DESCRIPTION
DATE	REV	
11/3/25		PERMIT DRAWINGS
PROJ. MGR.: Andrew Earle DRAFTER: HEW		
FA-2 SHEET NO. 2 OF 8		

FIRE ALARM SYSTEM
MULTICARE GSMOB
BUILDING FIRE ALARM DRAWING
1450 - 5TH STREET SE
PUYALLUP, WASHINGTON 98372



City of Puyallup Development & Permitting Services ISSUED PERMIT			
Building	Planning	Engineering	Public Works
Fire	Traffic		

REVISIONS		DESCRIPTION
DATE	BY	PERMIT DRAWINGS
11/2/25		

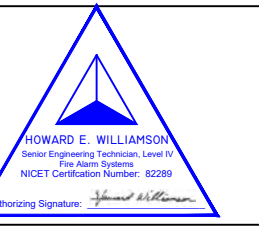


FIRE ALARM SYSTEM
MULTICARE GSMOB
BUILDING FIRE ALARM DRAWING
1450 - 5TH STREET SE
PUYALLUP, WASHINGTON 98372

REVISIONS		
REV	DATE	DESCRIPTION
	1/13/25	PERMIT DRAWINGS

PROJ. MGR.: Andrew Earle
DRAFTER: HEW

FA-4
SHEET NO.
4 OF 8

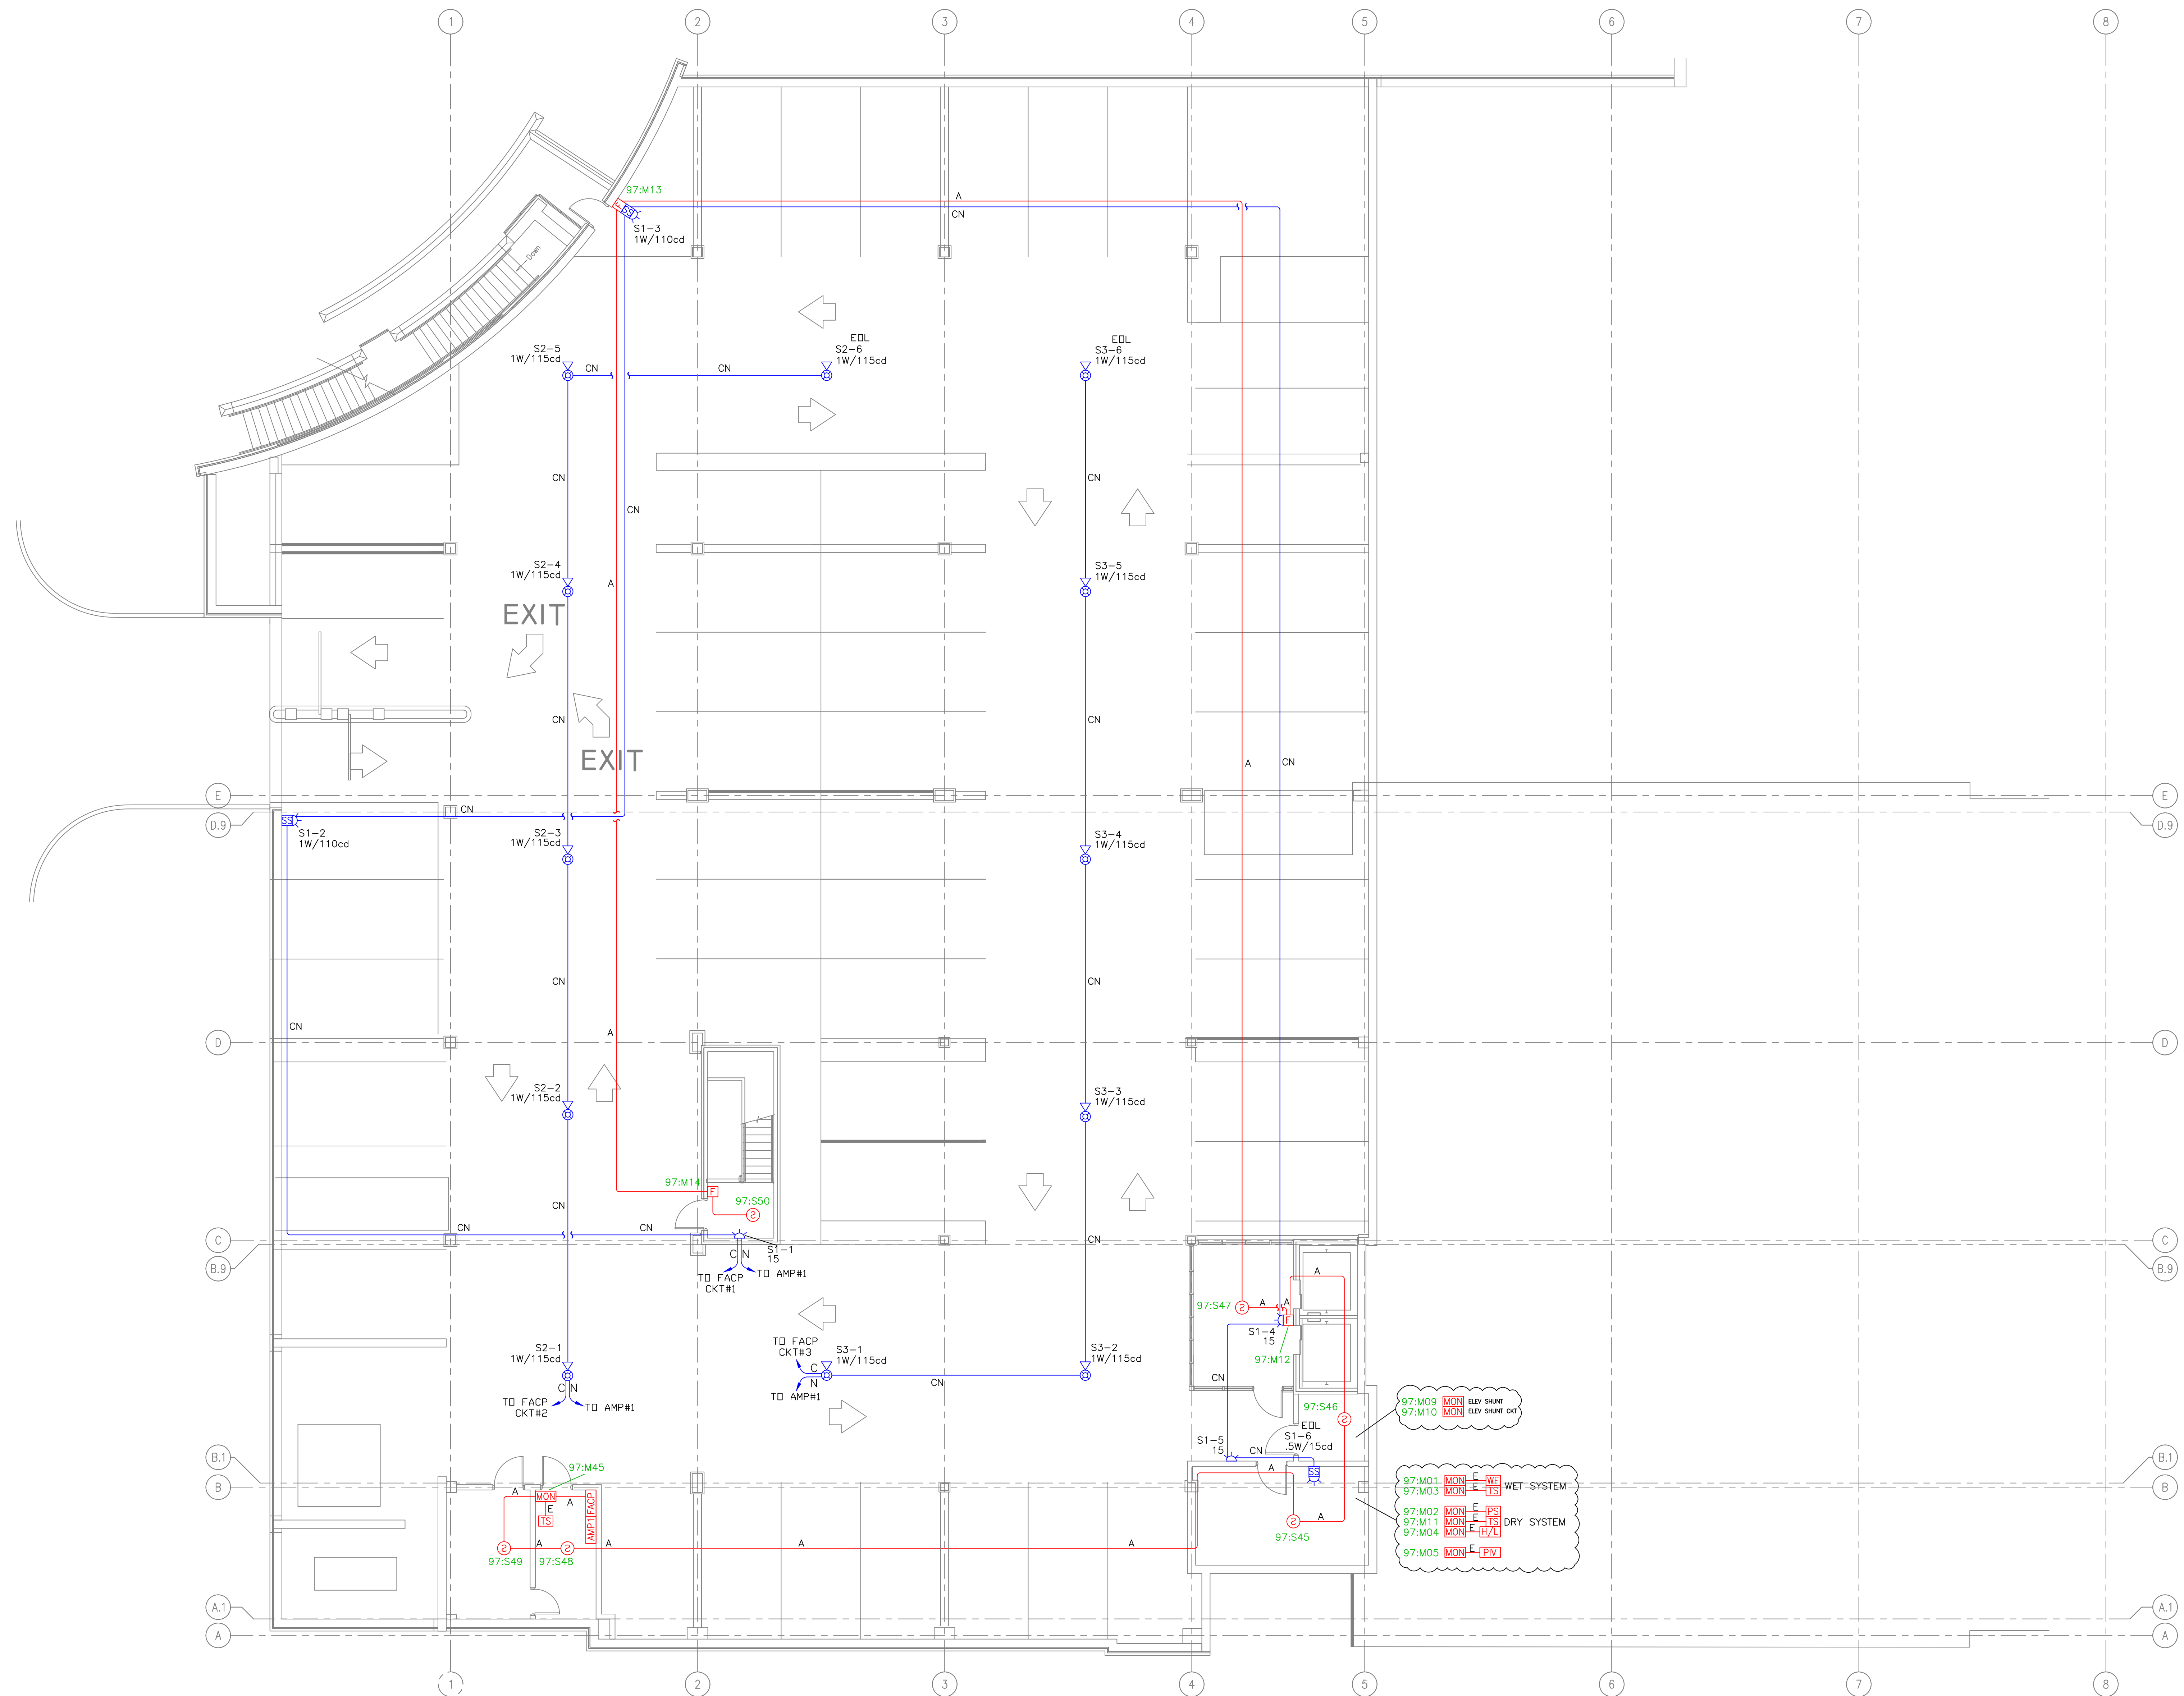


 **PARKING GARAGE - FIRE ALARM FLOOR PLAN**
SCALE: 1/8"=1'-0"



SCALE: 1/8"=1'-0"



**FIRE ALARM SYSTEM
MULTICARE GSMOB
BUILDING FIRE ALARM DRAWING
1450 - 5TH STREET SE
PUYALLUP, WASHINGTON 98372**

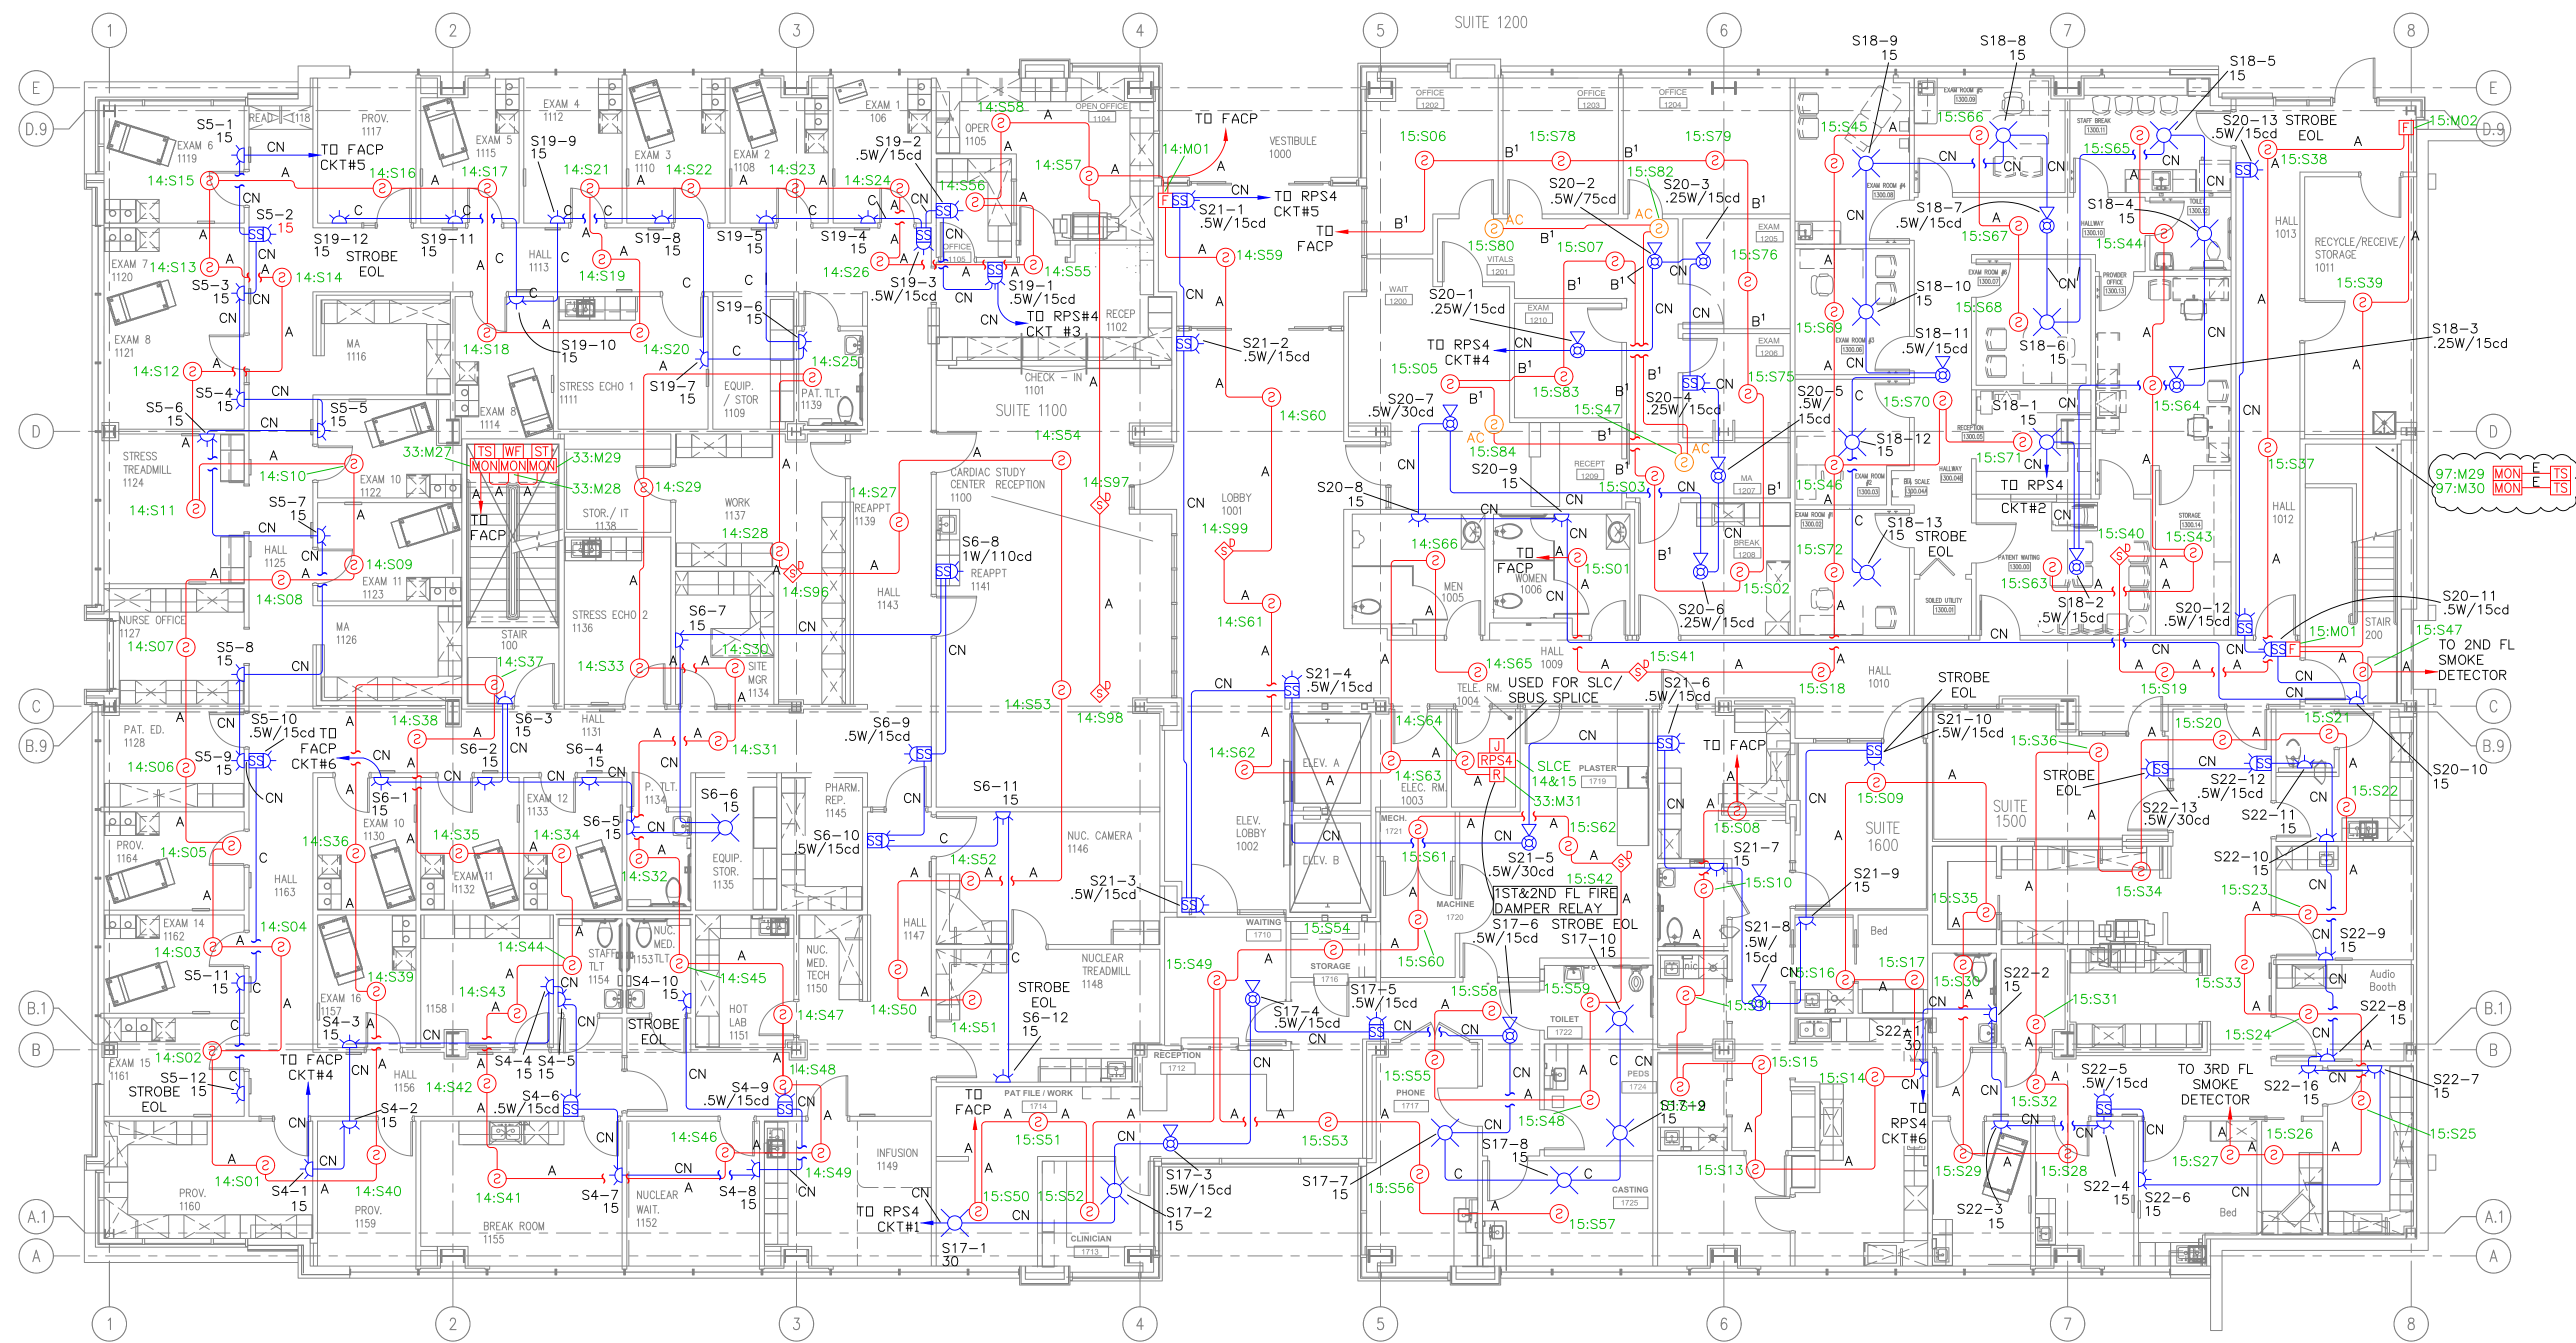


FIRST FLOOR - FIRE ALARM FLOOR PLAN
SCALE: 1/8"=1'-0"

City of Puyallup Development & Permitting Services ISSUED PERMIT	
Building	Planning
Engineering	Public Works
Fire	Traffic

REVISIONS	DESCRIPTION
REV	DATE
1	11/2/25


PROJ. MGR.: Andrew Earle
DRAWN BY: HEW

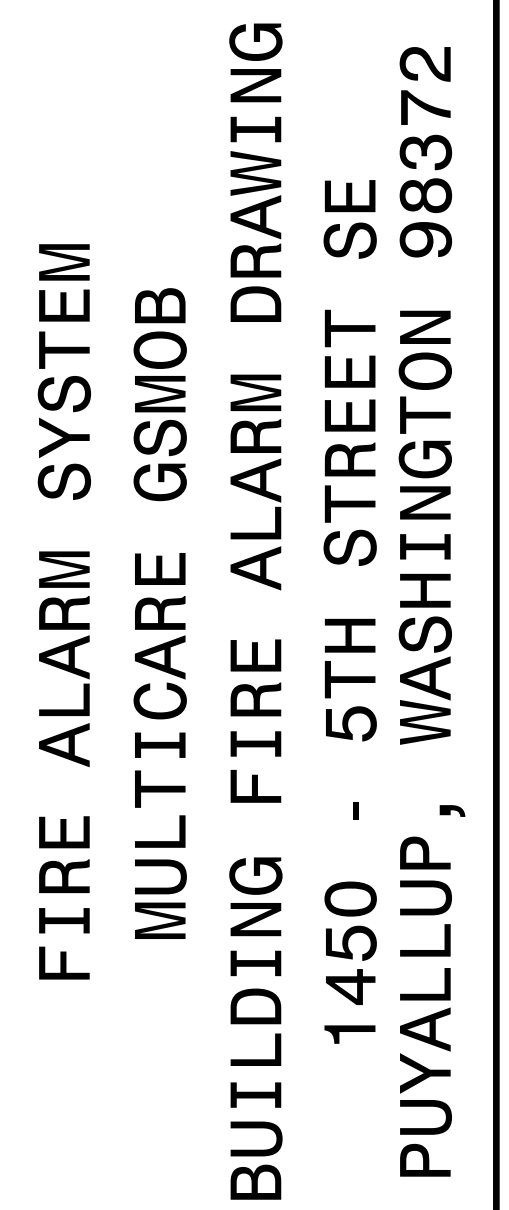

City of Puyallup Development & Permitting Services ISSUED PERMIT	
Building	Planning
Engineering	Public Works
Fire	Traffic

REV	DATE	DESCRIPTION
	1/18/25	PERMIT DRAWINGS

PROJ. MGR.: Andrew Earle
DRAFTER: HEW

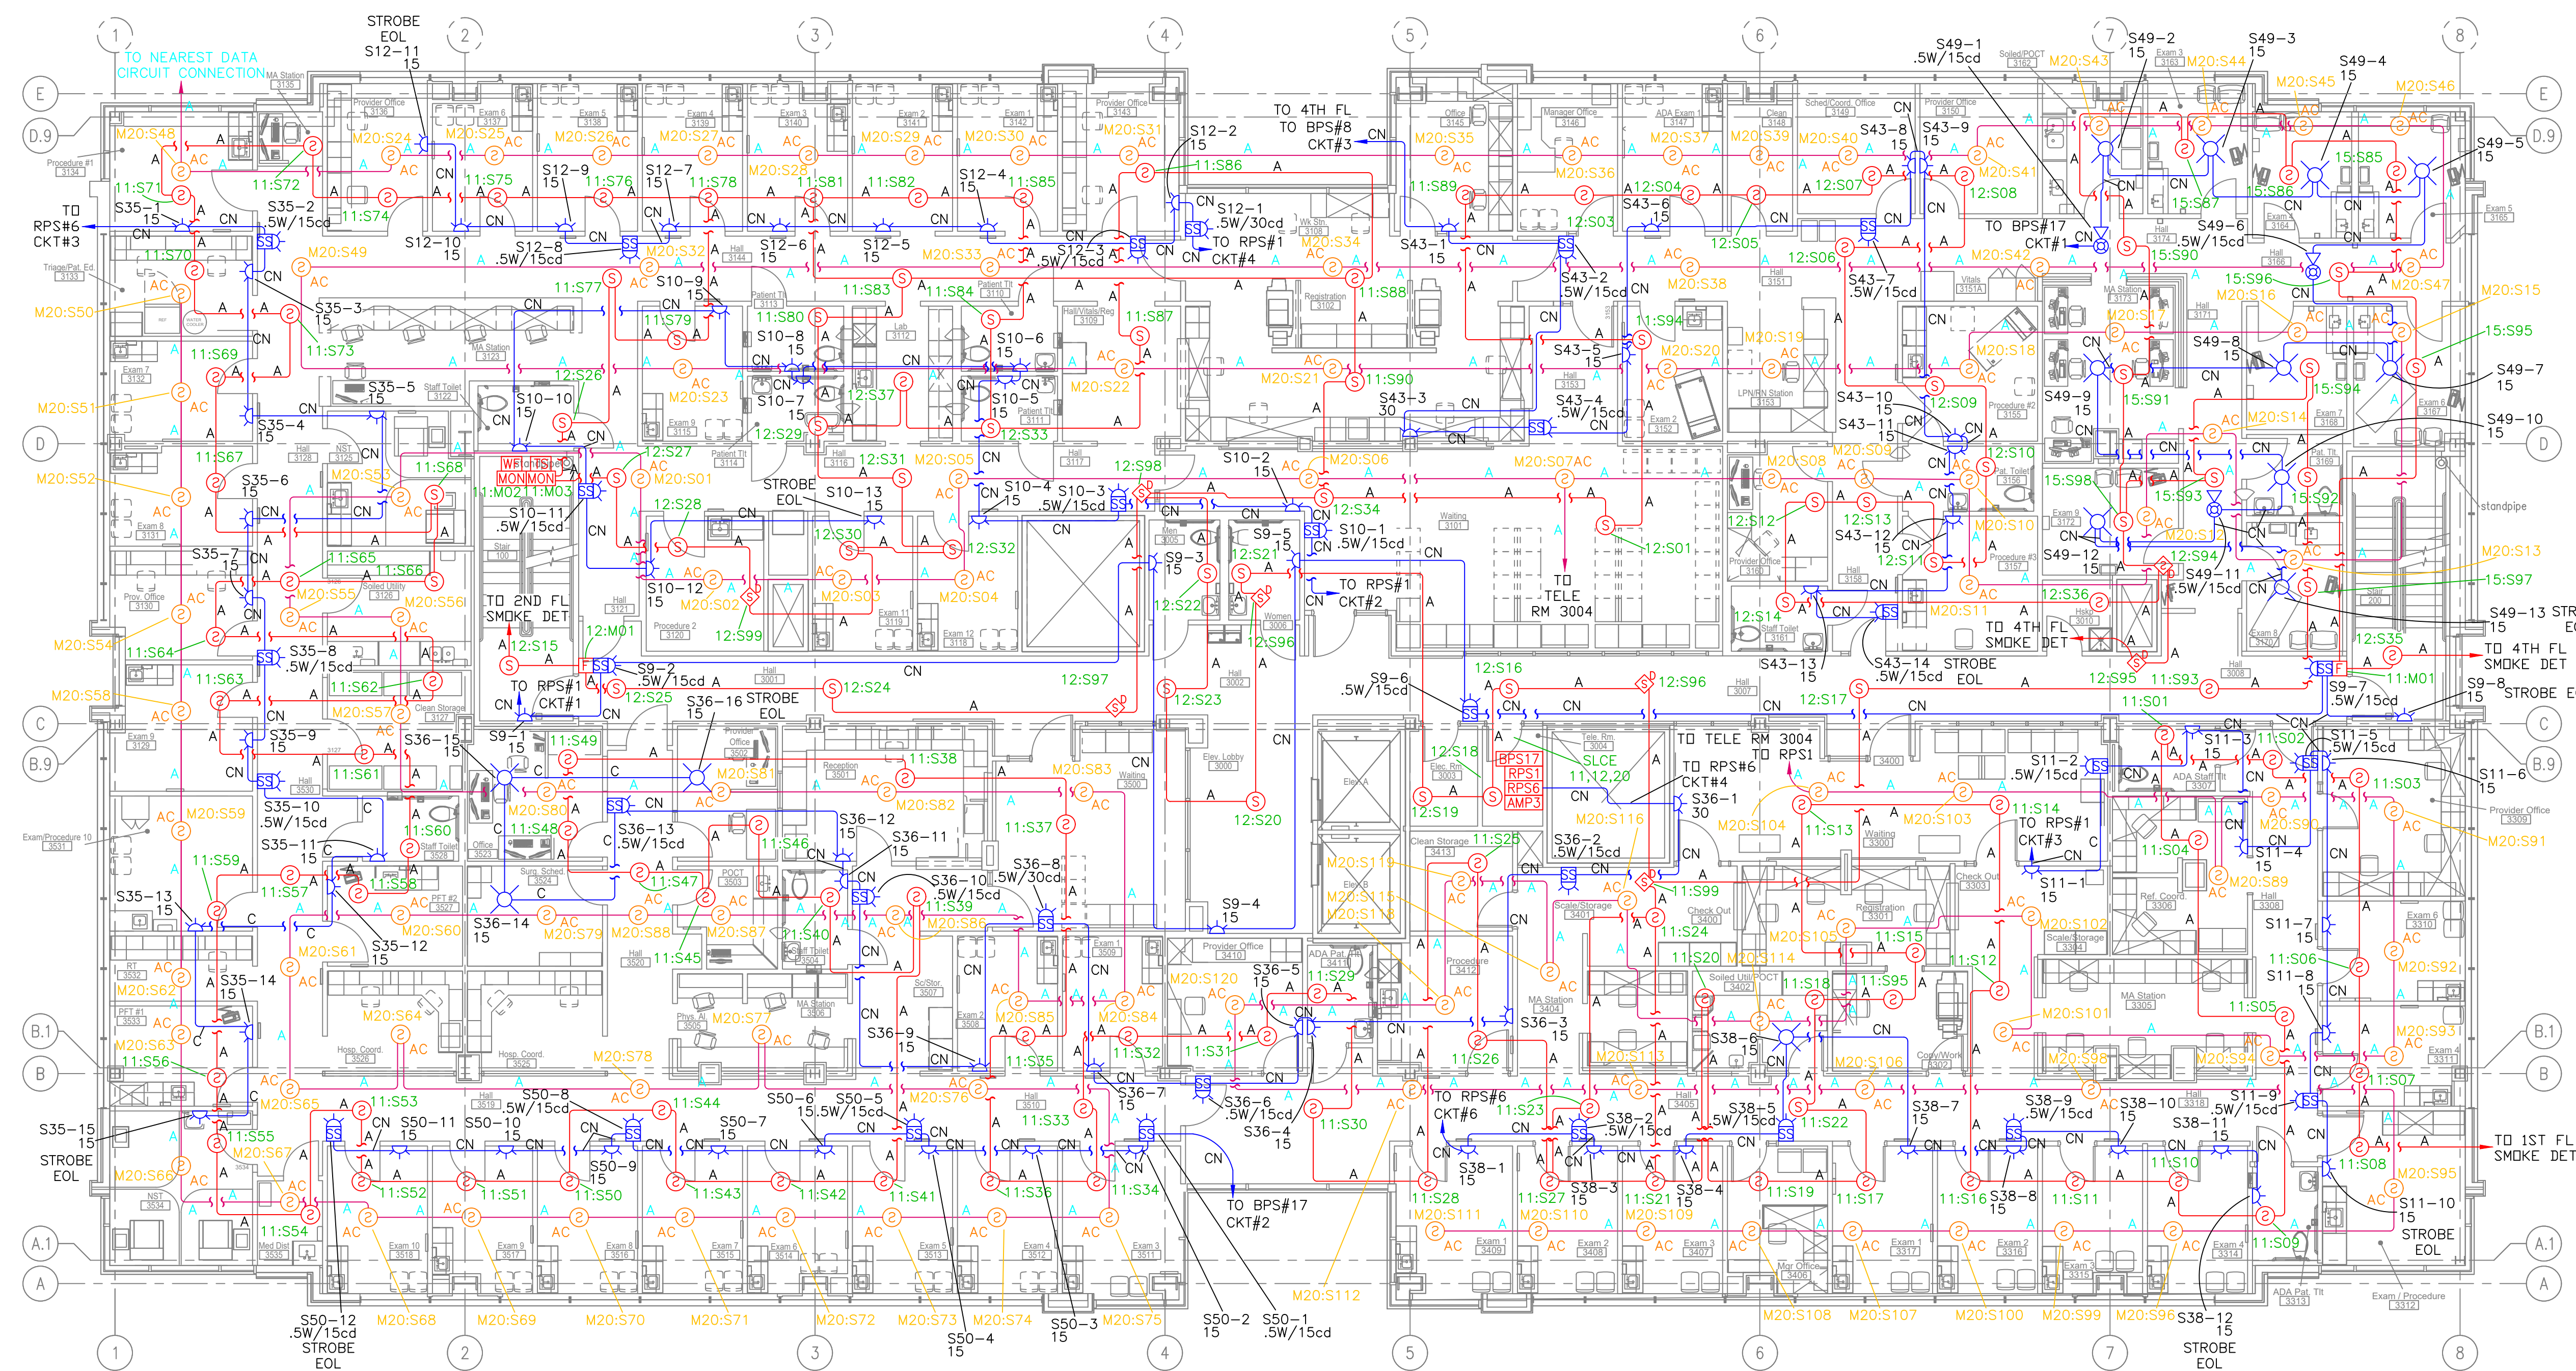

THIRD FLOOR - FIRE ALARM FLOOR PLAN
SCALE: 1/8"=1'-0"


FIRE ALARM SYSTEM
MULTICARE GSMOB
BUILDING FIRE ALARM DRAWING
1450 - 5TH STREET SE
PUYALLUP, WASHINGTON 98372

City of Puyallup Development & Permitting Services ISSUED PERMIT	
Building	Planning
Engineering	Public Works
Fire	Traffic

REVISIONS	DESCRIPTION
REV	DATE
1	11/2/25

PROJ. MGR.: Andrew Earle
DRAFTER: HEW

**FIRE ALARM SYSTEM
MULTICARE GSMOB
BUILDING FIRE ALARM DRAWING
1450 - 5TH STREET SE
PUYALLUP, WASHINGTON 98372**

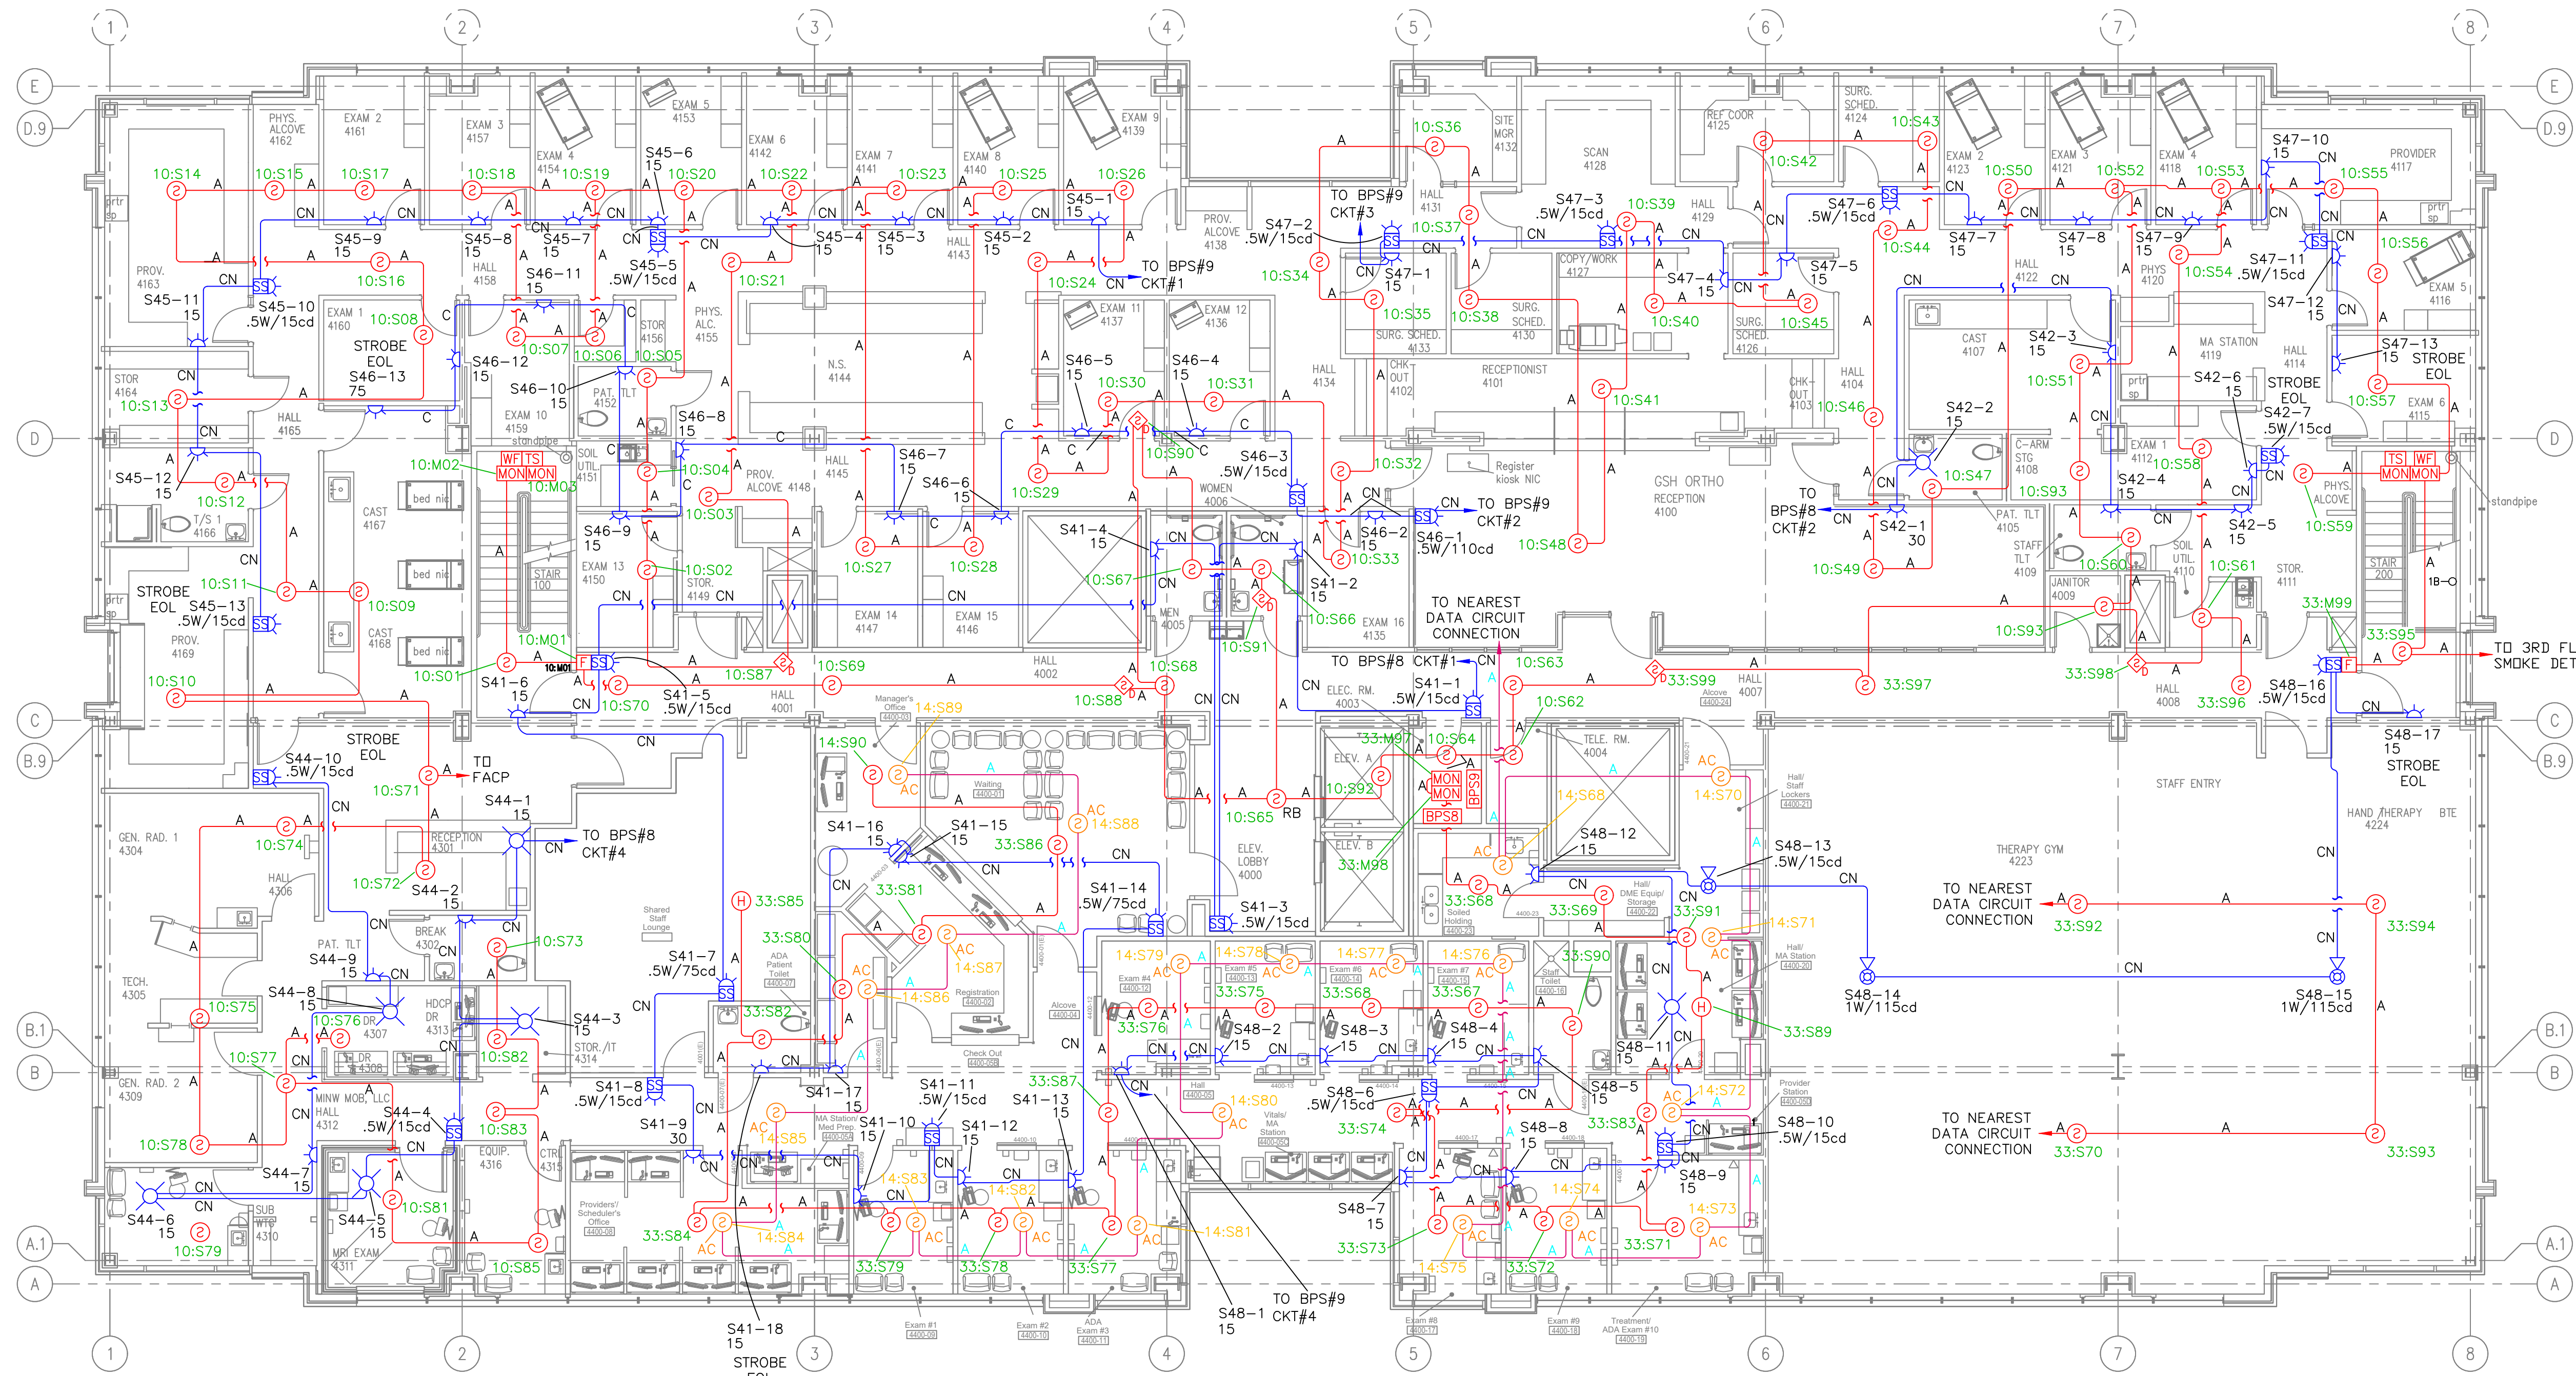

FOURTH FLOOR - FIRE ALARM FLOOR PLAN
SCALE: 1/8"=1'-0"

City of Puyallup Development & Permitting Services ISSUED PERMIT	
Building	Planning
Engineering	Public Works
Fire	Traffic

REVISIONS	
REV	DESCRIPTION
	PERMIT DRAWINGS