

City of Puyallup Development & Permitting Services ISSUED PERMIT			
Building	Planning	Engineering	Public Works
Fire	Traffic		

City of Puyallup
Building
REVIEWED
FOR
COMPLIANCE

BSnowden
04/25/2025
9:50:46 AM



See separate documents for Menu Sign and Monument Sign

The approved construction plans, documents, and all engineering must be posted on the job at all inspections in a visible and readily accessible location.

Full sized legible color plans are required to be provided by the permittee on site for inspection.

Approval of submitted plans is not an approval of omissions or oversights by this office or non compliance with any applicable regulations of local government. The contractor is responsible for making sure that the building complies with all applicable codes and regulations of the local government.

SITE PLAN - TACO TIME
PUYALLUP, WA



DESIGN
17469

PROJECT
TACO TIME | EAST MAIN PUYALLUP

INSTALL LOCATION
1115 E MAIN, PUYALLUP 98372

APPROVED BY/DATE
X

PROPRIETARY AND CONFIDENTIAL: THE INFORMATION CONTAINED IN THIS DRAWING IS THE SOLE PROPERTY OF PLUMB SIGNS. ANY REPRODUCTION IN PART OR AS A WHOLE WITHOUT THE WRITTEN PERMISSION OF PLUMB SIGNS IS PROHIBITED. COPYRIGHT ©2024 PLUMB SIGNS, INC.




PLUMB SIGNS, INC
909 SOUTH 28TH ST
TACOMA, WA 98409
TEL# 253-473-3323
FAX#253-472-3107

SALES
CARIN TAYLOR
DRAWN BY
CARTER / PETERSEN

SCALE
NA
START DATE
09.23.24

SHEET
1 of 7
UPDATED
R2 02.04.25

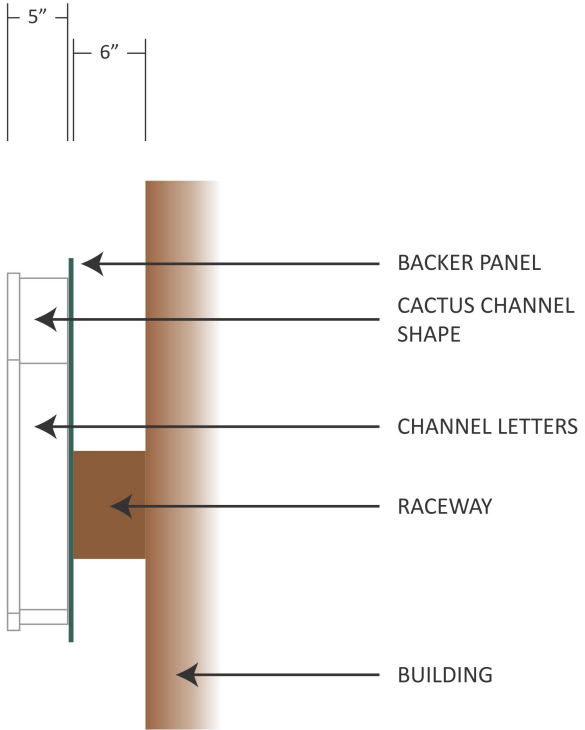

1

WALL DISPLAY/CHANNEL LETTERS w/ RACEWAY

32.0 SQ. FT.

QTY: 1 (SET)

FABRICATE AND INSTALL ONE (1) DISPLAY AND SET OF CHANNEL LETTERS/LOGO

CHANNEL LETTERS




- CUSTOM FABRICATED ALUMINUM CANNEL LETTERS AS SPECIFIED
- 3/16" WHITE ACRYLIC FACES
- WHITE CHANNEL LETTER RETURNS
- WHITE TRIMCAP
- INTERNALLY ILLUMINATED w/ WHITE LEDs


- MOUNT FLUSH TO CONTOUR BACKGROUND BACKER PANEL
- .125" ALUMINUM BACKER PANEL PAINTED MATTHEWS HARTFORD GREEN
- CACTUS HAS HOLLY GREEN TRANSLUCENT VINYL (3M 230-76) APPLIED TO FACE

WALL BG COLOR IS SHERWIN WILLIAMS SW-6356 "COPPER MOUNTAIN"

INSTALL/FABRICATION NOTES:

- INSTALL BACKER PANEL TO RACEWAY (9" HIGH w/ 6" DEPTH)
- BOTTOM OF SIGN SHOULD BE 19'-0" FROM GRADE/SLAB
- SIGN SHOULD BE ALIGNED LEFT w/ WINDOW JUST BELOW

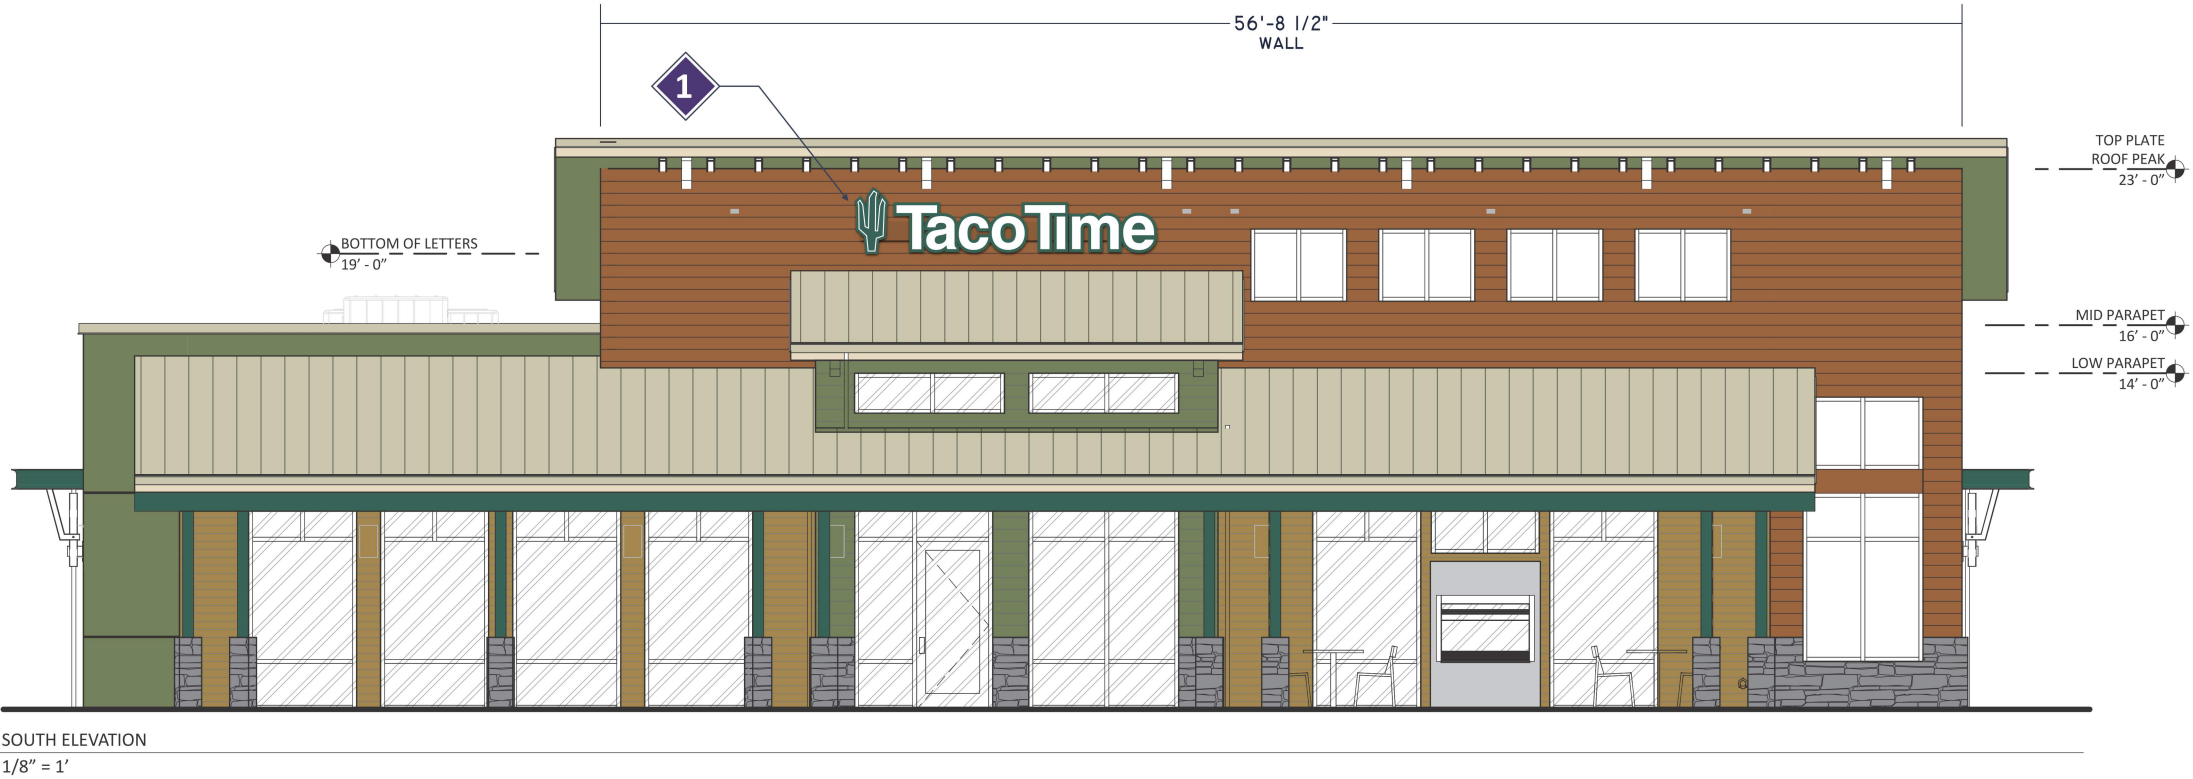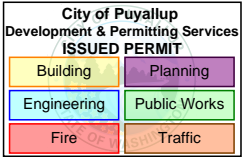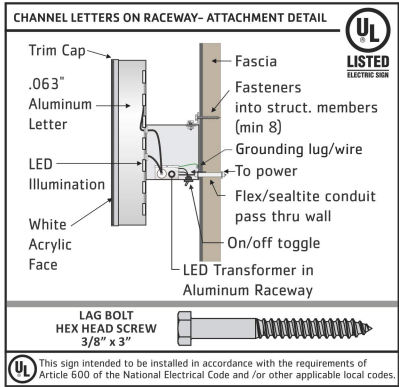

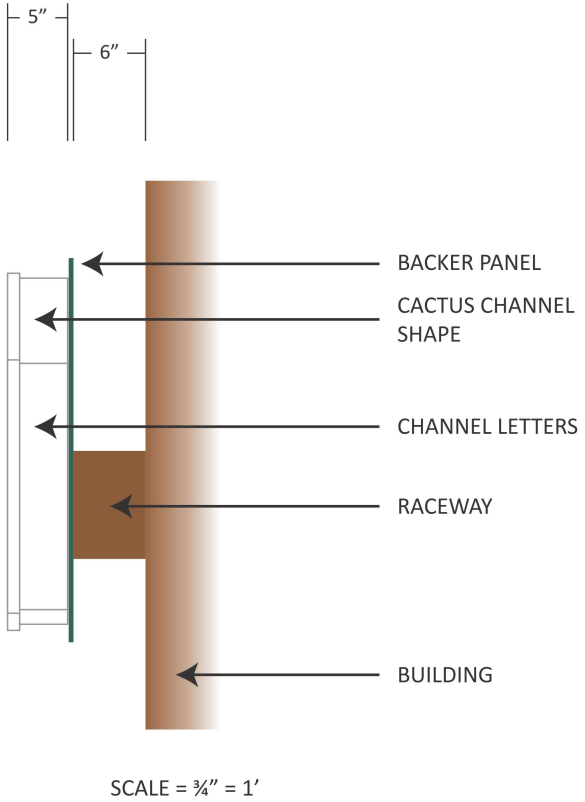

2 WALL DISPLAY/CHANNEL LETTERS w/ RACEWAY

32.0 SQ. FT. QTY: 1 (SET)

FABRICATE AND INSTALL ONE (1) DISPLAY AND SET OF CHANNEL LETTERS/LOGO

CHANNEL LETTERS



- CUSTOM FABRICATED ALUMINUM CANNEL LETTERS AS SPECIFIED
- 3/16" WHITE ACRYLIC FACES
- WHITE CHANNEL LETTER RETURNS
- WHITE TRIMCAP
- INTERNALLY ILLUMINATED w/ WHITE LEDs


- MOUNT FLUSH TO CONTOUR BACKGROUND BACKER PANEL
- .125" ALUMINUM BACKER PANEL PAINTED MATTHEWS HARTFORD GREEN
- CACTUS HAS HOLLY GREEN TRANSLUCENT VINYL (3M 230-76) APPLIED TO FACE

WALL BG COLOR IS SHERWIN WILLIAMS SW-6356 "COPPER MOUNTAIN"


INSTALL/FABRICATION NOTES:

- INSTALL BACKER PANEL TO RACEWAY (9" HIGH w/ 6" DEPTH)
- BOTTOM OF SIGN SHOULD BE 15'-0" FROM GRADE/SLAB
- SIGN SHOULD BE CENTERED ON FASCIA AREA OF SAME COLOR

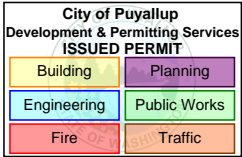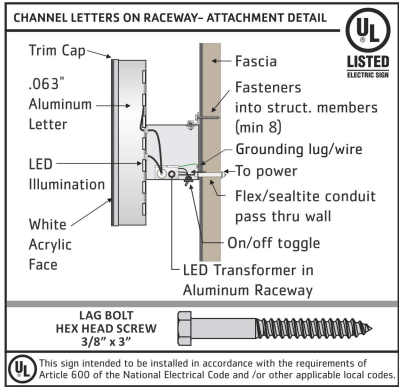

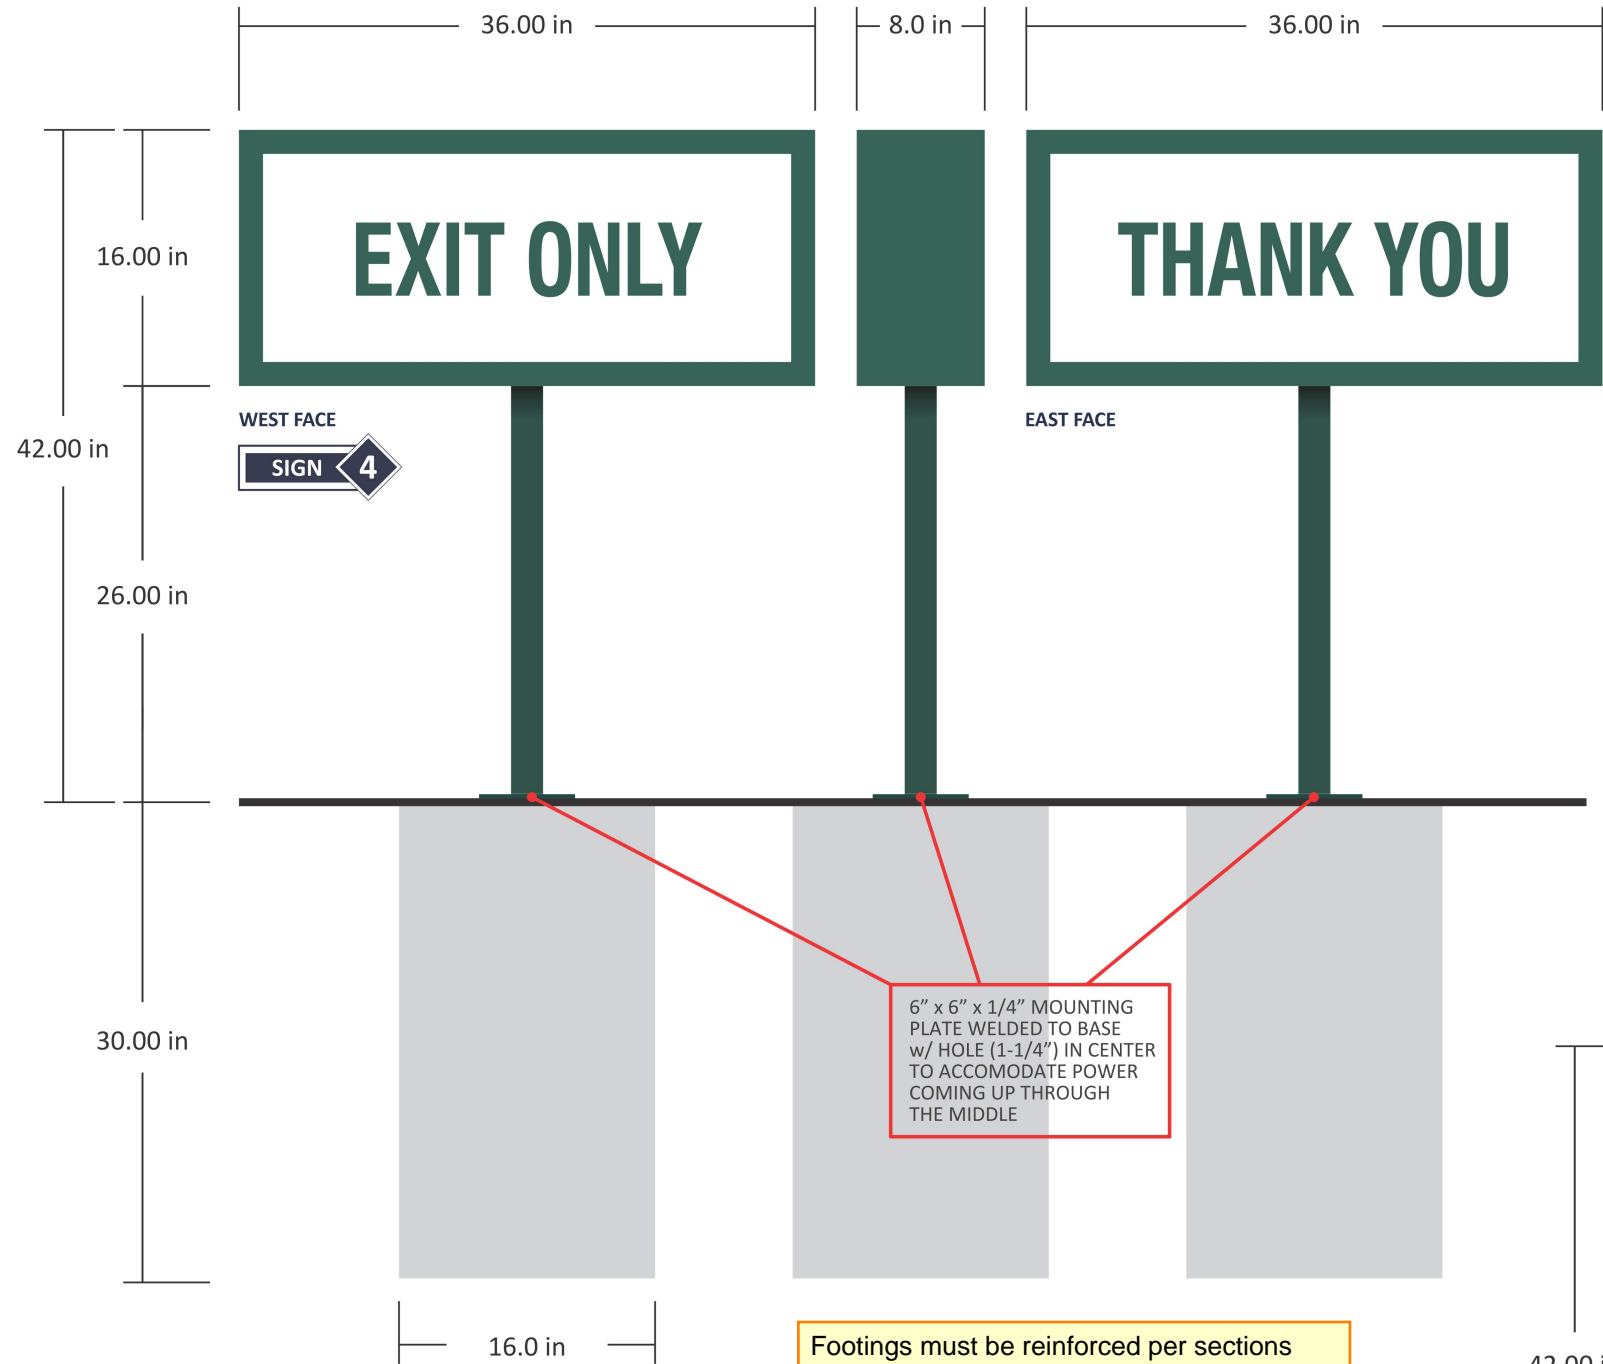

Footings must be reinforced per sections 1810.3.9.2 and 1810.3.9.4.2 of the 2021 Washington State Building Code. Reinforcement must be approved by the City Inspectors prior to covering.

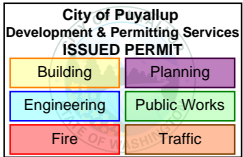

4

ILLUMINATED D/F DIRECTIONAL SIGN

4.0 SQ. FT.

QTY: 1

FABRICATE & INSTALL ONE (1) NEW POLE CABINET

- .090 ALUMINUM
- 1-1/2" RETAINER
- TRANSLUCENT WHITE ACRYLIC FACES
- TRANSLUCENT HOLLY GREEN [230-76] VINYL OVERLAY
- WHITE LED INTERNAL ILLUMINATION

- 2" SQUARE TUBE POST
- PAINT POLE & CABINET MATTHEWS HARTFORD GREEN
- FABRICATE 6" x 6" x 1/4" SQUARE MOUNTING PLATE LEAVING A 1-1/4" HOLE FOR POWER TO COME UP STRAIGHT THROUGH SQ TUBE POST
- MOUNTING PLATE BOLTS TO 16" SONOTUBE USING 1/2" ANCHOR BOLTS TO BE DRILLED ON SITE
- CONCRETE WILL BE DRILLED ONSITE TO MATCH PLATE HOLE PATTERN

INSTALL

- GC WILL SUPPLY SONOTUBE IN GROUND PRIOR TO INSTALL 16" DIAMETER & 30" DEPTH

7

ILLUMINATED D/F DIRECTIONAL SIGN

4.0 SQ. FT.

QTY: 1

INSTALL ONE (1) POLE CABINET [CLIENT SUPPLIED]

- TRANSLUCENT WHITE ACRYLIC FACES
- SOUTH FACE: TRANSLUCENT VINYL OVERLAY HOLLY GREEN [230-76]
- DIGITAL PRINT TO MATCH PANTONE 5767C
- NORTH FACE: BLOCK OUT VINYL PAINTED AS CABINET
- WHITE LED INTERNAL ILLUMINATION

- 2" SQUARE TUBE POST
- PAINT POLE & CABINET MATTHEWS HARTFORD GREEN
- FABRICATE 6" x 6" x 1/4" SQUARE MOUNTING PLATE LEAVING A 1-1/4" HOLE FOR POWER TO COME UP STRAIGHT THROUGH SQ TUBE POST
- MOUNTING PLATE BOLTS TO 16" SONOTUBE USING 1/2" ANCHOR BOLTS TO BE DRILLED ON SITE
- CONCRETE WILL BE DRILLED ONSITE TO MATCH PLATE HOLE PATTERN


INSTALL

- GC WILL SUPPLY SONOTUBE IN GROUND PRIOR TO INSTALL 16" DIAMETER & 30" DEPTH

Prior to installation:
Review anchor product's ICC-ES Report and install the product per the report. If the report states special inspection(s) are required - the final special inspection report must be on site during City inspections.




[SAME INSTALL/FOOTING DETAIL AS SIGN 4 ABOVE]

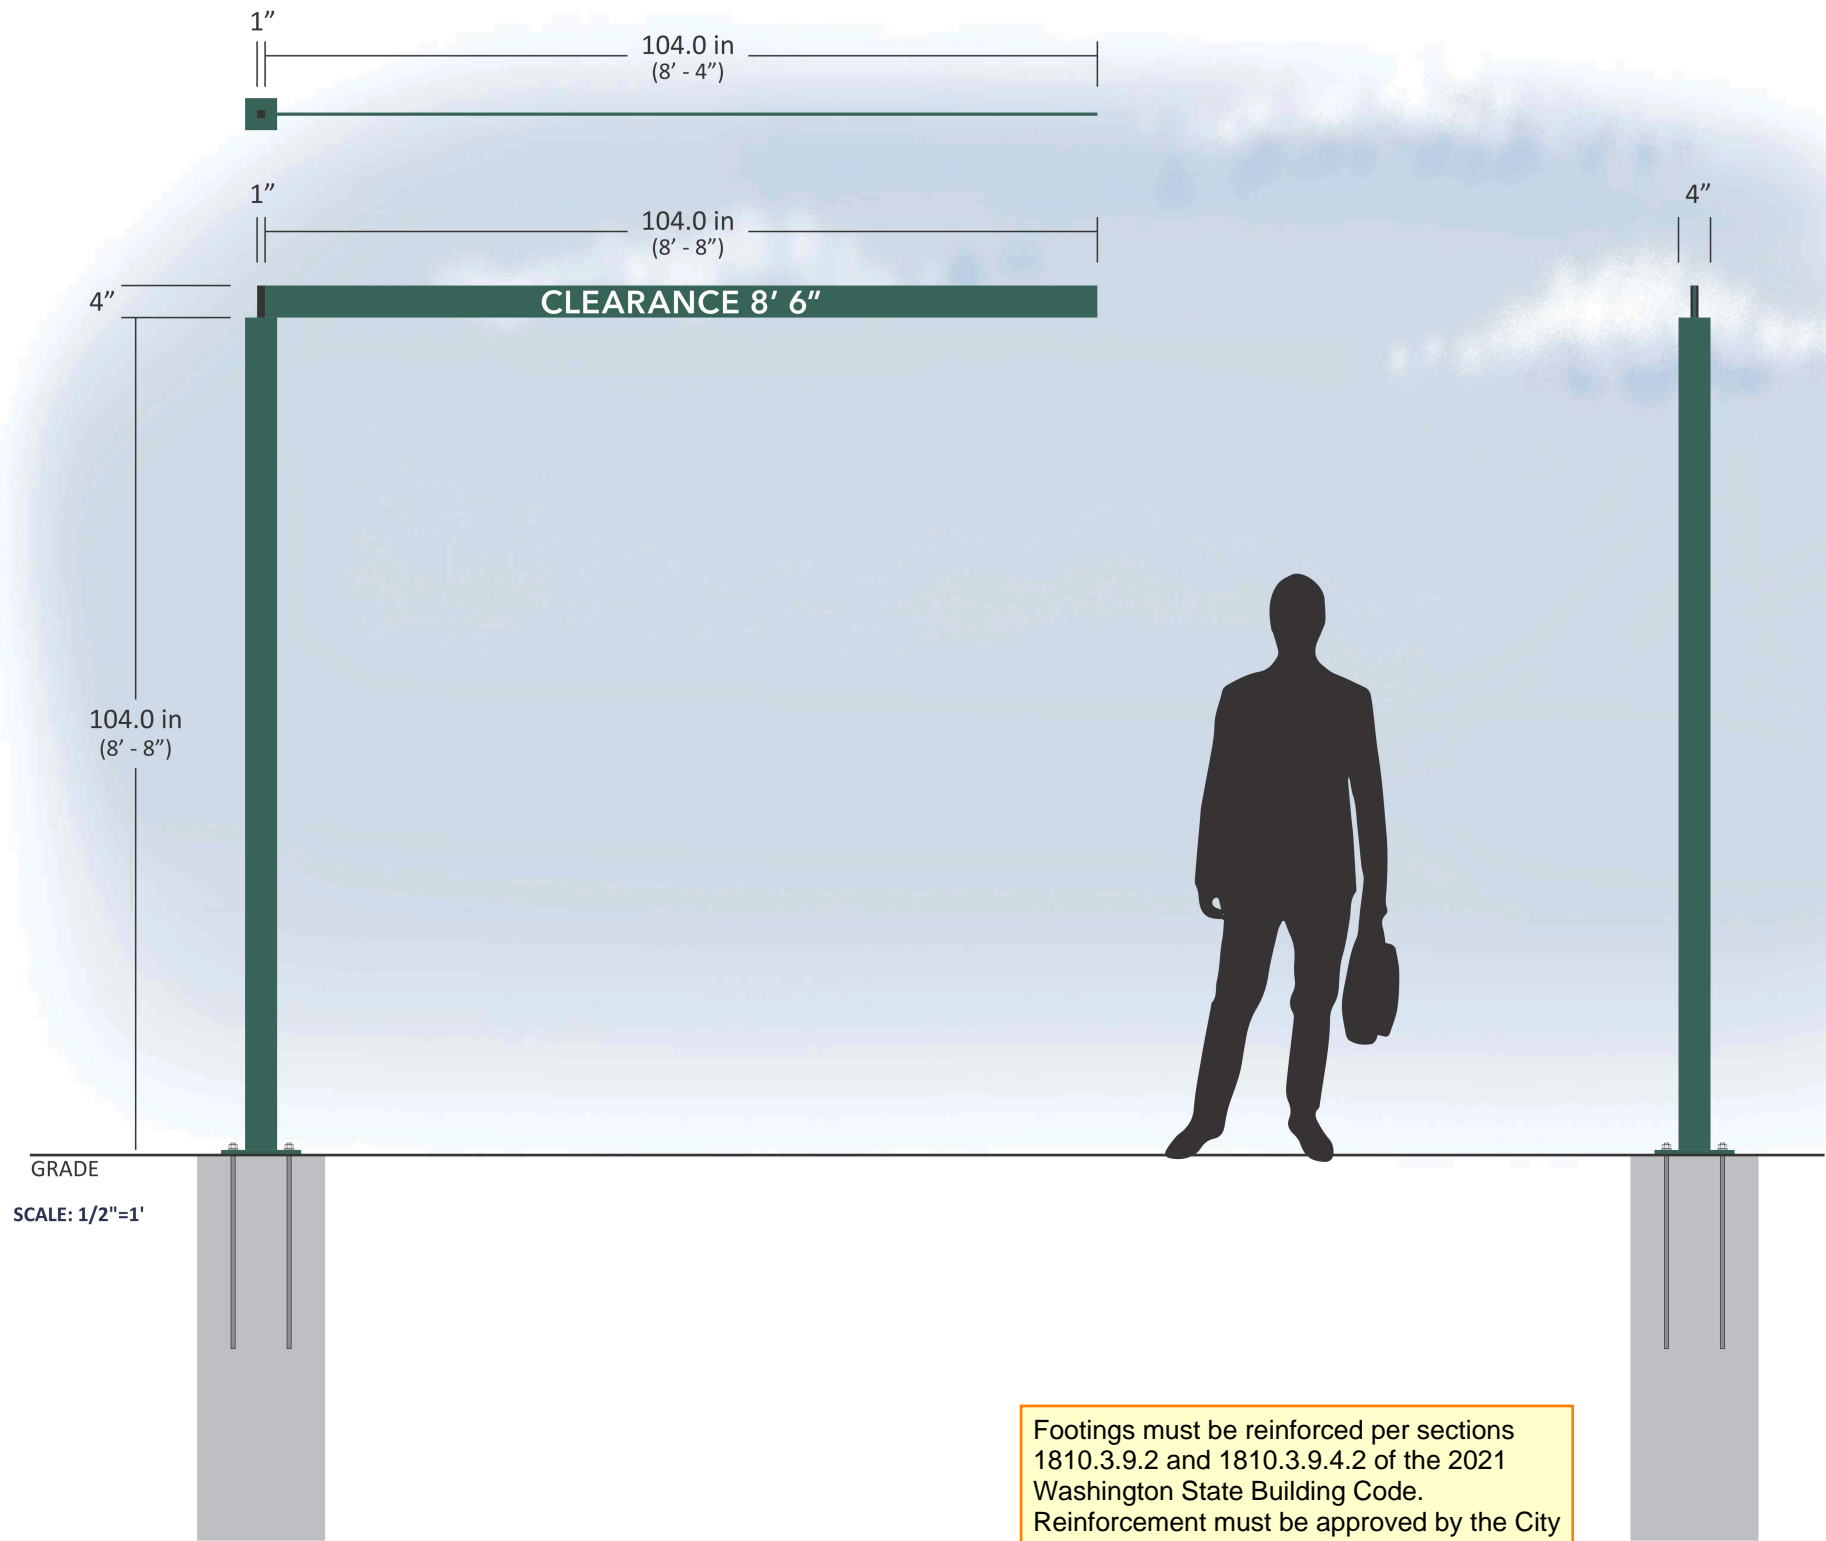

Footings must be reinforced per sections 1810.3.9.2 and 1810.3.9.4.2 of the 2021 Washington State Building Code. Reinforcement must be approved by the City Inspectors prior to covering.

City of Puyallup Development & Permitting Services ISSUED PERMIT			
Building	Planning		
Engineering	Public Works		
Fire	Traffic		

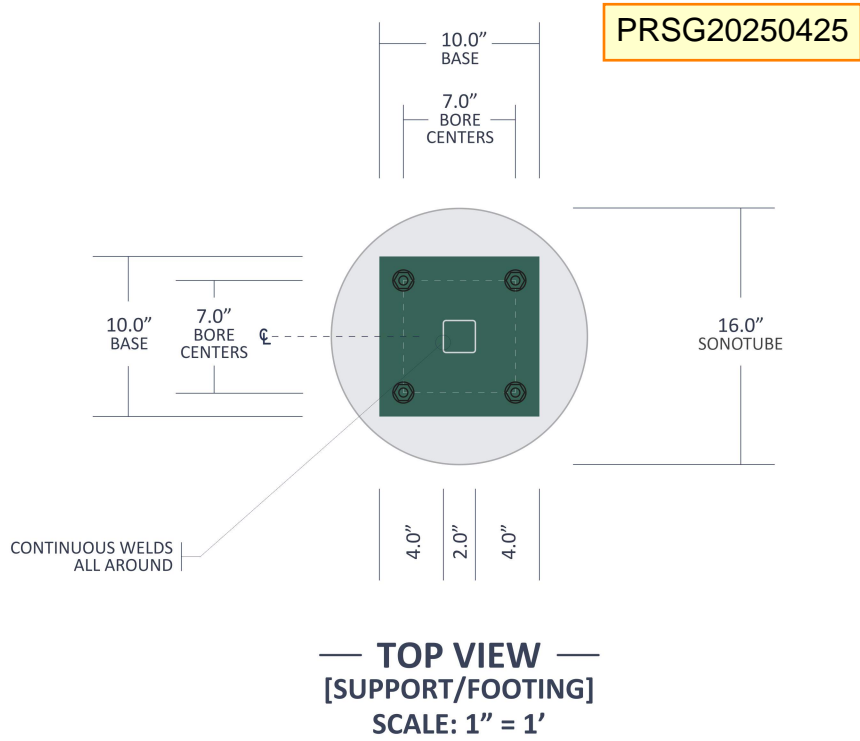

6 CLEARANCE BARS

QTY: 2

FABRICATE AND INSTALL TWO (2) CLEARANCE BARS FOR DRIVE THRU

- 4"x4" ALUMINUM SQUARE TUBE, PTM MATTHEWS HARTFORD GREEN
- 3/8" THICK ALUMINUM BAR, 4" TALL, PAINTED MATTHEWS HARTFORD GREEN
- WELD AS NEEDED
- APPLY OPAQUE VINYL: WHITE (GERBER 220-10) TO READ "CLEARANCE 8' 6"

- INSTALL USING 12" x 12" x 1/2" ALUMINUM PLATE, PTM HARTFORD GREEN
- 3/4" ANCHOR BOLT x 24" IN LENGTH INTO CONCRETE

COORDINATE PLACEMENT OF CONCRETE w/ G.C.

