


LEGEND		
ITEM #	MODEL #	DESCRIPTION
1	TEBCCT-200-CWUV	200 GAL BATCH COOK/CHILL TANK, CWTO, ULTRAVIOLET

REVISIONS				
ZONE	REV	DESCRIPTION	DATE	REVISED BY
	A	RELEASED FOR APPROVAL	3/14/2025	T. AFFELDT

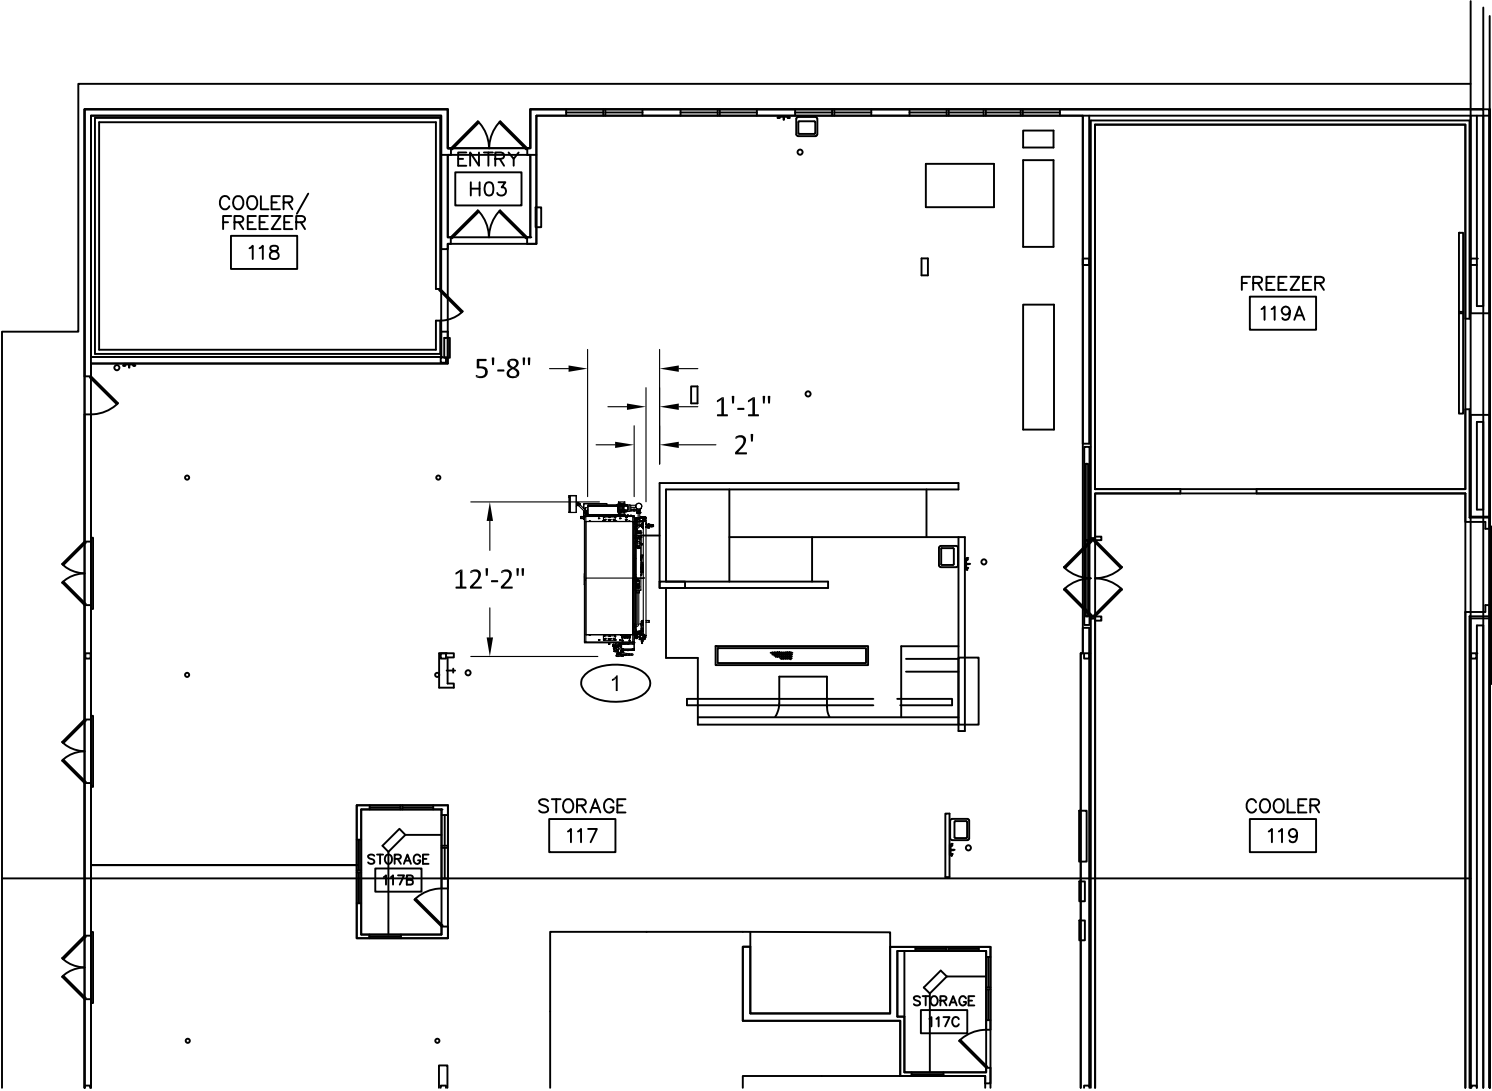

PRMH20250723

City of Puyallup
Development & Permitting Services
ISSUED PERMIT

Building

Planning

Engineering

Public Works

Fire

Traffic

TUCS DRAWING APPROVAL

APPROVED BY: _____ DATE: _____

TUCS EQUIPMENT INC. MUST RECEIVE FINAL APPROVAL OF THIS DRAWING PRIOR TO FABRICATION. APPROVAL OF THIS DRAWING CERTIFIES THAT THE SPECIFIED EQUIPMENT HAS BEEN REVIEWED AND ALL OF THE INFORMATION CONTAINED WITHIN HAS BEEN APPROVED AND ACCEPTED BY PURCHASER

TITLE: PUYALLUP - QUOTE 24092 REV 8

FLOOR PLAN

DATE: 3/14/2025

DRAWN BY: T. AFFELDT

UNLESS OTHERWISE SPECIFIED:

DIMENSIONS ARE IN INCHES
AND ARE USED FOR
REFERENCE ONLY.

ON-SITE VERIFICATION MAY
BE REQUIRED.

DO NOT SCALE.

MODEL NUMBER

FLOOR PLAN



REV

A

SHEET:
1 OF 3


LEGEND								
** ELECTRICAL				WATER				
TOTAL AMPS	VOLTS	PHASE	PLUG IN	WATER SUPPLY IN	OVERFLOW	BALL VALVE DRAIN (NPT)	TO KETTLES	FROM KETTLES
(3.3)	208	3	NO	¾" NPT	* ¾" NPT	* ½" NPT	1 ½" DC	1 ½" DC

* DIRECT CONNECTION TO DRAIN NOT REQUIRED, PLACEMENT NEAR FLOOR SINK SUGGESTED.
** ELECTRICAL SUPPLY AND CONTROLS PROVIDED THROUGH COOK/CHILLER CONTROL PANEL.

REVISIONS				
ZONE	REV	DESCRIPTION	DATE	REVISED BY
	A	RELEASE FOR APPROVAL	3/14/2025	T. AFFELDT

PRMH20250723

City of Puyallup Development & Permitting Services ISSUED PERMIT	
Building	Planning
Engineering	Public Works
Fire	Traffic

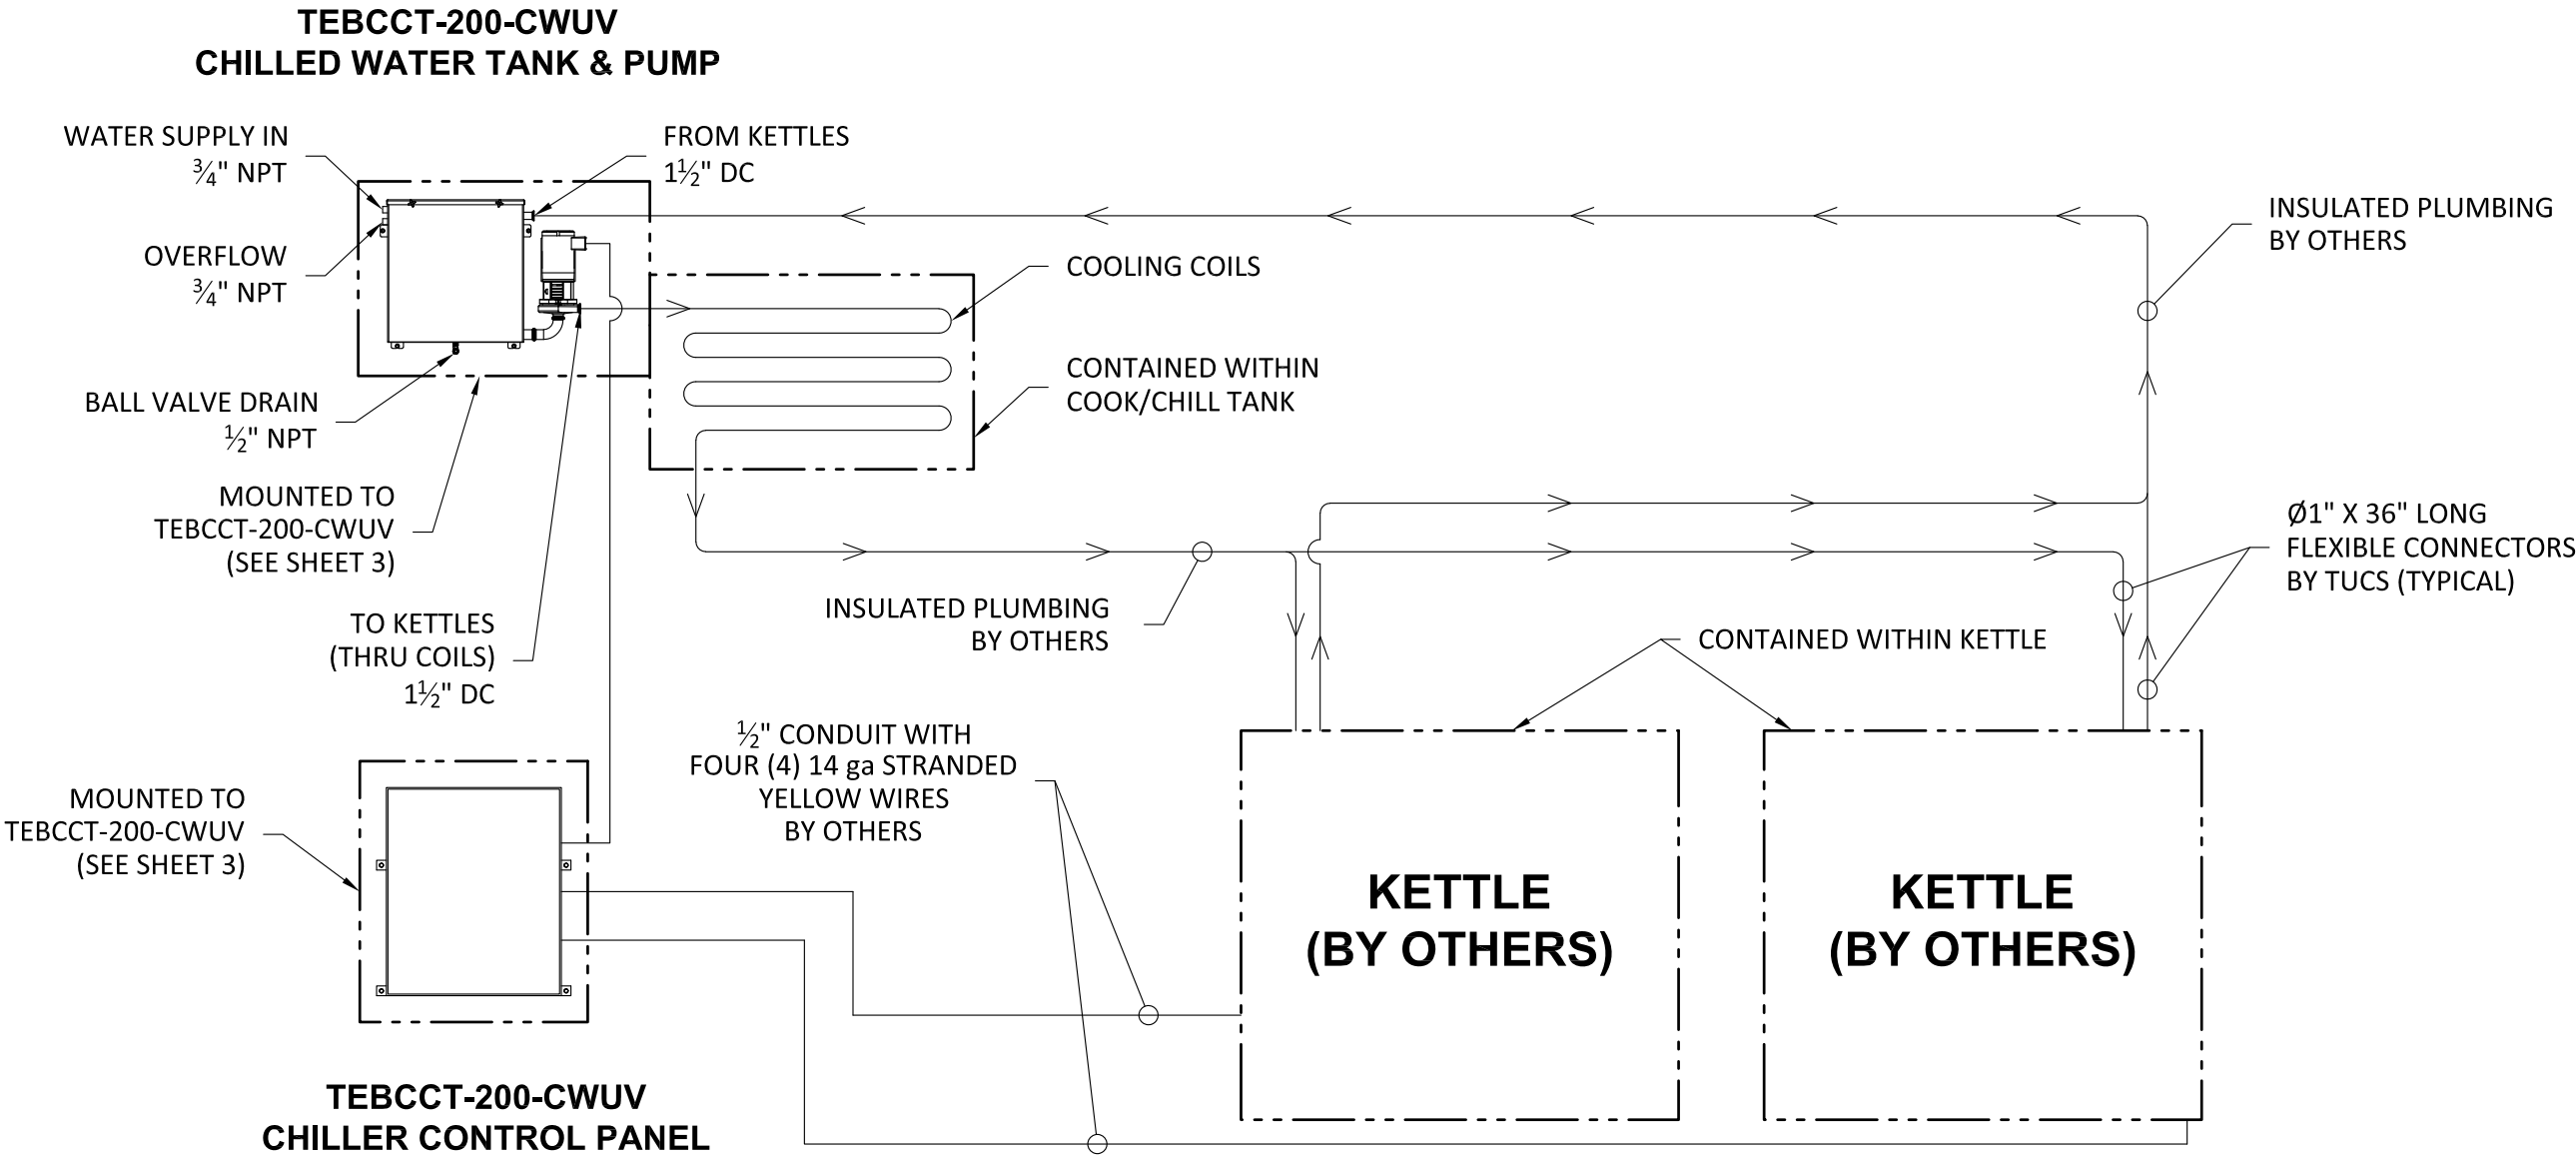

TUCS DRAWING APPROVAL

APPROVED BY: _____ DATE: _____






TUCS EQUIPMENT INC. MUST RECEIVE FINAL APPROVAL OF THIS DRAWING PRIOR TO FABRICATION. APPROVAL OF THIS DRAWING CERTIFIES THAT THE SPECIFIED EQUIPMENT HAS BEEN REVIEWED AND ALL OF THE INFORMATION CONTAINED WITHIN HAS BEEN APPROVED AND ACCEPTED BY PURCHASER

TITLE: PUYALLUP - QUOTE 24092 REV 8 CHILLED WATER TAKE OFF DIAGRAM		MODEL NUMBER	REV
		CHILLED WATER DIAGRAM	A
DATE: 3/14/2025	DRAWN BY: T. AFFELDT	TUCS EQUIPMENT INC. SHEET: 2 OF 3	


LEGEND															
COMPRESSED AIR				ELECTRICAL				EWON	STEAM		WATER		REFRIGERATION		
CFM	PSI	CONNECT SIZE	QUICK DISCONNECT	AMPS	VOLTS	PHASE	PLUG IN	CAT 5 OR WIRELESS	INPUT (NPT)	CONDENSATE RETURN (NPT)	POTABLE (NPT)	DRAIN (DC)	LIQUID	SUCTION	TOTAL BTUH
10	90	¼"	YES	17.1	208	3	NO	CAT 5	1"	1"	¾"	* 2"	(4X) ⅞"	(4X) 1⅜"	230,000

LEGEND NOTES:
* DIRECT CONNECTION TO DRAIN NOT REQUIRED, PLACEMENT NEAR FLOOR SINK SUGGESTED.

 



- NOTES:
- 3' FLEXIBLE CONNECTIONS SHALL BE PROVIDED FOR COMPRESSED AIR, STEAM IN, STEAM OUT, AND POTABLE WATER.
 - INCLUDES DIAL UP ALARM AND LOCKING COVER.
 - SEE SHEET 2 FOR CHILLED WATER TAKE OFF DETAILS.
 - 4X REFRIGERATION COILS BASED ON 4X CUSTOMER SUPPLIED 6HP (60,000 BTU) CONDENSING UNITS.

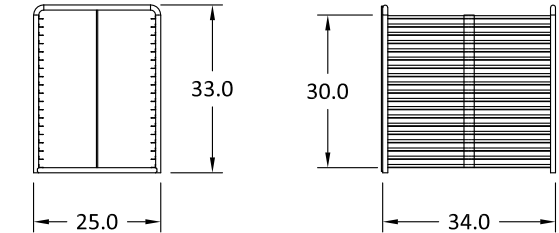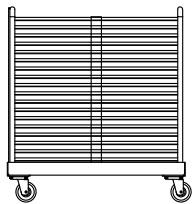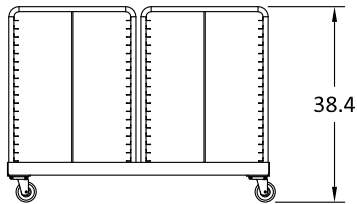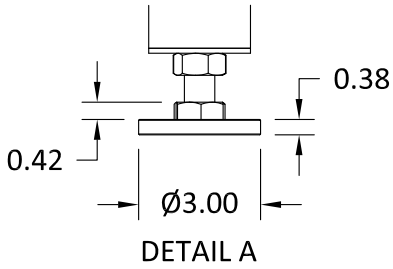

REVISIONS				
ZONE	REV	DESCRIPTION	DATE	REVISED BY
	A	RELEASED FOR APPROVAL	3/14/2025	T. AFFELDT
	B	4X REFRIGERATION CONNECTIONS WAS 2X AND ADDED NOTE 4	4/7/2025	T. AFFELDT

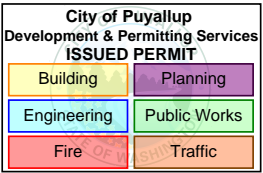

PRMH20250723

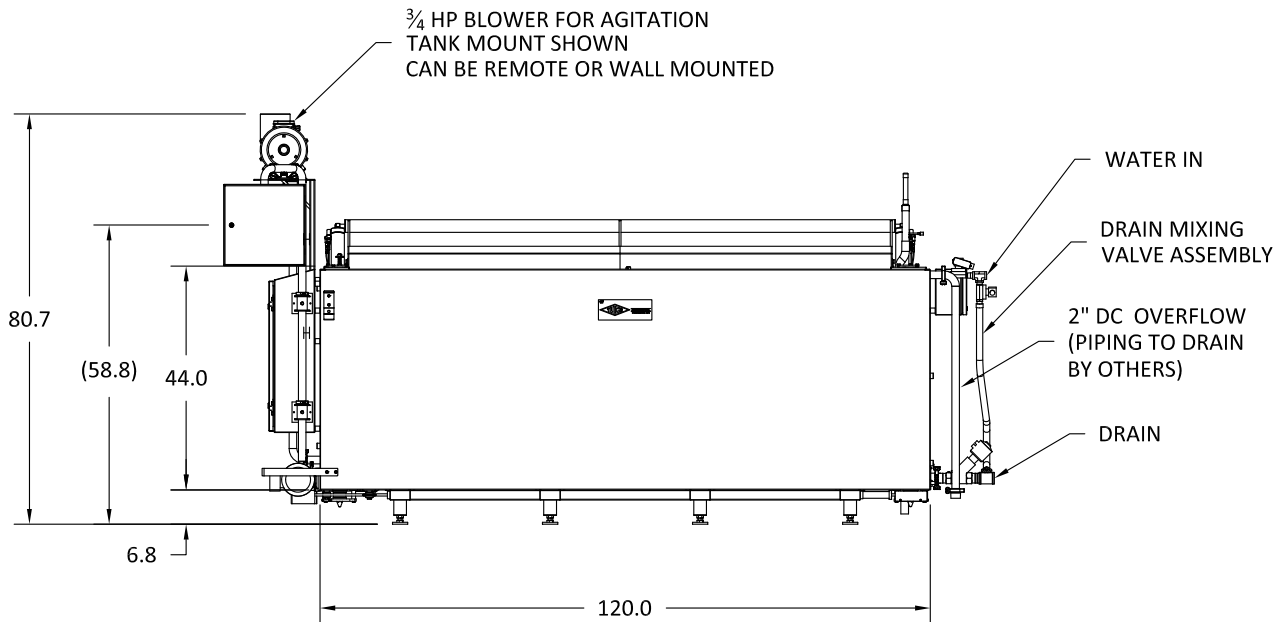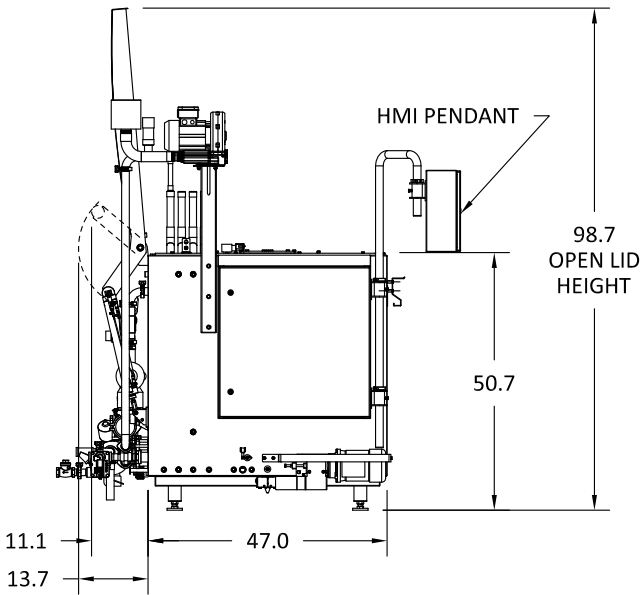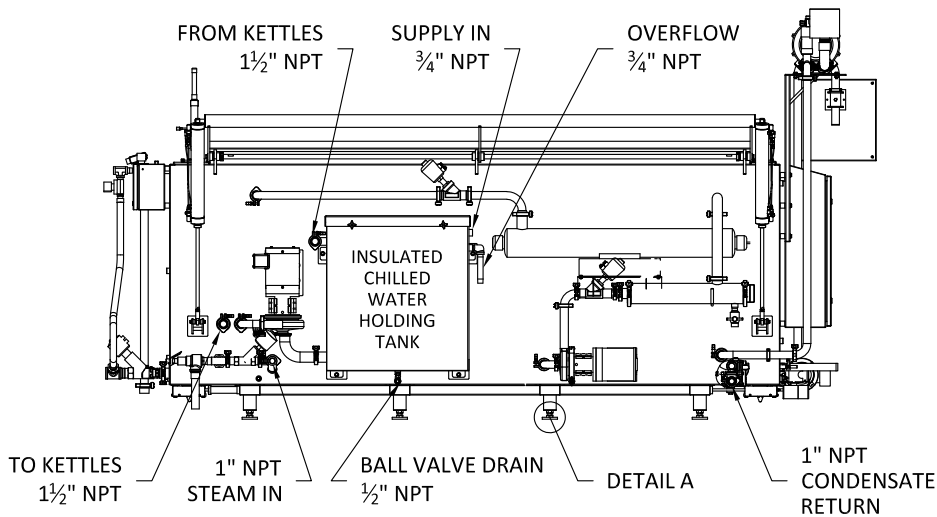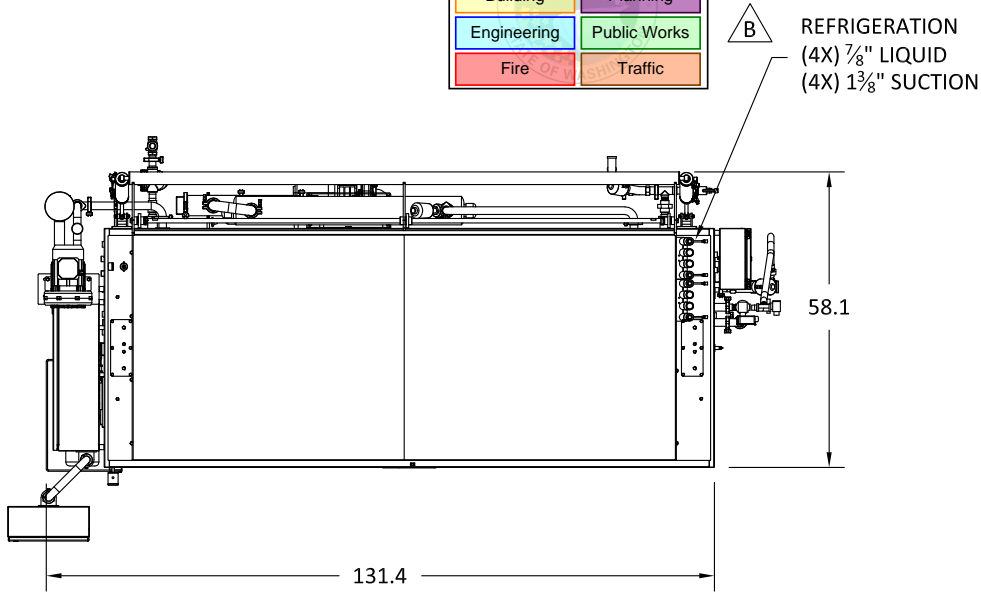

TUCS DRAWING APPROVAL

APPROVED BY: _____ DATE: _____

TUCS EQUIPMENT INC. MUST RECEIVE FINAL APPROVAL OF THIS DRAWING PRIOR TO FABRICATION. APPROVAL OF THIS DRAWING CERTIFIES THAT THE SPECIFIED EQUIPMENT HAS BEEN REVIEWED AND ALL OF THE INFORMATION CONTAINED WITHIN HAS BEEN APPROVED AND ACCEPTED BY PURCHASER

TITLE: PUYALLUP - QUOTE 24092 REV 8

BATCH COOK CHILL TANK, 200 GALLON

DATE: 3/14/2025

DRAWN BY: T. AFFELDT

UNLESS OTHERWISE SPECIFIED:

DIMENSIONS ARE IN INCHES AND ARE USED FOR REFERENCE ONLY.

ON-SITE VERIFICATION MAY BE REQUIRED.

DO NOT SCALE.

MODEL NUMBER

TEBCCT-200-CWUV



REV

B

SHEET: 3 OF 3