

- PROJECT NARRATIVE:**
- THE LIBRARY IS DOING A SMALL CONSTRUCTION PROJECT. ADDING/ADJUSTING DETECTION AND NOTIFICATION DEVICES IN THE AREAS OF CONSTRUCTION TO MEET CODE.
 - MOVING 2 HORN/STROBES
 - INSTALLING 1 NEW HORN/STROBE
 - UPDATING CANDELA SETTING ON 1 EXISTING HORN/STROBE
 - INSTALLING 1 NEW SMOKE DETECTOR
 - CALCS AND VOLTAGE DROP TO BE VERIFIED IN THE FIELD.
 - DEVICES SHOWN OUTSIDE AREA OF WORK ARE APPROXIMATE AND FROM AN OLD "NOT-TO-SCALE" DRAWING
 - REPLACING EXTERIOR BELL WITH NEW BELL AND STROBE
 - REPLACING ALL NOTIFICATION DEVICES & POWER SUPPLY "LIKE FOR LIKE"
 - CURRENTLY THERE ARE ISSUES WITH VOLTAGE DROPS ON EXISTING NACS, NEW DEVICES HAVE LOWER AMP DRAW AND NEW POWER SUPPLY IS RATED TO START AT 24 VOLTS RATHER THAN 20.4
 - EXTENDING EOL ON NAC 3 TO PICK UP THE LAST 8 DEVICES ON NAC 1, NAC 1 WILL NOW END JUST BEFORE NEW TEEN LOUNGE

FIRE ALARM LEGEND							
SYMBOL	EQUIPMENT	MANUFACTURER	PART NUMBER	BACKBOX	RING	MT. HEIGHT	NEW QTY.
	FIRE ALARM CONTROL PANEL (EXISTING)	SIEMENS	FC922	EXISTING	N/A	EXISTING	--
	POWER SUPPLY	SIEMENS	PAD4	PAD-4-ENCL	N/A	AS REQUIRED	1
	HORN/STROBE	SIEMENS	SC-HS-WW-F	4/SQ.	1-GANG	80" TO BOTTOM	46
	SMOKE DETECTOR	SIEMENS	OP921/DB-11	4/SQ.	1-GANG	CEILING	1
	BELL	SIEMENS	MBDC-10	WBBS-R	N/A	90" TO BOTTOM	1
	STROBE (WEATHERPROOF) - RED	SIEMENS	SL24XST-FR	INCLUDED	N/A	90" TO BOTTOM	1

SHEET INDEX	
FA2.1	LEGENDS & 2nd FLOOR - FIRE ALARM PLAN
FA2.0	FIRST FLOOR - FIRE ALARM PLAN

City of Puyallup
Fire
REVIEWED
FOR
COMPLIANCE

D Drake
07/09/2025
10:47:59 AM




 
THE APPROVED CONSTRUCTION PLANS AND ALL ENGINEERING MUST BE POSTED ON THE JOB AT ALL INSPECTIONS IN A VISIBLE AND READILY ACCESSIBLE LOCATION.

Approval of submitted plans is not an approval of omissions or oversight by this office or noncompliance with any applicable regulations of local government. The contractor is responsible for making sure that the building complies with all applicable building codes and regulations of the local government.

City of Puyallup
Development & Permitting Services
ISSUED PERMIT

Building	Planning
Engineering	Public Works
Fire	Traffic

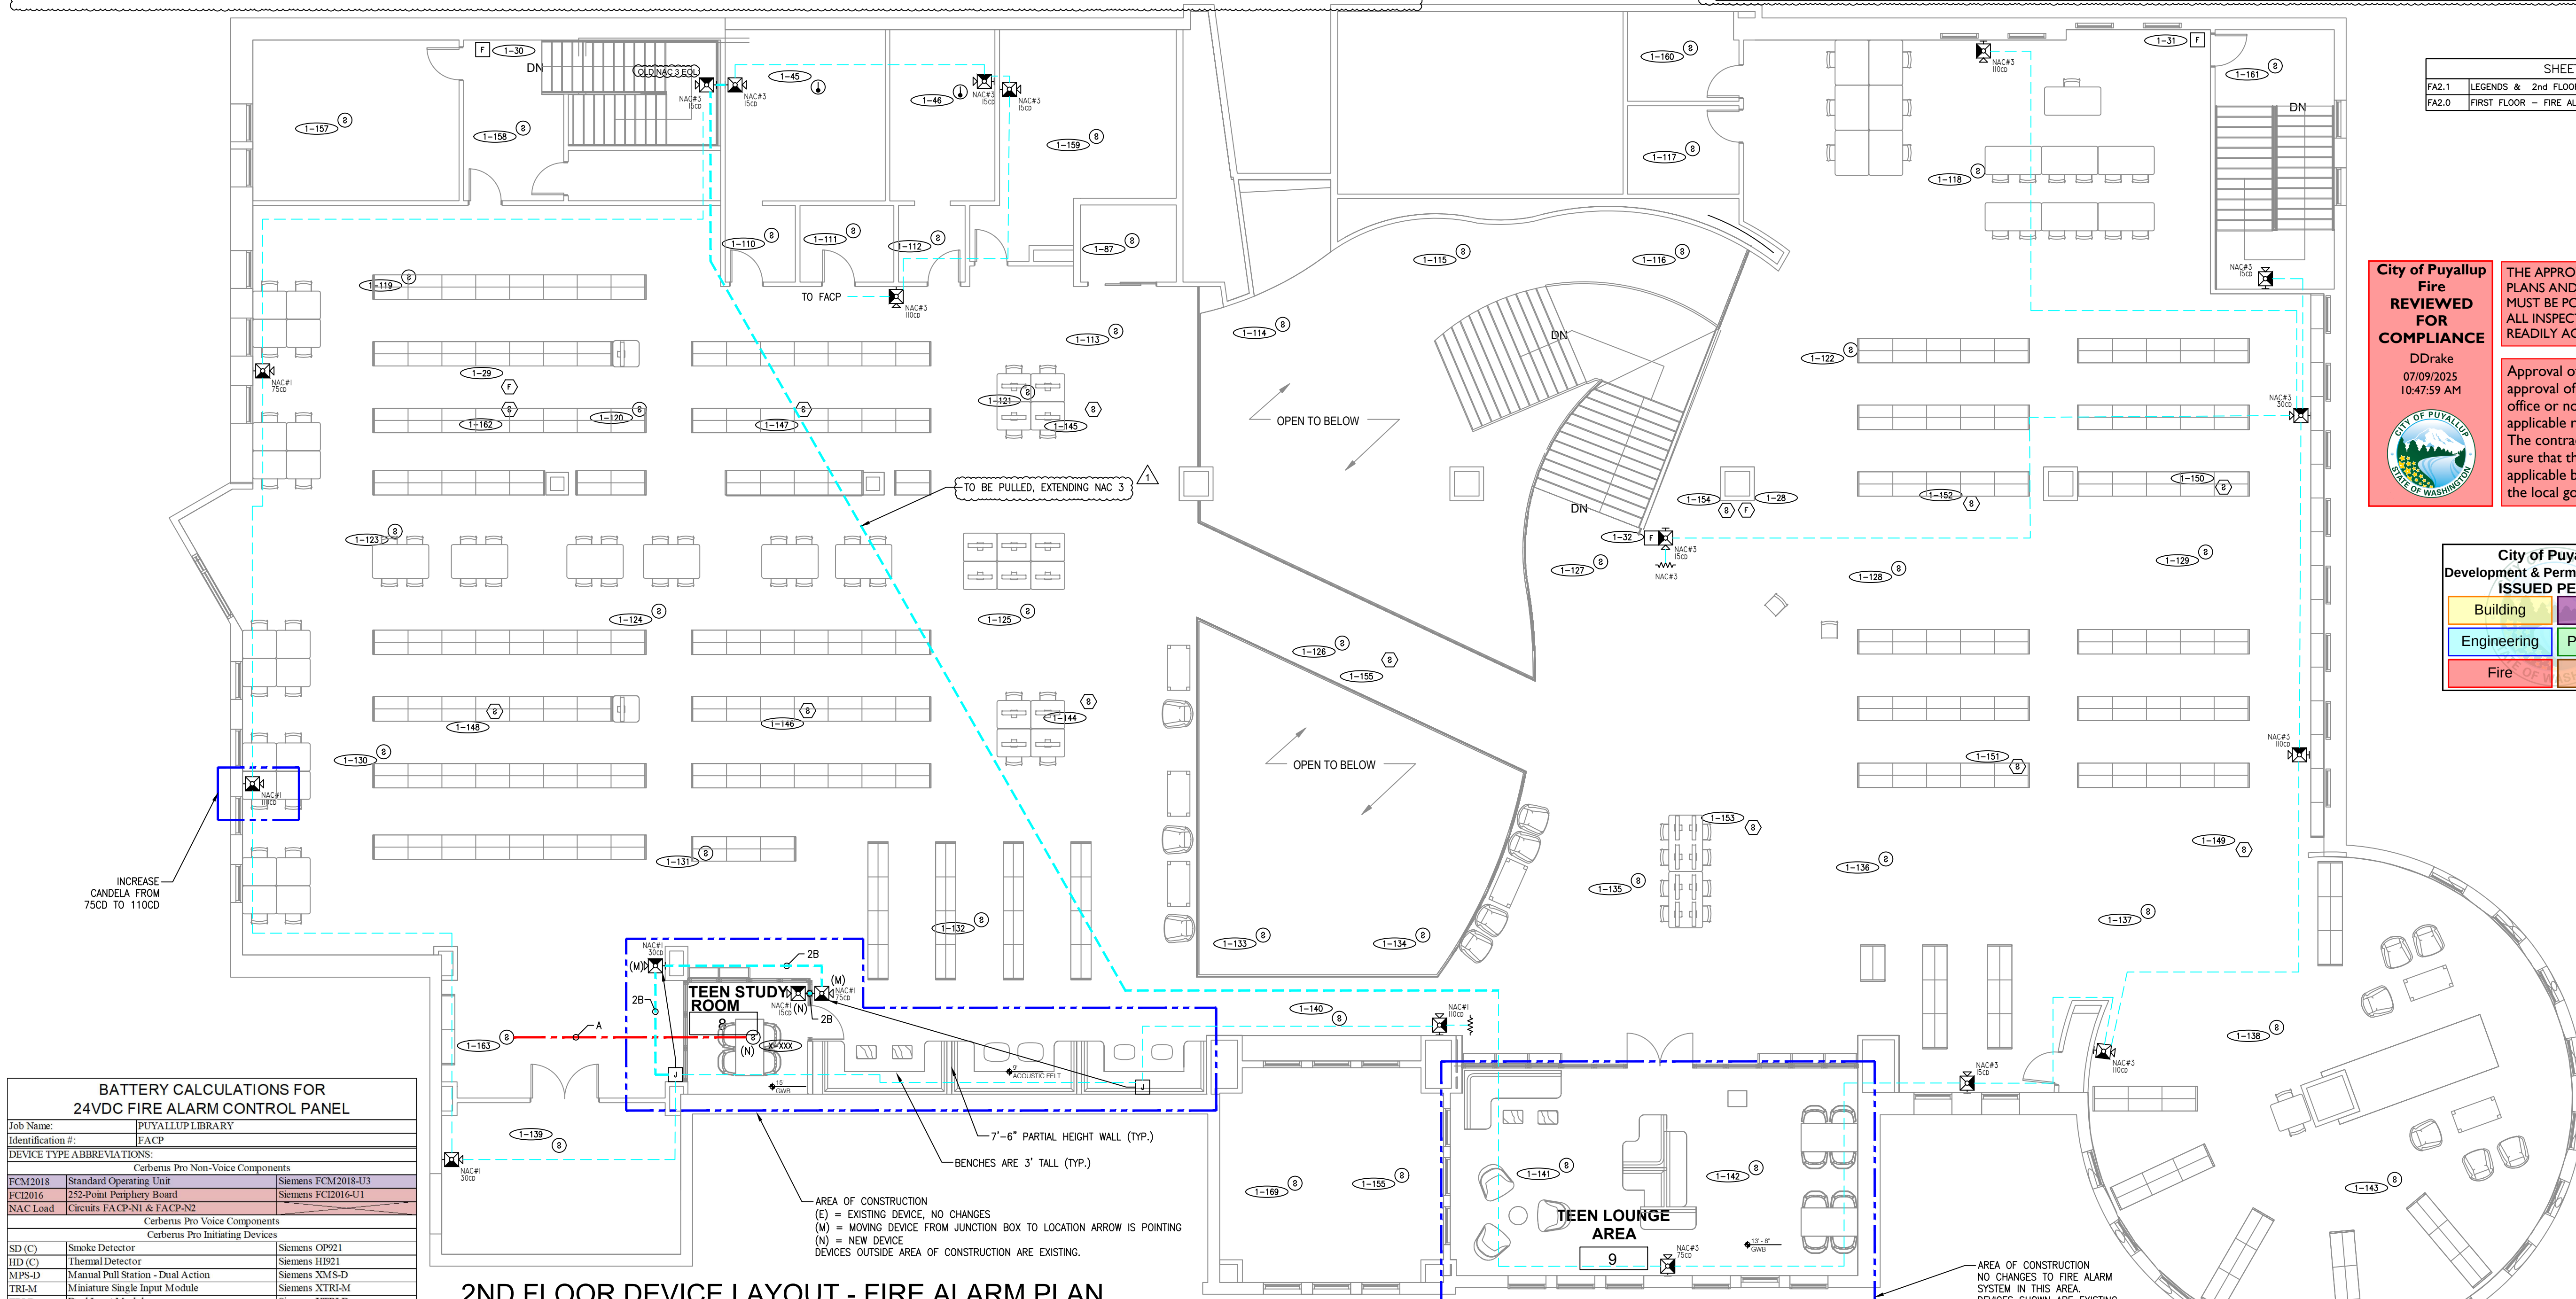


[illegible]

Sheet Title:

MAIN FLOOR DEVICE LAYOUT -
FIRE ALARM PLAN

FA2.0

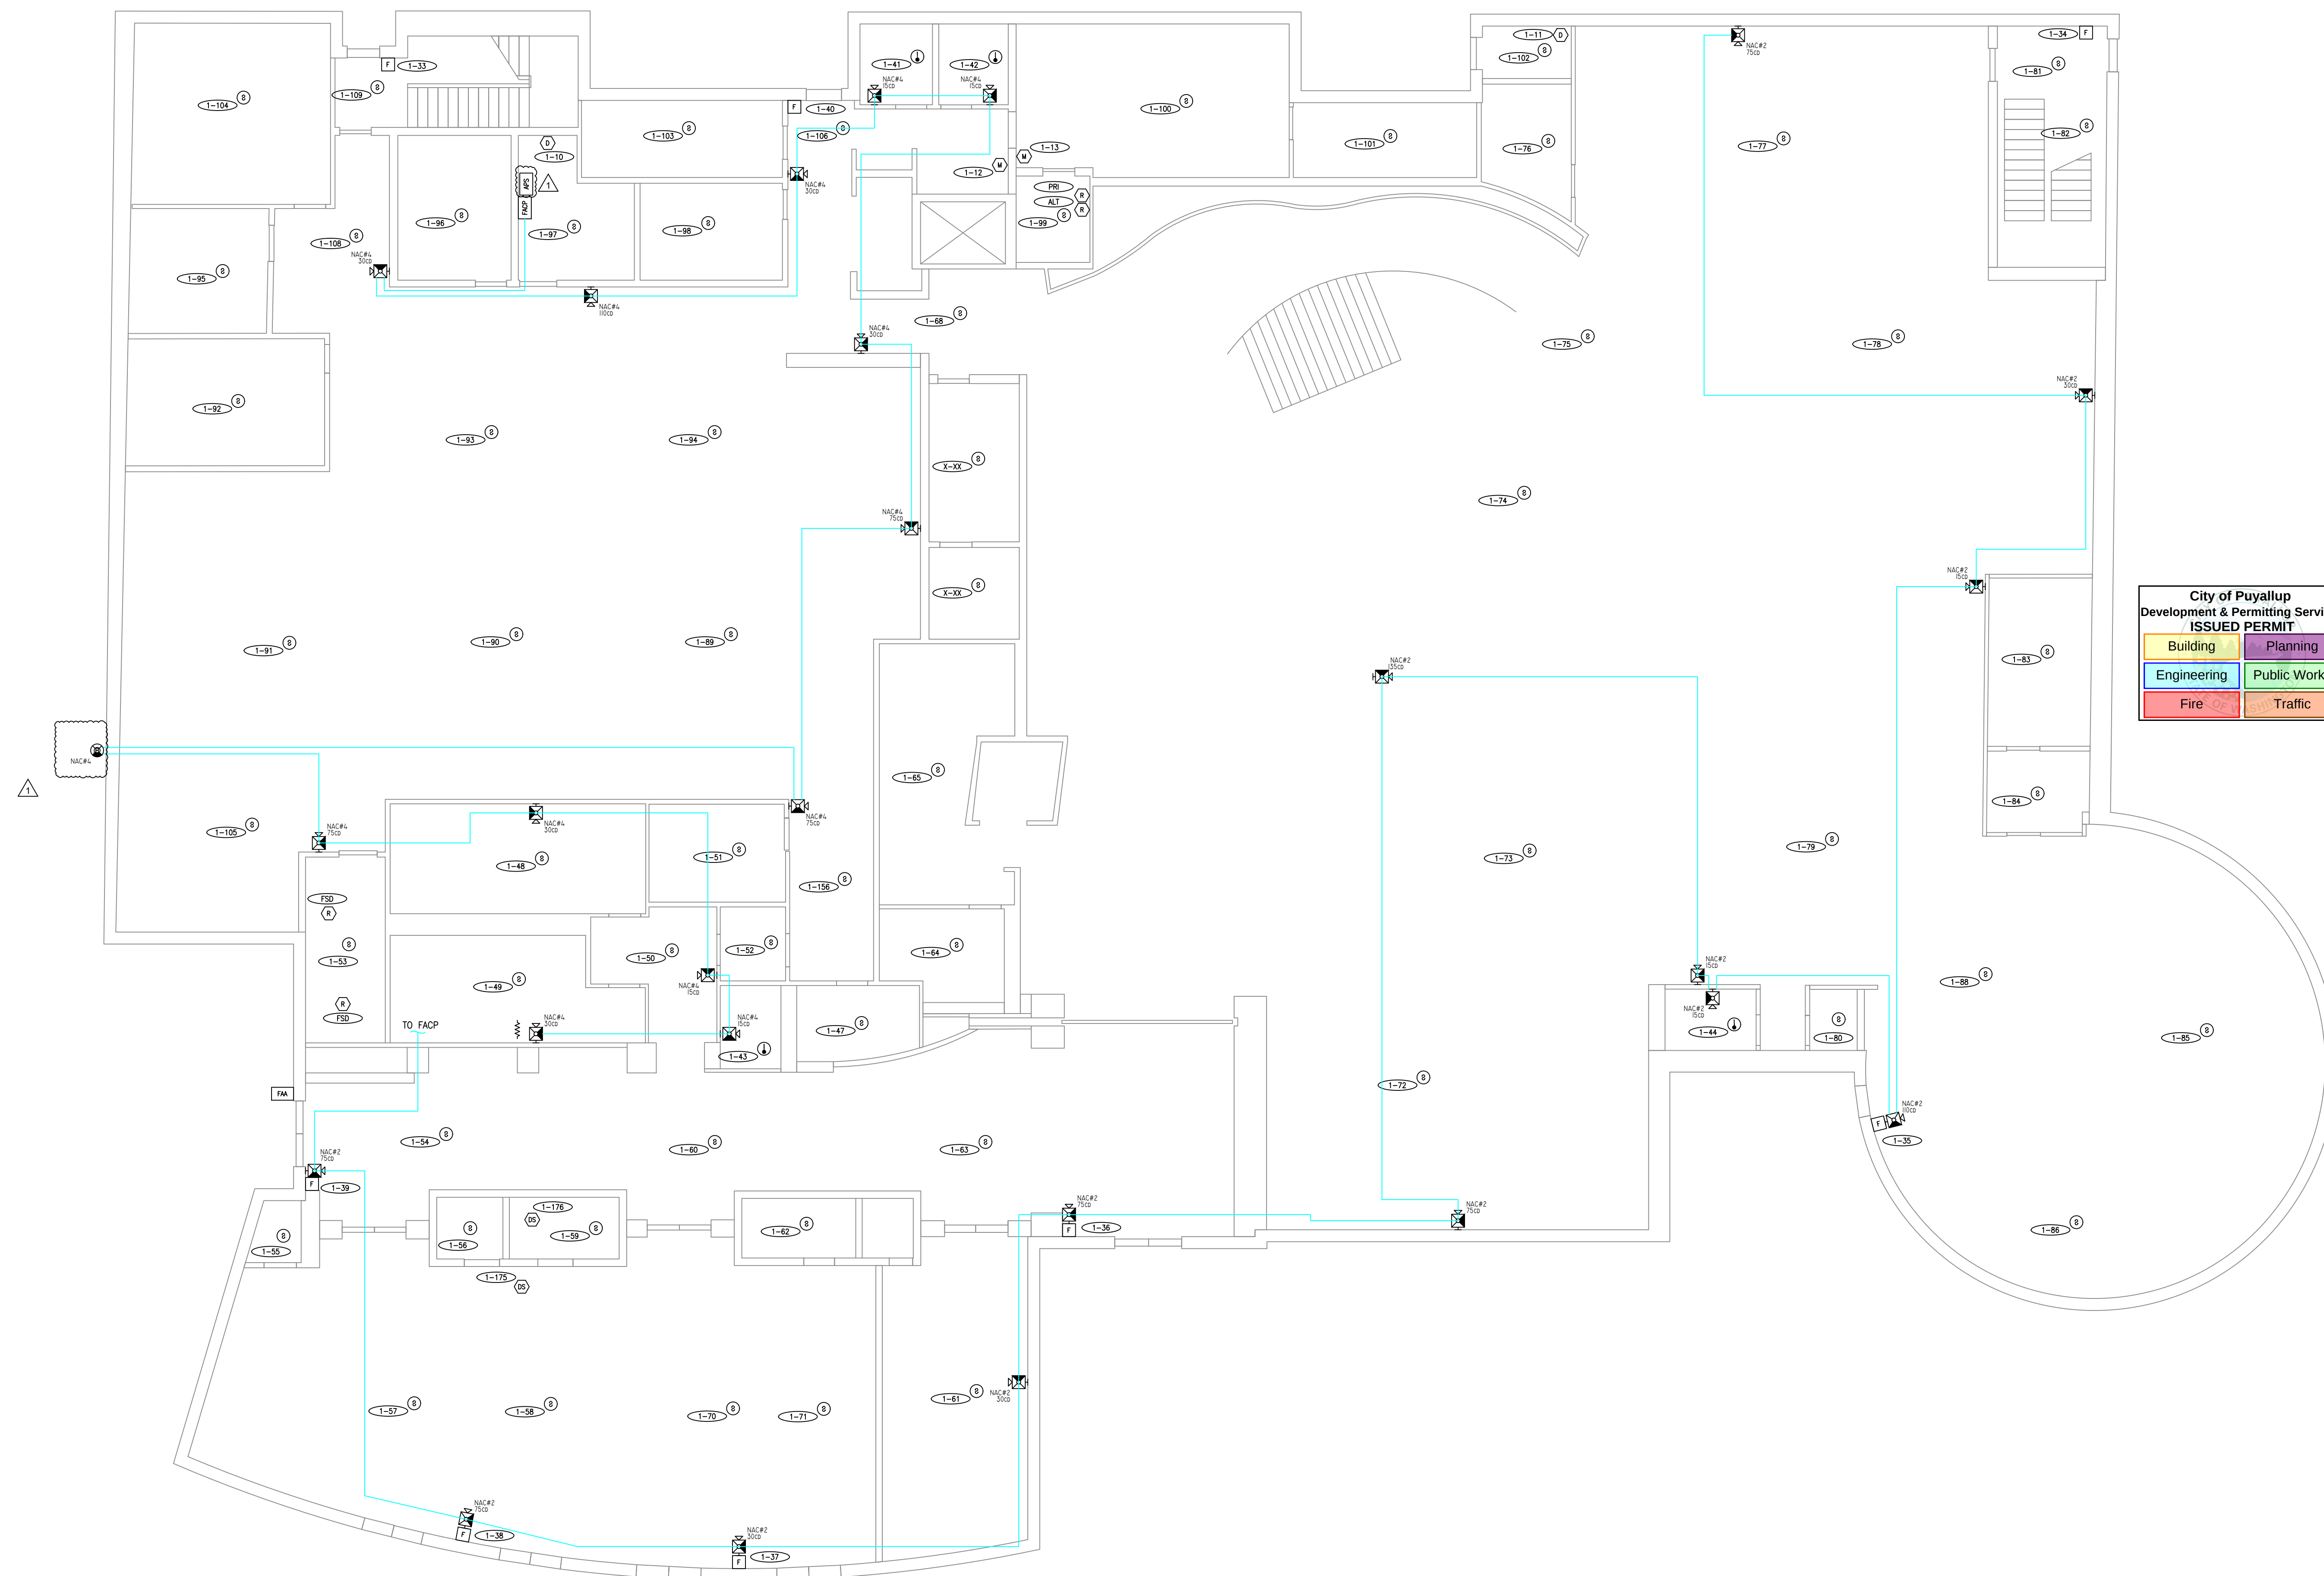

MAIN FLOOR DEVICE LAYOUT - FIRE ALARM PLAN