


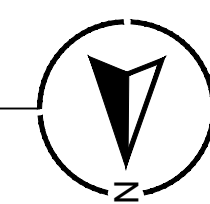

1 FIRST FLOOR PLAN



EQUIPMENT LIST	
SYMBOL	DESCRIPTION
[FACU]	FIRE ALARM CONTROL PANEL
[DOC]	FIRE ALARM DOCUMENT CABINET
[NAC]	10A CONVENTIONAL POWER SUPPLY
[CELL]	COMMUNICATOR
[ADM]	ADDRESSABLE DUAL MONITOR MODULE
[H]	ADDRESSABLE HEAT DETECTOR WITH STANDARD BASE
[S]	ADDRESSABLE SMOKE DETECTOR WITH STANDARD BASE
[F] WP	CONVENTIONAL PULL STATION, WEATHERPROOF
[WP]	HORN STROBE, WALL, RED, WEATHERPROOF
[F] LF	LOW FREQUENCY HORN, WALL, WHITE
[LF]	LOW FREQUENCY HORN/STROBE, WALL, WHITE, 177 FIXED CANDELA
[STROBE]	STROBE, WALL, WHITE
[JB]	JUNCTION BOX
KEY NOTES	
1	JUNCTION BOXES IN BATHROOMS ARE FOR FUTURE ADA ADAPTABILITY.

Jeremy Locken, ET
NICET Level III Fire Alarm
Certification #: 95603
Expires 07/2027




PROJECT
EAST TOWN CROSSING BUILDING F
SHAW RD. E. & PIONEER WY. E.
PUYALLUP, WA 98372

REVISION:
FIRST RELEASE


SHEET DESCRIPTION:
FIRE ALARM SYSTEM
FIRST FLOOR PLAN

DRAWN BY: JEM SYSTEMS
DATE: 06.13.2025
SCALE: SEE DRAWINGS

SHEET:
FA-01 OF 04

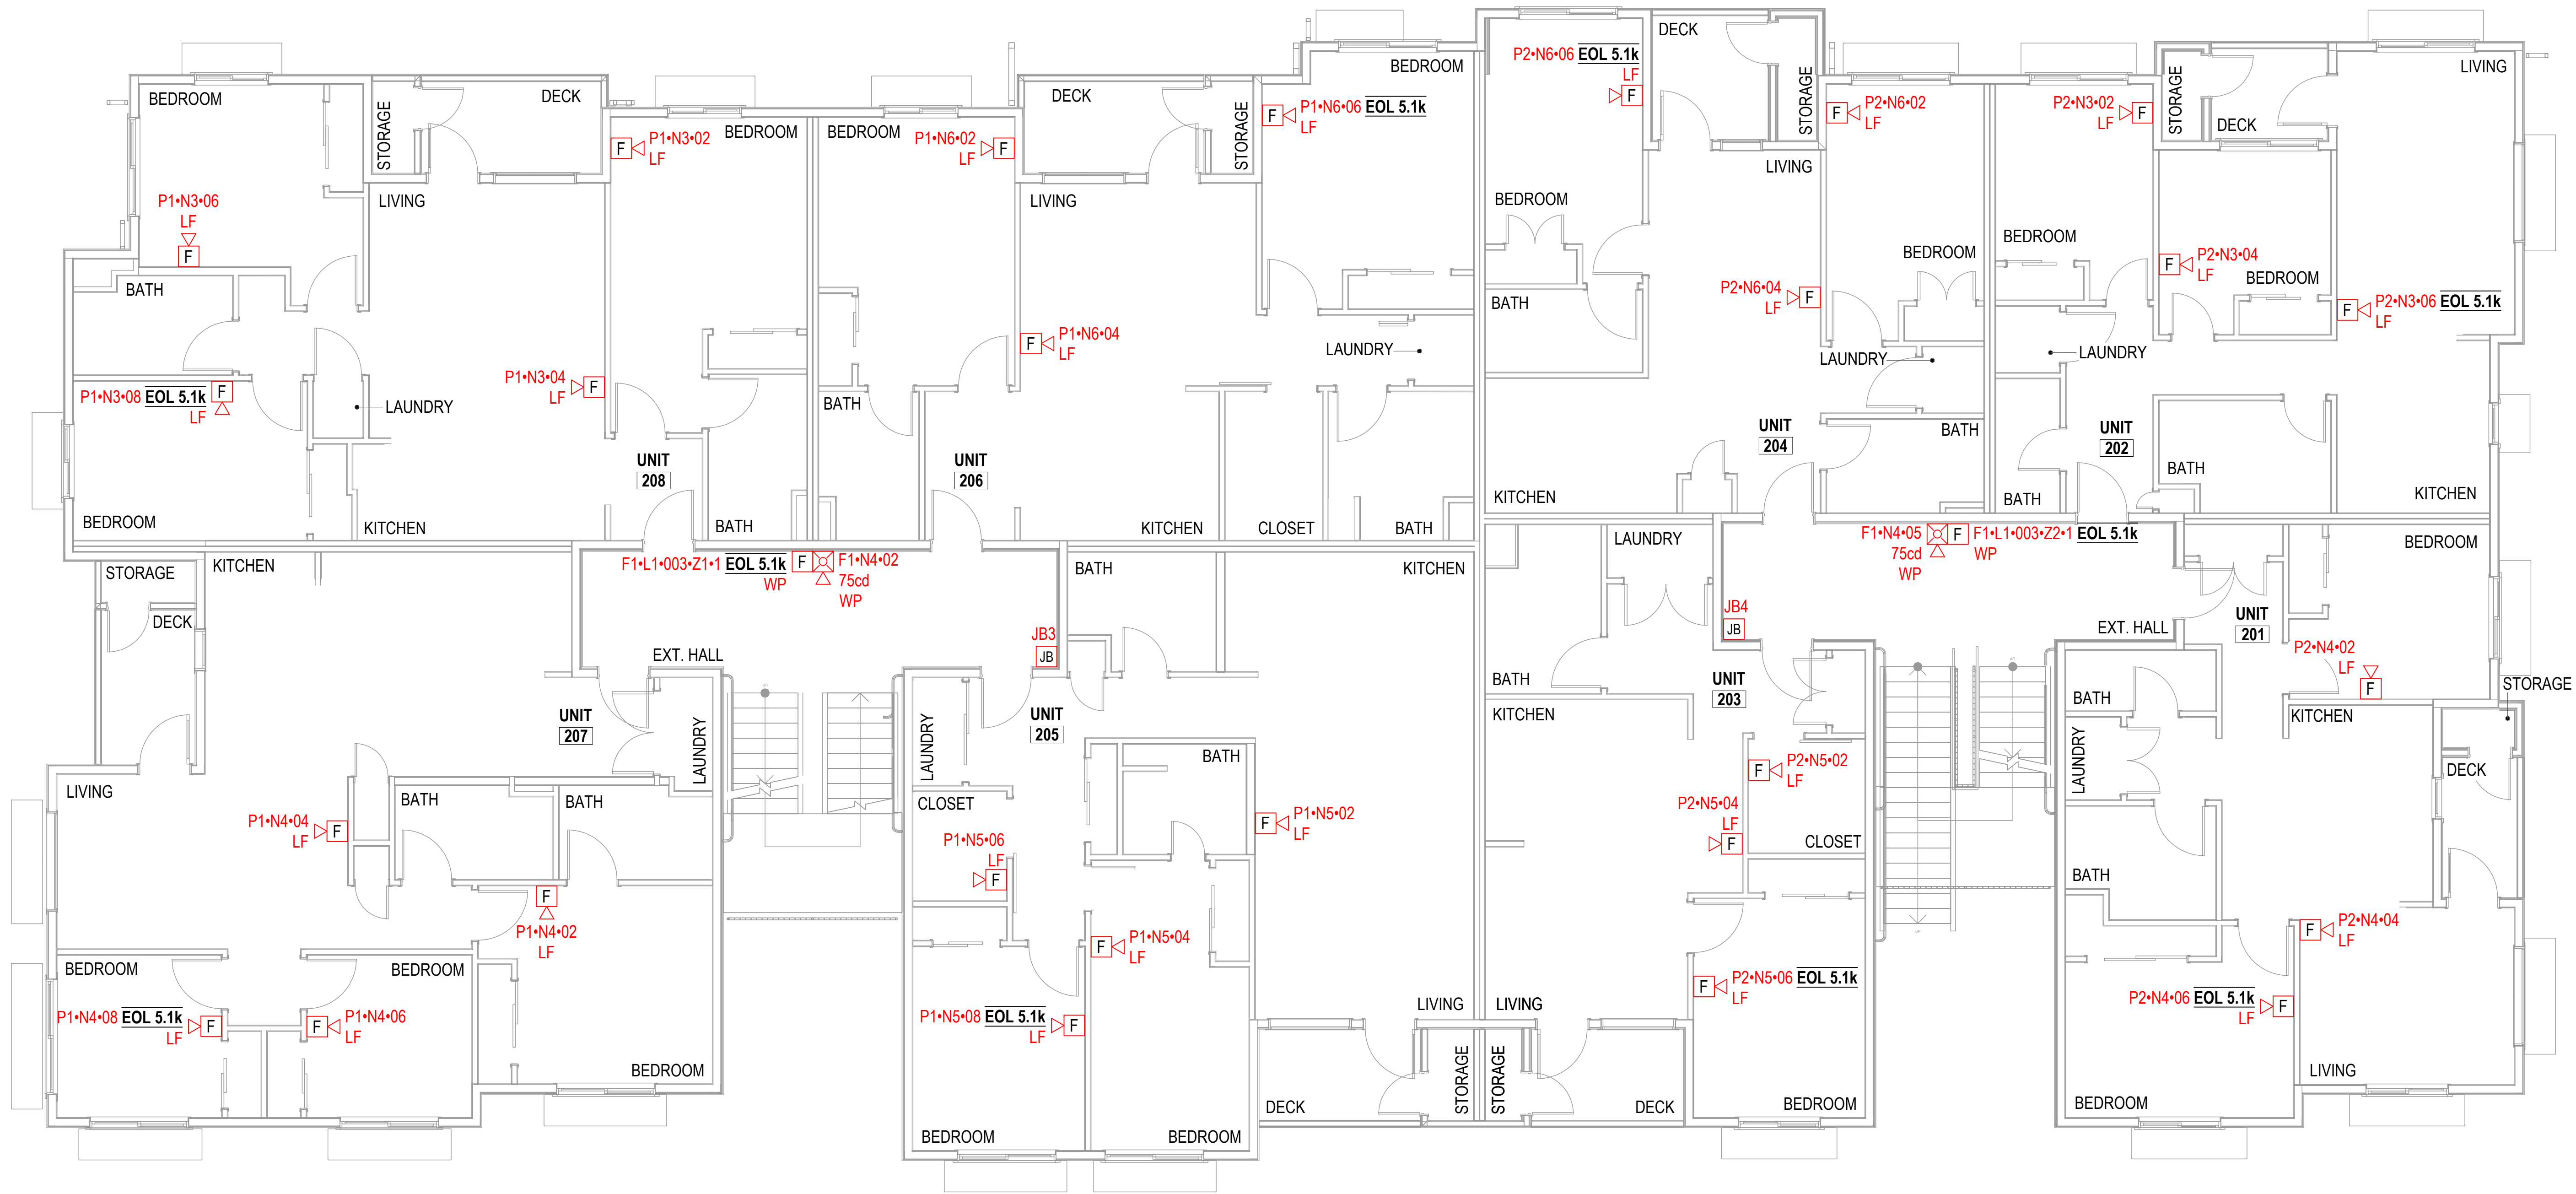

2 SECOND FLOOR PLAN

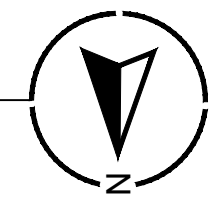

EQUIPMENT LIST	
SYMBOL	DESCRIPTION
[FACU]	FIRE ALARM CONTROL PANEL
[DOC]	FIRE ALARM DOCUMENT CABINET
[NAC]	10A CONVENTIONAL POWER SUPPLY
[CELL]	COMMUNICATOR
[ADM]	ADDRESSABLE DUAL MONITOR MODULE
[H]	ADDRESSABLE HEAT DETECTOR WITH STANDARD BASE
[S]	ADDRESSABLE SMOKE DETECTOR WITH STANDARD BASE
[F WP]	CONVENTIONAL PULL STATION, WEATHERPROOF
[WP]	HORN STROBE, WALL, RED, WEATHERPROOF
[LF]	LOW FREQUENCY HORN, WALL, WHITE
[LF]	LOW FREQUENCY HORN/STROBE, WALL, WHITE, 177 FIXED CANDELA
[WP]	STROBE, WALL, WHITE
[JB]	JUNCTION BOX
KEY NOTES	
1	JUNCTION BOXES IN BATHROOMS ARE FOR FUTURE ADA ADAPTABILITY.

Jeremy Locken, ET
NICET Level III Fire Alarm
Certification #: 95603
Expires 07/2027

MAX POWER
FIRE SYSTEM INSTALLATION

PROJECT

EAST TOWN CROSSING BUILDING F
SHAW RD. E. & PIONEER WY. E.
PUYALLUP, WA 98372

REVISION:

FIRST RELEASE

△

△

△

△

SHEET DESCRIPTION:

FIRE ALARM SYSTEM
SECOND FLOOR PLAN

DRAWN BY: JEM SYSTEMS

DATE: 06.13.2025


SCALE: SEE DRAWINGS

SHEET:

FA-02 OF 04



1 THIRD FLOOR PLAN

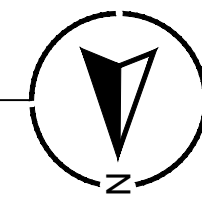

EQUIPMENT LIST	
SYMBOL	DESCRIPTION
[FACU]	FIRE ALARM CONTROL PANEL
[DOC]	FIRE ALARM DOCUMENT CABINET
[NAC]	10A CONVENTIONAL POWER SUPPLY
[CELL]	COMMUNICATOR
[ADM]	ADDRESSABLE DUAL MONITOR MODULE
[H]	ADDRESSABLE HEAT DETECTOR WITH STANDARD BASE
[S]	ADDRESSABLE SMOKE DETECTOR WITH STANDARD BASE
[F] WP	CONVENTIONAL PULL STATION, WEATHERPROOF
[WP]	HORN STROBE, WALL, RED, WEATHERPROOF
[F] LF	LOW FREQUENCY HORN, WALL, WHITE
[LF]	LOW FREQUENCY HORN/STROBE, WALL, WHITE, 177 FIXED CANDELA
[WP]	STROBE, WALL, WHITE
[JB]	JUNCTION BOX
KEY NOTES	
1	JUNCTION BOXES IN BATHROOMS ARE FOR FUTURE ADA ADAPTABILITY.

Jeremy Locken, ET
NICET Level III Fire Alarm
Certification #: 95603
Expires 07/2027

MAX POWER
FIRE SYSTEM INSTALLATION

PROJECT

EAST TOWN CROSSING BUILDING F
SHAW RD. E. & PIONEER WY. E.
PUYALLUP, WA 98372

REVISION:

FIRST RELEASE

SHEET DESCRIPTION:

FIRE ALARM SYSTEM
THIRD FLOOR PLAN


DRAWN BY: JEM SYSTEMS

DATE: 06.13.2025


SCALE: SEE DRAWINGS

SHEET:

FA-03 OF 04

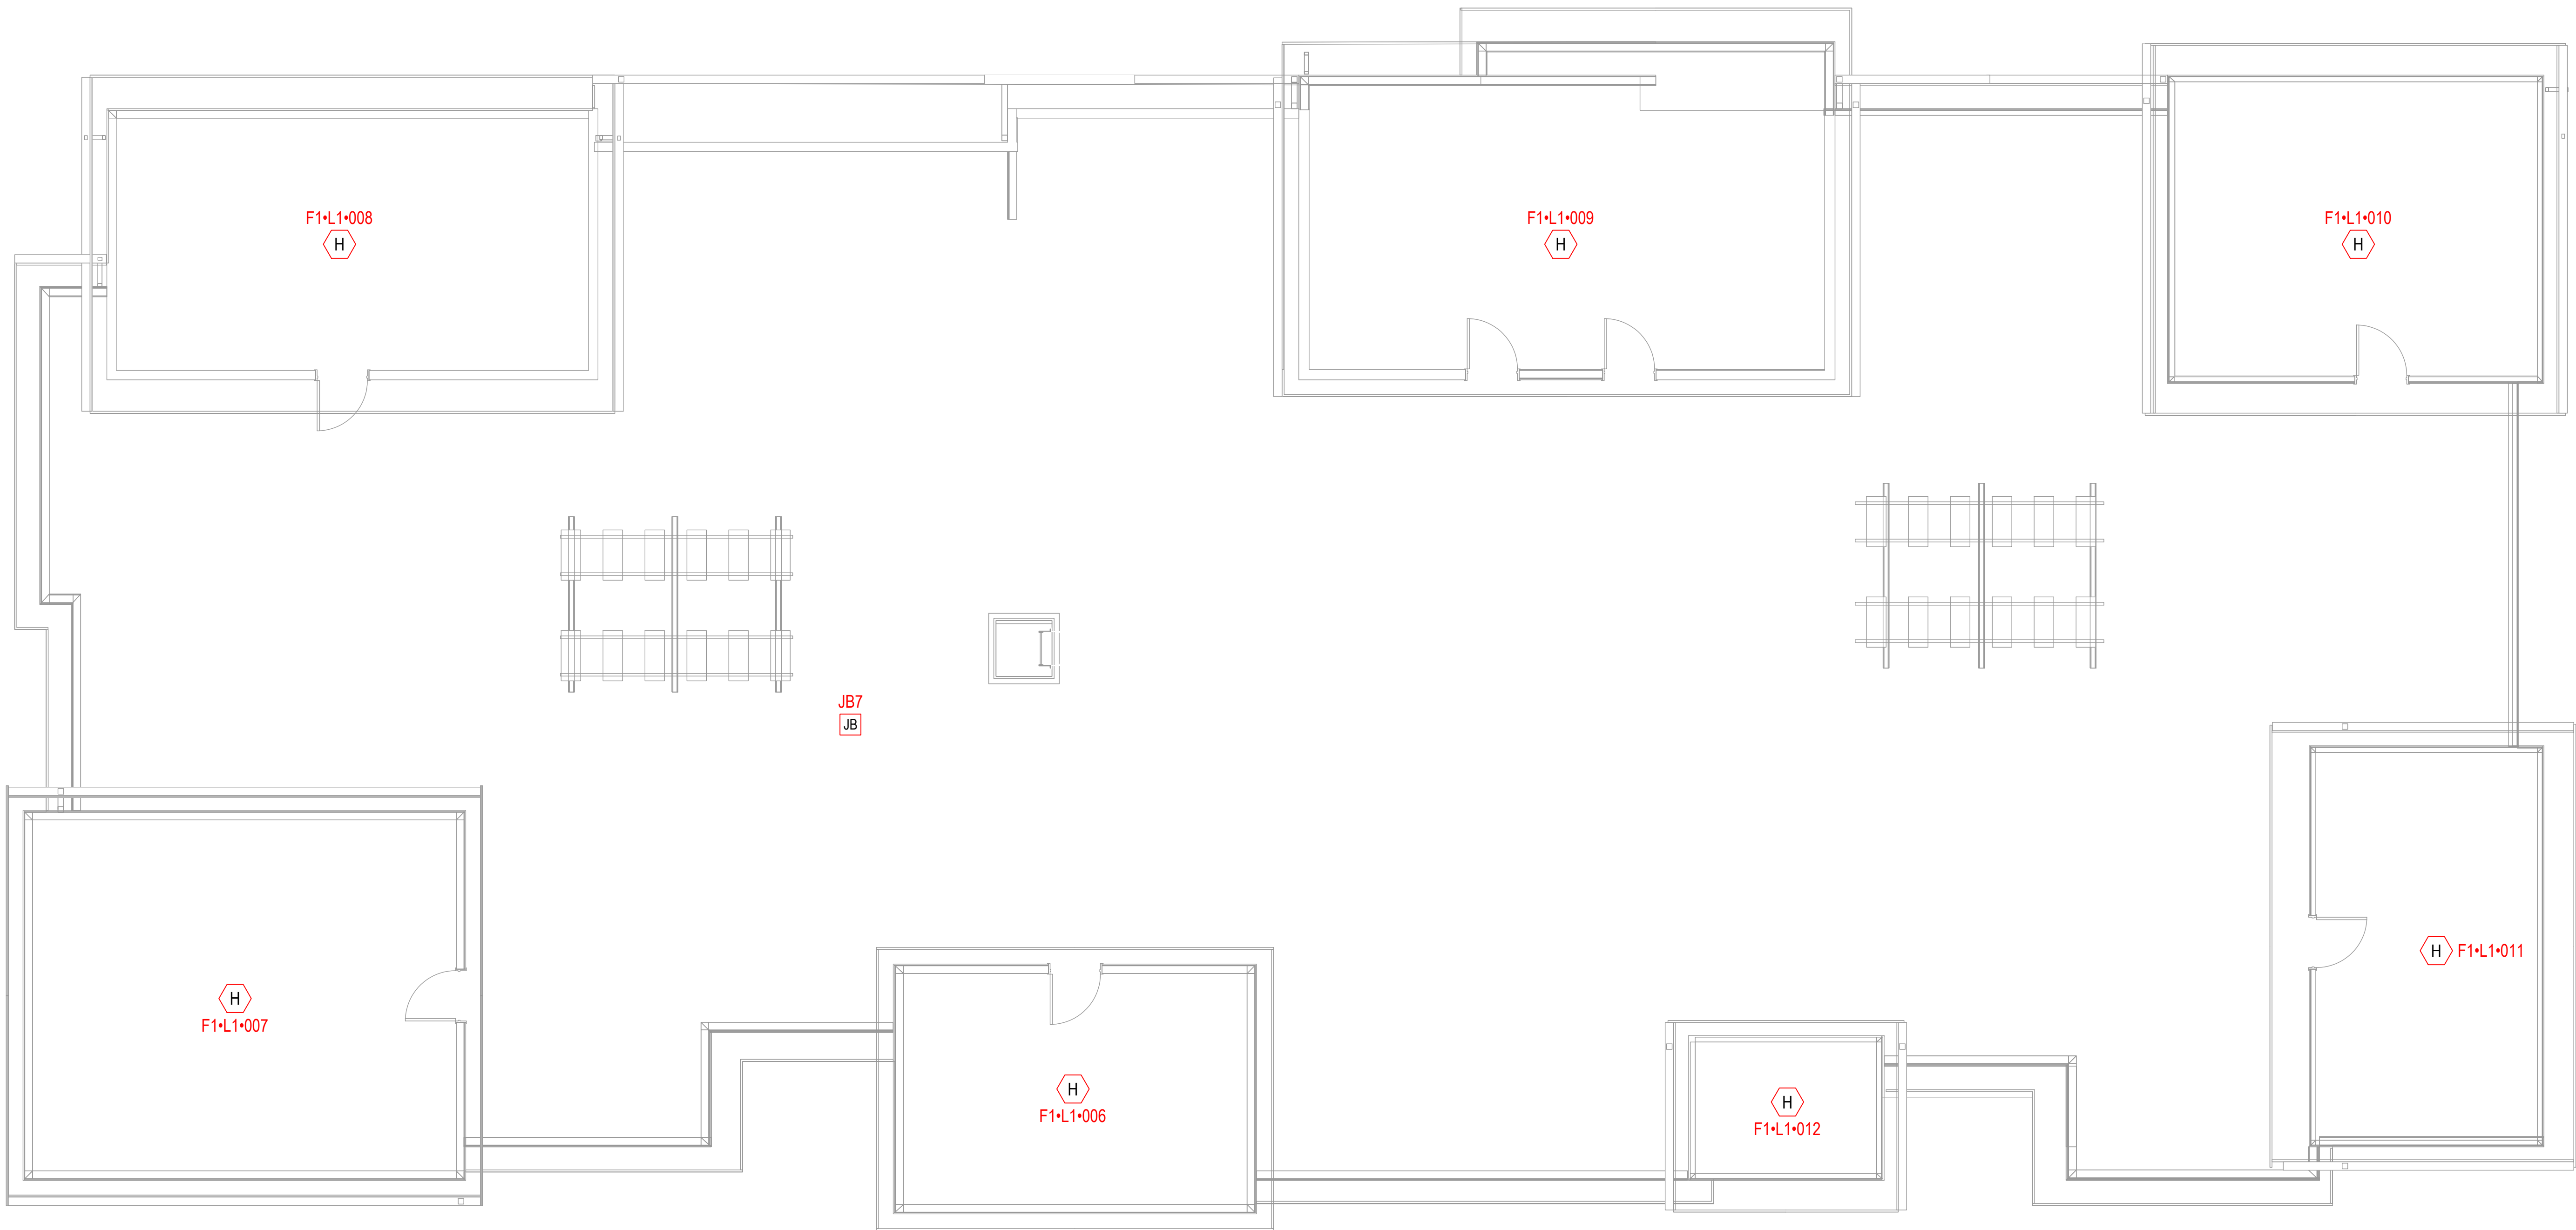

2 ROOF PLAN
0 1' 5' 10'
3/16" = 1'-0"

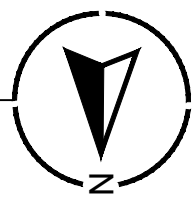

EQUIPMENT LIST	
SYMBOL	DESCRIPTION
	FIRE ALARM CONTROL PANEL
	FIRE ALARM DOCUMENT CABINET
	10A CONVENTIONAL POWER SUPPLY
	COMMUNICATOR
	ADDRESSABLE DUAL MONITOR MODULE
	ADDRESSABLE HEAT DETECTOR WITH STANDARD BASE
	ADDRESSABLE SMOKE DETECTOR WITH STANDARD BASE
	CONVENTIONAL PULL STATION, WEATHERPROOF
	HORN STROBE, WALL, RED, WEATHERPROOF
	LOW FREQUENCY HORN, WALL, WHITE
	LOW FREQUENCY HORN/STROBE, WALL, WHITE, 177 FIXED CANDELA
	STROBE, WALL, WHITE
	JUNCTION BOX
KEY NOTES	
	JUNCTION BOXES IN BATHROOMS ARE FOR FUTURE ADA ADAPTABILITY.

Jeremy Locken, ET
Jeremy Locken
NICET Level III Fire Alarm
Certification #: 95603
Expires 07/2027

MAX POWER
FIRE SYSTEM INSTALLATION

PROJECT

EAST TOWN CROSSING BUILDING F
SHAW RD. E. & PIONEER WY. E.
PUYALLUP, WA 98372

REVISION:

FIRST RELEASE

SHEET DESCRIPTION:

FIRE ALARM SYSTEM
ROOF PLAN

DRAWN BY: JEM SYSTEMS

DATE: 06.13.2025

SCALE: SEE DRAWINGS

SHEET:

FA-04 OF 04