



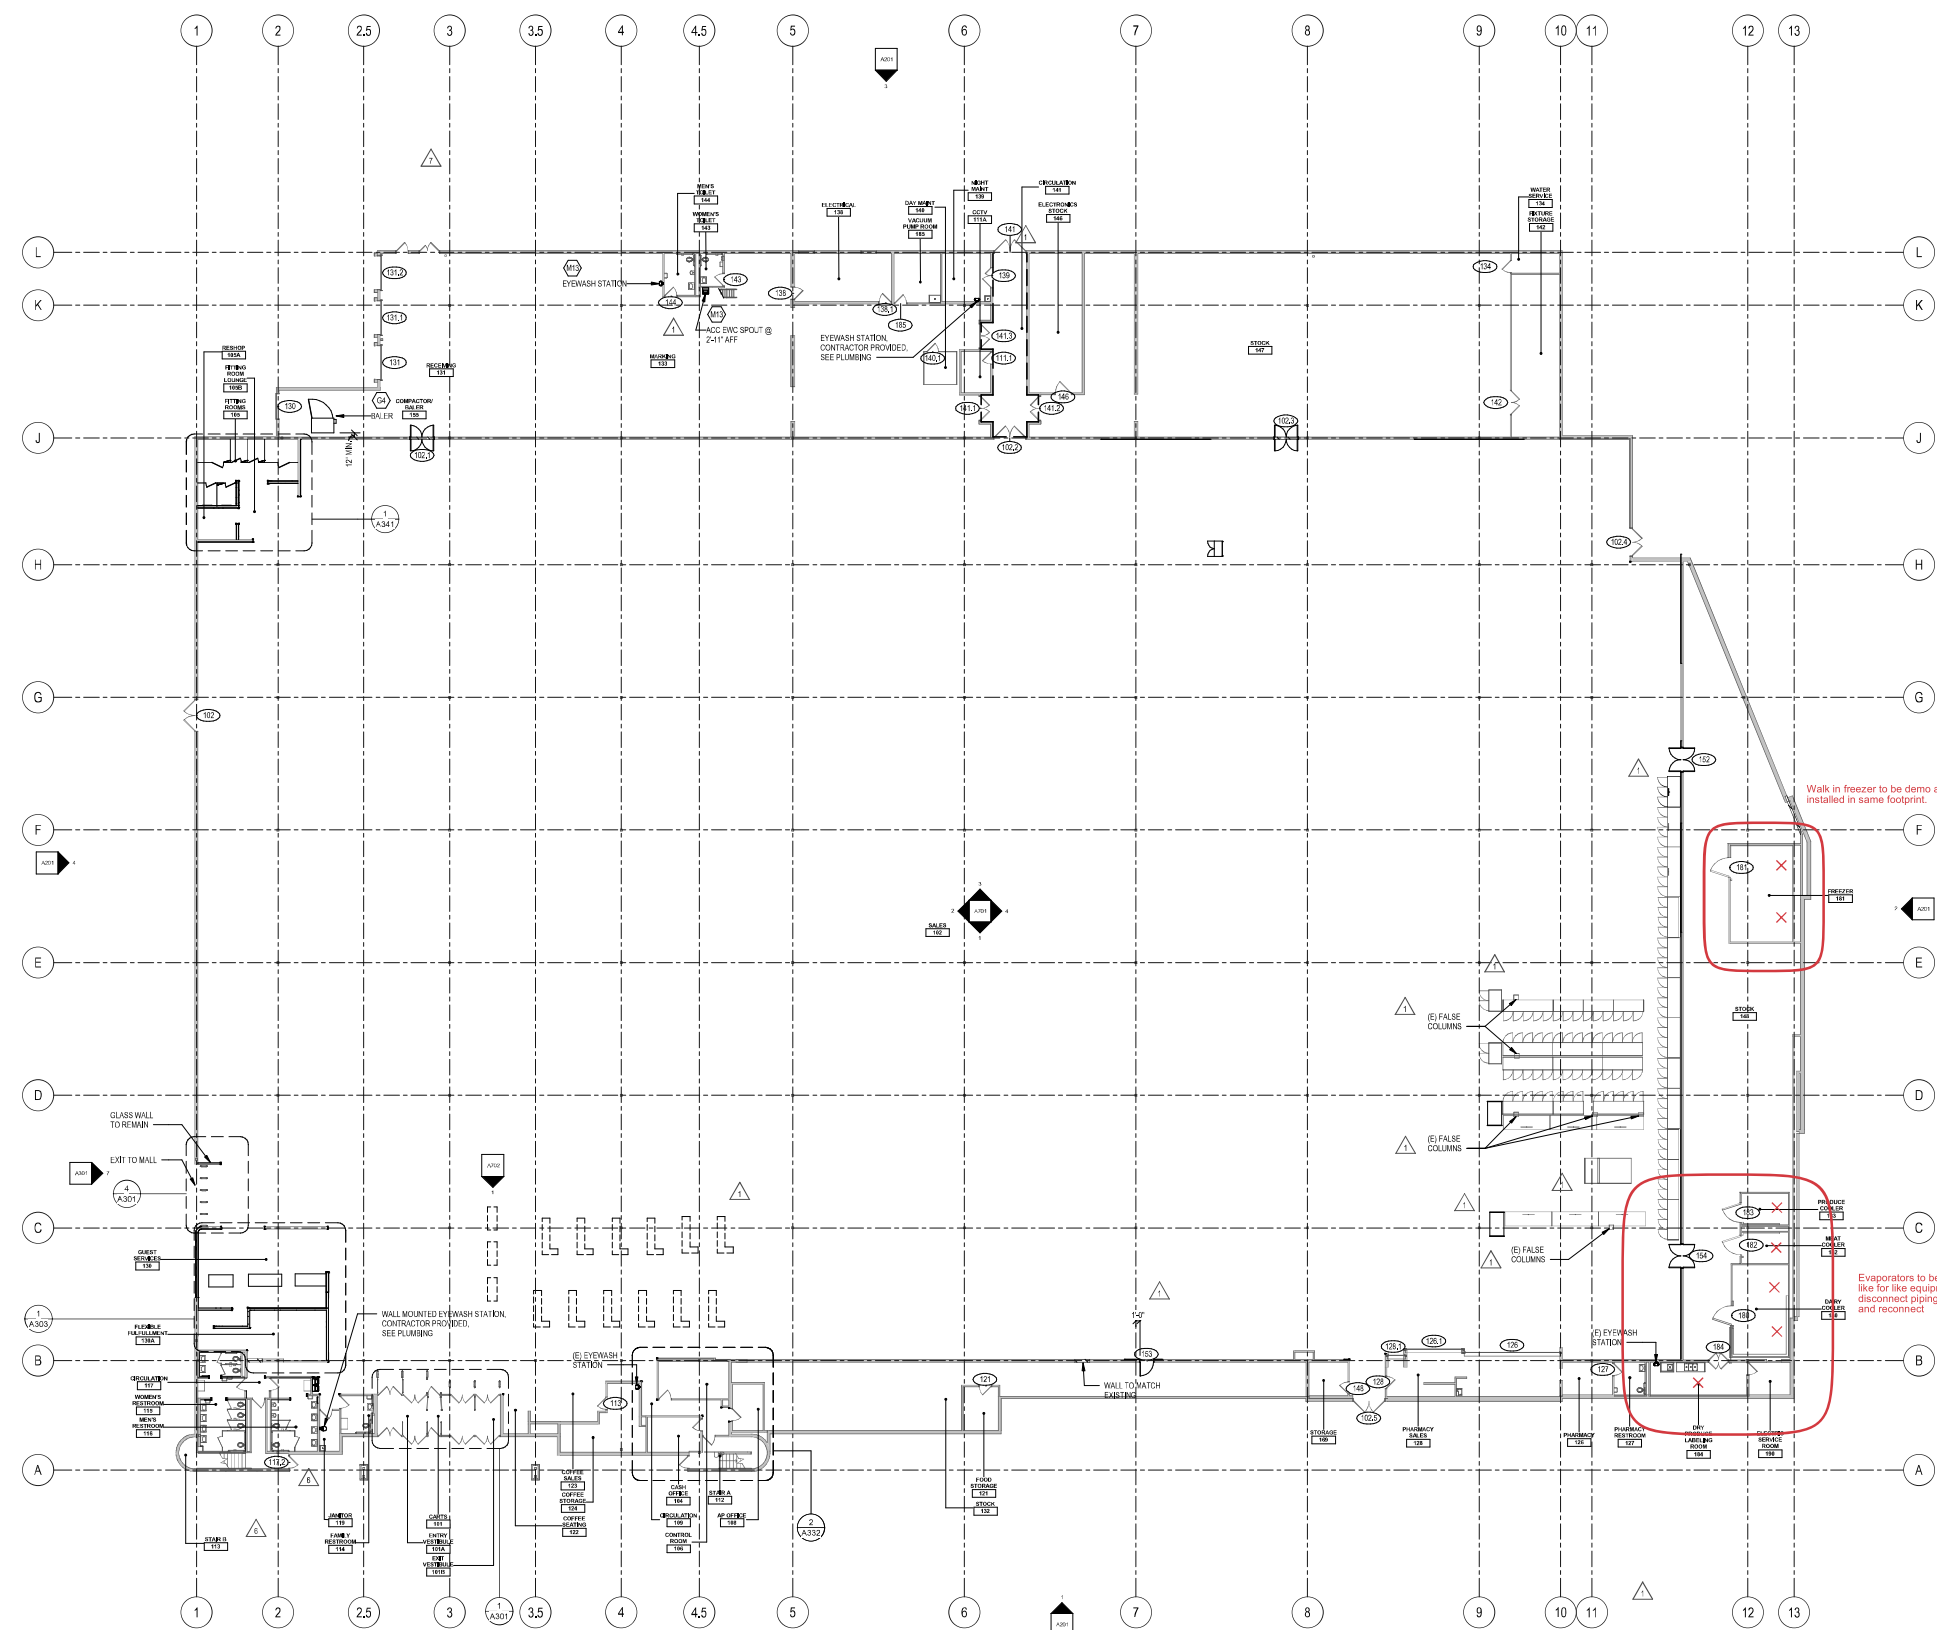

1 FLOOR PLAN
A111 SCALE: 1/16" = 1'-0"

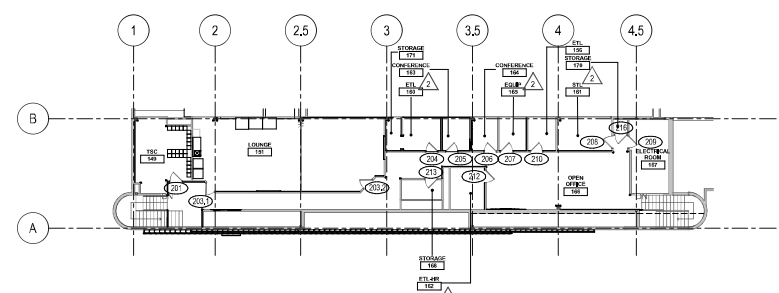

2 MEZZANINE FLOOR PLAN
A111 SCALE: 1/16" = 1'-0"

WALL LEGEND

- (E) WALLS TO REMAIN
- NEW WALLS
- 1-HOUR RATED WALL

FLOOR PLAN NOTES

A. SEE SHEET A001 FOR SYMBOLS

B. ALL DIMENSIONS ARE TO FINISH MATLS OR OPENINGS UNLESS OTHERWISE NOTED

C. FOR DOOR, ROOM FINISH, AND OWNER SUPPLIED MATL. A TYPICAL CONNECTION OF INTERIOR PARTITIONS TO EXTERIOR WALLS - SEE (1) A301 TYP

D. PARTITION TYPES INDICATE LOCATION FOR BLOCKING, FINISHES, ETC. SEE SHEET A001 FOR PARTITION TYPES

E. PLYWOOD BLOCKING IS INCLUDED IN PARTITION TYPE. SEE BLOCKING PLAN FOR SIZE OF WALL

F. FOR TYPICAL CONNECTION OF INTERIOR PARTITIONS TO EXTERIOR WALLS - SEE (1) A301 TYP


G. FOR PARTIAL HEIGHT PARTITION BRACING AND FLOOR ATTACHMENT DETAILS - SEE (1) A301 TYP

H. ALL ANGLES ARE 45° OR MULTIPLES OF 45° UNLESS NOTED OTHERWISE

I. FOR STUD WALLS EXTENDING TO (E) ROOF DECK, SEE (1) A301 TYP

J. EXISTING FIRE EXTINGUISHERS ARE TO REMAIN IN THEIR CURRENT LOCATIONS. IF A FIRE EXTINGUISHER NEEDS TO BE RELOCATED DUE TO FUTURE SHIFTS, THE FIRE EXTINGUISHERS ARE TO BE RELOCATED AND INSTALLED NO FURTHER THAN 15' FROM ITS CURRENT LOCATION. FINAL LOCATIONS: FIRE MARSHAL WALK-THROUGH INSPECTION.

7 HEAD @ COILING DOOR
A111 SCALE: 1/12" = 1'-0"

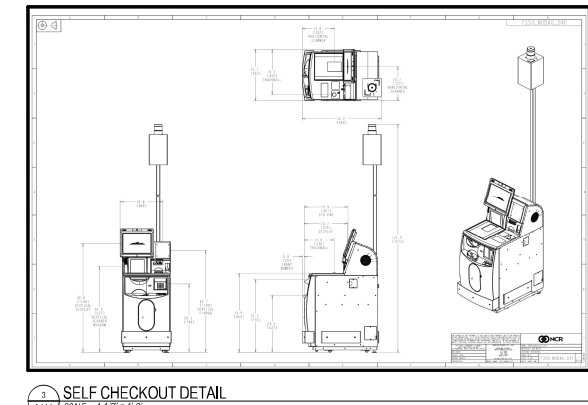

3 SELF CHECKOUT DETAIL
A111 SCALE: 1/12" = 1'-0"

Approval of submitted plans is not an approval of omissions or oversights by this office or non compliance with any applicable regulations of local government. The contractor is responsible for making sure that the building complies with all applicable codes and regulations of the local government.

The approved construction plans, documents, and all engineering must be posted on the job at all inspections in a visible and readily accessible location.

Full sized legible color plans are required to be provided by the permittee on site for inspection.

City of Puyallup
Development & Permitting Services
ISSUED PERMIT

Building	Planning
Engineering	Public Works
Fire	Traffic

City of Puyallup
Building
REVIEWED
FOR
COMPLIANCE

SKinnear
07/14/2025
11:07:17 AM

Separate Electrical Permit is required with the Washington State Department of Labor & Industries.
<https://lni.wa.gov/licensing-permits/electrical/electrical-permits-fees-and-inspections>
or call for Licensing Information: 1-800-647-0982

TARGET
1000 NICOLLET MALL
MINNEAPOLIS, MN 55403

1101 Second Ave, Ste 100
Seattle, WA 98101
206 962 6500
MG2.com

Date	No.	Description
02/07/18		PERMIT SET
03/21/18	1	DCN 1019634
04/04/18	2	DCN 1020009
05/09/18	6	DCN 1021794
05/29/18	7	DCN 1022086
05/30/18		BID SET

JUSTIN A. HILL, ARCHITECT

TARGET
PUYALLUP, WA
3310 S. MERIDIAN
PUYALLUP, WA 98373

Project Number **T0342**

Proto:P188	Version:N/A	Config:N/A
------------	-------------	------------

Drawn By **JCA**
Checked By **IL**

FLOOR PLAN

A111

PLAN NORTH

5/31/2018 12:18:48 PM