


GENERAL NOTES / SCOPE OF WORK

1. SYSTEM WIRING NOTED ON THE DRAWINGS IS PER MANUFACTURE AND CODE REQUIREMENTS. ANY ALTERATION TO SYSTEM WIRING, WITHOUT APPROVAL, IS AT ELECTRICAL CONTRACTOR'S OWN RISK!!
2. SYSTEM WIRING SHOWN ON DRAWINGS IS DIAGRAMMATIC AND ONLY USED FOR REFERENCE PURPOSES. ACTUAL WIRE AND DEVICE INSTALLATION MAY VARY DUE TO OBSTRUCTIONS.
3. WIRE SHOWN IN THIS DRAWING SET IS PERMITTED IN RACEWAYS LEADING TO FIRE PROTECTION EQUIPMENT. OTHER WIRE SHALL NOT BE PERMITTED IN THE SAME RACEWAY.
4. FIRE ALARM SYSTEM INSTALLATION SHALL CONFORM WITH THE LATEST U.L., N.E.C., N.F.P.A., W.A.C., AND OTHER STANDARDS AS APPLICABLE TO THE CITY STANDARDS.
5. WHEN NECESSARY, DUE TO CHANGING DESIGN REQUIREMENTS, FACTORY AVAILABILITY, ETC. FIRE SYSTEMS WEST RESERVES THE RIGHT TO SUBSTITUTE EQUIPMENT HEREIN MENTIONED OR SPECIFIED, WITH EQUIPMENT OF EQUAL OR BETTER QUALITY, FUNCTION AND DESIGN.
6. PARALLEL BRANCHING (T-TAPPING) OF WIRE TO ALL NOTIFICATION APPLIANCE CIRCUITS SHALL NOT BE PERMITTED.
7. FIRE SYSTEMS WEST WILL INSTALL A NEW FIRE ALARM POWER SUPPLY AND REMOTE ANNUNCIATOR.
8. FIRE SYSTEMS WEST WILL INSTALL NEW SMOKE DETECTORS THROUGHOUT.
9. FIRE SYSTEMS WEST WILL INSTALL A NEW RELAY MODULE FOR THE A/V SYSTEM.
10. FIRE SYSTEMS WEST WILL INSTALL NEW RELAY MODULES FOR THE HVLS FANS.
11. FIRE SYSTEMS WEST WILL INSTALL NEW NOTIFICATION DEVICES THROUGHOUT FOR THE TENANT IMPROVEMENT.


FLAG NOTES

1. INSTALL SMOKE DETECTOR ABOVE THE CEILING.
2. INSTALL RELAY FOR AV SHUTDOWN. COORDINATE WITH ELECTRICAL CONTRACTOR.
3. INSTALL RELAY FOR HVLS FAN SHUTDOWN. COORDINATE WITH MECHANICAL/ELECTRICAL CONTRACTOR.

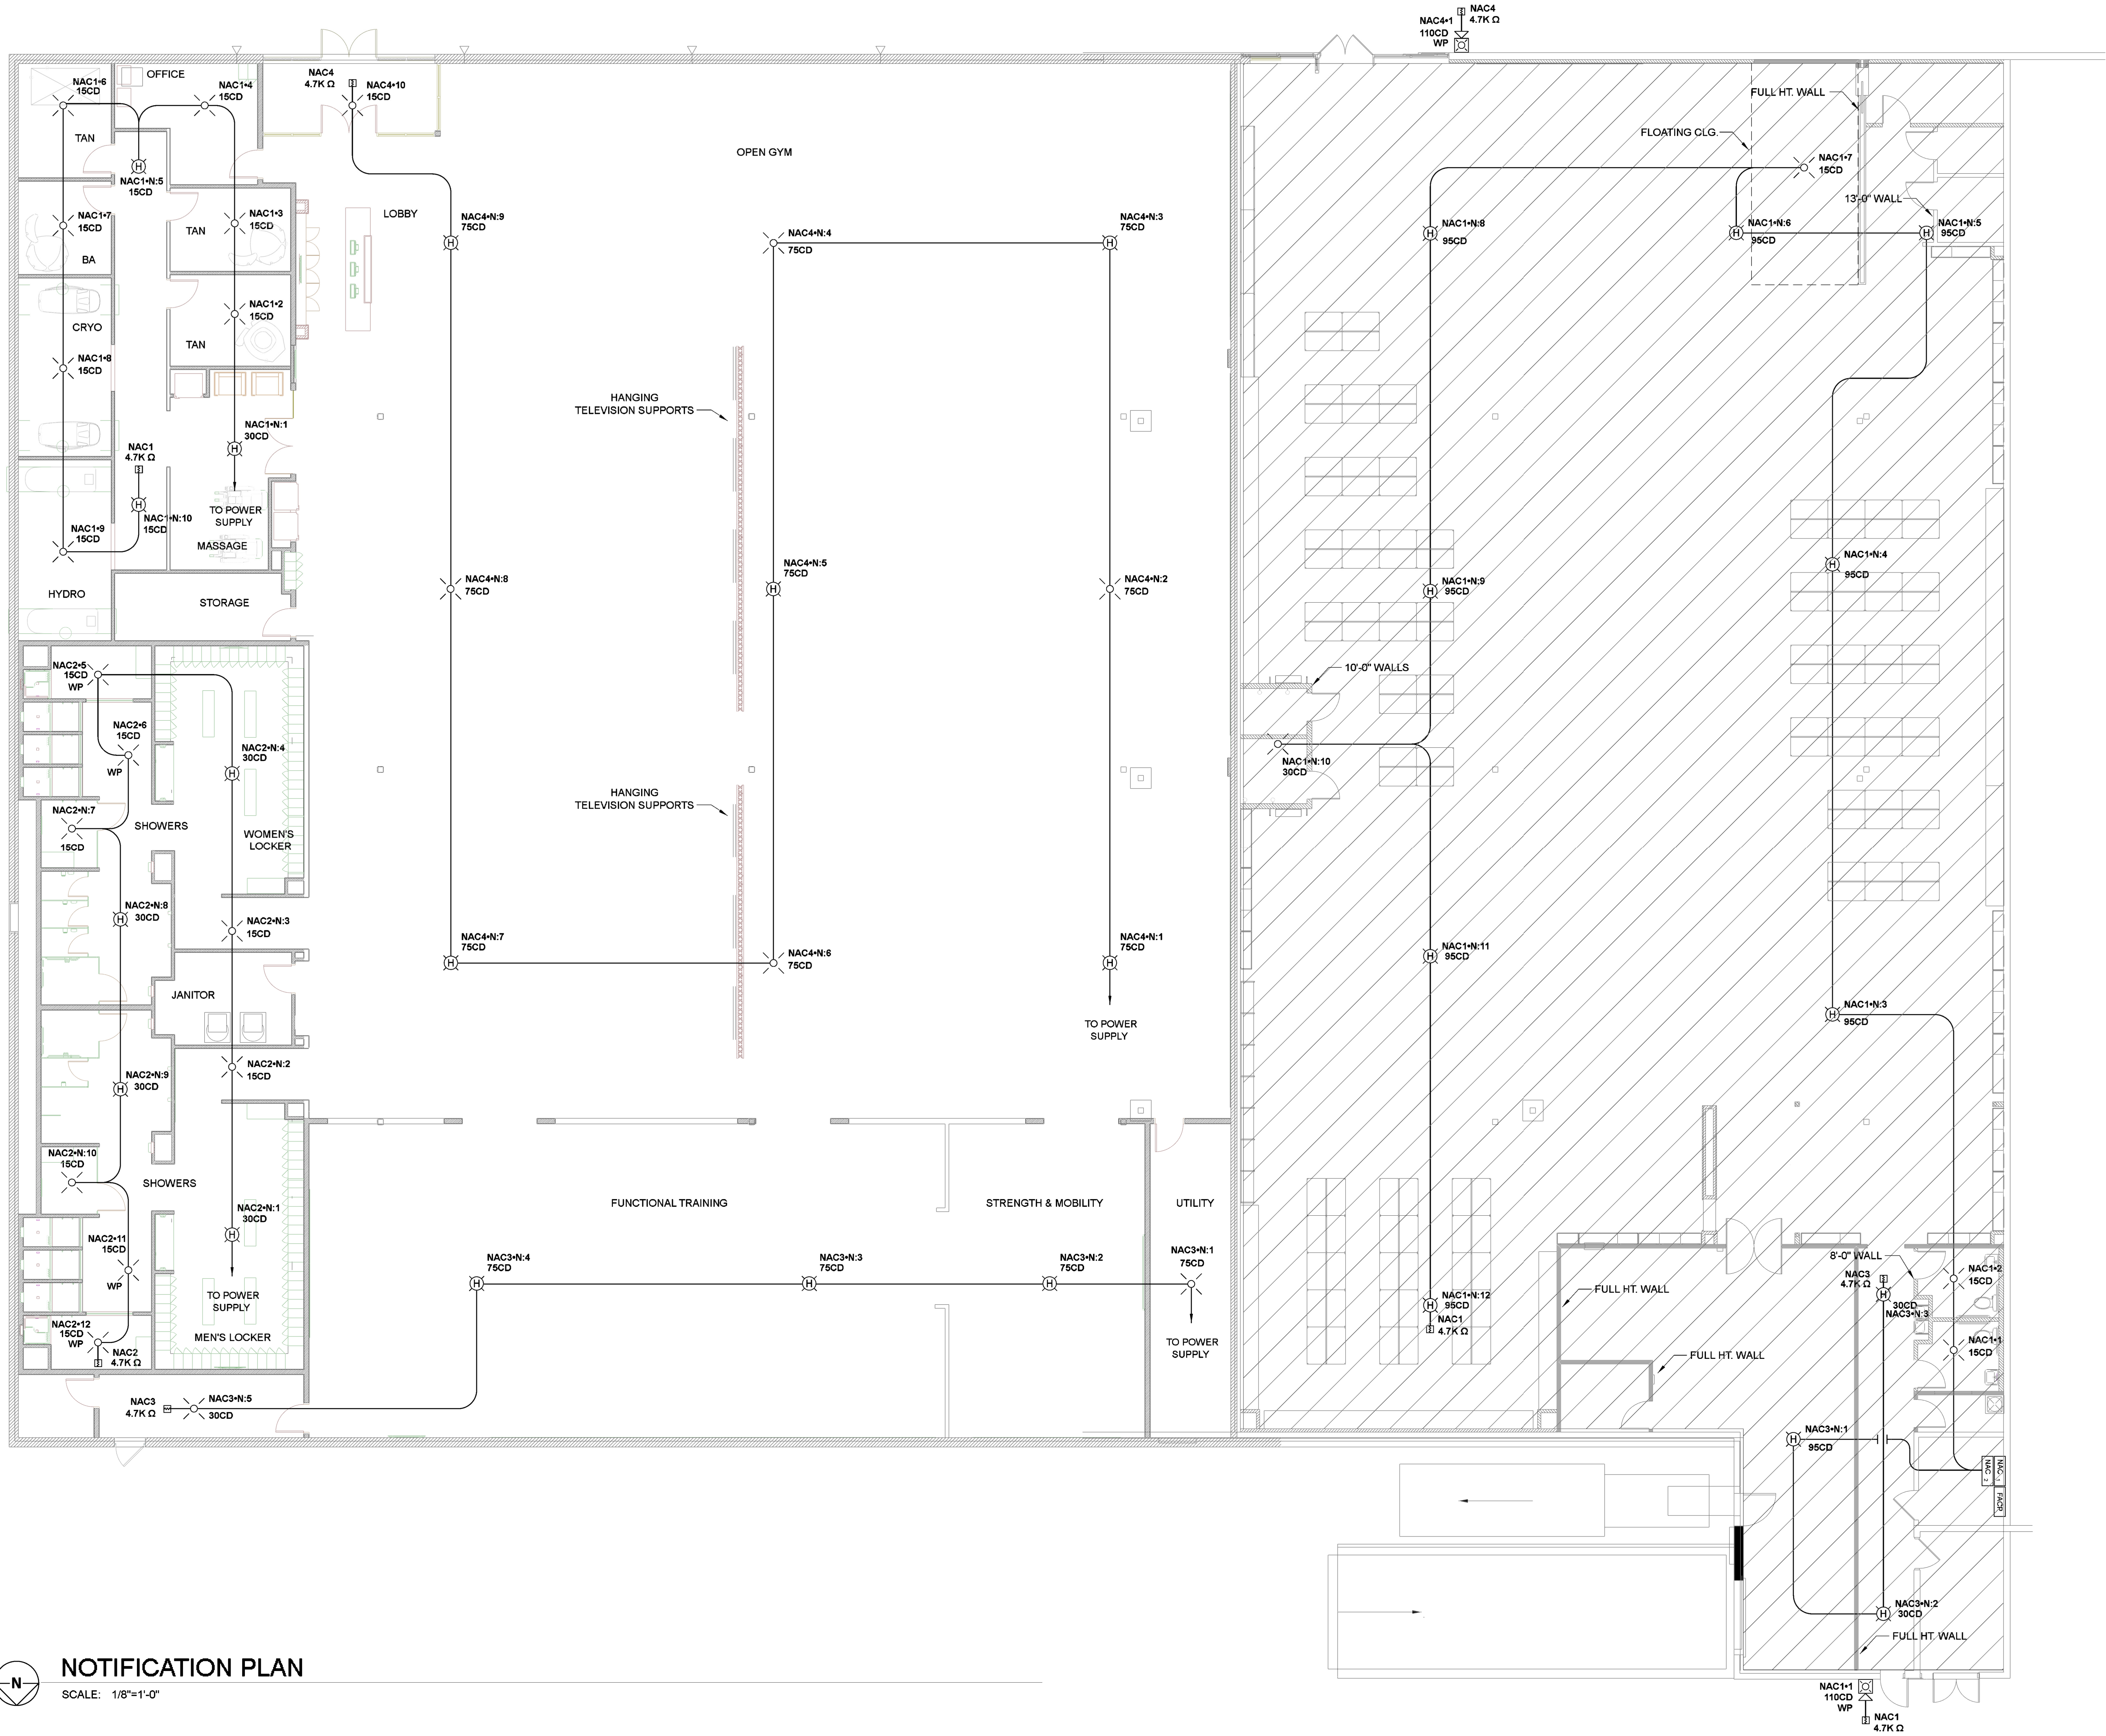

NOTIFICATION PLAN

SCALE: 1/8"=1'-0"

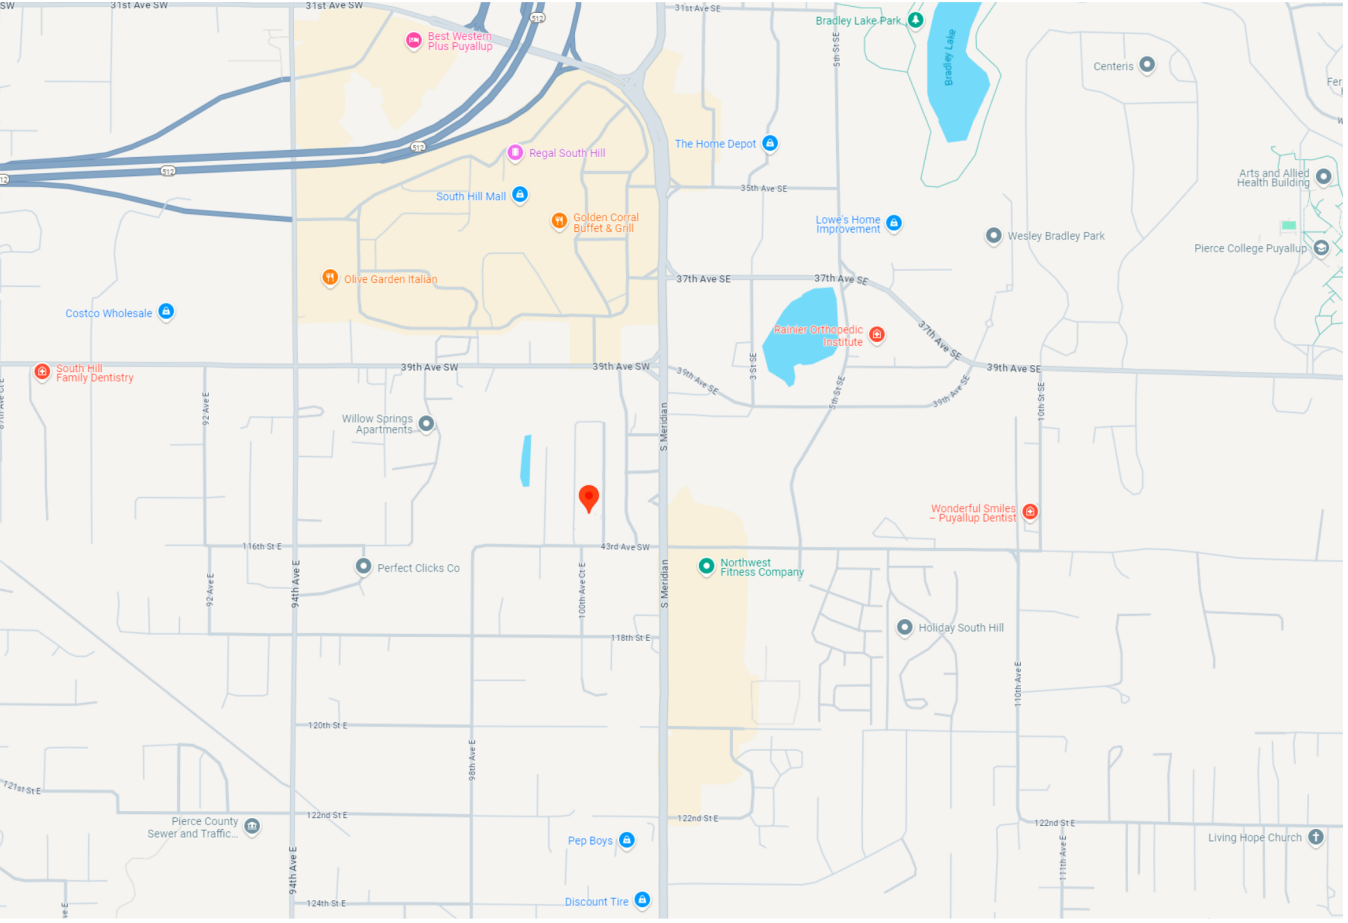

VICINITY MAP

NOT TO SCALE

PROJECT: 817-1479	PLANET FITNESS - FIRE ALARM PLAN	A B EX D N R	14/2 FPLP 16/2 FPLP EXISTING LOCATION DEMO DEVICE NEW DEVICE RELOCATE	CODE COMPLIANCE	DESIGNER CAMRYN OLIVAREZ NICET PAS-II, #153071 FIRE SYSTEMS WEST, INC. 208 FRONTAGE ROAD NORTH #C PACIFIC, WASHINGTON 98047	REVISIONS	206 Frontage Rd. North #C Pacific, WA 98047 f:(253) 735-0113 t:(253) 833-1248 WA ECL# FIRESWI 055LW WA CL# FIRESWI 140B1
DATE: 08/20/2025	CONTRACT: Planet Fitness 4102 S Meridian Puyallup, WA 98373	CUSTOMER: Leibo Brothers Management 700 State Street, Suite 403 New Haven, CT 06511	STROBE COVERAGE AREA SHALL BE DEFINED AS: 10 FT. CLG. HT. 30 FT. CLG. HT. 30 FT. CLG. HT. 15 cd = 20'x20' 30 cd = 20'x20' 75 cd = 20'x20' 30 cd = 30'x30' 75 cd = 30'x30' 95 cd = 30'x30' 75 cd = 40'x40' 95 cd = 40'x40' 110 cd = 40'x40' 95 cd = 50'x50' 110 cd = 50'x50' 115 cd = 50'x50'	OCCUPANT TYPE: A CITY OF PUYALLUP MUNICIPAL CODE OCCUPANT LOAD: 194 2021 INTERNATIONAL BUILDING CODE AREA: 13,171 SF 2021 INTERNATIONAL FIRE CODE CONSTRUCTION: 2023 NATIONAL ELECTRICAL CODE SPRINKLERED: YES 2022 NATIONAL FIRE ALARM & SIGNALING CODE	NO. DESCRIPTION DATE BY CHK 1 ISSUED_FOR_REVIEW 10/30/2024 CO MWC 2 REV. 1 11/21/2024 CO MWC 3 AS BUILT 12/19/2024 CO MWC 4 ZONE MAP 12/19/2024 CO MWC 5 PLANET FITNESS TI 08/20/2025 CO MWC		