

SYSTEM WIRING NOTED ON THE DRAWINGS IS PER MANUFACTURE AND CODE REQUIREMENTS. ANY ALTERATION TO SYSTEM WIRING, WITHOUT APPROVAL, IS AT ELECTRICAL CONTRACTOR'S OWN RISK!!

5. WIRE SHOWN IN THIS DRAWING SET IS PERMITTED IN RACEWAYS LEADING TO FIRE PROTECTION EQUIPMENT. OTHER WIRE SHALL NOT BE PERMITTED IN THE SAME RACEWAY.

5. WHEN NECESSARY, DUE TO CHANGING DESIGN REQUIREMENTS, FACTORY AVAILABILITY, ETC. FIRE SYSTEMS WEST RESERVES THE RIGHT TO SUBSTITUTE EQUIPMENT HEREIN MENTIONED OR SPECIFIED, WITH

7. FIRE SYSTEMS WEST WILL INSTALL A NEW FIRE ALARM POWER SUPPLY AND REMOTE ANNUNCIATOR.

0. FIRE SYSTEMS WEST WILL INSTALL NEW RELAY MODULES FOR THE HVLS FANS.

FLAG NOTES

2. INSTALL RELAY FOR A/V SHUTDOWN. COORDINATE WITH ELECTRICAL CONTRACTOR.

3. INSTALL RELAY FOR HVLS FAN SHUTDOWN. COORDINATE WITH MECHANICAL/ELECTRICAL CONTRACTOR.

A: CHANGE SMOKE DETECTORS TO HEAT DETECTORS IN SHOWER AREAS TO AVOID FALSE ALARMS.



WA ECL# FIRESWI 055LW
WA CL# FIRESWI 140B1

Fire Systems West, Inc.

206 Frontage Rd. North #C
Pacific, WA 98047


f:(253) 735-0113
t:(253) 833-1248

WA ECL# FIRESWI 0555LW
WA CL# FIRESWI 140B1

11. FIRE SYSTEMS WEST WILL INSTALL NEW NOTIFICATION DEVICES THROUGHOUT FOR THE TENANT IMPROVEMENT.

3. INSTALL RELAY FOR HVLS FAN SHUTDOWN. COORDINATE WITH MECHANICAL/ELECTRICAL CONTRACTOR.

A: CHANGE SMOKE DETECTORS TO HEAT DETECTORS IN SHOWER AREAS TO AVOID FALSE ALARMS.

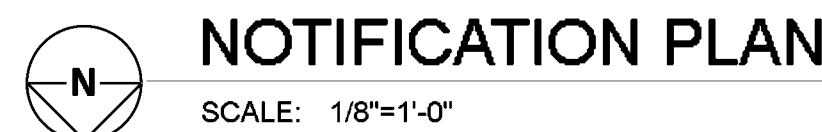

PROJECT: 817-1479	PLANET FITNESS - FIRE ALARM PLAN		A B EX D N R	14/2 FFLP 16/2 FFLP EXISTING LOCATION DEMO DEVICE NEW DEVICE RELOCATE	CODE COMPLIANCE			DESIGNER	REVISIONS					 206 Frontage Rd. North #C Pacific, WA 98047 f:(253) 735-0113 t:(253) 833-1248		
DATE: 08/20/2025	CONTRACT:	CUSTOMER:			OCCUPANT TYPE:	A	CITY OF PUYALLUP MUNICIPAL CODE	CAMRYN OLIVAREZ NICET FAS-II, #153071	NO.	DESCRIPTION	DATE	BY	CHK			
SCALE: 1/8"=1'-0"	Planet Fitness	Leibo Brothers Management			OCCUPANT LOAD:	194	2021 INTERNATIONAL BUILDING CODE	FIRE SYSTEMS WEST, INC 208 FRONTAGE ROAD NORTH #C PACIFIC, WASHINGTON 98047	1	ISSUED FOR REVIEW	10/30/2024	CO	MWC			
SHEET: FA02	4102 S Meridian	700 State Street, Suite 403			AREA:	13,171 SF	2021 INTERNATIONAL FIRE CODE		2	REV. 1	11/21/2024	CO	MWC			
			10.FT. CLG. HT. 20.FT. CLG. HT. 30.FT. CLG. HT. 15' cd = 20x20' 30' cd = 20x20' 75' cd = 20x30' 30' cd = 30x30' 75' cd = 30x30' 95' cd = 30x30' 75' cd = 40x40' 95' cd = 40x40' 110' cd = 40x40' 95' cd = 50x50' 110' cd = 50x50' 110' cd = 50x50'		CONSTRUCTION:		2023 NATIONAL ELECTRICAL CODE		3	AS BUILT	12/19/2024	CO	MWC			
					SPRINKLERED:	YES	2022 NATIONAL FIRE ALARM & SIGNALING CODE	x 		4	ZONE MAP	12/19/2024	CO	MWC		
									5	PLANET FITNESS TI	08/20/2025	CO	MWC			
									6	PLANET FITNESS REV. 1	10/02/2025	CO	MWC			
-- FILE: Boat Barn E1 DATE: 10/02/25 TIME: 12:44:54 --															WA ECL# FIRESWT 055LW WA CL# FIRESWT 140B1	

GENERAL NOTES / SCOPE OF WORK


1. SYSTEM WIRING NOTED ON THE DRAWINGS IS PER MANUFACTURE AND CODE REQUIREMENTS. ANY ALTERATION TO SYSTEM WIRING, WITHOUT APPROVAL, IS AT ELECTRICAL CONTRACTOR'S OWN RISK!!
2. SYSTEM WIRING SHOWN ON DRAWINGS IS DIAGRAMMATIC AND ONLY USED FOR REFERENCE PURPOSES. ACTUAL WIRE AND DEVICE INSTALLATION MAY VARY DUE TO OBSTRUCTIONS.
3. WIRE SHOWN IN THIS DRAWING SET IS PERMITTED IN RACEWAYS LEADING TO FIRE PROTECTION EQUIPMENT. OTHER WIRE SHALL NOT BE PERMITTED IN THE SAME RACEWAY.
4. FIRE ALARM SYSTEM INSTALLATION SHALL CONFORM WITH THE LATEST U.L., N.E.C., N.F.P.A., W.A.C., AND OTHER STANDARDS AS APPLICABLE TO THE CITY STANDARDS.
5. WHEN NECESSARY, DUE TO CHANGING DESIGN REQUIREMENTS, FACTORY AVAILABILITY, ETC. FIRE SYSTEMS WEST RESERVES THE RIGHT TO SUBSTITUTE EQUIPMENT HEREIN MENTIONED OR SPECIFIED, WITH EQUIPMENT OF EQUAL OR BETTER QUALITY, FUNCTION AND DESIGN.
6. PARALLEL BRANCHING (T-TAPPING) OF WIRE TO ALL NOTIFICATION APPLIANCE CIRCUITS SHALL NOT BE PERMITTED.
7. FIRE SYSTEMS WEST WILL INSTALL A NEW FIRE ALARM POWER SUPPLY AND REMOTE ANNUNCIATOR.
8. FIRE SYSTEMS WEST WILL INSTALL NEW SMOKE DETECTORS THROUGHOUT.
9. FIRE SYSTEMS WEST WILL INSTALL A NEW RELAY MODULE FOR THE A/V SYSTEM.
10. FIRE SYSTEMS WEST WILL INSTALL NEW RELAY MODULES FOR THE HVLS FANS.
11. FIRE SYSTEMS WEST WILL INSTALL NEW NOTIFICATION DEVICES THROUGHOUT FOR THE TENANT IMPROVEMENT.

FLAG NOTES


1. INSTALL SMOKE DETECTOR ABOVE THE CEILING.
2. INSTALL RELAY FOR AV SHUTDOWN. COORDINATE WITH ELECTRICAL CONTRACTOR.
3. INSTALL RELAY FOR HVLS FAN SHUTDOWN. COORDINATE WITH MECHANICAL/ELECTRICAL CONTRACTOR.

REVISIONS

A: CHANGE SMOKE DETECTORS TO HEAT DETECTORS IN SHOWER AREAS TO AVOID FALSE ALARMS.

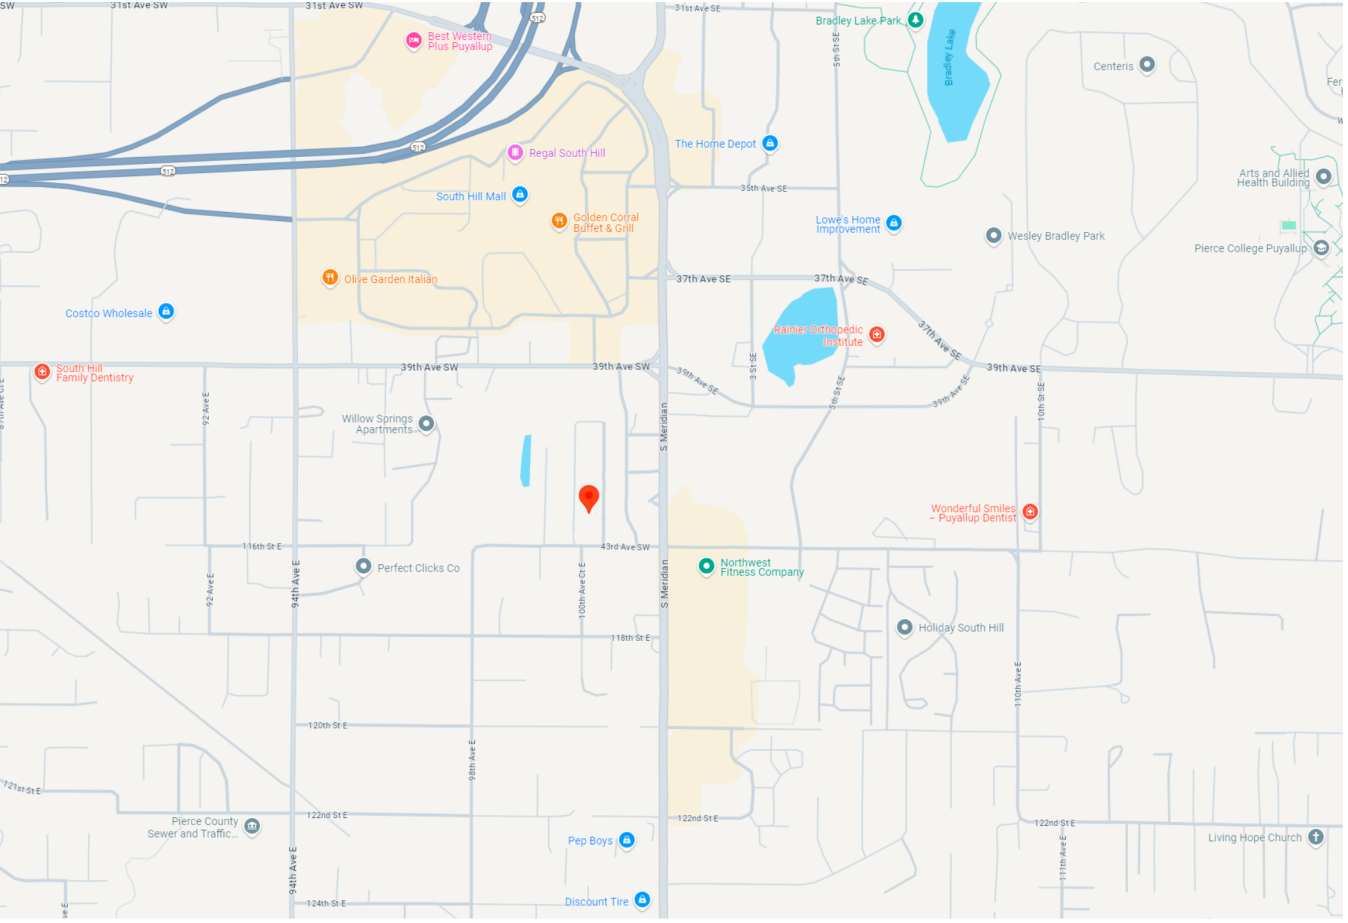

VICINITY MAP
NOT TO SCALE

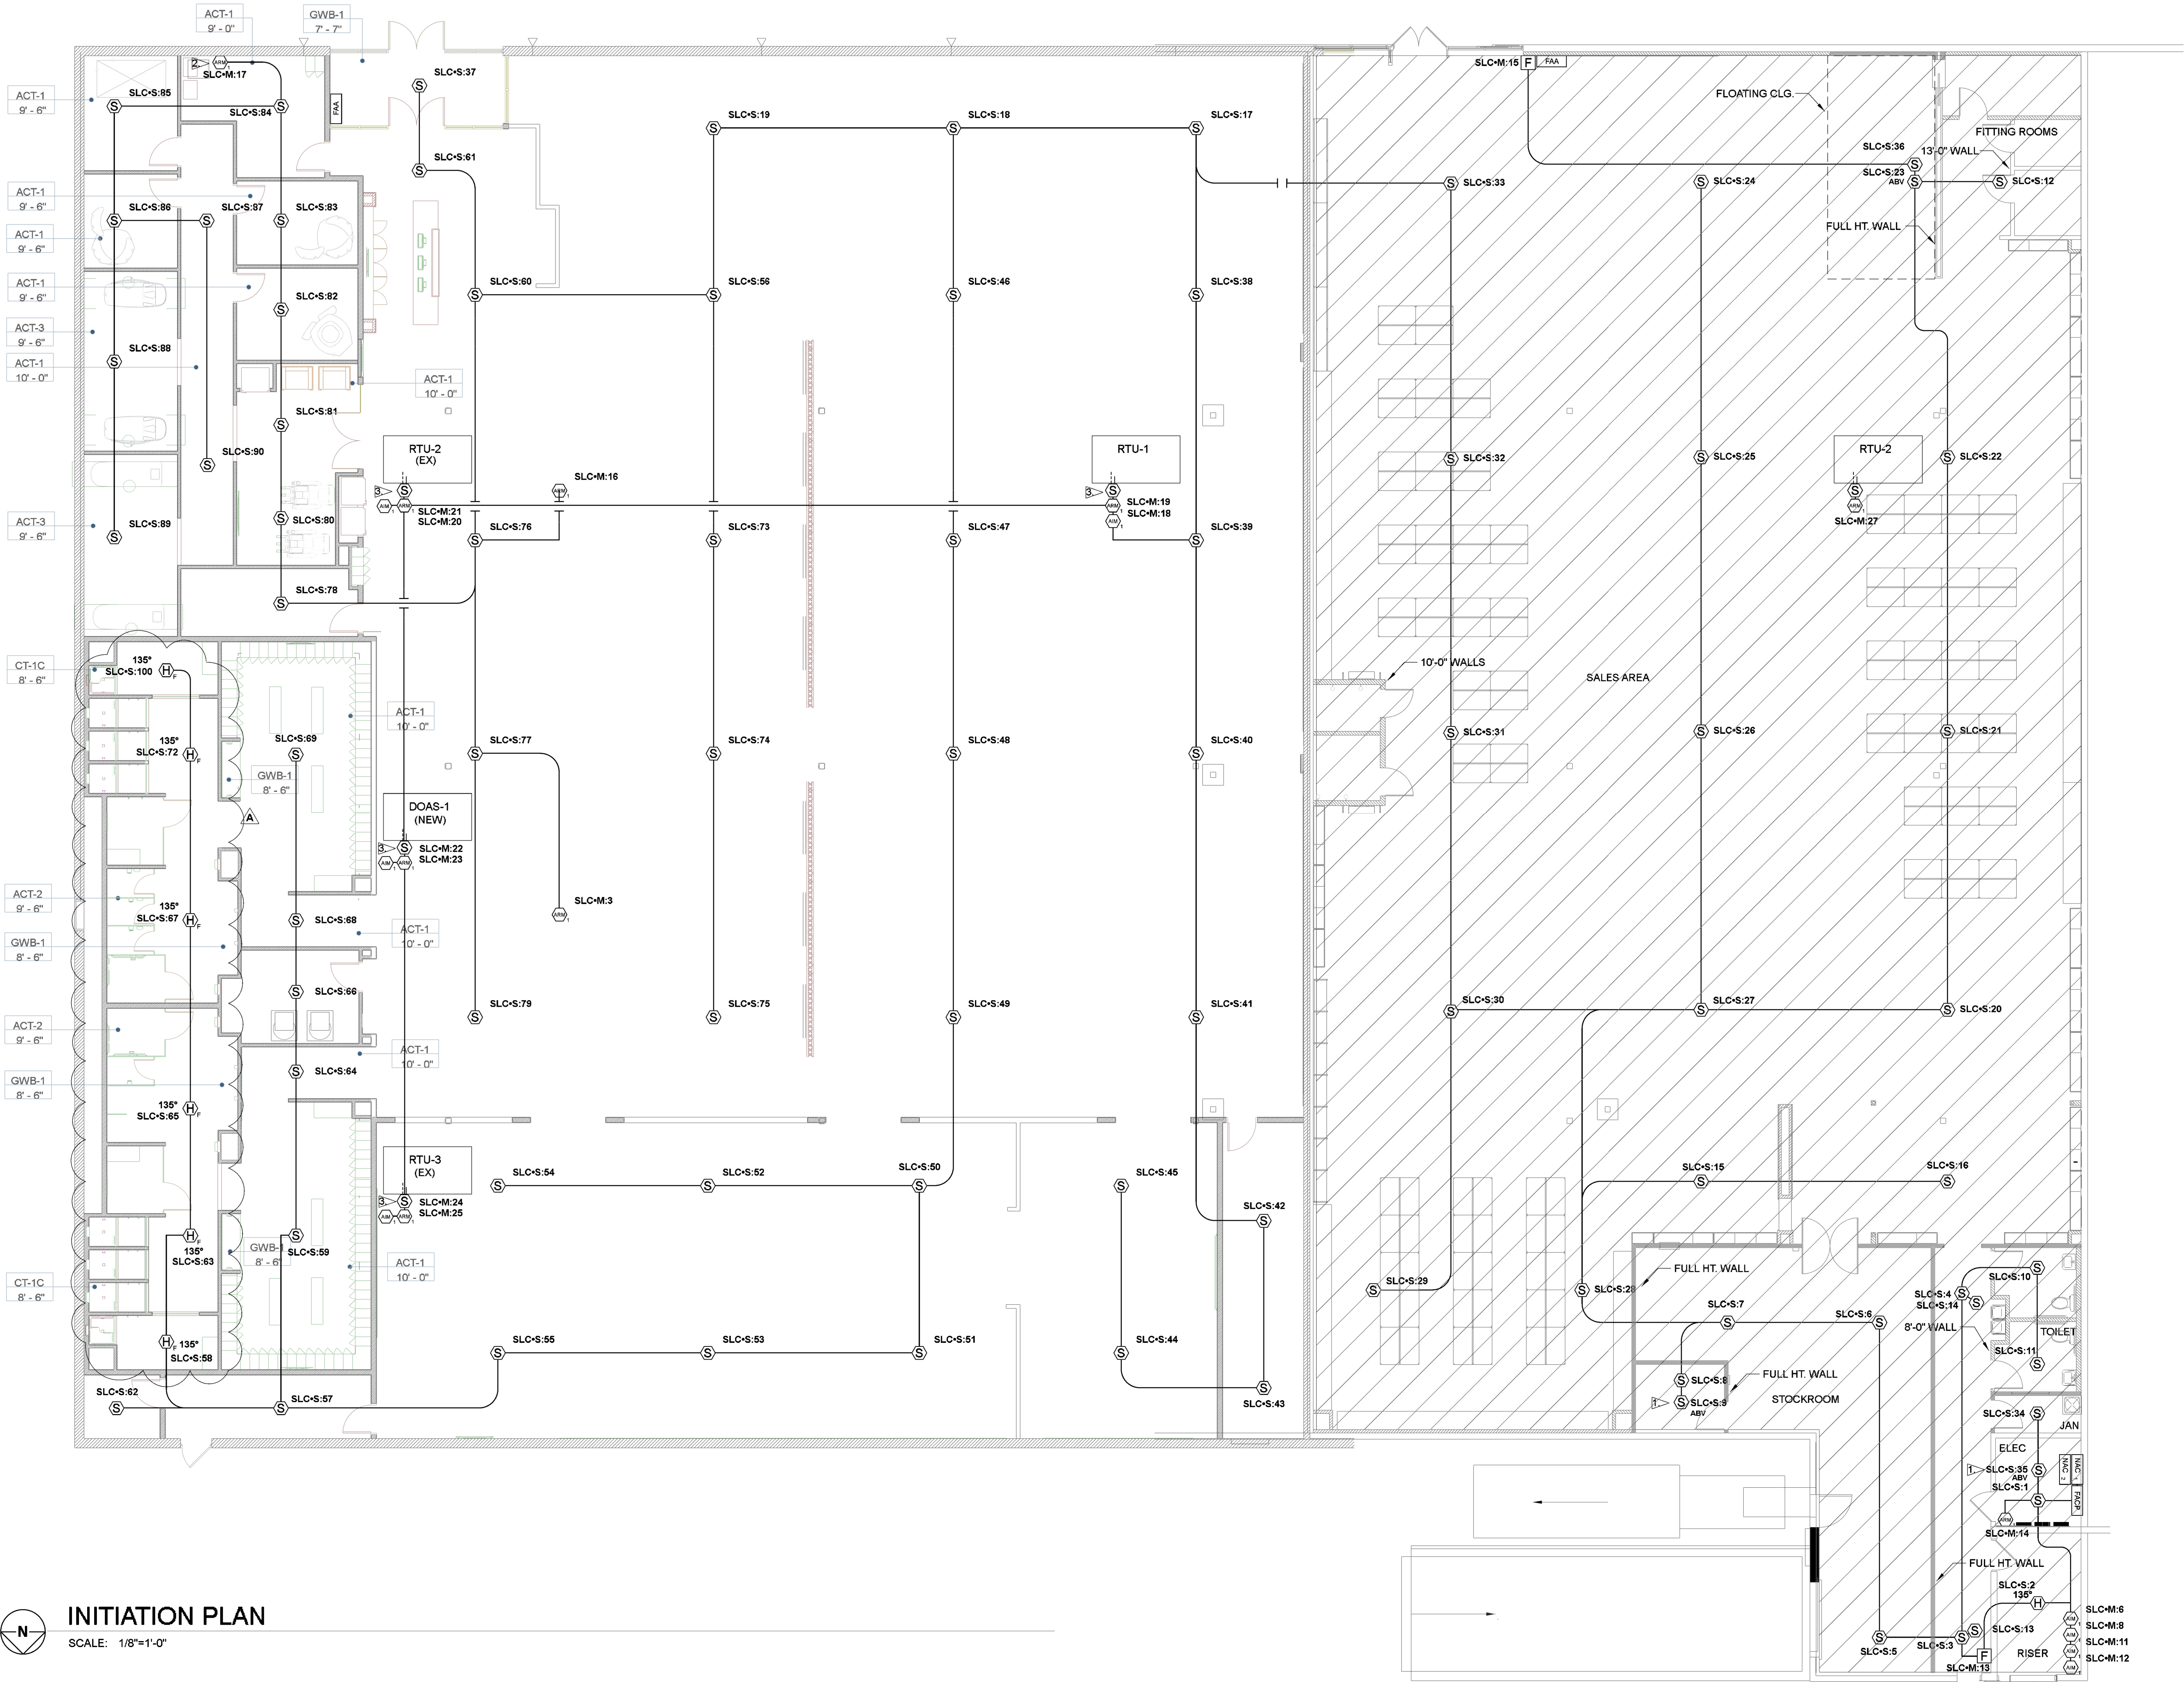

INITIATION PLAN
SCALE: 1/8"=1'-0"

PROJECT: 817-1479		PLANET FITNESS - FIRE ALARM PLAN		A B EX D N R		14/2 FPLP 16/2 FPLP EXISTING LOCATION DEMO DEVICE NEW DEVICE RELOCATE		OCCUPANT TYPE: A CITY OF PUYALLUP MUNICIPAL CODE		DESIGNER CAMRYN OLIVAREZ NICET PAS-II, #153071		REVISIONS		206 Frontage Rd. North #C Pacific, WA 98047			
DATE: 08/20/2025		CONTRACT:		CUSTOMER:		STROBE COVERAGE AREA SHALL BE DEFINED AS:		OCCUPANT LOAD: 194 2021 INTERNATIONAL BUILDING CODE		FIRE SYSTEMS WEST, INC 208 FRONTAGE ROAD NORTH #C PACIFIC, WASHINGTON 98047		NO. DESCRIPTION DATE BY CHK		f:(253) 735-0113 t:(253) 833-1248			
SCALE: 1/8"=1'-0"		Planet Fitness 4102 S Meridian Puyallup, WA 98373		Leibo Brothers Management 700 State Street, Suite 403 New Haven, CT 06511		10 FT. CLG. HT. 15 cd = 20'x20' 20 FT. CLG. HT. 30 cd = 20'x20' 30 cd = 30'x30' 75 cd = 40'x40' 95 cd = 50'x50'		AREA: 13,171 SF 2021 INTERNATIONAL FIRE CODE		2023 NATIONAL ELECTRICAL CODE		1 ISSUED FOR REVIEW 10/30/2024 CO MWC		Fire Systems West, Inc.			
SHEET: FA03						20 FT. CLG. HT. 30 cd = 20'x20' 30 cd = 30'x30' 75 cd = 40'x40' 95 cd = 50'x50'		CONSTRUCTION: 2023 NATIONAL FIRE ALARM & SIGNALING CODE		2022 NATIONAL FIRE ALARM & SIGNALING CODE		2 REV. 1 11/21/2024 CO MWC		AS BUILT 12/19/2024 CO MWC		WA ECL# FIRESWI 055LW WA CL# FIRESWI 140B1	
-- FILE: Boot Barn E1 DATE: 10/02/25 TIME: 12:52:31 --												3 ZONE MAP 12/19/2024 CO MWC		PLANET FITNESS REV. 1 10/02/2025 CO MWC			

GENERAL NOTES / SCOPE OF WORK



1. SYSTEM WIRING NOTED ON THE DRAWINGS IS PER MANUFACTURE AND CODE REQUIREMENTS. ANY ALTERATION TO SYSTEM WIRING, WITHOUT APPROVAL, IS AT ELECTRICAL CONTRACTOR'S OWN RISK!!
2. SYSTEM WIRING SHOWN ON DRAWINGS IS DIAGRAMMATIC AND ONLY USED FOR REFERENCE PURPOSES. ACTUAL WIRE AND DEVICE INSTALLATION MAY VARY DUE TO OBSTRUCTIONS.
3. WIRE SHOWN IN THIS DRAWING SET IS PERMITTED IN RACEWAYS LEADING TO FIRE PROTECTION EQUIPMENT. OTHER WIRE SHALL NOT BE PERMITTED IN THE SAME RACEWAY.
4. FIRE ALARM SYSTEM INSTALLATION SHALL CONFORM WITH THE LATEST U.L., N.E.C., N.F.P.A., W.A.C., AND OTHER STANDARDS AS APPLICABLE TO THE CITY STANDARDS.
5. WHEN NECESSARY, DUE TO CHANGING DESIGN REQUIREMENTS, FACTORY AVAILABILITY, ETC. FIRE SYSTEMS WEST RESERVES THE RIGHT TO SUBSTITUTE EQUIPMENT HEREIN MENTIONED OR SPECIFIED, WITH EQUIPMENT OF EQUAL OR BETTER QUALITY, FUNCTION AND DESIGN.
6. PARALLEL BRANCHING (T-TAPPING) OF WIRE TO ALL NOTIFICATION APPLIANCE CIRCUITS SHALL NOT BE PERMITTED.
7. FIRE SYSTEMS WEST WILL INSTALL A NEW FIRE ALARM POWER SUPPLY AND REMOTE ANNUNCIATOR.
8. FIRE SYSTEMS WEST WILL INSTALL NEW SMOKE DETECTORS THROUGHOUT.
9. FIRE SYSTEMS WEST WILL INSTALL A NEW RELAY MODULE FOR THE A/V SYSTEM.
10. FIRE SYSTEMS WEST WILL INSTALL NEW RELAY MODULES FOR THE HVLS FANS.
11. FIRE SYSTEMS WEST WILL INSTALL NEW NOTIFICATION DEVICES THROUGHOUT FOR THE TENANT IMPROVEMENT.

FLAG NOTES

1. INSTALL SMOKE DETECTOR ABOVE THE CEILING.
2. INSTALL RELAY FOR AV SHUTDOWN. COORDINATE WITH ELECTRICAL CONTRACTOR.
3. INSTALL RELAY FOR HVLS FAN SHUTDOWN. COORDINATE WITH MECHANICAL/ELECTRICAL CONTRACTOR.

REVISIONS

A: CHANGE SMOKE DETECTORS TO HEAT DETECTORS IN SHOWER AREAS TO AVOID FALSE ALARMS.

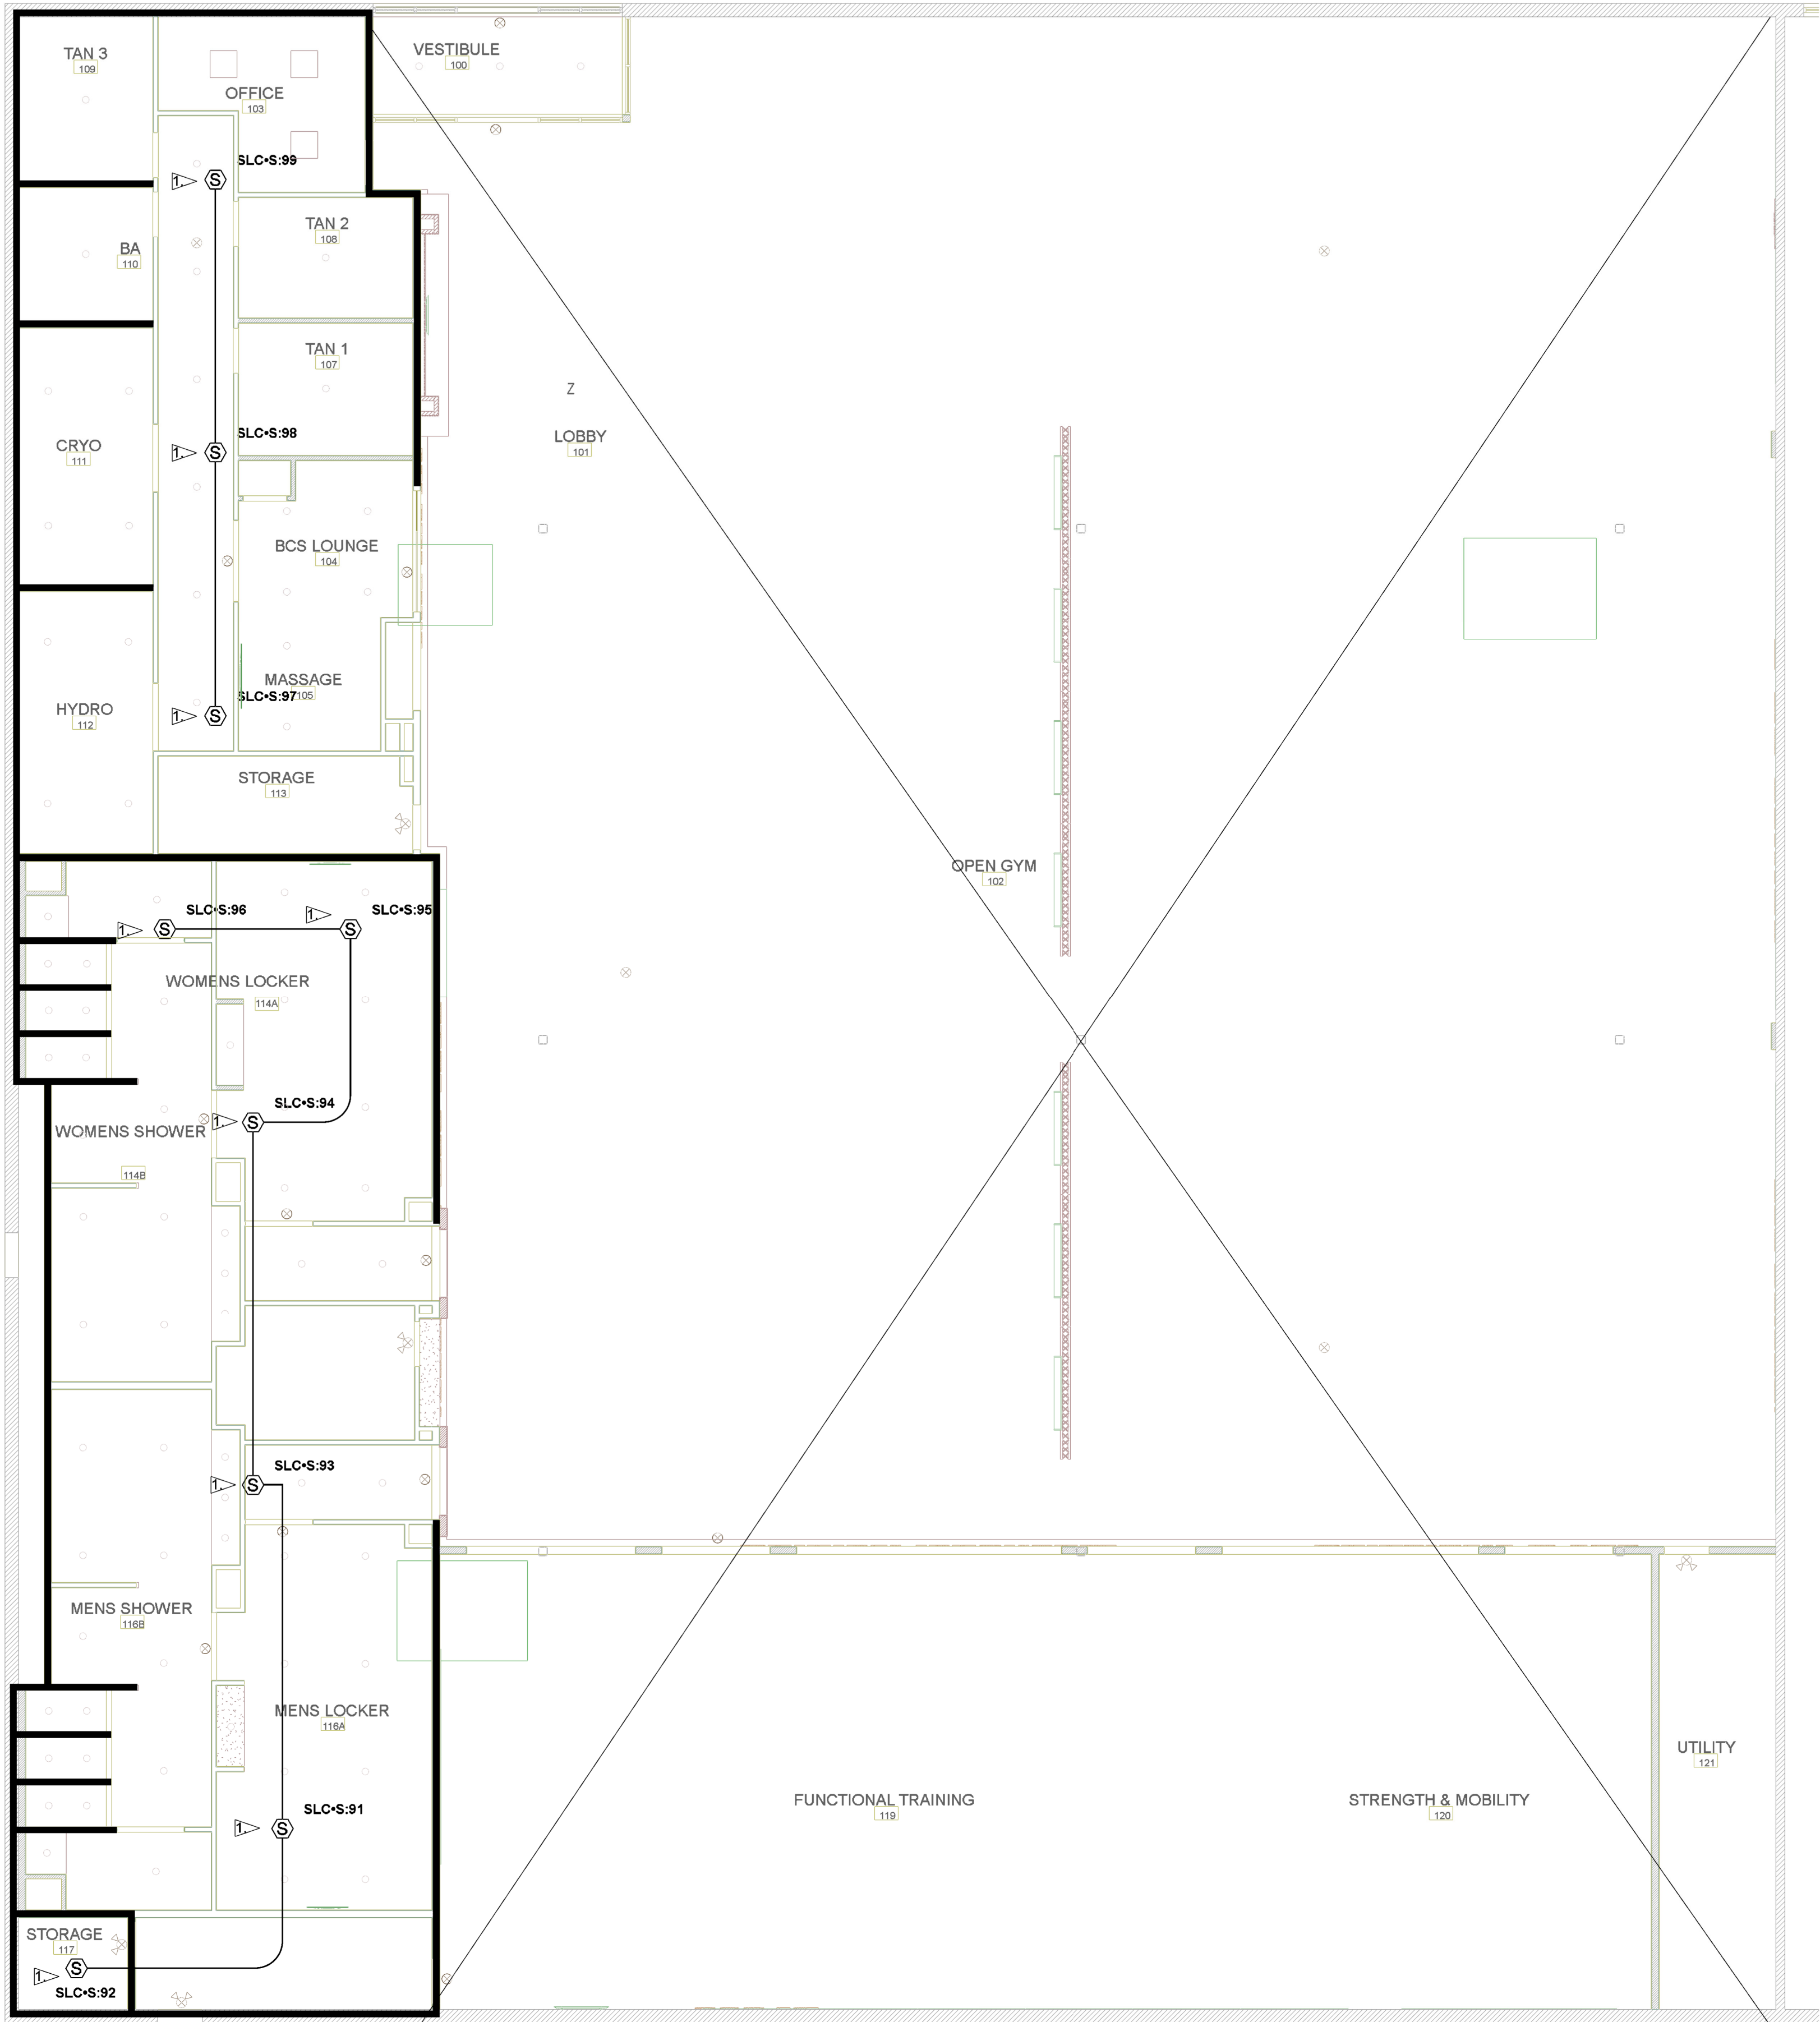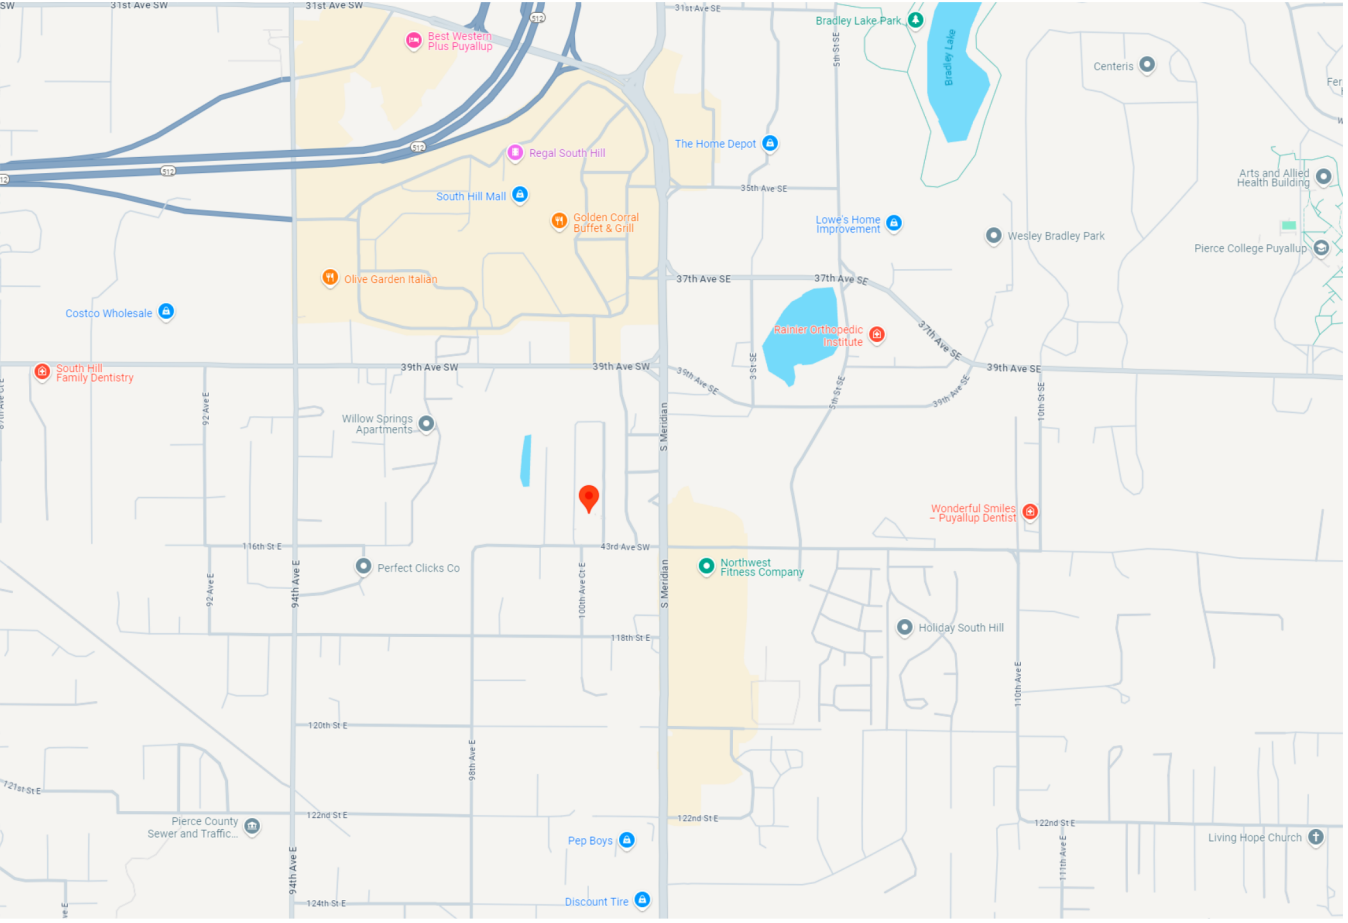

INITIATION PLAN (ABOVE CEILING)
SCALE: 1/8"=1'-0"

PROJECT: 817-1479		PLANET FITNESS - FIRE ALARM PLAN				A B EX D N R		14/2 FPLP 16/2 FPLP EXISTING LOCATION DEMO DEVICE NEW DEVICE RELOCATE		CODE COMPLIANCE				DESIGNER CAMRYN OLIVAREZ NICET PAS-II, #153071		REVISIONS				 206 Frontage Rd. North, #C Pacific, WA 98047 f:(253) 735-0113 t:(253) 833-1248 WA ECL# FIRESWI 055LW WA CL# FIRESWI 140B1							
DATE: 08/20/2025		CONTRACT:		Planet Fitness 4102 S Meridian Puyallup, WA 98373		CUSTOMER:		Leibo Brothers Management 700 State Street, Suite 403 New Haven, CT 06511		OCCUPANT TYPE:		A		CITY OF PUYALLUP MUNICIPAL CODE		NO.		DESCRIPTION				DATE		BY		CHK	
SCALE: 1/8"=1'-0"										OCCUPANT LOAD:		194		2021 INTERNATIONAL BUILDING CODE		2		REV. 1				11/21/2024		CO		MWC	
SHEET: FA04										AREA:		13,171 SF		2021 INTERNATIONAL FIRE CODE		3		AS BUILT				12/19/2024		CO		MWC	
										CONSTRUCTION:				2023 NATIONAL ELECTRICAL CODE		5		PLANET FITNESS TI				08/20/2025		CO		MWC	
										SPRINKLERED:		YES		2022 NATIONAL FIRE ALARM & SIGNALING CODE		6		PLANET FITNESS REV. 1				10/02/2025		CO		MWC	

STROBE COVERAGE AREA SHALL BE DEFINED AS:

10 FT. CLG. HT.	30 FT. CLG. HT.	30 FT. CLG. HT.
15 cd = 20'x20'	30 cd = 20'x20'	75 cd = 20'x20'
30 cd = 30'x30'	75 cd = 30'x30'	95 cd = 30'x30'
75 cd = 40'x40'	95 cd = 40'x40'	110 cd = 40'x40'
95 cd = 50'x50'	110 cd = 50'x50'	115 cd = 50'x50'