

MECHANICAL
DRAWINGS

CENTERS
VOLTAGE PARK UPS
1019 39th AVENUE SE
PUYALLUP, WA 98374

PRCTI20240275, Revision#5



Revision No.	Description	Date
1	VOLTAGE PARK PHASE 2 - PERMIT	10/25/2024
2	VOLTAGE PARK PHASE 2 - REVISIONS	02/03/2025
3	VOLTAGE PARK PHASE 2 - REVISIONS 2	10/15/2025

Drawn By: RM
Checked By: JL

MECHANICAL LEVEL 1
ENLARGED PLAN

M.VP2.301

KEY NOTES

M-15 PRIOR TO CONSTRUCTION, MECHANICAL CONTRACTOR SHALL VERIFY ALL DUCTS, DAMPERS, SENSORS AND EQUIPMENT FOR FIRE/SMOKE DAMAGE AND REPLACE IF REQUIRED.


The approved construction plans, documents, and all engineering must be posted on the job at all inspections in a visible and readily accessible location.

Full sized legible color plans are required to be provided by the permittees on site for inspection.

Approval of submitted plans is not an approval of omissions or oversights by this office or non compliance with any applicable regulations of local government. The contractor is responsible for making sure that the building complies with all applicable codes and regulations of the local government.

City of Puyallup
Building
REVIEWED
FOR
COMPLIANCE
BSnowden
10/20/2025
8:51:46 AM
CITY OF PUYALLUP
STATE OF WASHINGTON

City of Puyallup
Development & Permitting Services
ISSUED PERMIT
Building Planning
Engineering Public Works
Fire Traffic

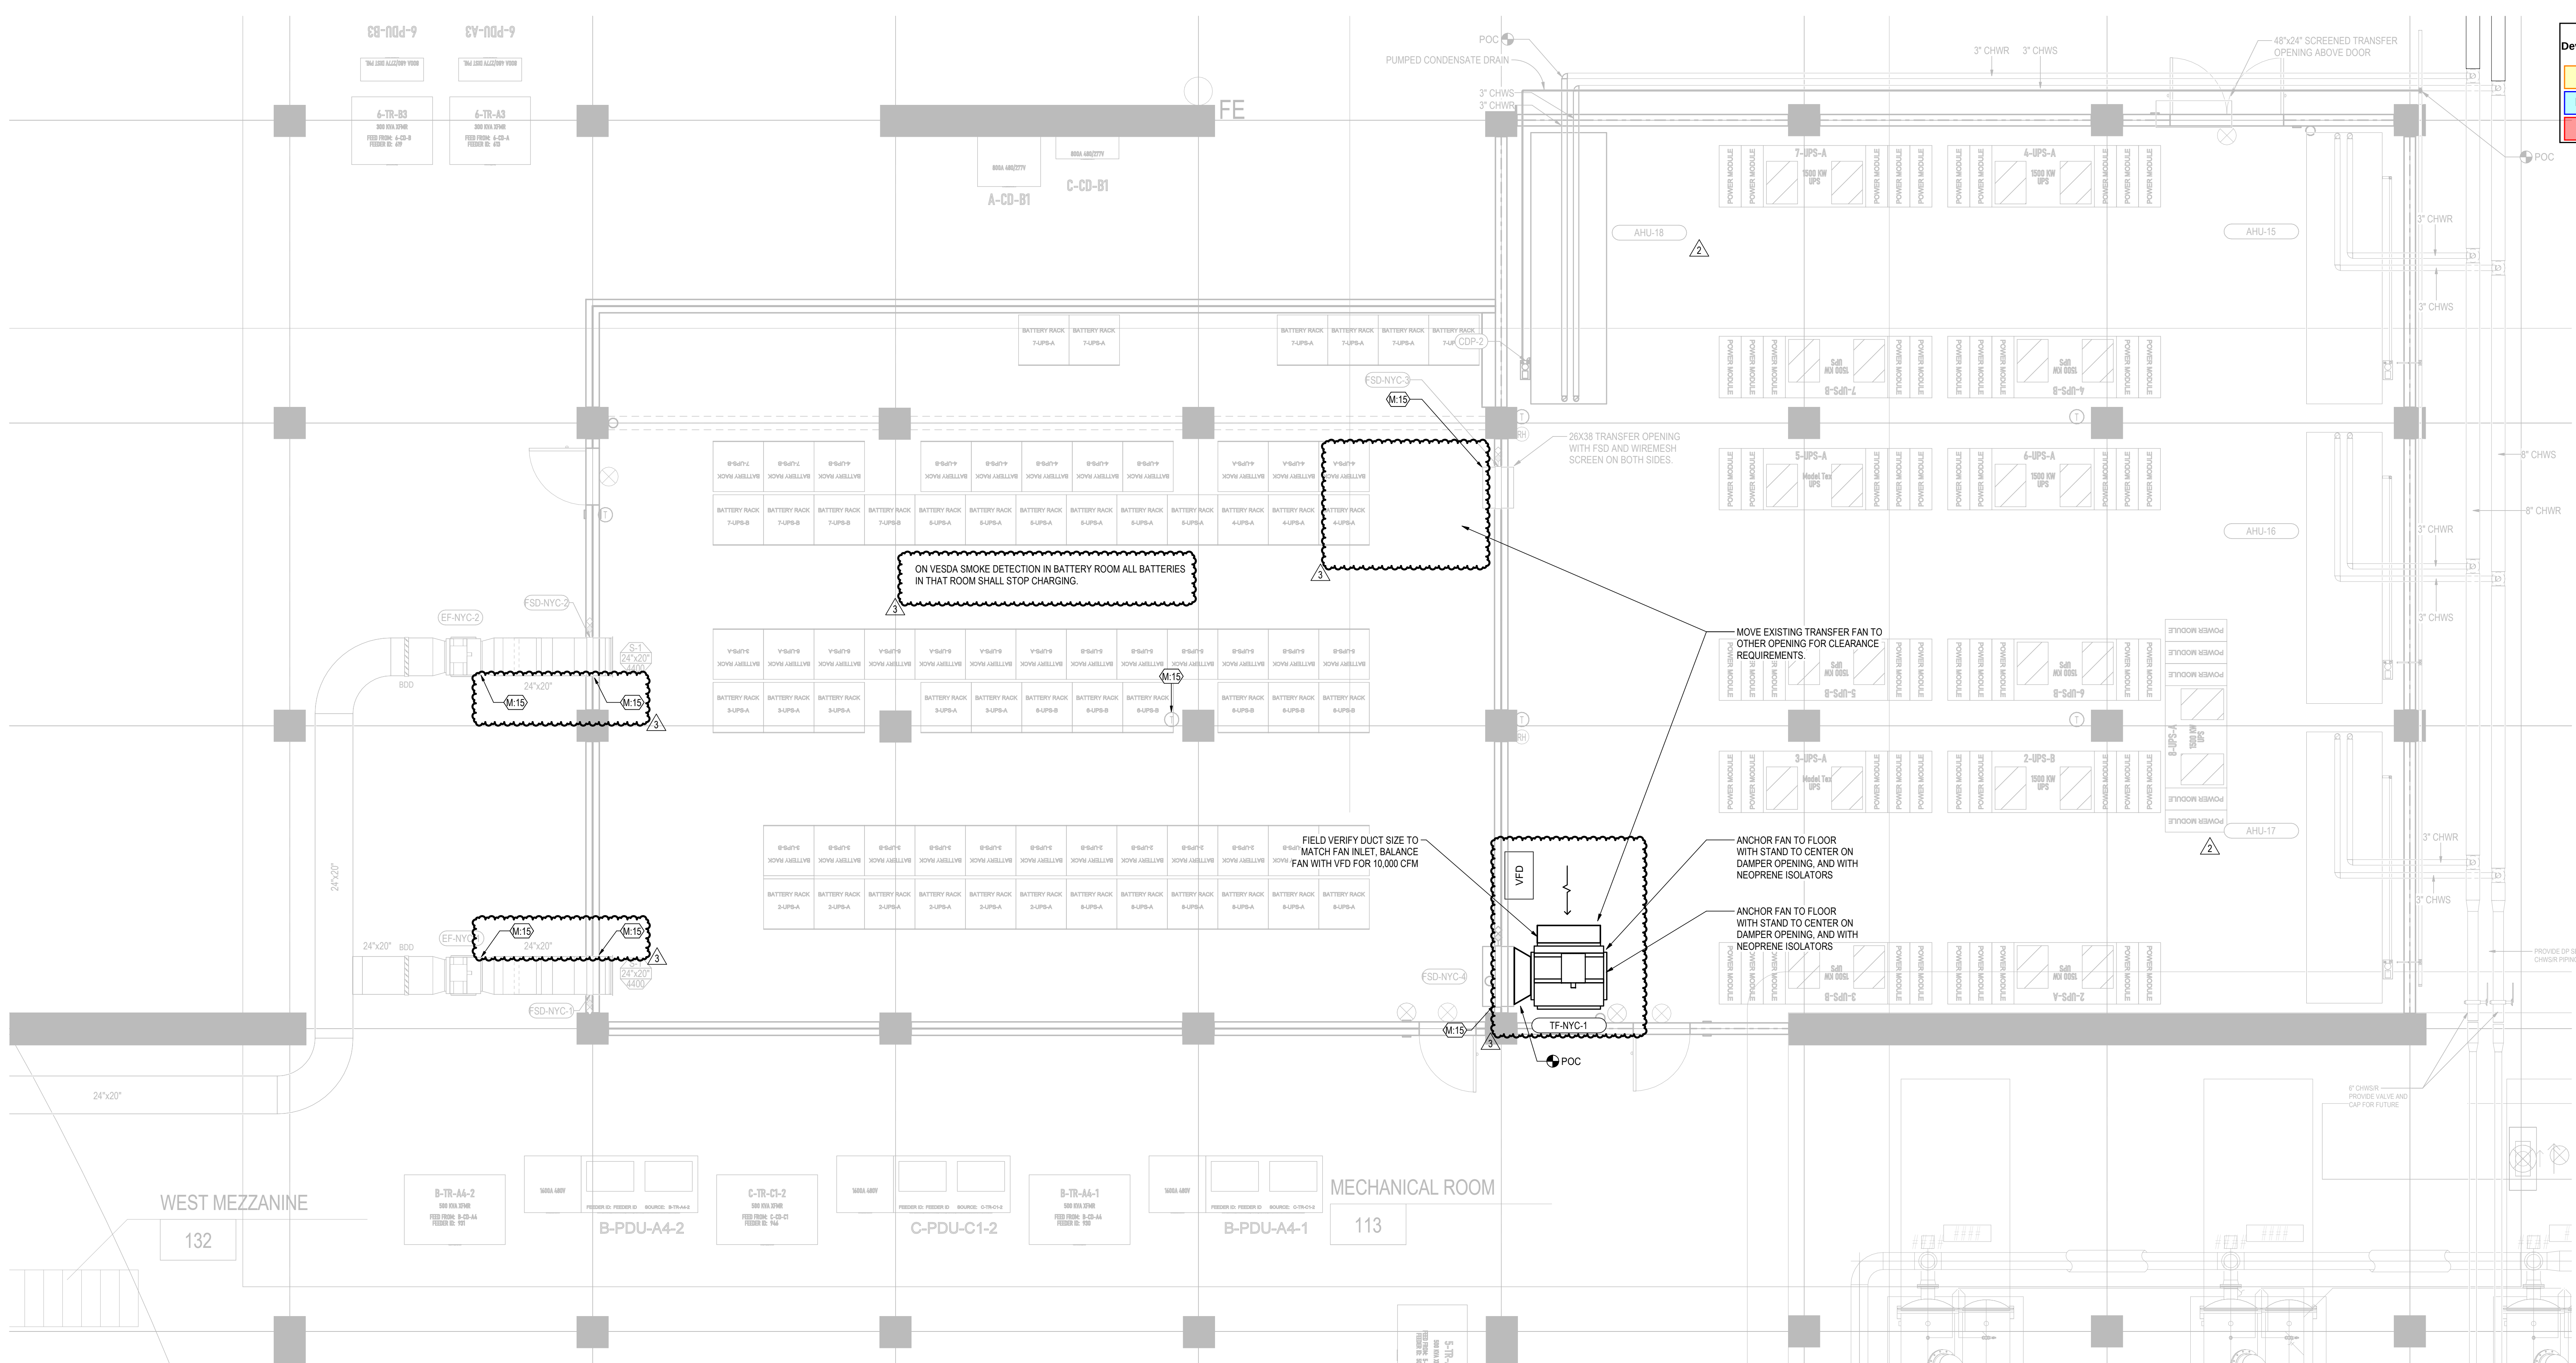

MECHANICAL DRAWINGS

CENTERIS
VOLTAGE PARK UPS
1019 39th AVENUE SE
PUYALLUP, WA 98374

PRCTI20240275, Revision#5



2025-10-1

Revision No.	Description	Date
1	VOLTAGE PARK PHASE 2 - PERMIT	10/25/2024
2	VOLTAGE PARK PHASE 2	02/03/2025
	REVISIONS	
3	VOLTAGE PARK PHASE 2	10/15/2025
	REVISIONS 2	

Drawn By:	Checked By:
RM	JL

MECHANICAL DIAGRAMS

M.VP2.601

Sheet

1 NYC UPS AIR-COOLED CHILLER PIPING DIAGRAM

M.VP2.601 NTS

2 NYC UPS AND BATTERY ROOM CONTROL DIAGRAM

M.VP2.601 NTS