



CLIENT


MINISO
200 S. LOS ROBLES AVE., SUITE 200
PASADENA, CA 91101
PROEJCT MANAGER: LEO LIU
EMAIL: LEO.L@MINISO-NA.COM
TEL: (213) 263-1639

CONSULTANT

ASTRA MAGNIFICA LLC.
1201 S HOPE ST,
LOS ANGELES CA 90015
PROJECT MANAGER: IAN MCQUEEN
OFFICE: 323-364-8869
EMAIL: IAN@ASTRAMAGNIFICA.ORG

PROJECT

MINISO
3500 S Meridian #325, Puyallup, WA 98373

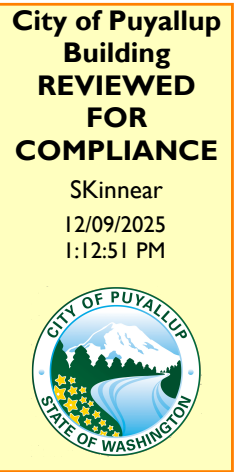

Approval of submitted plans is not an approval of omissions or oversights by this office or non compliance with any applicable regulations of local government. The contractor is responsible for making sure that the building complies with all applicable codes and regulations of the local government.

The approved construction plans, documents, and all engineering must be posted on the job at all inspections in a visible and readily accessible location.

Full sized legible color plans are required to be provided by the permittee on site for inspection.



STORE FRONT

PROJECT DIRECTORY

VICINITY MAP

[illegible]

SHEET INDEX

Separate Electrical Permit is required with the Washington State Department of Labor & Industries.
<https://lni.wa.gov/licensing-permits/electrical/electrical-permits-fees-and-inspections>
 or call for Licensing Information: 1-800-647-0982

SYMBOL LEGEND

ABBREVIATIONS

GENERAL NOTES

Project Owner:



MINISO

200 S. LOS ROBLES AVE., SUITE 200
PASADENA, CA 91101
PROEJCT MANAGER: LEO LIU

Consultant:



LOS ANGELES OFFICE
1201 S HOPE ST
LOS ANGELES CA 90015
TEL 323-364-8869

Project Address:

MINISO
3500 S Meridian #325, Puyallup, WA 98373

Stamp:

PRCTI20251541

No.	Date	Description

Sheet Title:

COVER SHEET

DRAWN BY: W

DWG. DATE: 10.17.25

REVIEWED BY: IM

PROJECT NUMBER:

TEMPLATE TYPE:

SHEET:

G001

Project Owner:



MINISO

200 S. LOS ROBLES AVE., SUITE 200
PASADENA, CA 91101
PROEJCT MANAGER: LEO LIU

Consultant:



LOS ANGELES OFFICE
1201 S HOPE ST
LOS ANGELES CA 90015
TEL 323-364-8869

Project Address:

MINISO
3500 S Meridian #325, Puyallup, WA 98373

Stamp:

PRCTI20251541

No.	Date	Description

Sheet Title:

FLOOR PLAN

DRAWN BY: W

DWG. DATE: 10.17.25


REVIEWED BY: IM

PROJECT NUMBER:

TEMPLATE TYPE:

SHEET:

A111

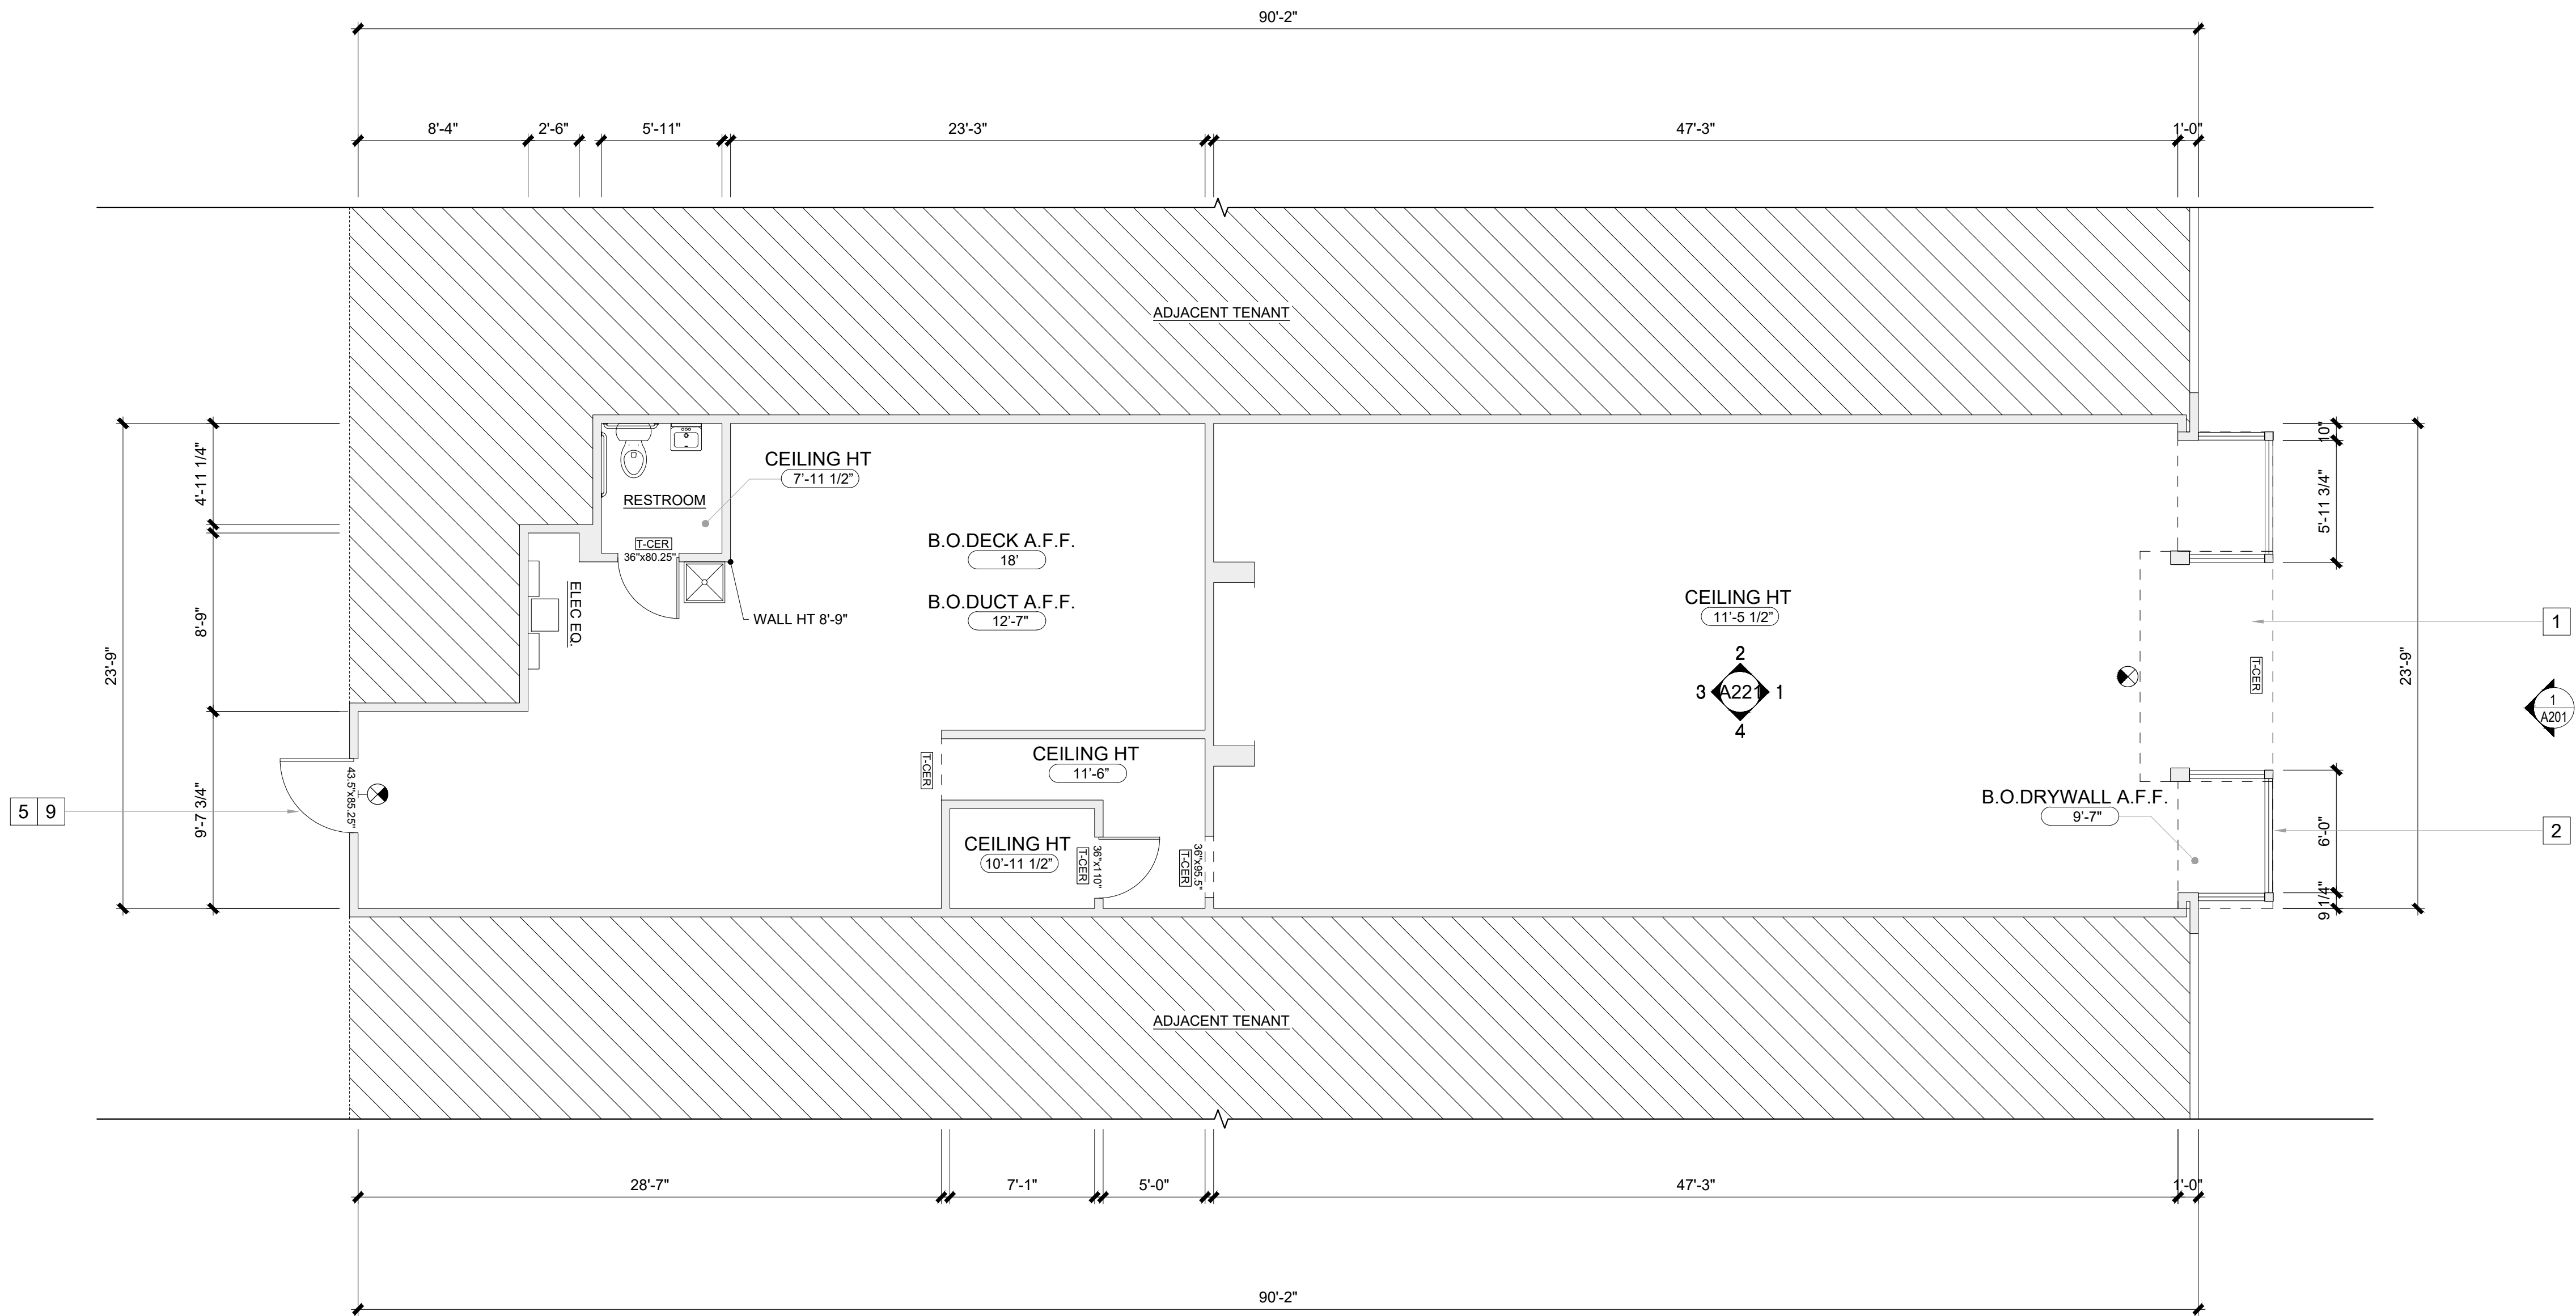

FLOOR PLAN (2,076 SQ.FT.)										SCALE	1
3/16"=1'-0"											
ELECTRICAL		FIRE / SAFETY		MECHANICAL		PLUMBING		FLOOR FINISH			
	SINGLE OUTLET		FIRE ALARM BELL / STROBE		THERMOSTAT		FLOOR DRAIN		CERAMIC TILE FLOORING		MAIN STOREFRONT
	DUPLEX OUTLET		FIRE ALARM PULL STATION		WATER HEATER		FLOOR SINK		CARPET FLOORING		STOREFRONT WINDOW SYSTEM
	QUADRAPLEX OUTLET		FIRE ALARM PULL STATION W/ STROBE		COMPRESSORS		CLEANOUT		VINYL COMPOSITE FLOORING		DEMISING WALL (WOOD, GYP BOARD)
	DUPLEX OUTLET - FLOOR		FIRE EXTINGUISHER		BOILERS		MOP SINK		TERRAZZO FLOORING		ELECTRICAL PANEL
	QUADRAPLEX OUTLET - FLOOR		FEC - SEMI-RECESSED		FURNACE		GAS METER		METAL FLOORING		REAR DOOR
	TELEPHONE JACK		FEC - RECESSED		HEAT PUMP				LINOLEUM FLOORING		CONCRETE/CMU WALL
	DATA JACK		FIRE ALARM CONTROL PANEL		BASEBOARD HEATERS				CONCRETE FLOORING		CASHIER COUNTER TABLE
	TELEPHONE AND DATA JACK		FIRE DEPARTMENT CONNECTION		RADIATOR HEATER						FLOOR TRANSITION
	ELEC PANEL - SURFACE MOUNTED		SIAMESE FIRE DEPARTMENT CONNECTION								ALARMED/EMERGENCY DOOR
	ELEC PANEL - FLUSH MOUNTED		FIRE RISER								BUILT-IN/MILLWORK
											SHELVING UNIT
											DISPLAY PLATFORM
											TV MONITOR
LEGEND										KEYNOTE	