

AGENCY REVIEW
09/14/2021


MERIDIAN POINTE APARTMENTS
RESIDENTIAL UNIT REHABILITATION
407 VALLEY AVE. N.E.
PUYALLUP, WA 98372
COVER SHEET

PROJECT

DATE

DESC.

APPROVAL STAMPS

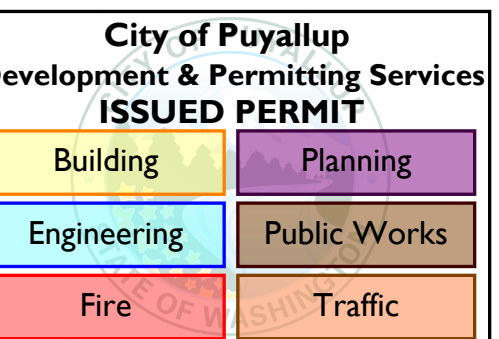

JOB NO.: 1922
ISSUE DATE: 09/14/2021
REVISED:
DRAWN BY: BM
SHEET

G-001

9/14/2021 9:48:15 AM

MERIDIAN POINTE APARTMENTS
RESIDENTIAL UNIT REHABILITATION

407 VALLEY AVE. N.E.
PUYALLUP, WA 98372

ABBREVIATIONS

Table of abbreviations including AB (ANCHOR BOLT), ACOUS (ACOUSTIC), ACT (ACOUSTICAL CEILING TILE), AFF (ABOVE FINISHED FLOOR), ALUM (ALUMINUM), ARCH (ARCHITECTURAL), AT (ACOUSTIC TILE), AUTO (AUTOMATIC), BITUM (BITUMINOUS), BL (BORROWED LIGHT), BLDG (BUILDING), BLK (BLOCK), BM (BEAM), BOT (BOTTOM), CAB (CABINET), CC (CUBICLE CURTAIN), CEM (CEMENT), CG (CORNER GUARD), CJ (CONTROL JOINT), CL (CENTER LINE), CLG (CEILING), CLOS (CLOSET), CLR (CLEAR), CMU (CONCRETE MASONRY UNIT), CO (CASED OPENING), COL (COLUMN), CONC (CONCRETE), CONT (CONTINUOUS), CONTR (CONTRACT OR CONTRACTOR), CSS (CLINICAL SERVICE SINK), CT (CERAMIC TILE), CTR (COUNTER), CTR (COUNTER FLASH), FLASH, DET (DETAIL), DIA (DIAMETER), DIM (DIMENSION), DIS (DISPENSER), DN (DOWN), DWG (DRAWING), EA (EACH), EJ (EXPANSION JOINT), EL (ELEVATION), ELEC (ELECTRIC), ELEV (ELEVATOR), EQ (EQUAL), EQUIP (EQUIPMENT), EXIST (EXISTING), FD (FLOOR DRAIN), FDN (FOUNDATION), FEC (FIRE EXTINGUISHER CABINET), FHC (FIRE HOSE CABINET), FHV (FIRE HOSE VALVE), FIN (FINISH), FL (FLOOR), FLASH (FLASHING), FR (FRAME), FT (FEET OR FOOT), FTG (FOOTING), FURR (FURRING), GA (GAUGE), GALV (GALVANIZED), GL (GLASS), GYP BD (GYPSUM BOARD), HC (HOLLOW CORE), HFS (HALF FULL SIZE), HM (HOLLOW METAL), HORIZ (HORIZONTAL), HT (HEIGHT), HTG (HEATING), ID (INSIDE DIAMETER), IN (INCH), INCL (INCLUDED), INFO (INFORMATION), INSUL (INSULATION), INT (INTERIOR), JC (JANITOR CLOSET), JT (JOINT), LAM (LAMINATED), LAT (LAY-IN ACOUSTICAL TILE), LAV (LAVATORY), LK (LOCKERS), MAS (MASONRY), MAT (MATERIAL), MAX (MAXIMUM), MECH (MECHANICAL), MED (MEDICINE), MET (METAL), MET STD (METAL STUD), MFR (MANUFACTURER), MIN (MINIMUM), MISC (MISCELLANEOUS), ML (METAL LATH), MTD (MOUNTED), MW (MILLWORK), N (NORTH), NIC (NOT IN CONTRACT), NO (NUMBER), NOM (NOMINAL), NTS (NOT TO SCALE), O2 (OXYGEN), OC (ON CENTER), OD (OUTSIDE DIAMETER), OH (OPPOSITE HAND), OPNG (OPENING), PL (PLATE), PLAS (PLASTIC LAMINATE), PLAS (PLASTER), PLMB (PLUMBING), PTN (PARTITION), R (RUBBER), RAD (RADIUS), RD (ROOF DRAIN), RECP (RECEPTACLE), REF (REFERENCE), REFRIG (REFRIGERATOR), REINF (REINFORCE), REOD (REQUIRED), RESIL (RESILIENT), REV (REVISION), RM (ROOM), S (SLIDE), S/S (SERVICE SINK), SC (SOLID CORE), SCH (SCHEDULE), SECT (SECTION), SERV (SERVICE), SHT (SHEET), SIM (SIMILAR), SL (SLIDING), SM (SHEET METAL), SNK (SINK), SPEC (SPECIFICATIONS), SQ (SQUARE), SS (STAINLESS STEEL), STD (STANDARD), STL (STEEL), STORE (STORAGE), STR (STRUCTURAL), SUSP (SUSPEND), T/C (TOP OF CURB), TB (TACKBOARD), TEL (TELEPHONE), THK (THICK), TK (THICKNESS), TOIL (TOILET), TRANS (TRANSFORMER), TV (TELEVISION), TYP (TYPICAL), UL (UNDERWRITERS LABORATORIES), UNO (UNLESS OTHERWISE NOTED), V (VINYL), VB (VIEW BOXES), VCT (VINYL COMPOSITION TILE), VERT (VERTICAL), VEST (VESTIBULE), VIF (VERIFY IN FIELD), W (WIDTH), W / (WITH), W / O (WITHOUT), WC (WHEELCHAIR), WC (WATER CLOSET), WD (WOOD), WP (WATERPROOF), WT (WEIGHT), WWF (WIELDED WIRE FABRIC)

ABBREVIATIONS

Table of abbreviations including MAT (MATERIAL), MAX (MAXIMUM), MECH (MECHANICAL), MED (MEDICINE), MET (METAL), MET STD (METAL STUD), MFR (MANUFACTURER), MIN (MINIMUM), MISC (MISCELLANEOUS), ML (METAL LATH), MTD (MOUNTED), MW (MILLWORK), N (NORTH), NIC (NOT IN CONTRACT), NO (NUMBER), NOM (NOMINAL), NTS (NOT TO SCALE), O2 (OXYGEN), OC (ON CENTER), OD (OUTSIDE DIAMETER), OH (OPPOSITE HAND), OPNG (OPENING), PL (PLATE), PLAS (PLASTIC LAMINATE), PLAS (PLASTER), PLMB (PLUMBING), PTN (PARTITION), R (RUBBER), RAD (RADIUS), RD (ROOF DRAIN), RECP (RECEPTACLE), REF (REFERENCE), REFRIG (REFRIGERATOR), REINF (REINFORCE), REOD (REQUIRED), RESIL (RESILIENT), REV (REVISION), RM (ROOM), S (SLIDE), S/S (SERVICE SINK), SC (SOLID CORE), SCH (SCHEDULE), SECT (SECTION), SERV (SERVICE), SHT (SHEET), SIM (SIMILAR), SL (SLIDING), SM (SHEET METAL), SNK (SINK), SPEC (SPECIFICATIONS), SQ (SQUARE), SS (STAINLESS STEEL), STD (STANDARD), STL (STEEL), STORE (STORAGE), STR (STRUCTURAL), SUSP (SUSPEND), T/C (TOP OF CURB), TB (TACKBOARD), TEL (TELEPHONE), THK (THICK), TK (THICKNESS), TOIL (TOILET), TRANS (TRANSFORMER), TV (TELEVISION), TYP (TYPICAL), UL (UNDERWRITERS LABORATORIES), UNO (UNLESS OTHERWISE NOTED), V (VINYL), VB (VIEW BOXES), VCT (VINYL COMPOSITION TILE), VERT (VERTICAL), VEST (VESTIBULE), VIF (VERIFY IN FIELD), W (WIDTH), W / (WITH), W / O (WITHOUT), WC (WHEELCHAIR), WC (WATER CLOSET), WD (WOOD), WP (WATERPROOF), WT (WEIGHT), WWF (WIELDED WIRE FABRIC)

PROJECT INFORMATION

Table with 2 columns: PROJECT SCOPE, UNIT REHABILITATION; PARCEL NUMBER, 0420222056, 0420222055, 0420226014, 0420226015, 0420226016, 0420222051, 0420226013; PROJECT LOCATION, 407 VALLEY AVE N.E., PUYALLUP, WA 98372; SITE ZONING, RM-20; HIGH DENSITY MULTI-FAMILY RESIDENTIAL; ZONING JURISDICTION, CITY OF PUYALLUP; SITE USE, R-2, TYPE VB; LANDSCAPE CATEGORY; SET BACK - FRONTAGE, N/A; SET BACK - SIDE, N/A; SET BACK - REAR, N/A; SITE AREA, N/A; LOT COVERAGE TOTAL, N/A; IMPERVIOUS SURFACE COVERAGE, N/A; UNIT DENSITY, N/A; BUILDING HEIGHT LIMIT PER ZONING, N/A

SCOPE OF WORK:

THE SCOPE OF WORK COMPRISES OF THE REMOVAL AND REPLACEMENT OF EXISTING APPLIANCES, FIXTURES AND FLOORING THROUGHOUT. THE FOLLOWING ITEMS INCLUDE:

- 1) REMOVE AND REPLACE EXISTING GRAY POLY WATER LINES WITH WIRSBO/PEX PIPING WITHIN THE UNITS. ALL NEW HOT WATER LINES TO BE INSULATED. DRYWALL REMOVAL WHERE GRAY POLY WATER LINES ARE LOCATED AND/OR NEW PIPING TO BE INSTALLED.
2) EXISTING COPPER PIPING, WASTE LINES, FIRE SPRINKLERS AND HEAD, AND WATER SUPPLY LINE TO BUILDINGS TO REMAIN.
3) WHERE DRYWALL IS REMOVED WITHIN A RATED ASSEMBLY, THE DRYWALL SHALL BE REPLACED WITH 5/8" TYPE X DRYWALL (CERTAINTED OR EQUAL) AND FIRESTOP SEALANT (STI WF300) WILL BE APPLIED AT ANY PENETRATIONS THROUGH THE RATED ASSEMBLIES.
4) REPLACE EXISTING CABINETS LIKE FOR LIKE AS WELL AS COUNTERTOPS. NO CHANGE TO EXISTING ELEVATION OF CABINETS FOR STANDARD UNITS. EXISTING ADA UNITS TO REMAIN ACCESSIBLE WHERE THE TOP OF SINK RIM WILL NOT EXCEED 34" FROM FINISH FLOOR. REMOVABLE DOORS AND BOTTOMS SHELF/TOE KICKS TO PROVIDE UNDER SINK AND WORKSTATION FOR 60" MIN CLEARANCE (WIDTH) AND 27" MIN. CLEARANCE UNDER SINK. EXISTING WALLS WILL NOT BE MOVED WITH THE RENOVATION. TO THE EXTENT POSSIBLE, BEST EFFORTS WILL BE MADE WITHIN EXISTING KITCHEN AND BATHROOM FOOTPRINTS TO MEET CURRENT ADA STANDARDS.
5) REPLACE EXISTING FLOORING MATERIAL LIKE FOR LIKE.
6) REPLACE MILLWORK, INTERIOR DOORS AND HARDWARE LIKE FOR LIKE.
7) REPLACE EXISTING PLUMBING FIXTURES INCLUDING DISPOSALS. NO CHANGE TO EXISTING LOCATIONS OR COUNT.
8) REPLACE HOT WATER TANKS INCLUDING SEISMIC STRAP AND EXPANSION TANK.
9) REPLACE LAVATORIES.
10) REPLACE AUTO WASHER BOX ALL LOCATED WITHIN THE INTERIOR UNIT WALLS.
11) REPLACE ANGLE STOPS
12) REPLACE SHOWER VALVE INCLUDING RISER TO HEAD AND STUB TO SPOUT.
13) REPLACE PLASTIC LAMINATE TUB SURROUND WITH LIKE FOR LIKE.
14) REPLACE ALL EXISTING ELECTRICAL DEVICES.
15) REPLACE EXISTING BATHROOM FANS WITH DUAL SPEED EXHAUST FANS. NO NEW DUCTWORK; EXISTING DUCTWORK AND CEILING TO REMAIN.
16) REPLACE APPLIANCES.
17) PAINT INTERIOR UNITS.
18) REPLACE EXISTING SMOKE & CARBON MONOXIDE DETECTOR IN ALL UNIT HALLWAYS. ADD SELF-CONTAINED, BATTERY OPERATED SMOKE ALARMS IN ALL UNIT BEDROOMS.


SHEET INDEX

Table with 4 columns: SHEET #, SHEET NAME, REV. #, REV. DATE. Rows include G-001 COVER SHEET, 5.ARCHITECTURAL, A-100 OVERALL SITE PLAN - PHASE I, A-101 OVERALL SITE PLAN - PHASE II, A-213 ENLARGED UNIT PLAN - 1 BED/1 BATH, A-214 ENLARGED UNIT PLAN - 2 BED/1 BATH, A-215 ENLARGED UNIT PLAN - 2 BED/2 BATH, A-216 ENLARGED UNIT PLAN - 3 BED/2 BATH

THE APPROVED CONSTRUCTION PLANS, DOCUMENTS AND ALL ENGINEERING MUST BE POSTED ON THE JOB AT ALL INSPECTIONS IN A VISIBLE AND READILY ACCESSIBLE LOCATION.

FULL SIZED LEDGIBLE COLOR PLANS ARE REQUIRED TO BE PROVIDED BY THE PERMITEE ON SITE FOR INSPECTION

Approval of submitted plans is not an approval of omissions or oversights by this office or noncompliance with any applicable regulations of local government. The contractor is responsible for making sure that the building complies with all applicable codes and regulations of the local government.

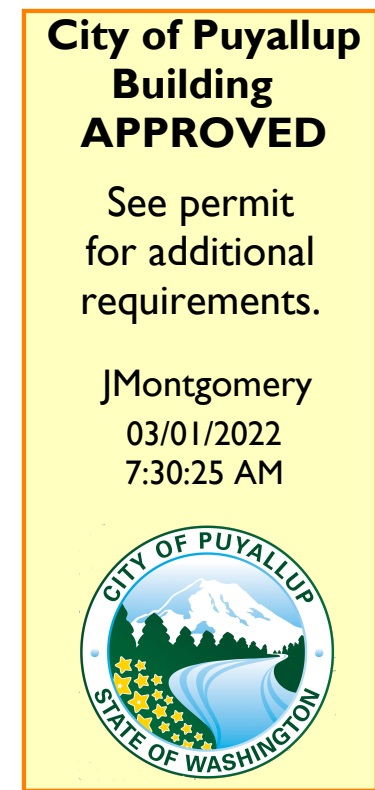

REVISIONS

Table with 3 columns: #, CURRENT REVISION DESCRIPTION, REV. DATE


MATERIAL LEGEND


Table with 2 columns: Material Name, Material Pattern. Includes EARTH, AGGREGATE / POROUS, CONCRETE, CEMENT / CONCRETE UNDERLAYMENT, CONCRETE ASPHALT, RIGID INSULATION, BATT INSULATION

SYMBOLS LEGEND

Table with 2 columns: Symbol, Description. Includes Building Section (SIM A101), Callouts (SIM A101), Exterior Elevations (Ref 1 A101), Interior Elevations (1/1/1)


VICINITY MAP

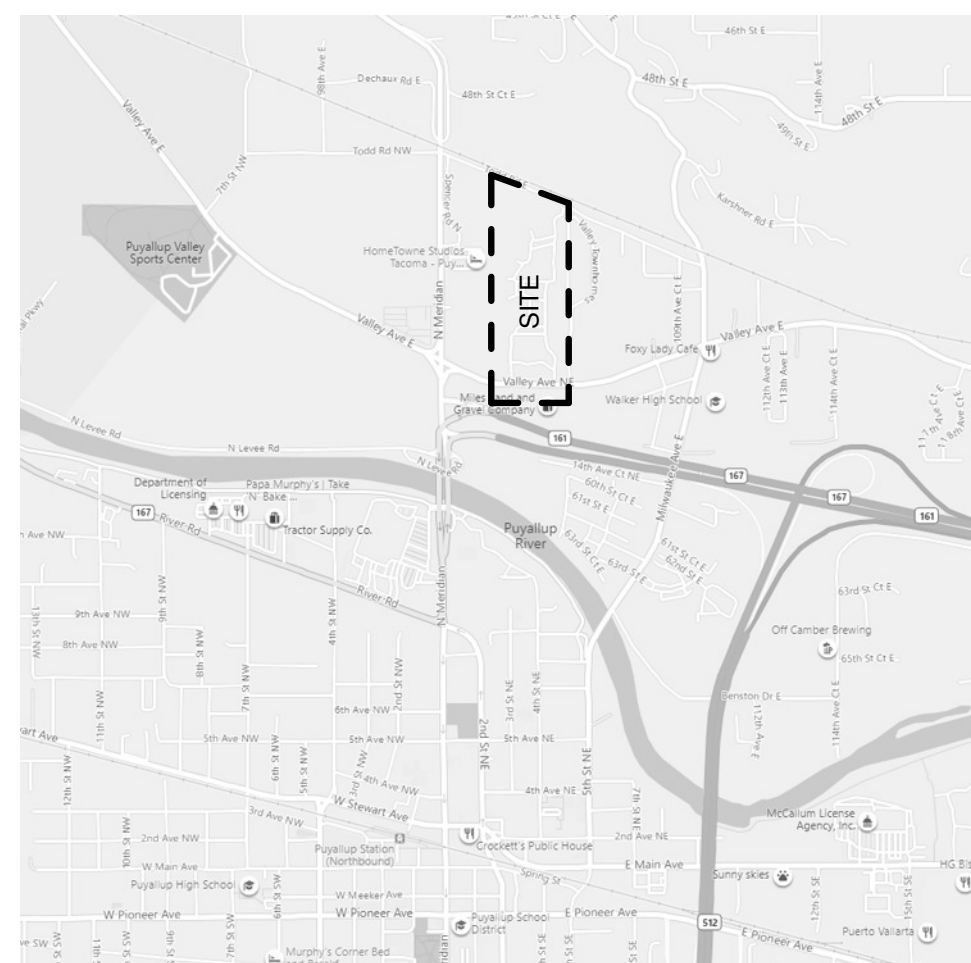

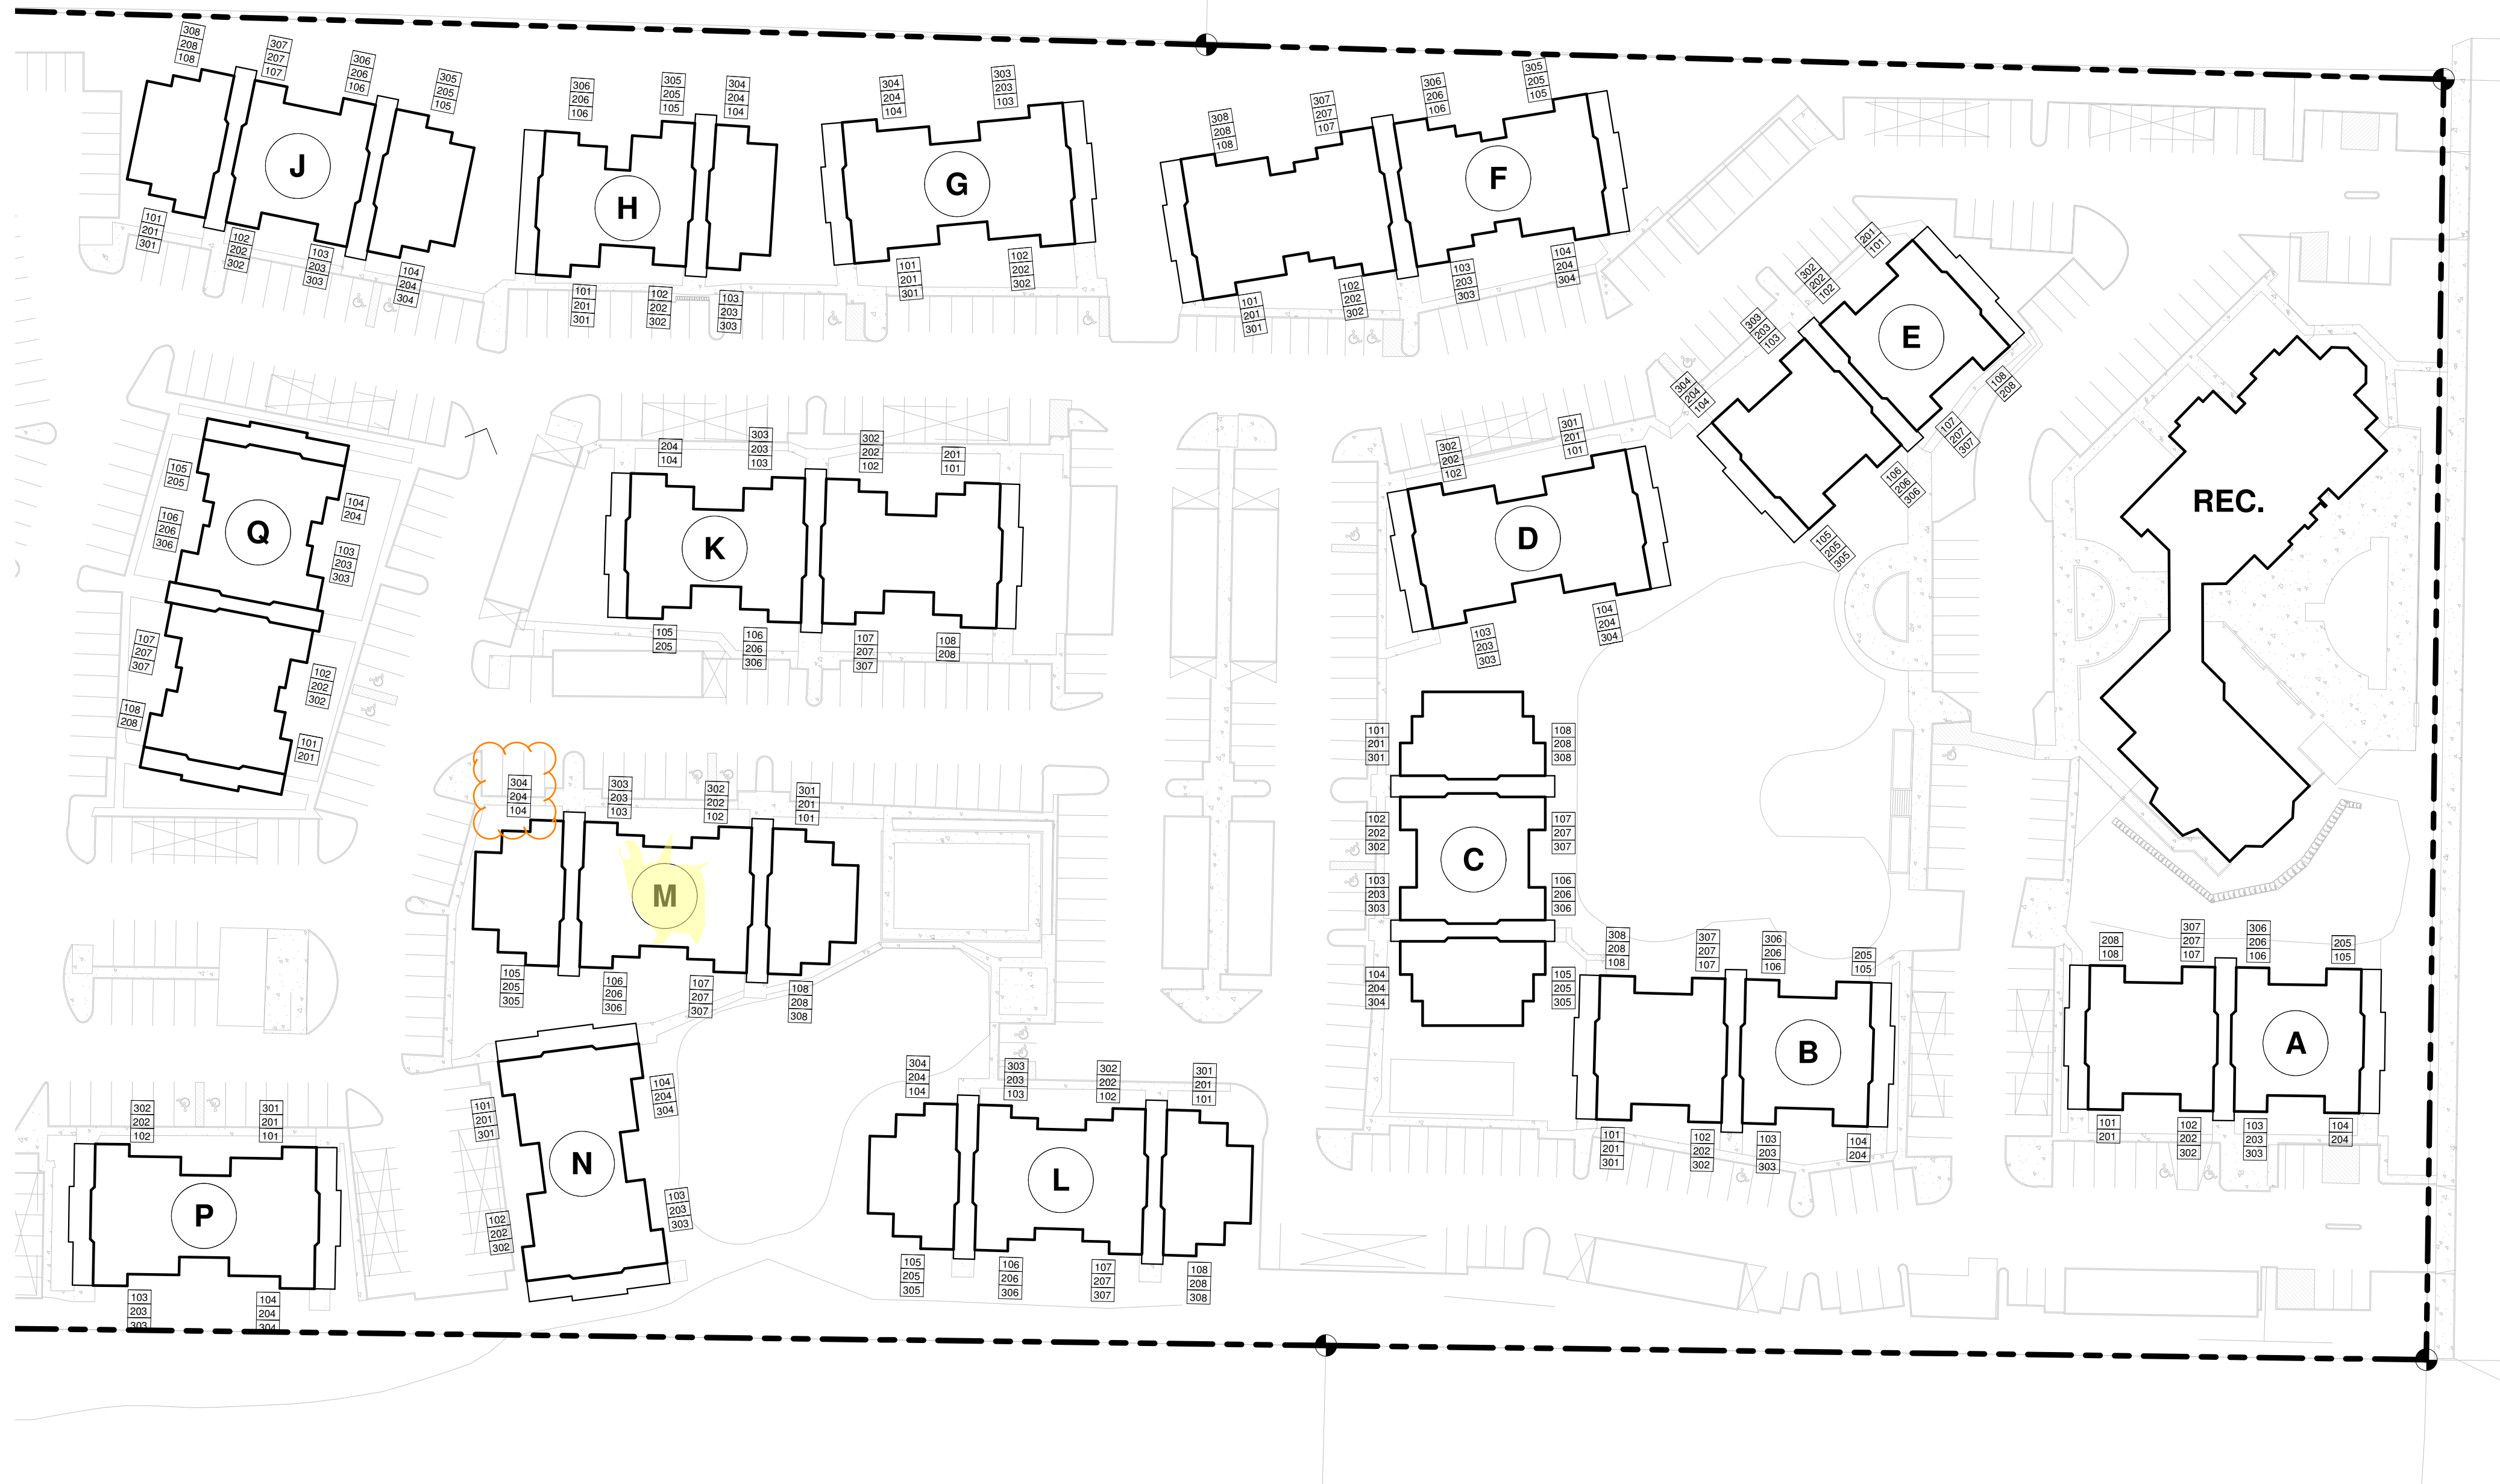

OVERALL SITE PLAN - PHASE I

1" = 50'-0"

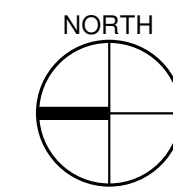

BUILDING 'A' UNITS

UNIT TYPE	NET AREA	COUNT
BUILDING 'A'		
1 BED / 1 BATH	683 SF	20
		20

BUILDING 'B' UNITS

UNIT TYPE	NET AREA	COUNT
BUILDING 'B'		
1 BED / 1 BATH	683 SF	22
		22

BUILDING 'C' UNITS

UNIT TYPE	NET AREA	COUNT
BUILDING 'C'		
1 BED / 1 BATH	683 SF	10
1 BED / 1 BATH ADA	683 SF	2
2 BED / 2 BATH	899 SF	12
		24

BUILDING 'D' UNITS

UNIT TYPE	NET AREA	COUNT
BUILDING 'D'		
3 BED / 2 BATH	1,121 SF	10
3 BED / 2 BATH ADA	1,121 SF	2
		12

BUILDING 'E' UNITS

UNIT TYPE	NET AREA	COUNT
BUILDING 'E'		
1 BED / 1 BATH	683 SF	21
1 BED / 1 BATH ADA	683 SF	1
		22

BUILDING 'F' UNITS

UNIT TYPE	NET AREA	COUNT
BUILDING 'F'		
2 BED / 2 BATH	899 SF	12
3 BED / 2 BATH	1,121 SF	12
		24

BUILDING 'G' UNITS

UNIT TYPE	NET AREA	COUNT
BUILDING 'G'		
3 BED / 2 BATH	1,121 SF	12
		12

BUILDING 'H' UNITS

UNIT TYPE	NET AREA	COUNT
BUILDING 'H'		
1 BED / 1 BATH	683 SF	12
2 BED / 1 BATH	868 SF	6
		18

BUILDING 'J' UNITS

UNIT TYPE	NET AREA	COUNT
BUILDING 'J'		
1 BED / 1 BATH	683 SF	12
2 BED / 2 BATH	899 SF	10
2 BED / 2 BATH ADA	899 SF	2
		24

BUILDING 'K' UNITS

UNIT TYPE	NET AREA	COUNT
BUILDING 'K'		
2 BED / 1 BATH	868 SF	20
		20

BUILDING 'L' UNITS

UNIT TYPE	NET AREA	COUNT
BUILDING 'L'		
2 BED / 1 BATH	868 SF	12
2 BED / 2 BATH	899 SF	12
		24

BUILDING 'M' UNITS

UNIT TYPE	NET AREA	COUNT
BUILDING 'M'		
2 BED / 1 BATH	868 SF	12
2 BED / 2 BATH	899 SF	10
2 BED / 2 BATH ADA	899 SF	2
		24

BUILDING 'N' UNITS

UNIT TYPE	NET AREA	COUNT
BUILDING 'N'		
3 BED / 2 BATH	1,121 SF	12
		12

BUILDING 'P' UNITS


UNIT TYPE	NET AREA	COUNT
BUILDING 'P'		
3 BED / 2 BATH	1,121 SF	10
3 BED / 2 BATH ADA	1,121 SF	2
		12

BUILDING 'Q' UNITS

UNIT TYPE	NET AREA	COUNT
BUILDING 'Q'		
1 BED / 1 BATH	683 SF	10
1 BED / 1 BATH ADA	683 SF	2
2 BED / 2 BATH	899 SF	8
		20

R D + A

ROSS DECKMAN & ASSOCIATES INC.
 207 FOURTH AVENUE SOUTHEAST
 PUYALLUP, WASHINGTON 98372
 PHONE: 253.840.9405
 FAX: 253.840.9503

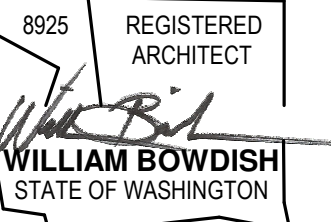

AGENCY REVIEW

09/14/2021

PROJECT
MERIDIAN POINTE APARTMENTS
RESIDENTIAL UNIT REHABILITATION
 407 VALLEY AVE. N.E.
 PUYALLUP, WA 98372
OVERALL SITE PLAN - PHASE I

#	DATE	DESC.

APPROVAL STAMPS

City of Puyallup
 Development & Permitting Services
ISSUED PERMIT



<input checked="checked" type="checkbox"/> Building	<input checked="checked" type="checkbox"/> Planning
<input checked="checked" type="checkbox"/> Engineering	<input checked="checked" type="checkbox"/> Public Works
<input checked="checked" type="checkbox"/> Fire	<input checked="checked" type="checkbox"/> Traffic

JOB NO.: 1922
 ISSUE DATE: 09/14/2021
 REVISED:
 DRAWN BY: BM
 SHEET

A-100

9/14/2021 9:47:51 AM

P:\1922 Meridian Poins Apartments\05-Drawings\1922 Meridian Poins Apartments Units.rvt

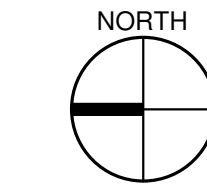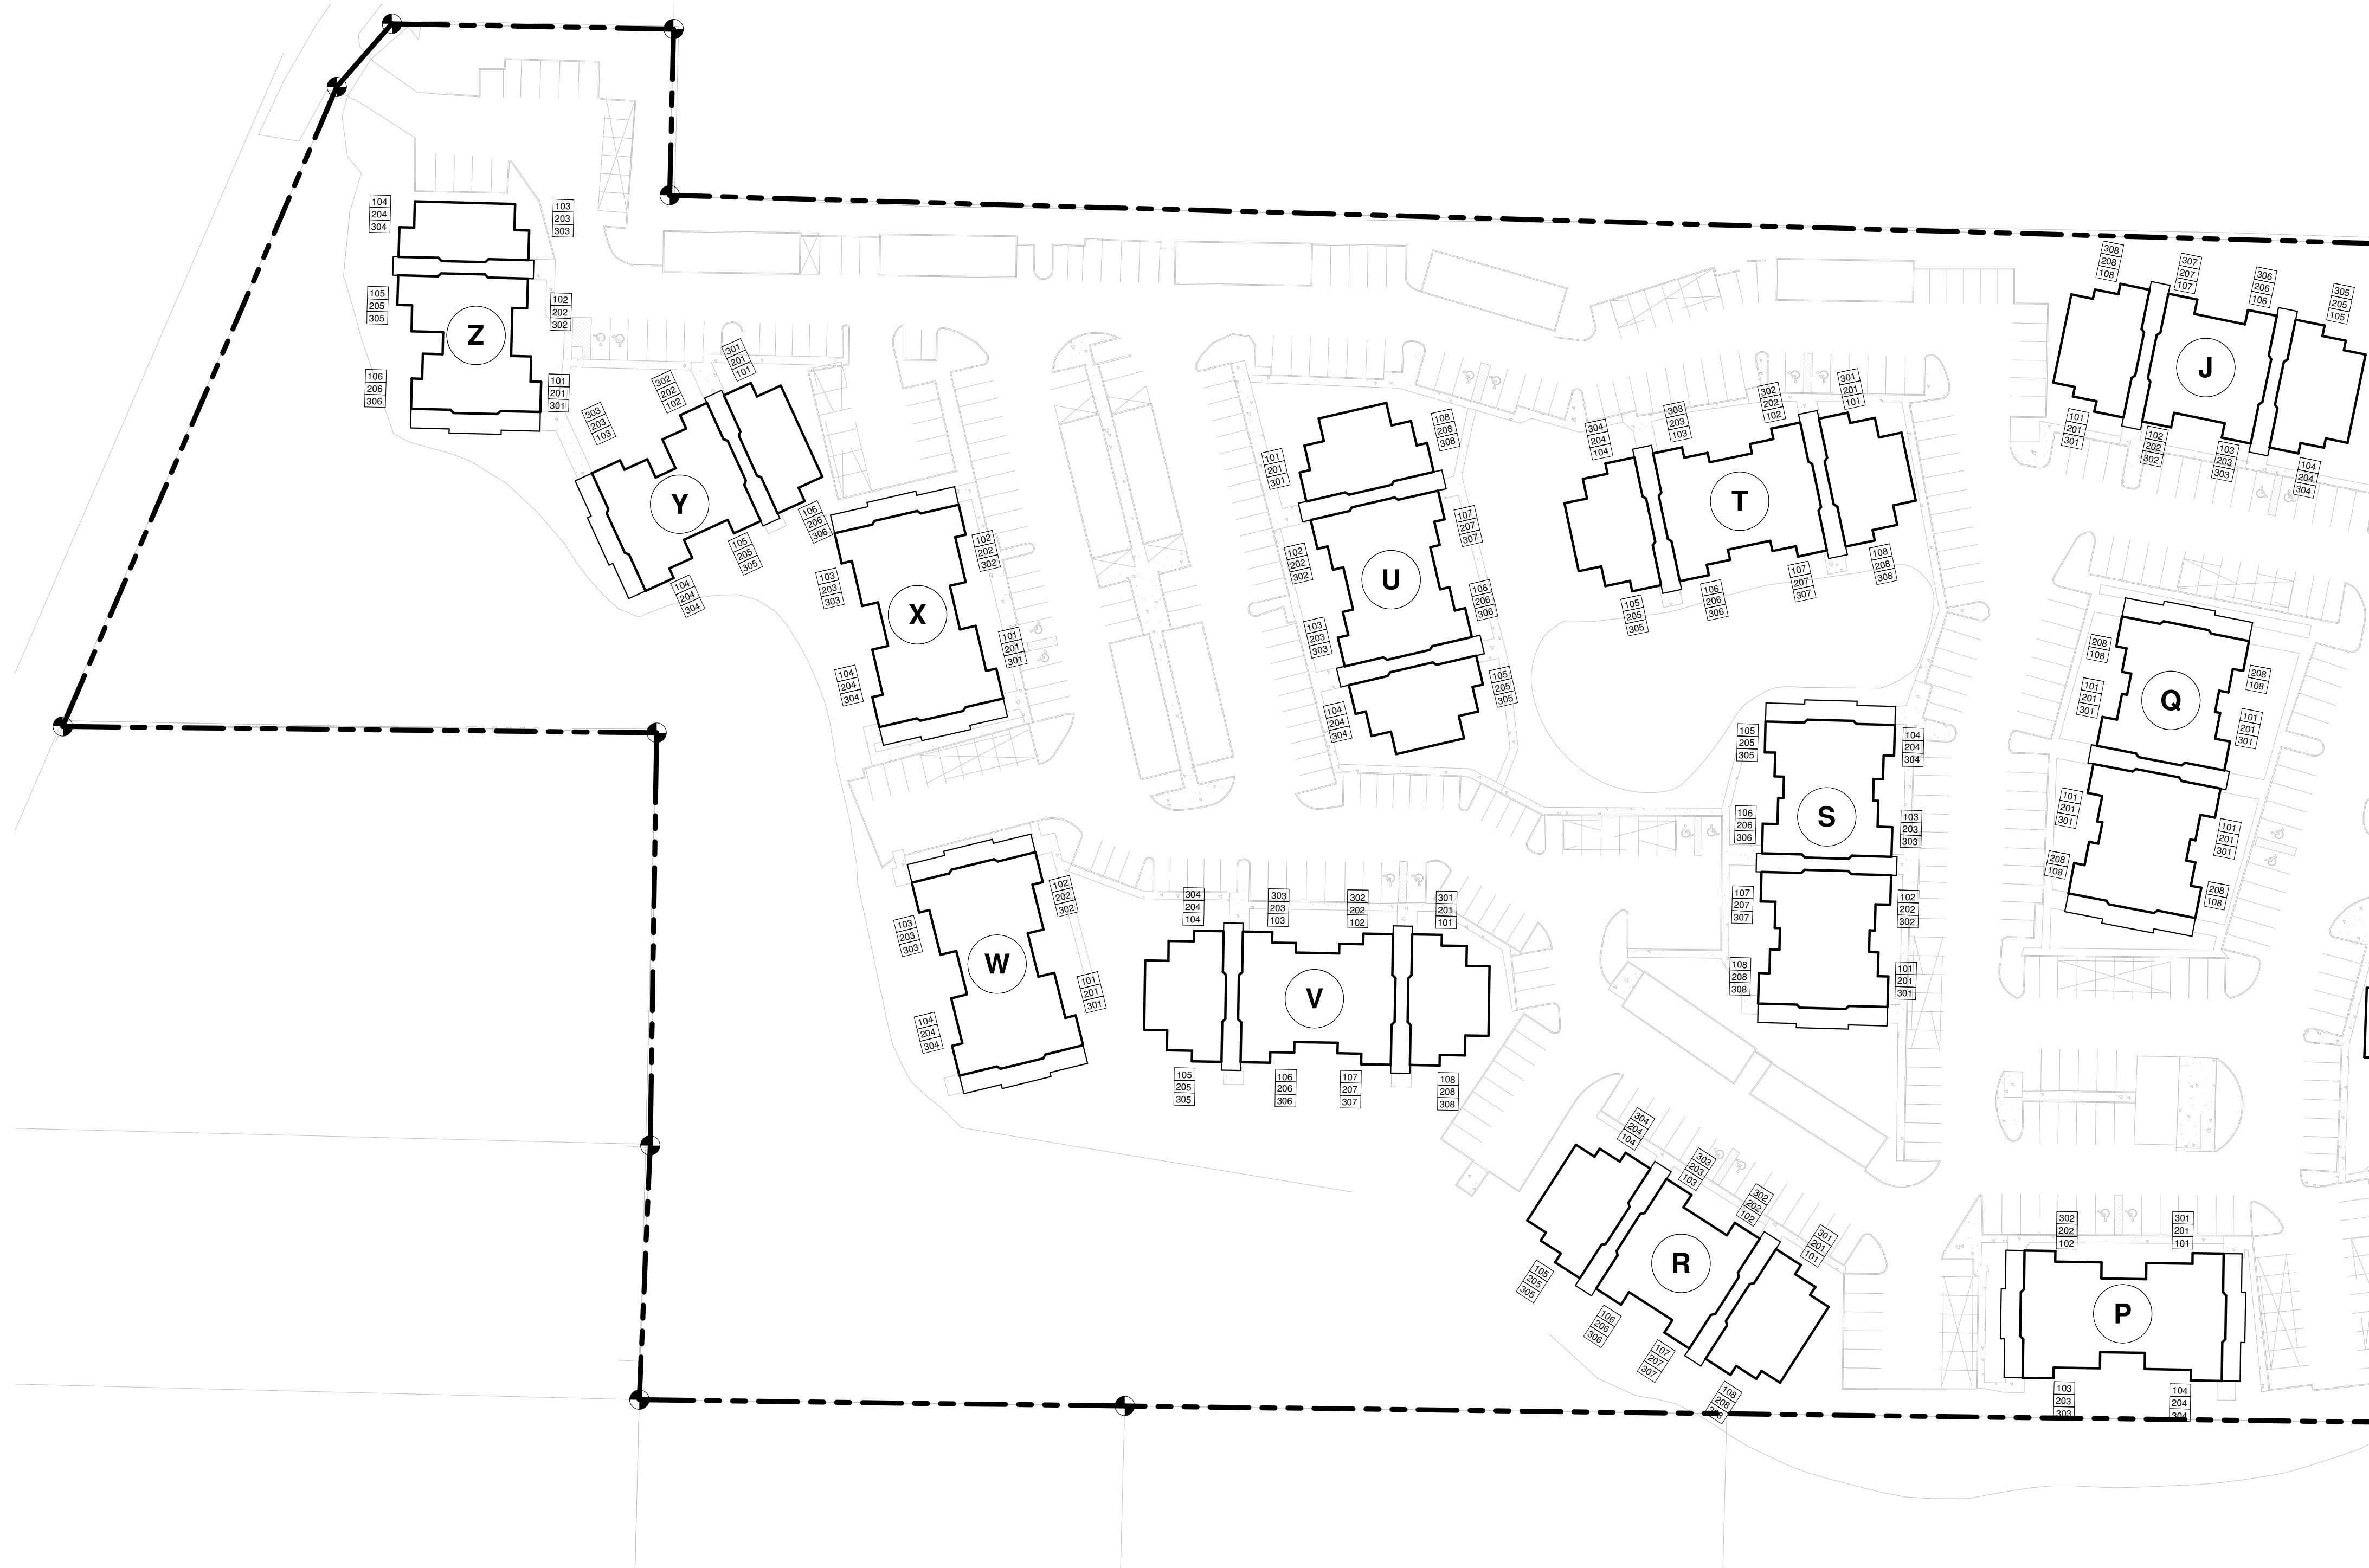

OVERALL SITE PLAN - PHASE II

1" = 50'-0"

BUILDING 'J' UNITS PRCT120220125

UNIT TYPE	NET AREA	COUNT
BUILDING 'J'		
1 BED / 1 BATH	683 SF	12
2 BED / 2 BATH	899 SF	10
2 BED / 2 BATH ADA	899 SF	2
		24

BUILDING 'P' UNITS

UNIT TYPE	NET AREA	COUNT
BUILDING 'P'		
3 BED / 2 BATH	1,121 SF	10
3 BED / 2 BATH ADA	1,121 SF	2
		12

BUILDING 'Q' UNITS

UNIT TYPE	NET AREA	COUNT
BUILDING 'Q'		
1 BED / 1 BATH	683 SF	10
1 BED / 1 BATH ADA	683 SF	2
2 BED / 2 BATH	899 SF	8
		20

BUILDING 'R' UNITS

UNIT TYPE	NET AREA	COUNT
BUILDING 'R'		
1 BED / 1 BATH	683 SF	10
1 BED / 1 BATH ADA	683 SF	2
2 BED / 2 BATH	899 SF	12
		24

BUILDING 'S' UNITS

UNIT TYPE	NET AREA	COUNT
BUILDING 'S'		
1 BED / 1 BATH	683 SF	11
1 BED / 1 BATH ADA	683 SF	1
2 BED / 2 BATH	899 SF	11
2 BED / 2 BATH ADA	899 SF	1
		24

BUILDING 'T' UNITS

UNIT TYPE	NET AREA	COUNT
BUILDING 'T'		
2 BED / 1 BATH	868 SF	12
2 BED / 2 BATH	899 SF	10
2 BED / 2 BATH ADA	899 SF	2
		24

BUILDING 'U' UNITS

UNIT TYPE	NET AREA	COUNT
BUILDING 'U'		
2 BED / 1 BATH	868 SF	12
2 BED / 2 BATH	899 SF	10
2 BED / 2 BATH ADA	899 SF	2
		24

BUILDING 'V' UNITS

UNIT TYPE	NET AREA	COUNT
BUILDING 'V'		
2 BED / 1 BATH	868 SF	12
2 BED / 2 BATH	899 SF	10
2 BED / 2 BATH ADA	899 SF	2
		24

BUILDING 'W' UNITS

UNIT TYPE	NET AREA	COUNT
BUILDING 'W'		
3 BED / 2 BATH	1,121 SF	12
		12

BUILDING 'X' UNITS

UNIT TYPE	NET AREA	COUNT
BUILDING 'X'		
3 BED / 2 BATH	1,121 SF	11
3 BED / 2 BATH ADA	1,121 SF	1
		12

BUILDING 'Y' UNITS

UNIT TYPE	NET AREA	COUNT
BUILDING 'Y'		
1 BED / 1 BATH	683 SF	12
2 BED / 1 BATH	868 SF	6
		18

BUILDING 'Z' UNITS


UNIT TYPE	NET AREA	COUNT
BUILDING 'Z'		
1 BED / 1 BATH	683 SF	12
2 BED / 1 BATH	868 SF	6
		18

R D + A

ROSS DECKMAN & ASSOCIATES INC.

207 FOURTH AVENUE, SOUTHEAST,
PUYALLUP, WASHINGTON 98372

PHONE: 253.840.9405
FAX: 253.840.9503

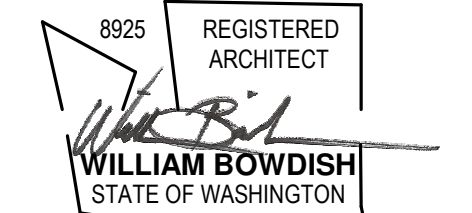

AGENCY REVIEW

09/14/2021

PROJECT
MERIDIAN POINTE APARTMENTS
RESIDENTIAL UNIT REHABILITATION
407 VALLEY AVE. N.E.
PUYALLUP, WA 98372
OVERALL SITE PLAN - PHASE II


PROJECT

DATE

DESC.

#

APPROVAL STAMPS

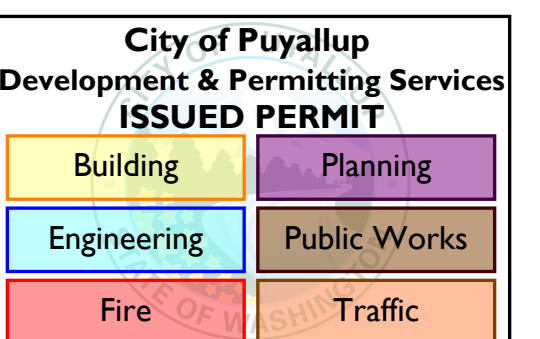

JOB NO.: 1922
ISSUE DATE: 09/14/2021
REVISED:
DRAWN BY: BM
SHEET

A-101


9/14/2021 9:47:56 AM

#	DATE


APPROVAL STAMPS

City of Puyallup	
Development & Permitting Services	
ISSUED PERMIT	
Building	Planning
Engineering	Public Works
Fire	Traffic


JOB NO.:	1922
ISSUE DATE:	09/14/2021
REVISED:	
DRAWN BY:	BM
SHEET	

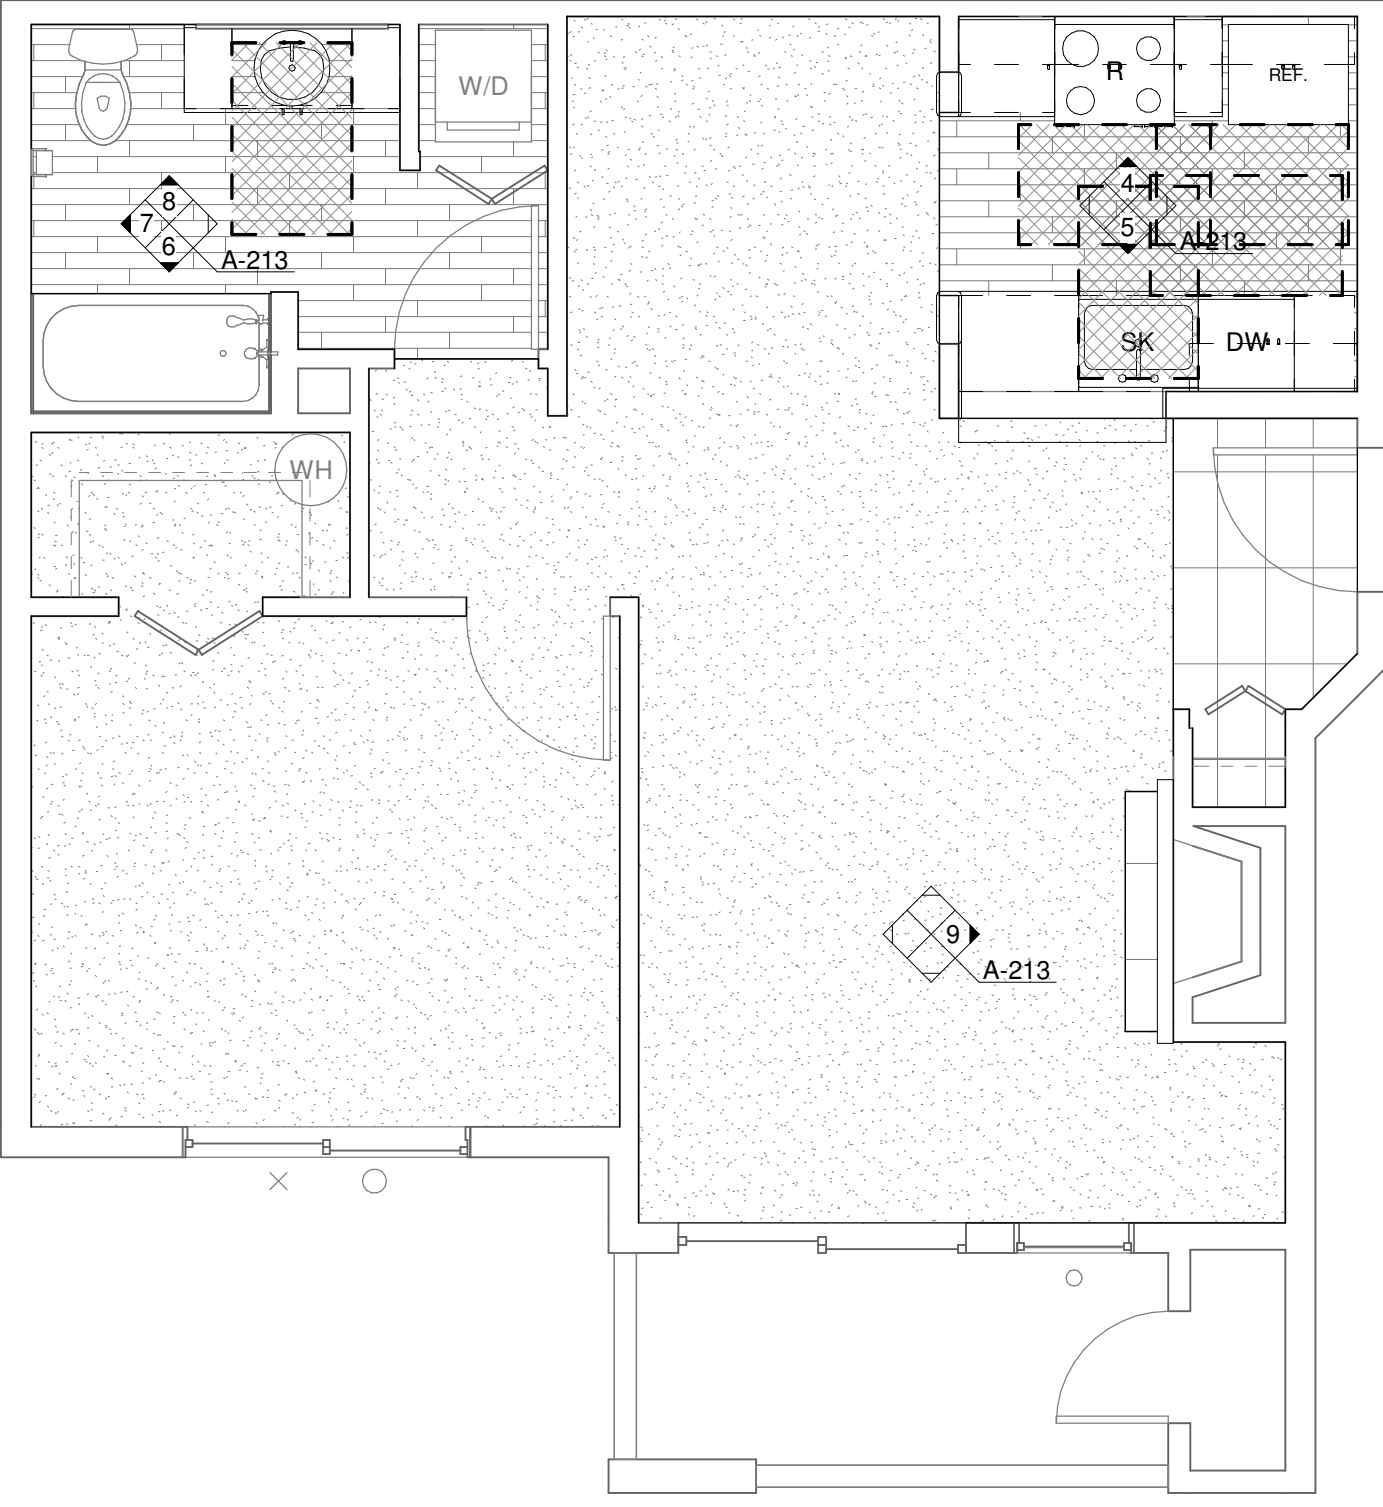

2 ENLARGED UNIT PLAN - 1 BED/1 BATH (ADA)
1/4" = 1'-0"

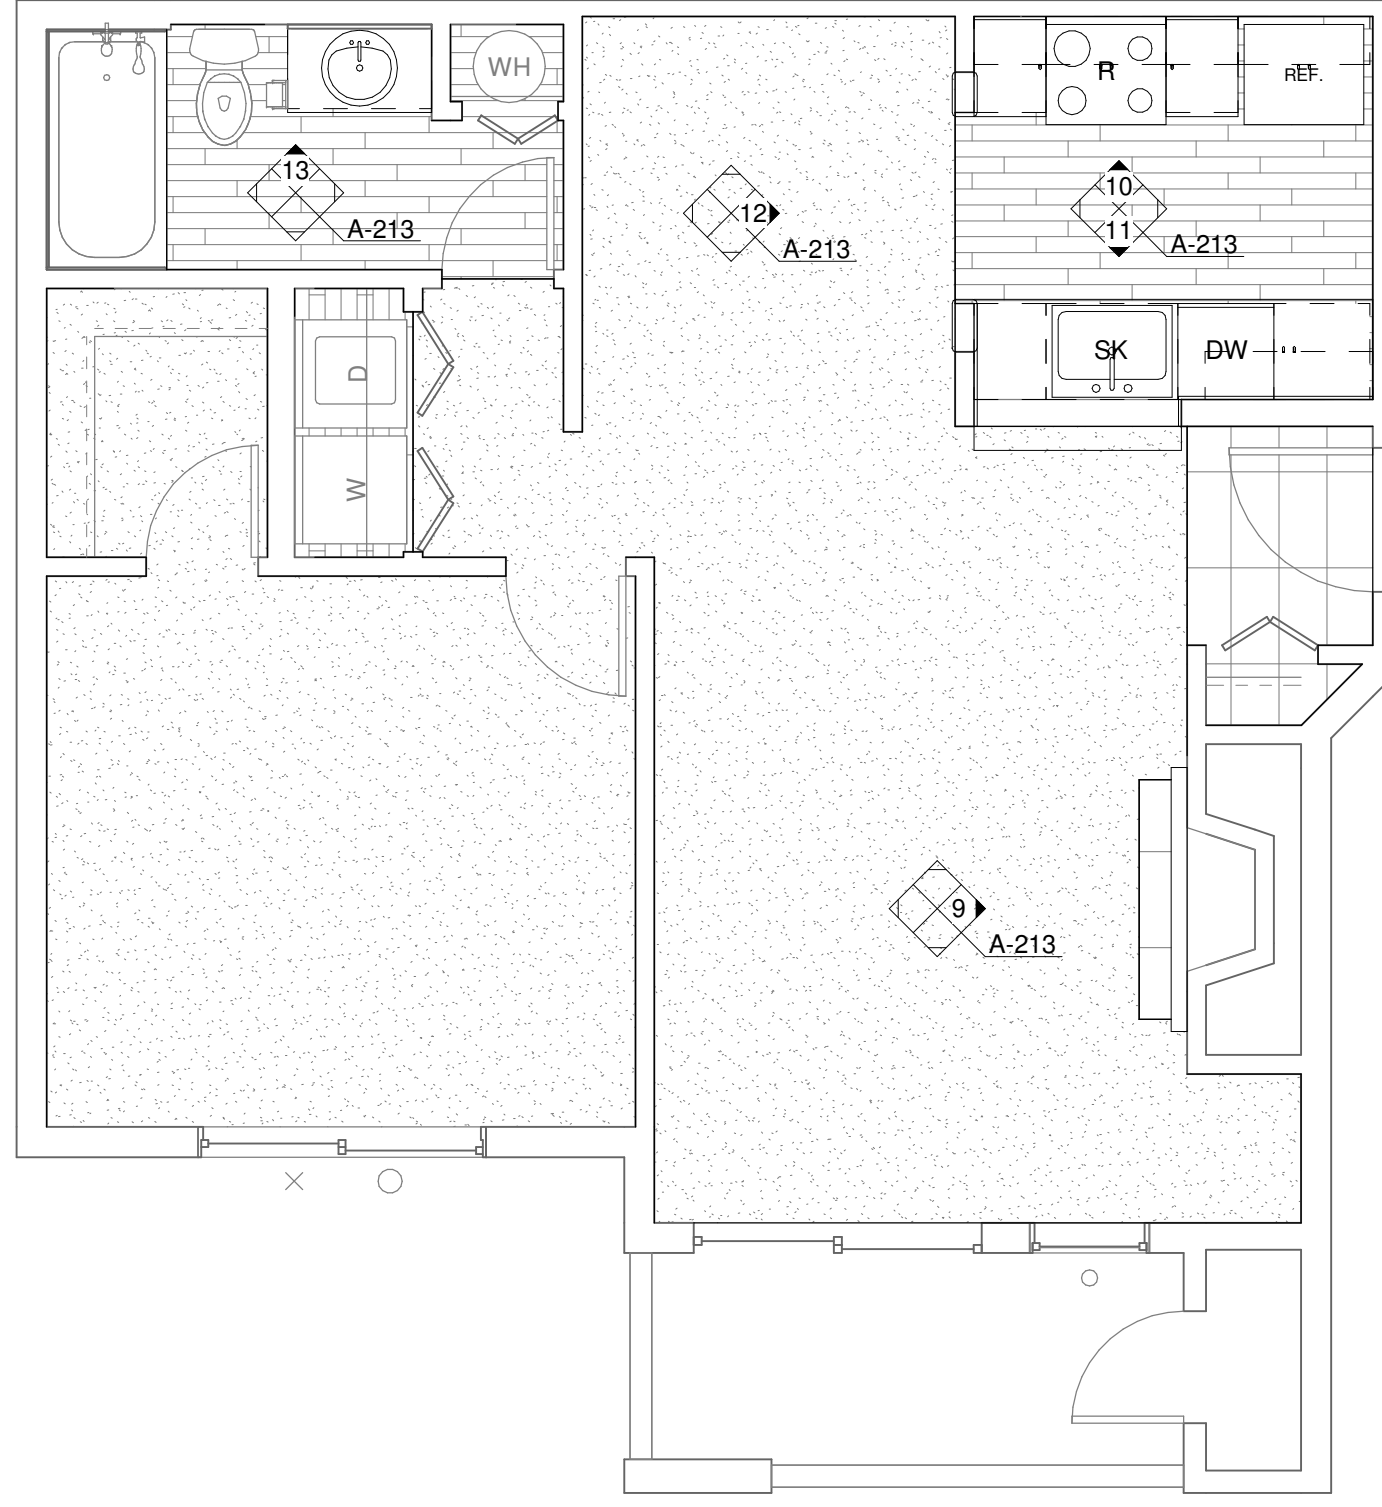

3 ENLARGED UNIT PLAN - 1 BED/1 BATH (TYP)
1/4" = 1'-0"

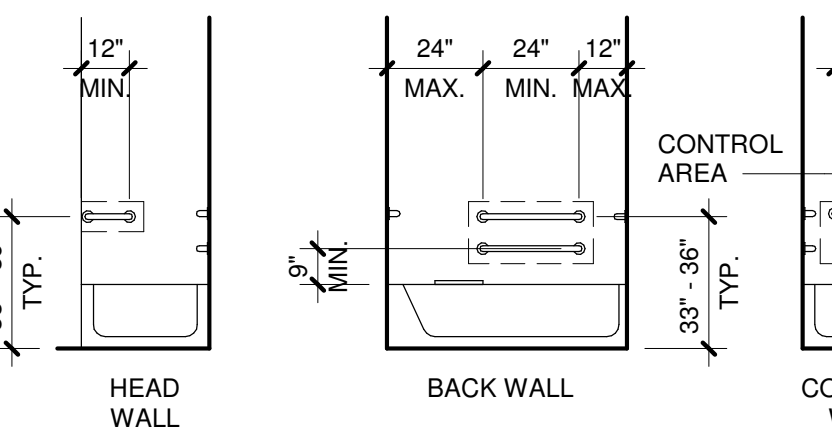


GRAB BARS:
INSTALL GRAB BARS 33" MIN & 36" MAX AFF.
GRAB BARS SHALL COMPLY WITH AND MEET
THE STRUCTURAL STRENGTH REQUIREMENTS
OF ANSI SEC. 609.8. LOCATE GRAB BARS PER
ANSI SEC. 607.4.2.


SEAT:
A REMOVABLE SEAT IS NOT REQUIRED PER
ANSI SEC. 1003.11.2.5.1 EX.1.

CONTROLS:
607.5 CONTROLS, OTHER THAN DRAIN
STOPPERS, SHALL BE PROVIDED ON AN END
WALL, LOCATED BETWEEN THE BATHTUB RIM
AND GRAB BAR, AND BETWEEN THE OPEN SIDE
OF THE BATHTUB AND THE CENTERLINE OF THE
WIDTH OF THE BATHTUB. CONTROLS SHALL
COMPLY WITH SECTION 309.4. THE ADJUSTABLE
HEIGHT HAND SHOWER SHALL INCLUDE A 59"
MIN LONG HOSE AND COMPLY WITH ANSI SEC.
607.6. CONTROLS SHALL NOT OBSTRUCT THE
USE OF GRAB BARS.


1 BATHTUB REQUIREMENTS
1/4" = 1'-0"

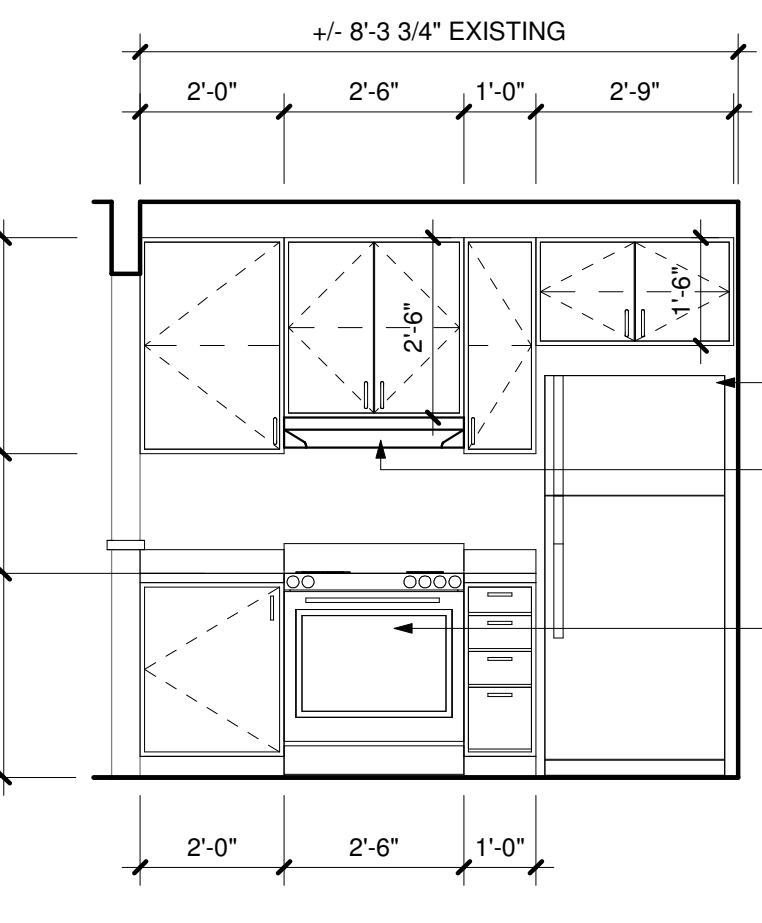


4 KITCHEN (ADA)
3/8" = 1'-0"

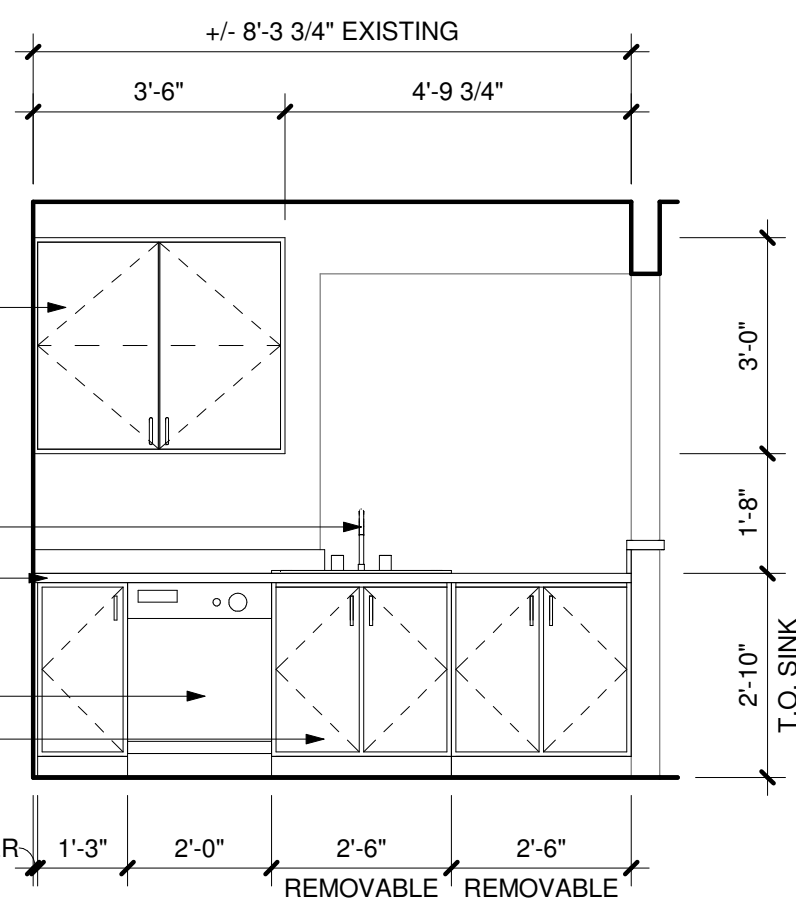


5 KITCHEN (ADA)
3/8" = 1'-0"

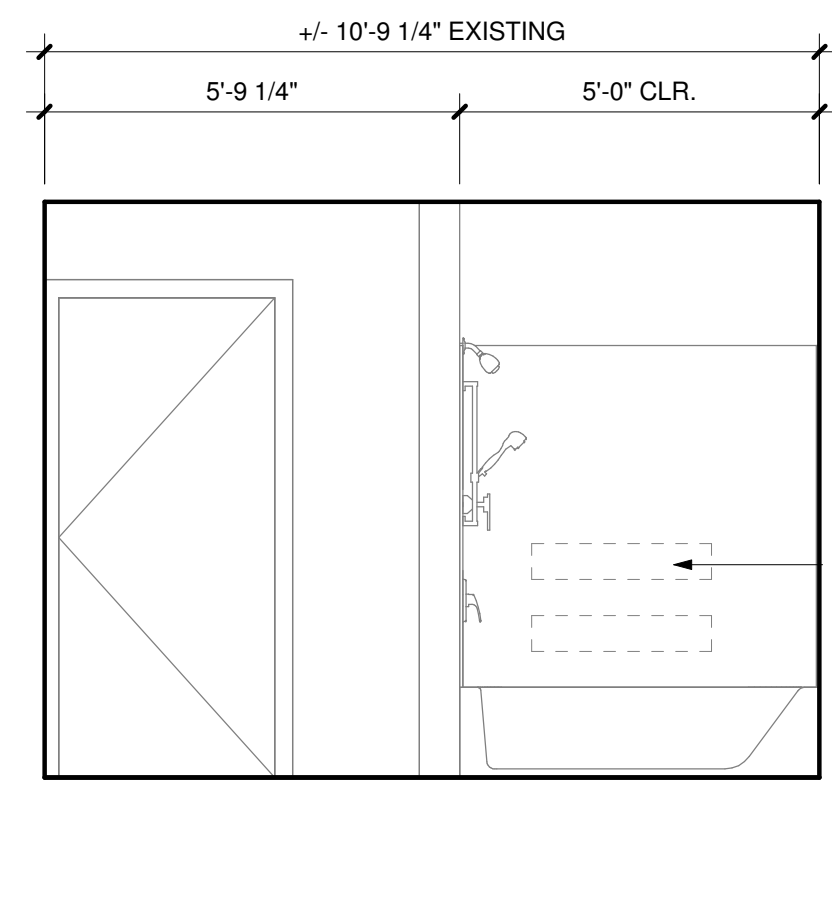

6 BATHROOM (ADA)
3/8" = 1'-0"

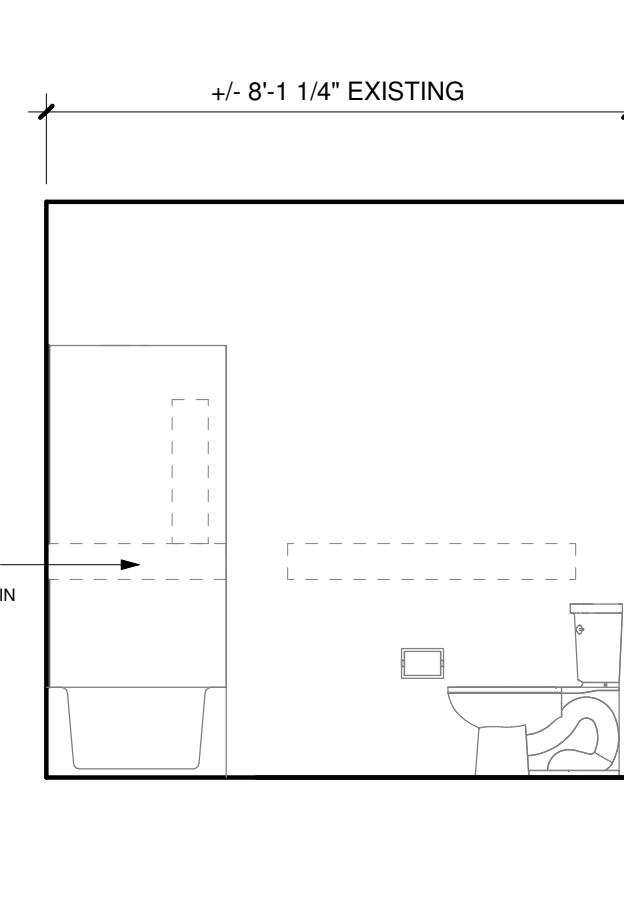

7 BATHROOM (ADA)
3/8" = 1'-0"

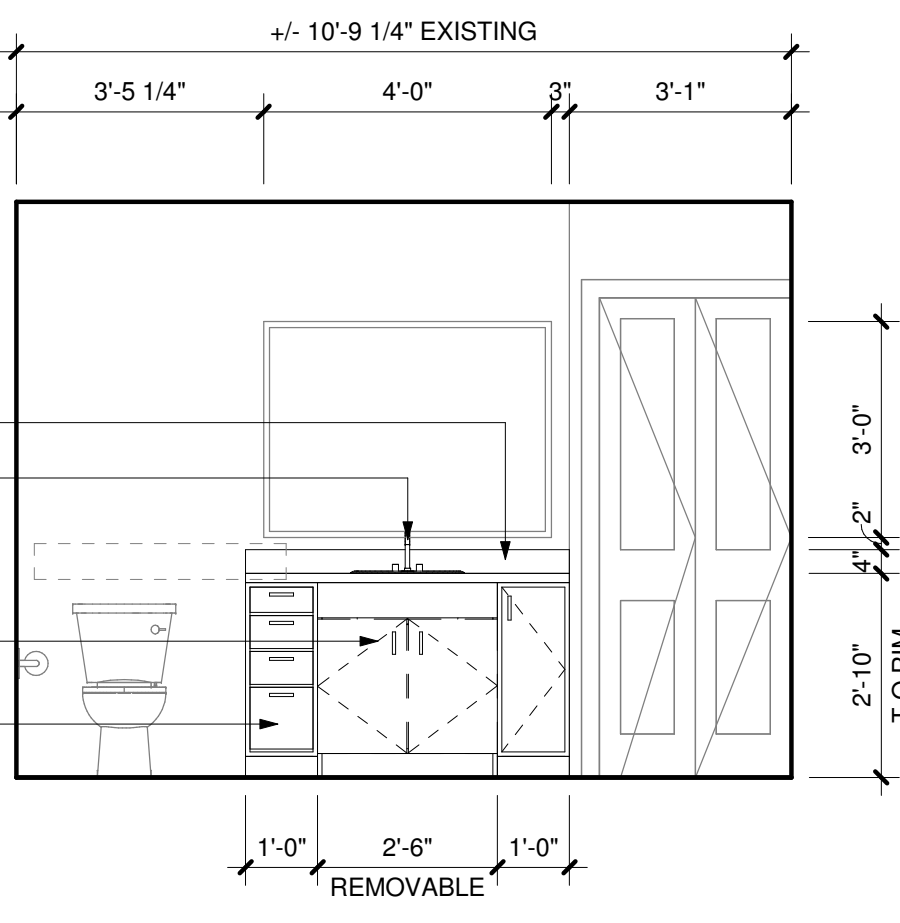


8 BATHROOM (ADA)
3/8" = 1'-0"

DEMOLITION NOTES


#	DESCRIPTION
1	REPLACE ALL EXISTING FLOORING & BASE AND FIREPLACE HEARTH. PREP FOR NEW FINISH AS REQUIRED.
2	DEMO ALL EXISTING UPPER & LOWER CABINETS AND PLUMBING FIXTURE AT KITCHEN. ALL EXISTING APPLIANCES TO BE REMOVED. PREP WALL AND FLOOR FOR NEW FINISHES.
3	REPLACE EXISTING LIGHT FIXTURES. PREP FOR NEW FIXTURE AS REQUIRED.
4	DEMO ALL EXISTING LOWER CABINET, PLUMBING FIXTURE & MIRROR. PREP FOR NEW FINISHES AS REQUIRED.
5	DEMO HALF WALL AND EXISTING COUNTER TO ACCOMMODATE NEW COUNTER.
6	MEDICINE CABINET TO BE REMOVED AND REPLACED BY OWNER.
7	DEMO EXISTING MANTLE & FIRE PLACE TILE SURROUND. PREP FOR NEW FINISHES. SEE FIREPLACE ELEVATION FOR DETAILS.
8	REMOVE EXISTING COUNTERSHELF AT LIVING ROOM. PATCH & REPAIR WALL AS REQUIRED FOR NEW FINISHES.
9	REPLACE EXISTING SHOWER HEAD, SHOWER CONTROL KNOB, VALVE, AND ASSOCIATED RISER PIPING.
10	SEE DETAIL 1/A-213 FOR BATHTUB CONTROL AND GRAB BAR LOCATIONS FOR BATHROOMS.

KEYNOTES


#	DESCRIPTION
00 00 22	REMOVABLE CABINET, EXTEND FLOORING TO WALL AT BACK OF EACH REMOVABLE CABINET
09 30 13	CERAMIC TILING
11 30 13.A1	RANGE
11 30 13.A3	DISHWASHER
11 30 13.A4	REFRIGERATOR
12 32 00	MANUFACTURED WOOD CASEWORK
12 36 61.19	QUARTZ AGGLOMERATE COUNTERTOPS
22 40 00.A2	LAVATORY/FAUCET
22 40 00.A4	UNDER COUNTER SINK/FAUCET

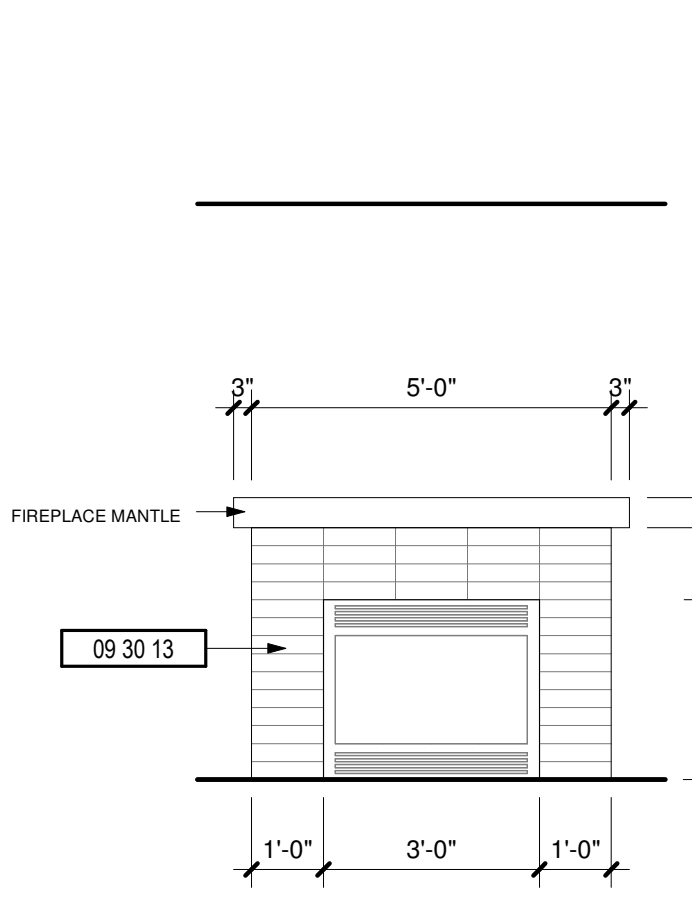


9 FIREPLACE
3/8" = 1'-0"

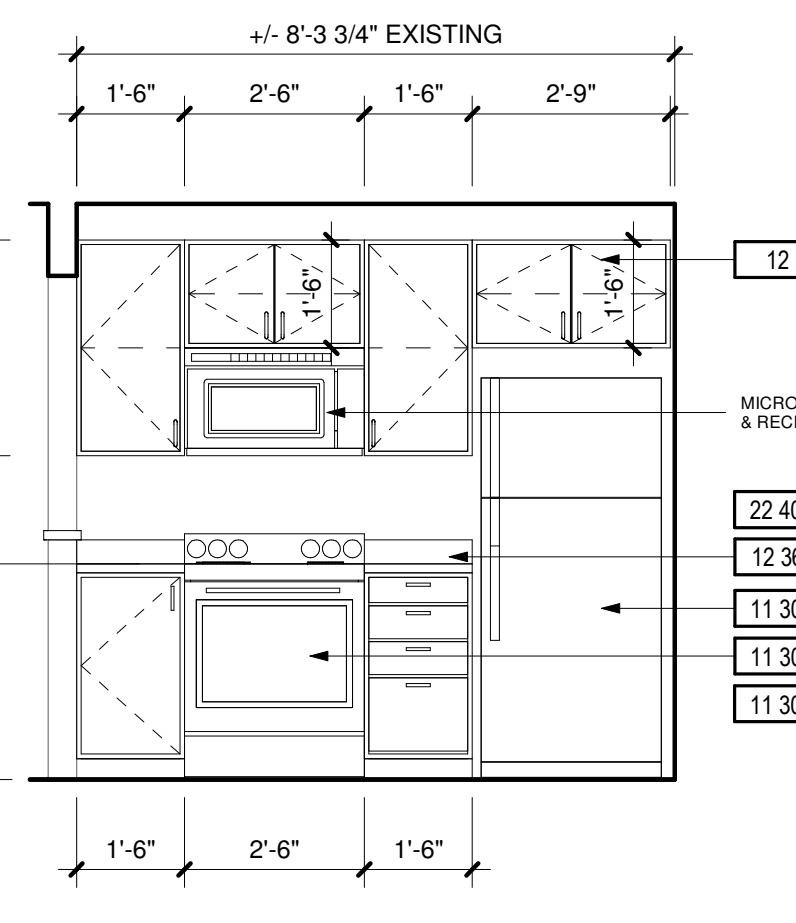


10 KITCHEN
3/8" = 1'-0"

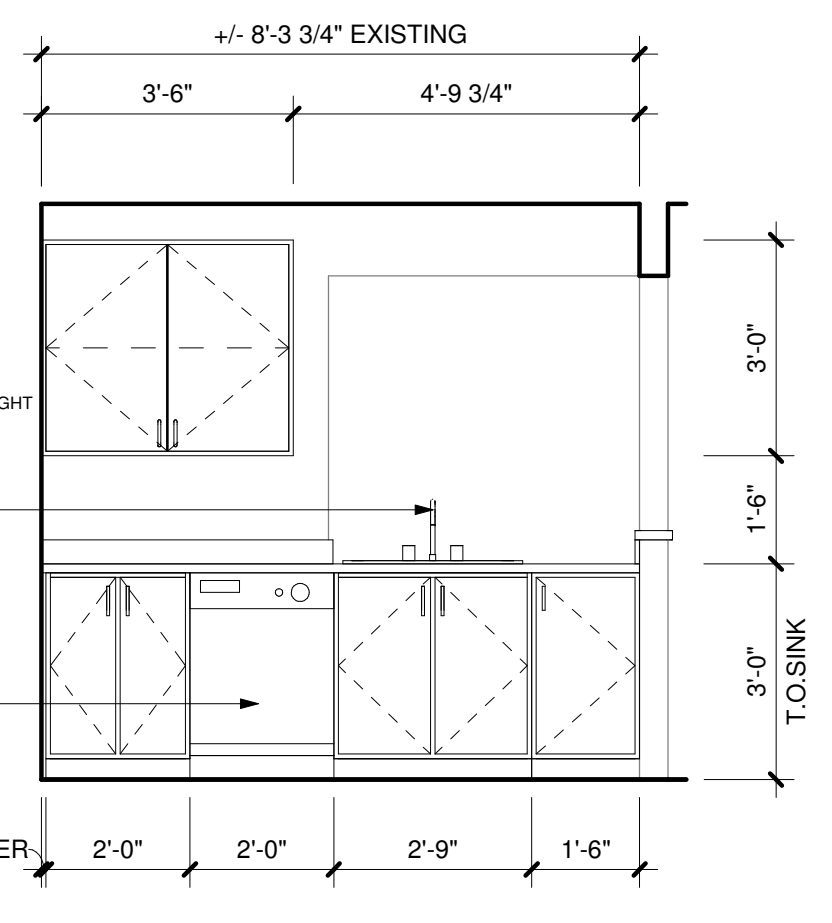


11 KITCHEN
3/8" = 1'-0"

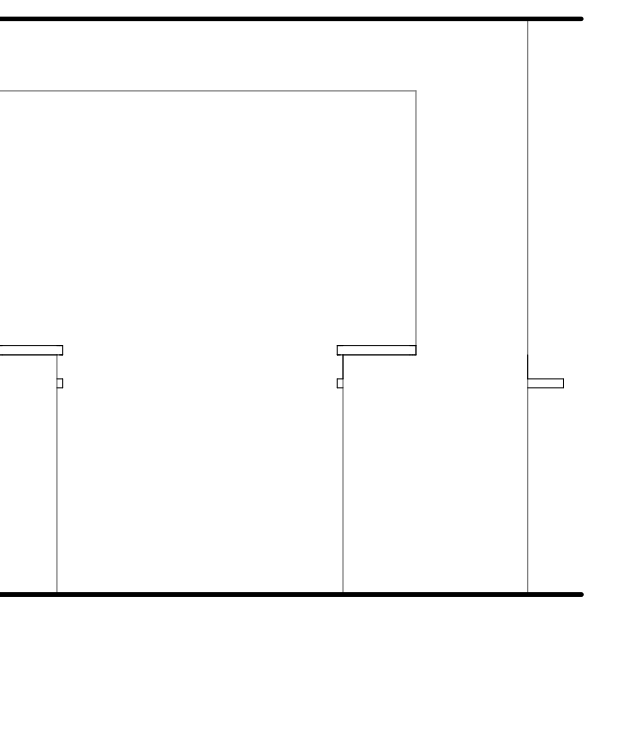


12 DINING ROOM
3/8" = 1'-0"

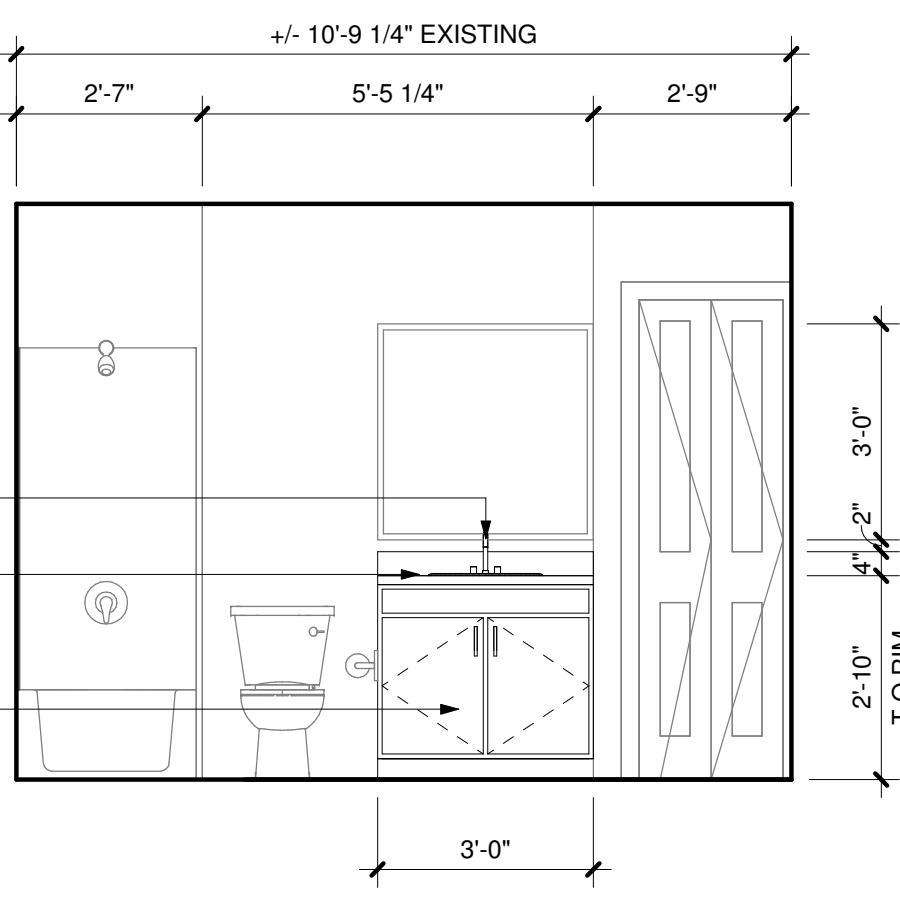

13 BATHROOM
3/8" = 1'-0"

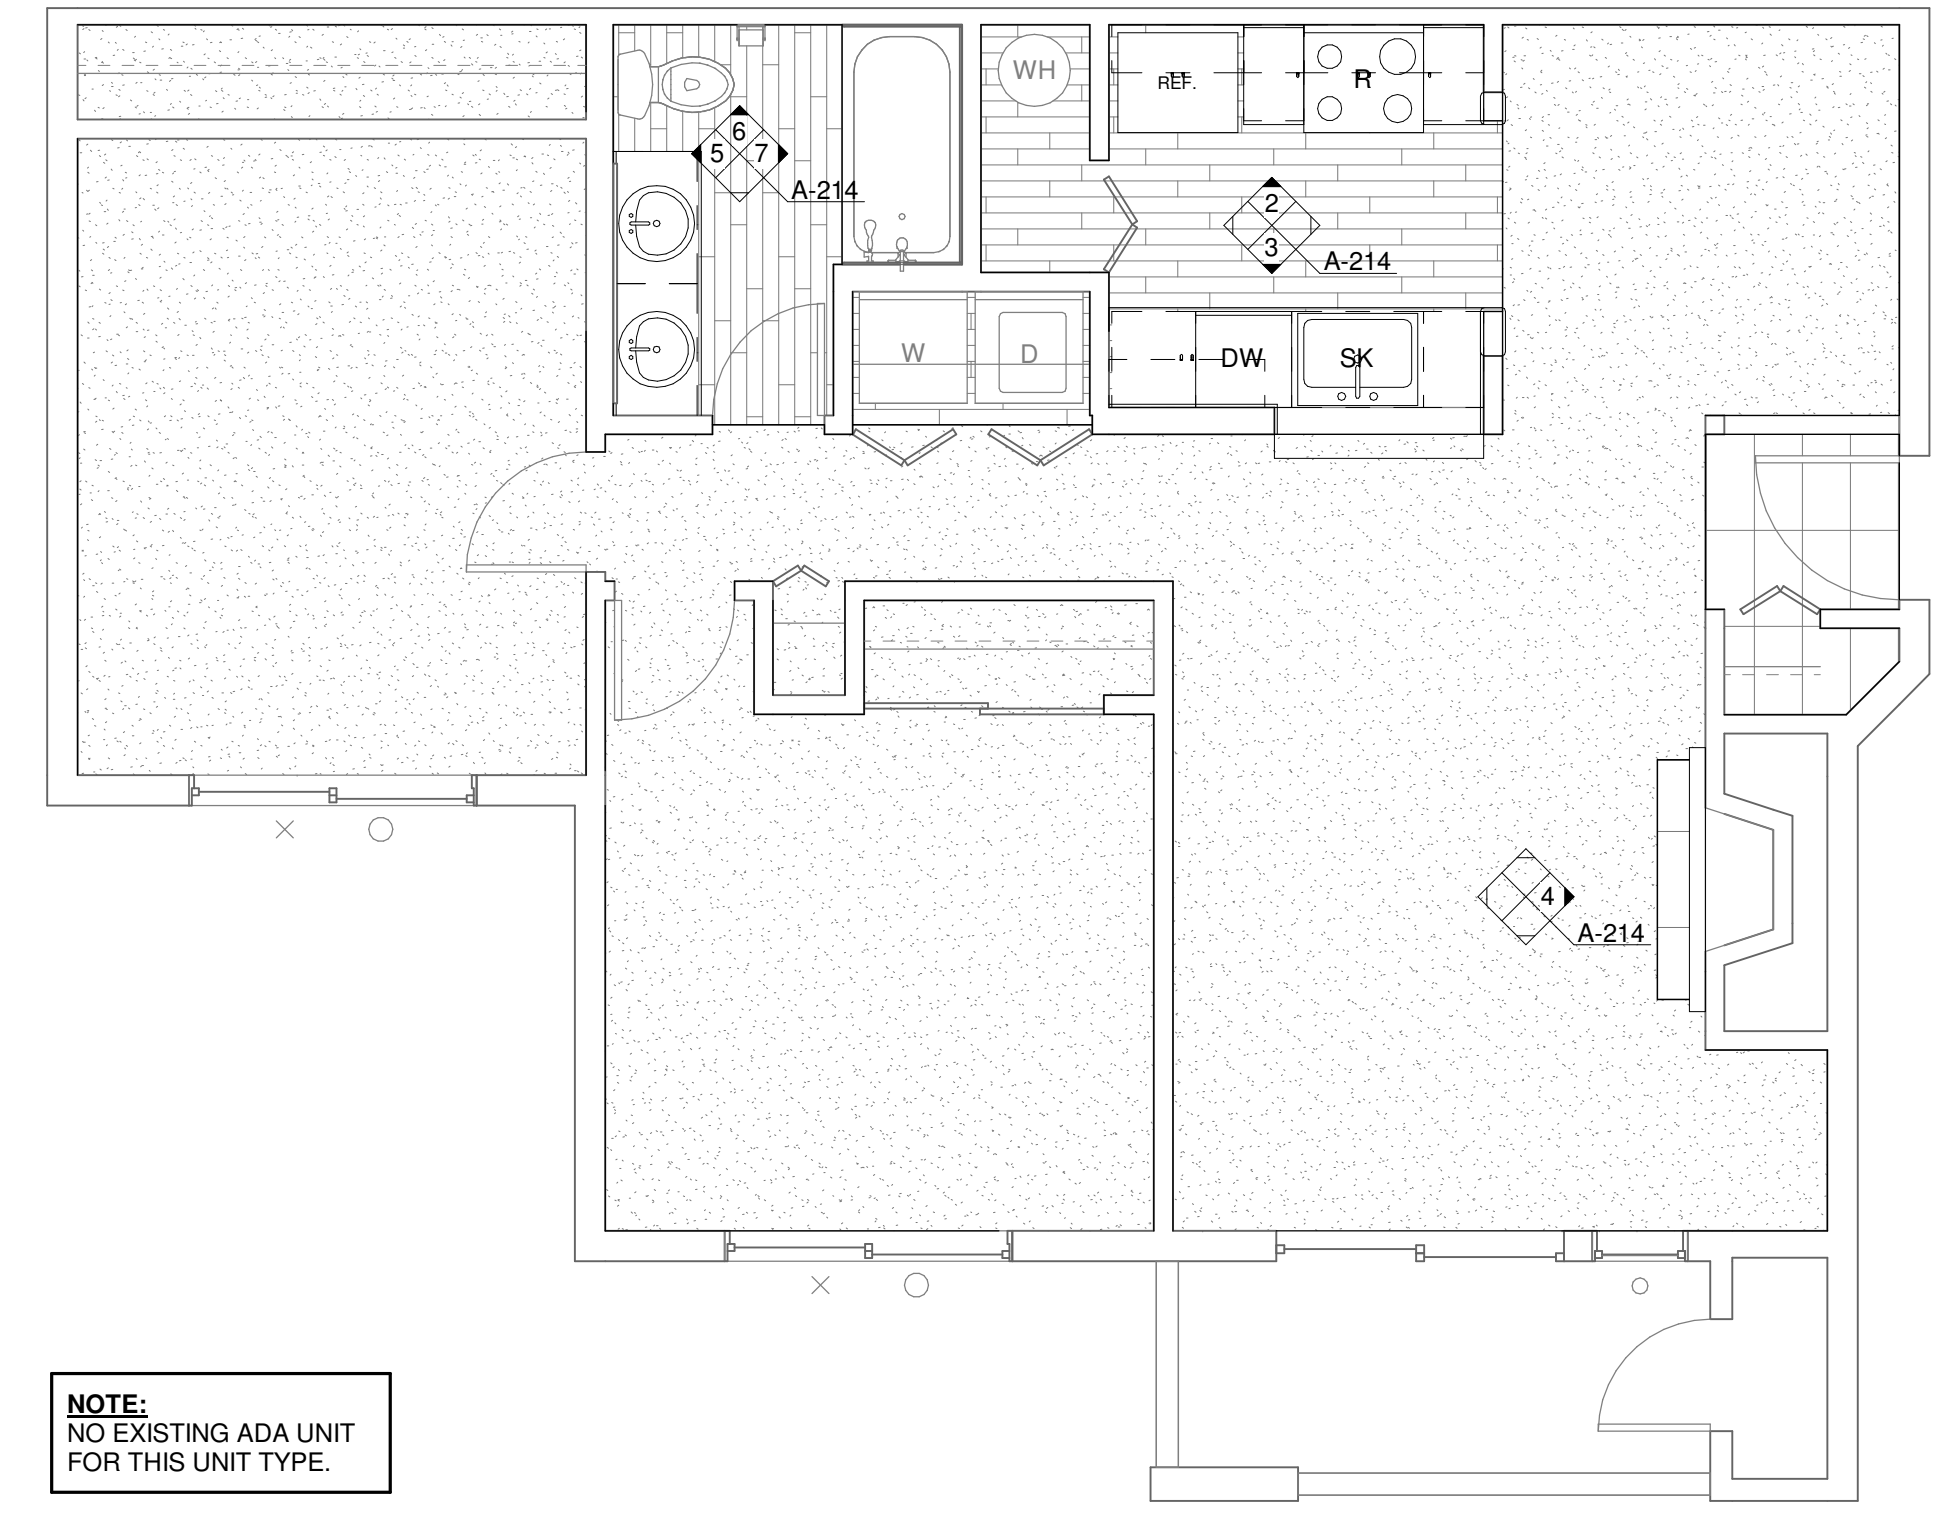

1 ENLARGED UNIT PLAN - 2 BED/1 BATH (TYP)
1/4" = 1'-0"

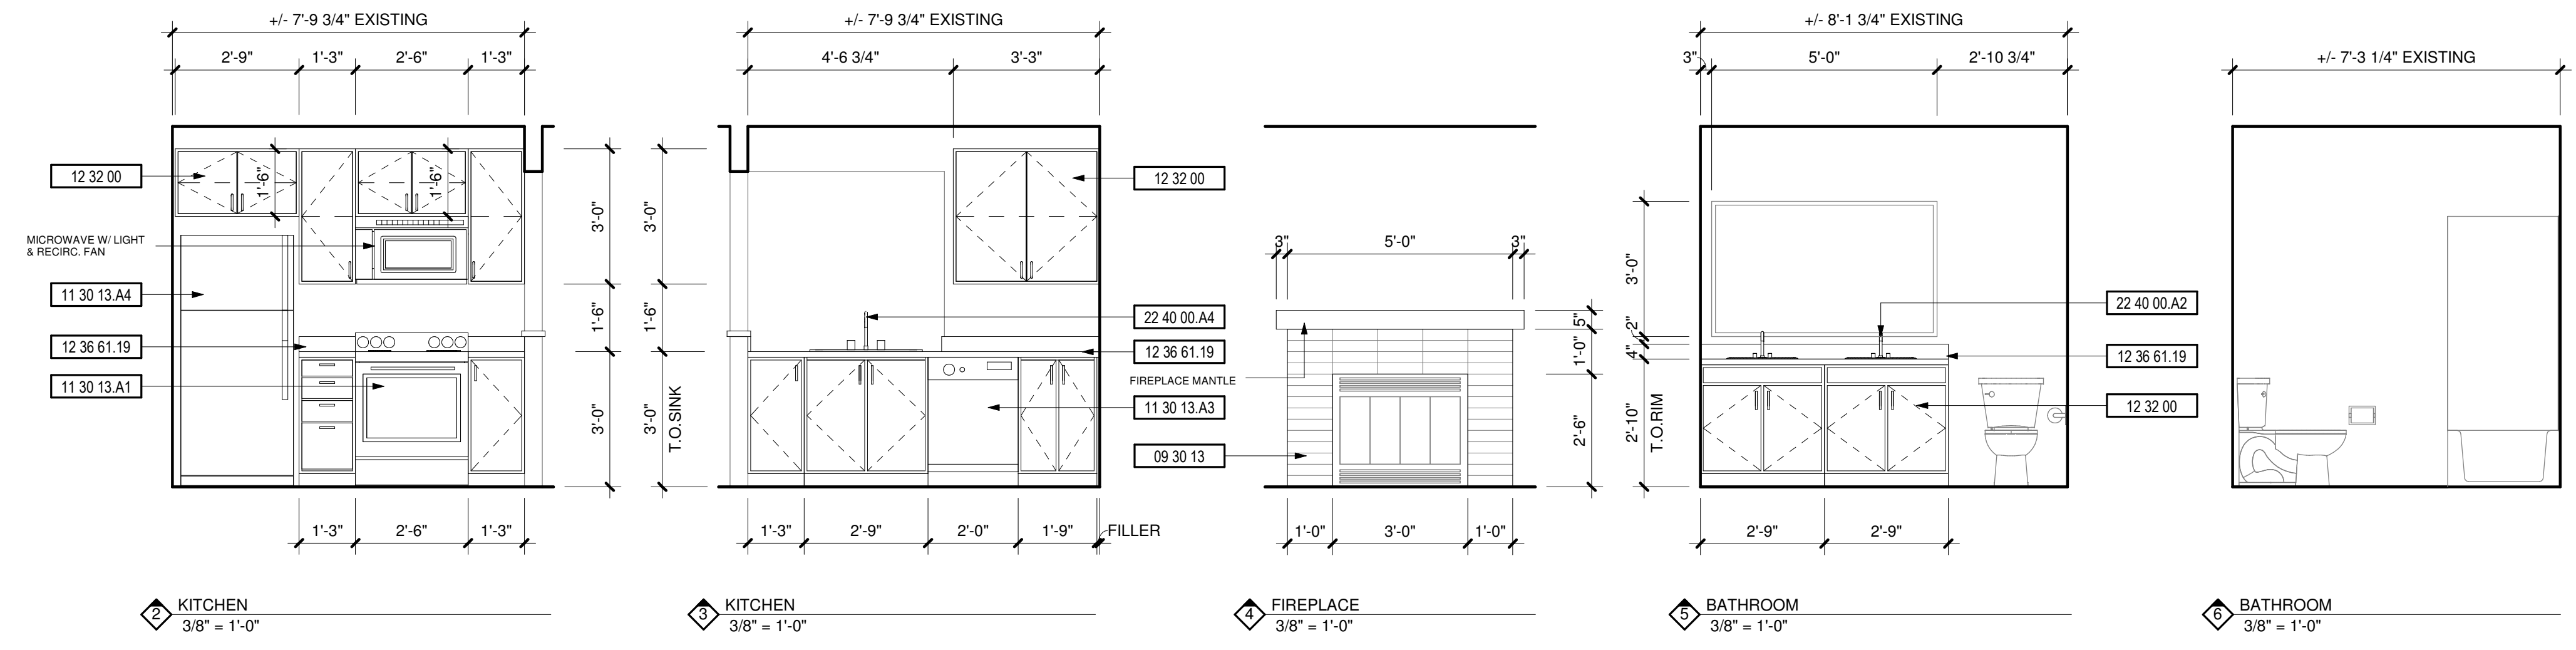

DEMOLITION NOTES

#	DESCRIPTION
1	REPLACE ALL EXISTING FLOORING & BASE AND FIREPLACE HEARTH. PREP FOR NEW FINISH AS REQUIRED.
2	DEMO ALL EXISTING UPPER & LOWER CABINETS AND PLUMBING FIXTURE AT KITCHEN. ALL EXISTING APPLIANCES TO BE REMOVED. PREP WALL AND FLOOR FOR NEW FINISHES.
3	REPLACE EXISTING LIGHT FIXTURES. PREP FOR NEW FIXTURE AS REQUIRED.
4	DEMO ALL EXISTING LOWER CABINET, PLUMBING FIXTURE & MIRROR. PREP FOR NEW FINISHES AS REQUIRED.
5	DEMO HALF WALL AND EXISTING COUNTER TO ACCOMMODATE NEW COUNTER.
6	MEDICINE CABINET TO BE REMOVED AND REPLACED BY OWNER.
7	DEMO EXISTING MANTLE & FIRE PLACE TILE SURROUND. PREP FOR NEW FINISHES. SEE FIREPLACE ELEVATION FOR DETAILS.
8	REMOVE EXISTING COUNTERSHELF AT LIVING ROOM. PATCH & REPAIR WALL AS REQUIRED FOR NEW FINISHES.
9	REPLACE EXISTING SHOWER HEAD, SHOWER CONTROL KNOB, VALVE, AND ASSOCIATED RISER PIPING.
10	SEE DETAIL 1/A-213 FOR BATHTUB CONTROL AND GRAB BAR LOCATIONS FOR BATHROOMS.

KEYNOTES

#	DESCRIPTION
09 30 13	CERAMIC TILING
11 30 13.A1	RANGE
11 30 13.A3	DISHWASHER
11 30 13.A4	REFRIGERATOR
12 32 00	MANUFACTURED WOOD CASEWORK
12 36 61.19	QUARTZ AGGLOMERATE COUNTERTOPS
22 40 00.A2	LAVATORY/FAUCET
22 40 00.A4	UNDER COUNTER SINK/FAUCET



#	DESC.	DATE

APPROVAL STAMPS

City of Puyallup
Development & Permitting Services
ISSUED PERMIT


Building	Planning
Engineering	Public Works
Fire	Traffic

JOB NO.: 1922
ISSUE DATE: 09/14/2021
REVISED:
DRAWN BY: BM
SHEET

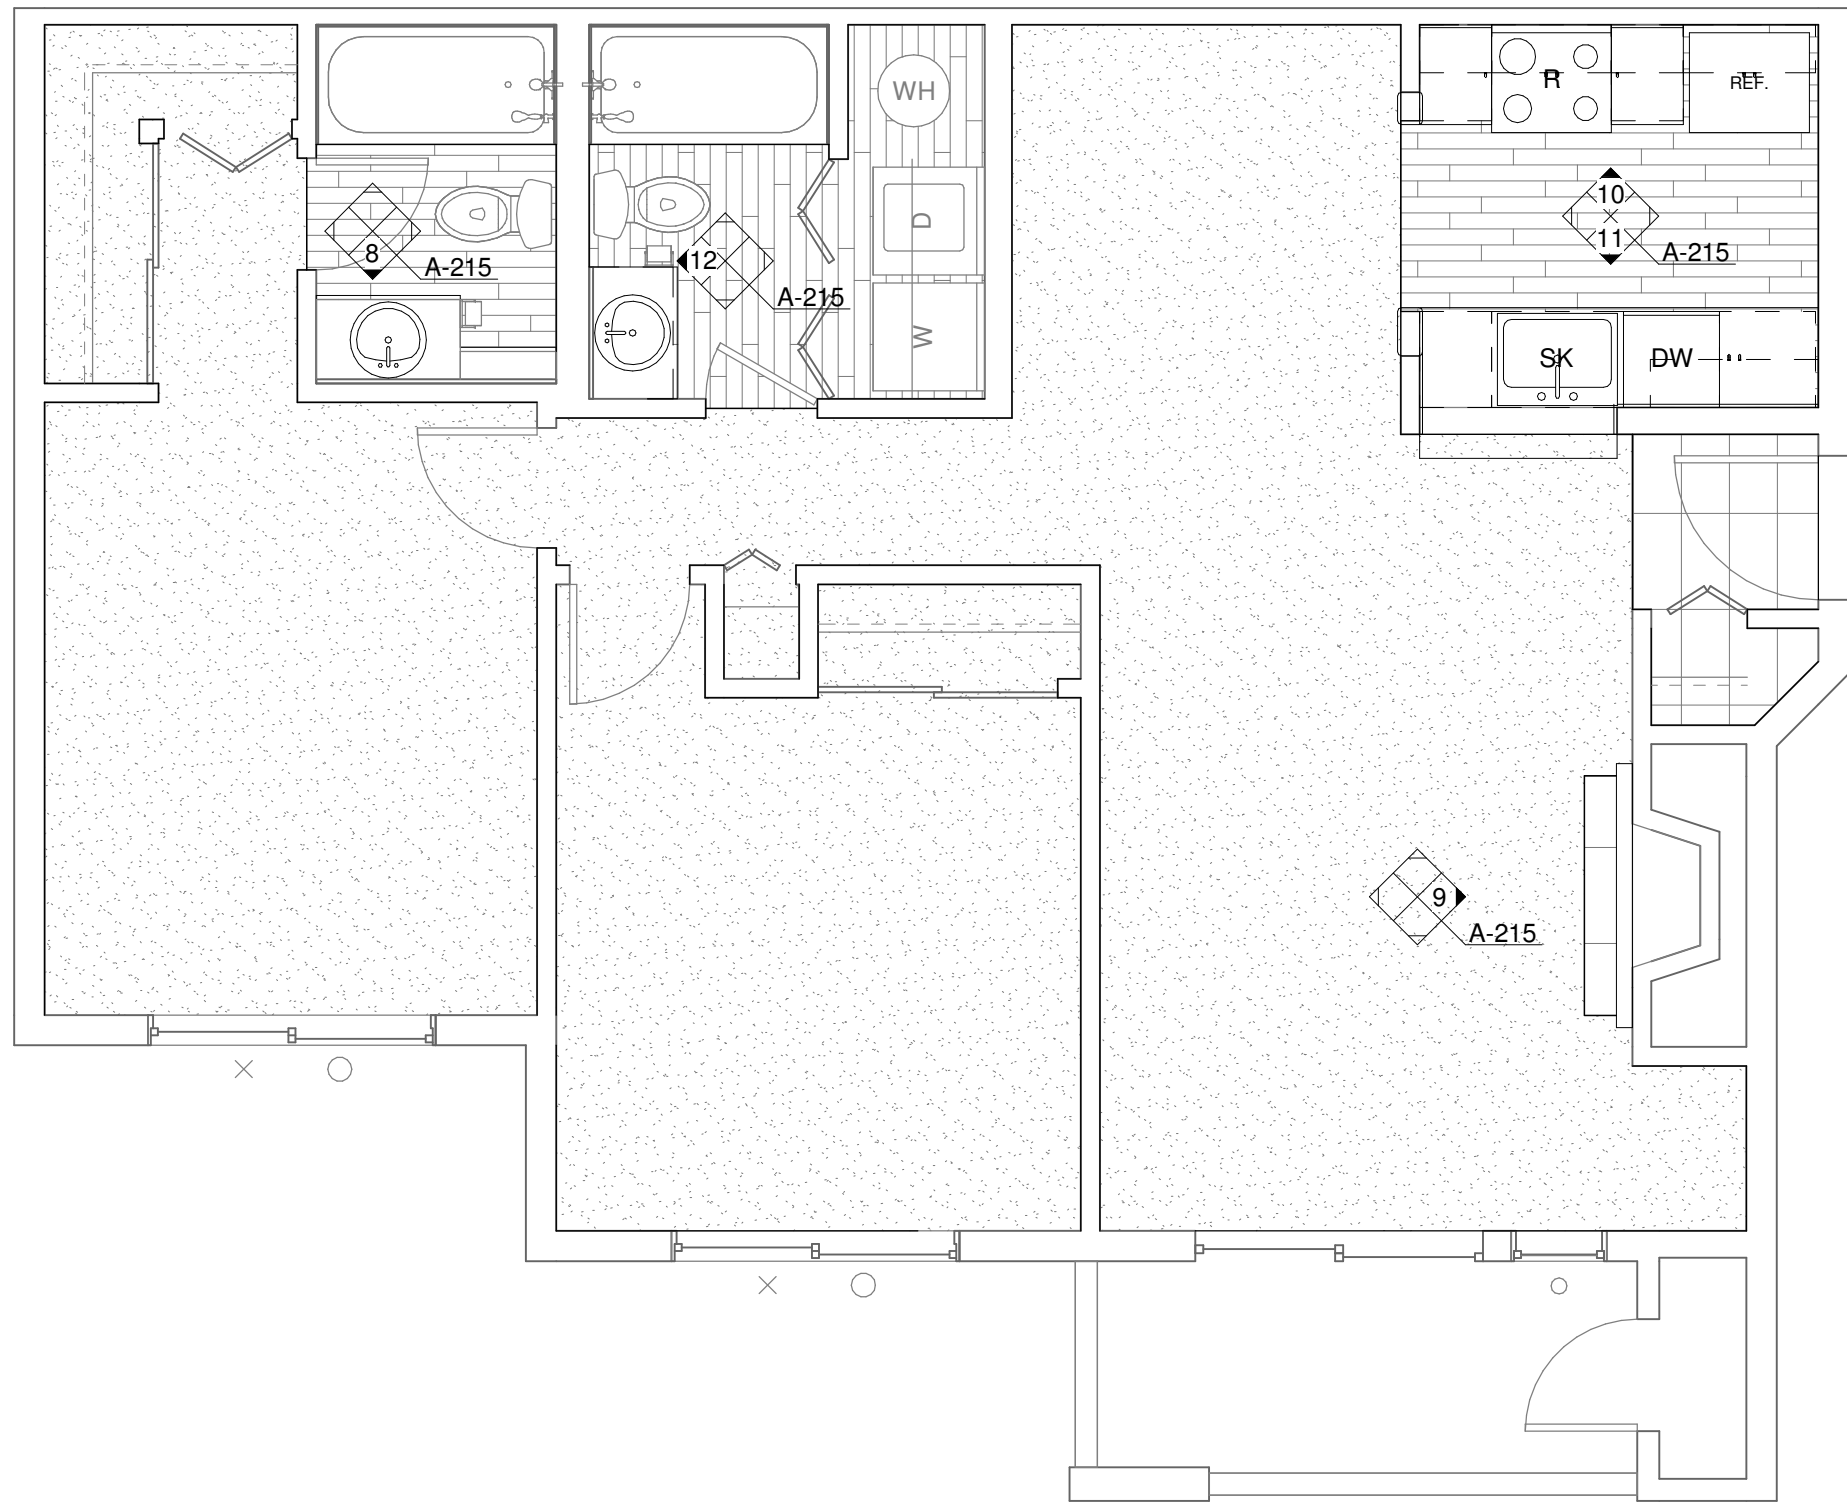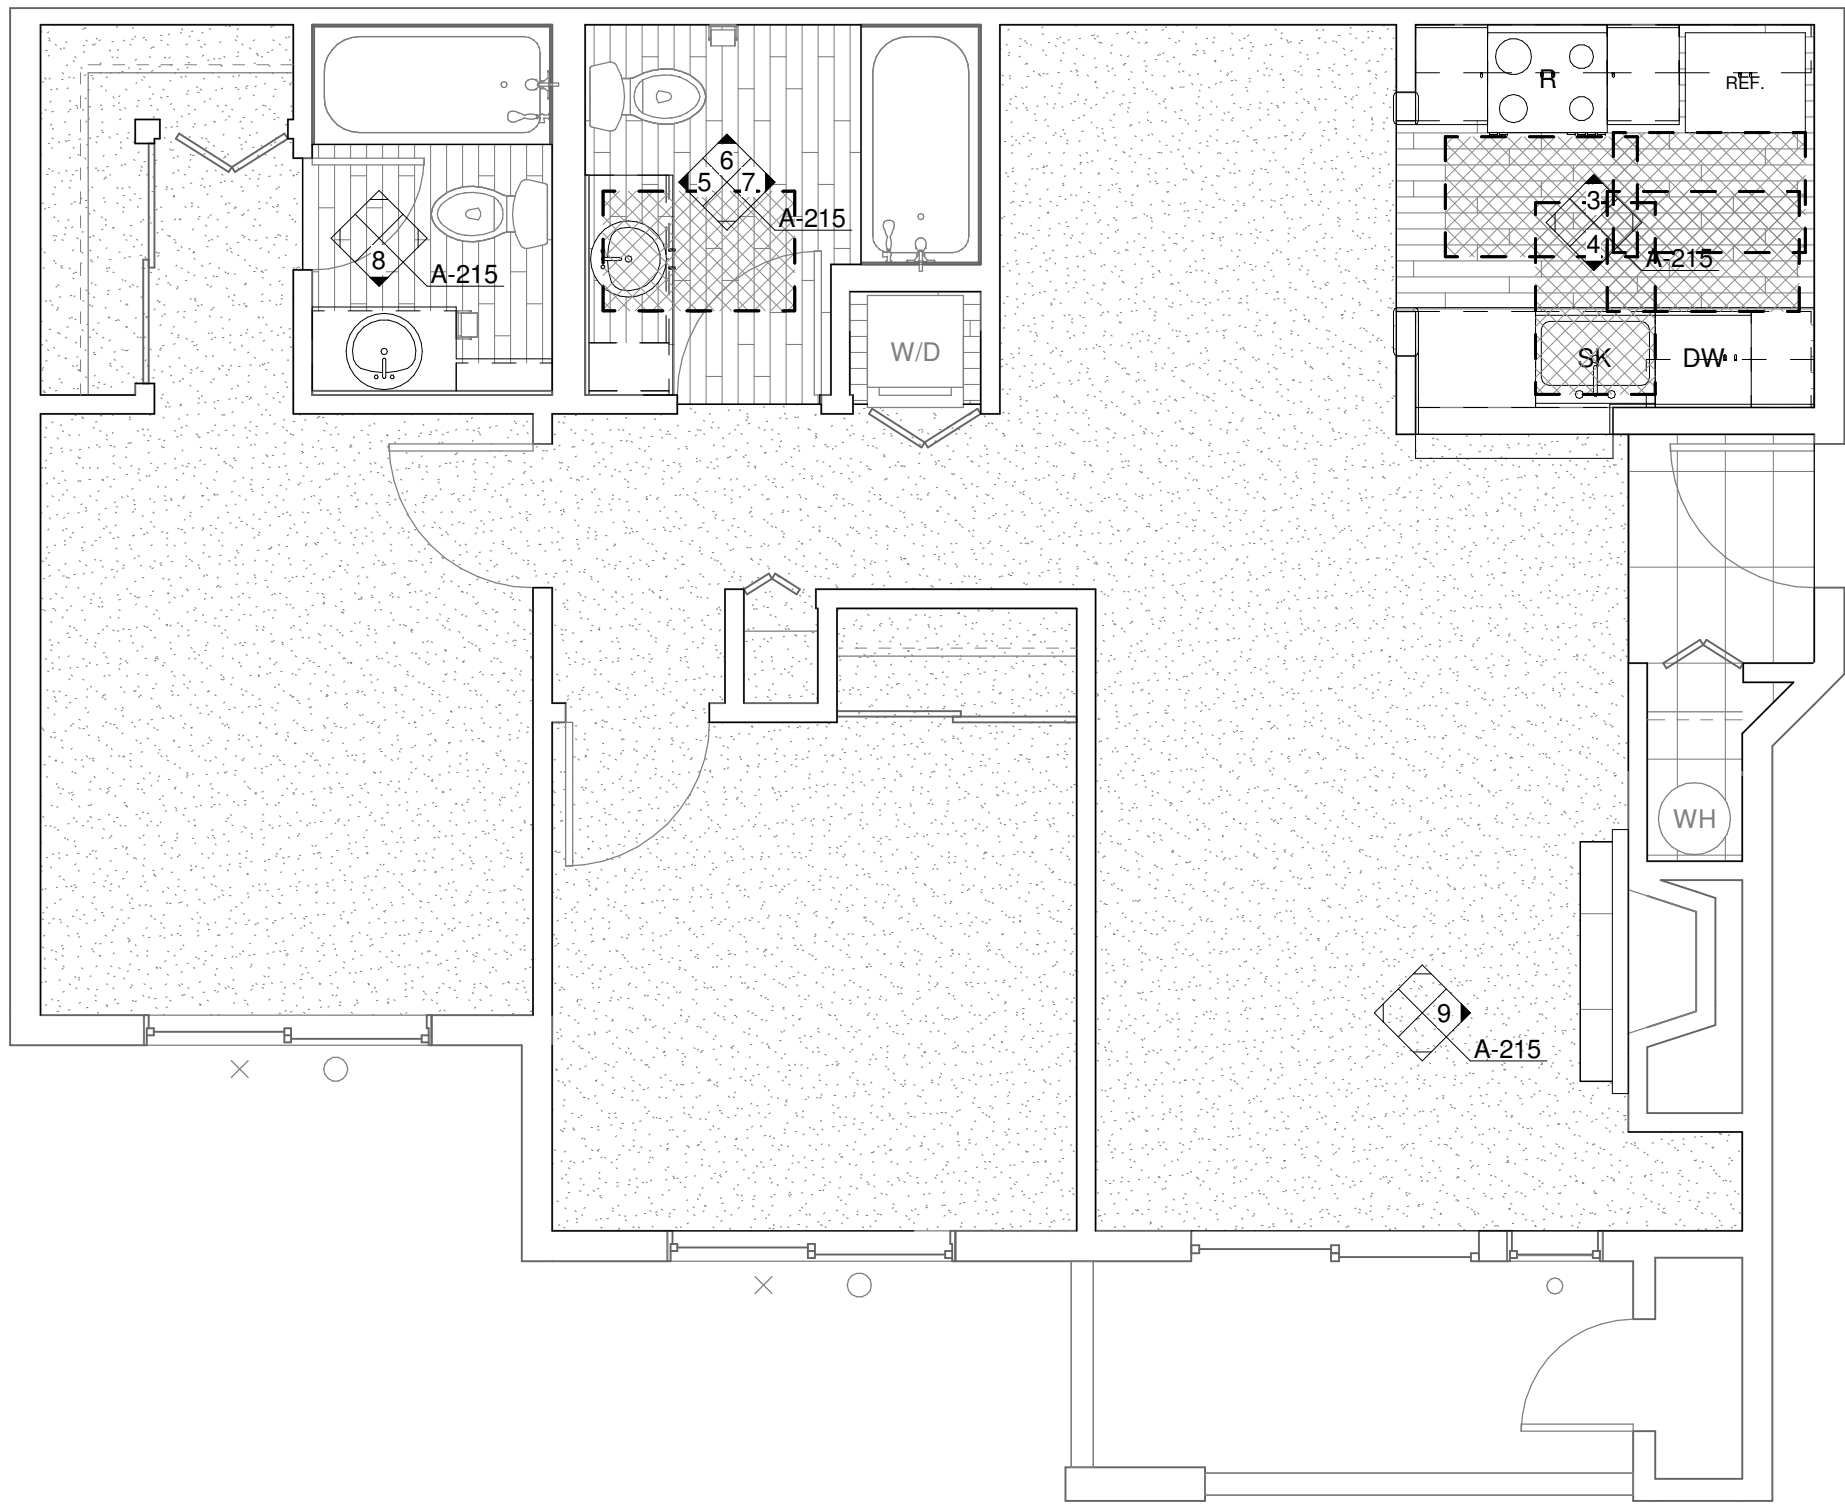

1 ENLARGED UNIT PLAN - 2 BED/2 BATH (ADA)
1/4" = 1'-0"

2 ENLARGED UNIT PLAN - 2 BED/2 BATH (TYP)
1/4" = 1'-0"

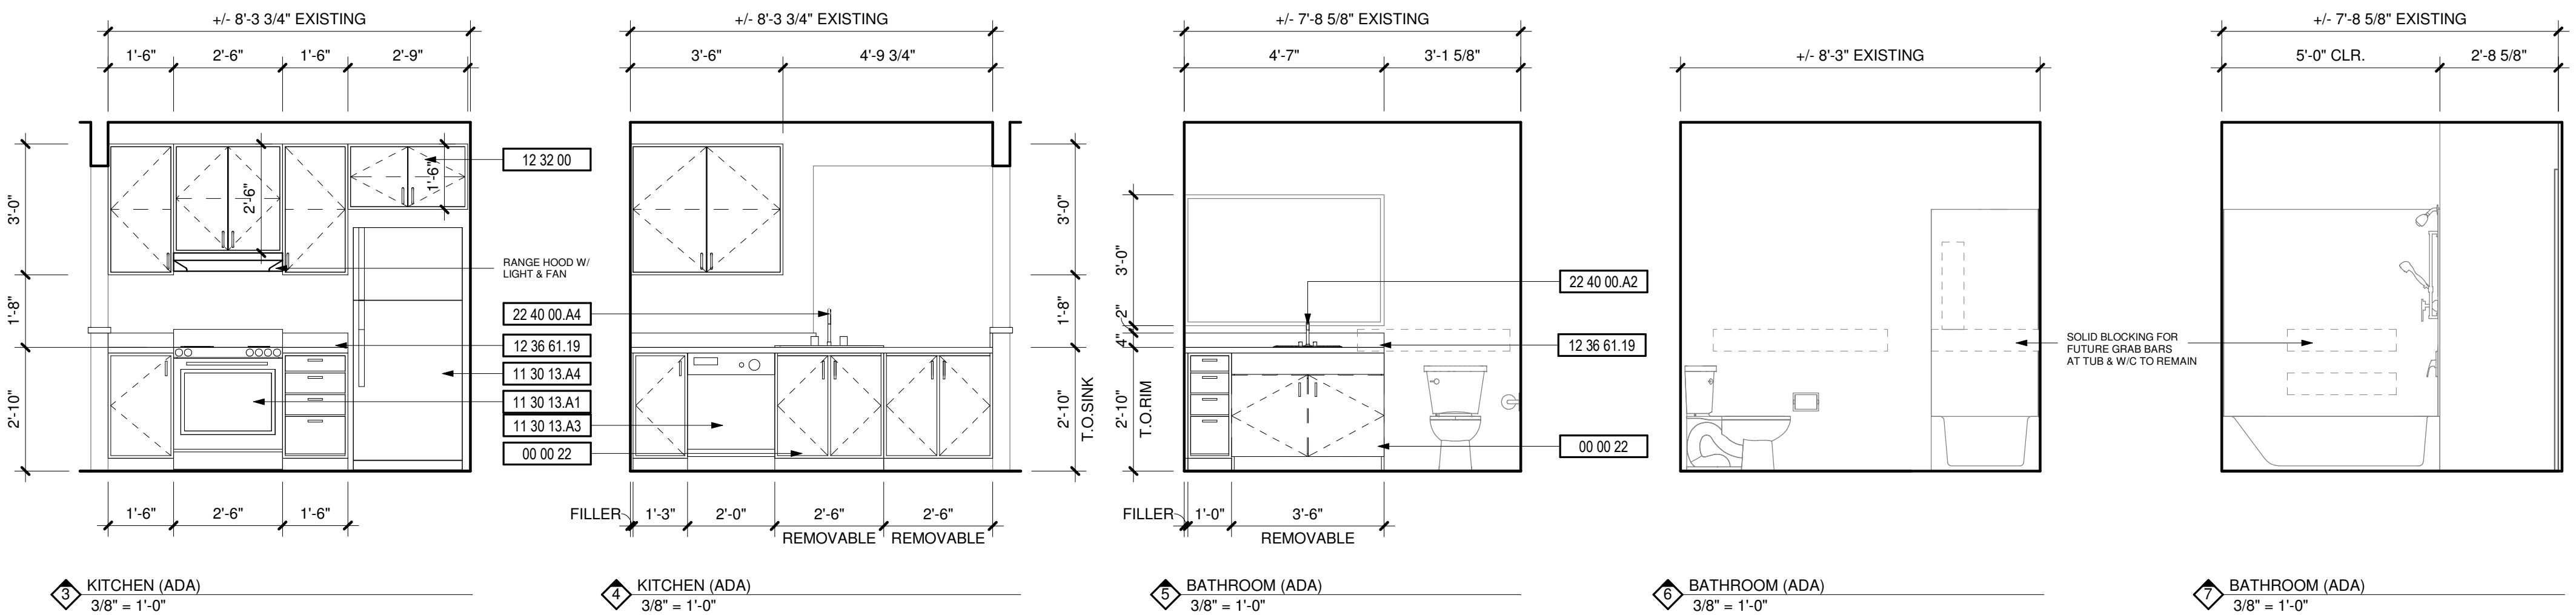

DEMOLITION NOTES

#	DESCRIPTION
1	REPLACE ALL EXISTING FLOORING & BASE AND FIREPLACE HEARTH. PREP FOR NEW FINISH AS REQUIRED.
2	DEMO ALL EXISTING UPPER & LOWER CABINETS AND PLUMBING FIXTURE AT KITCHEN. ALL EXISTING APPLIANCES TO BE REMOVED. PREP WALL AND FLOOR FOR NEW FINISHES.
3	REPLACE EXISTING LIGHT FIXTURES. PREP FOR NEW FIXTURE AS REQUIRED.
4	DEMO ALL EXISTING LOWER CABINET, PLUMBING FIXTURE & MIRROR. PREP FOR NEW FINISHES AS REQUIRED.
5	DEMO HALF WALL AND EXISTING COUNTER TO ACCOMMODATE NEW COUNTER.
6	MEDICINE CABINET TO BE REMOVED AND REPLACED BY OWNER.
7	DEMO EXISTING MANTLE & FIRE PLACE TILE SURROUND. PREP FOR NEW FINISHES. SEE FIREPLACE ELEVATION FOR DETAILS.
8	REMOVE EXISTING COUNTERSHELF AT LIVING ROOM. PATCH & REPAIR WALL AS REQUIRED FOR NEW FINISHES.
9	REPLACE EXISTING SHOWER HEAD, SHOWER CONTROL KNOB, VALVE, AND ASSOCIATED RISER PIPING.
10	SEE DETAIL 1/A-213 FOR BATHTUB CONTROL AND GRAB BAR LOCATIONS FOR BATHROOMS.

KEYNOTES

#	DESCRIPTION
00 00 22	REMOVABLE CABINET, EXTEND FLOORING TO WALL AT BACK OF EACH REMOVABLE CABINET
09 30 13	CERAMIC TILING
11 30 13.A1	RANGE
11 30 13.A3	DISHWASHER
11 30 13.A4	REFRIGERATOR
12 32 00	MANUFACTURED WOOD CASEWORK
12 36 61.19	QUARTZ AGGLOMERATE COUNTERTOPS
22 40 00.A2	LAVATORY/FAUCET
22 40 00.A4	UNDER COUNTER SINK/FAUCET

#	DATE	DESC.

APPROVAL STAMPS


City of Puyallup
Development & Permitting Services
ISSUED PERMIT

Building	Planning
Engineering	Public Works
Fire	Traffic


JOB NO.: 1922
ISSUE DATE: 09/14/2021
REVISED:
DRAWN BY: BM
SHEET

P:\1922 Meridian Pointe Apartments\05-Drawings\1922 Meridian Pointe Apartments Units.rvt

1 ENLARGED UNIT PLAN - 3 BED/2 BATH (ADA)
1/4" = 1'-0"

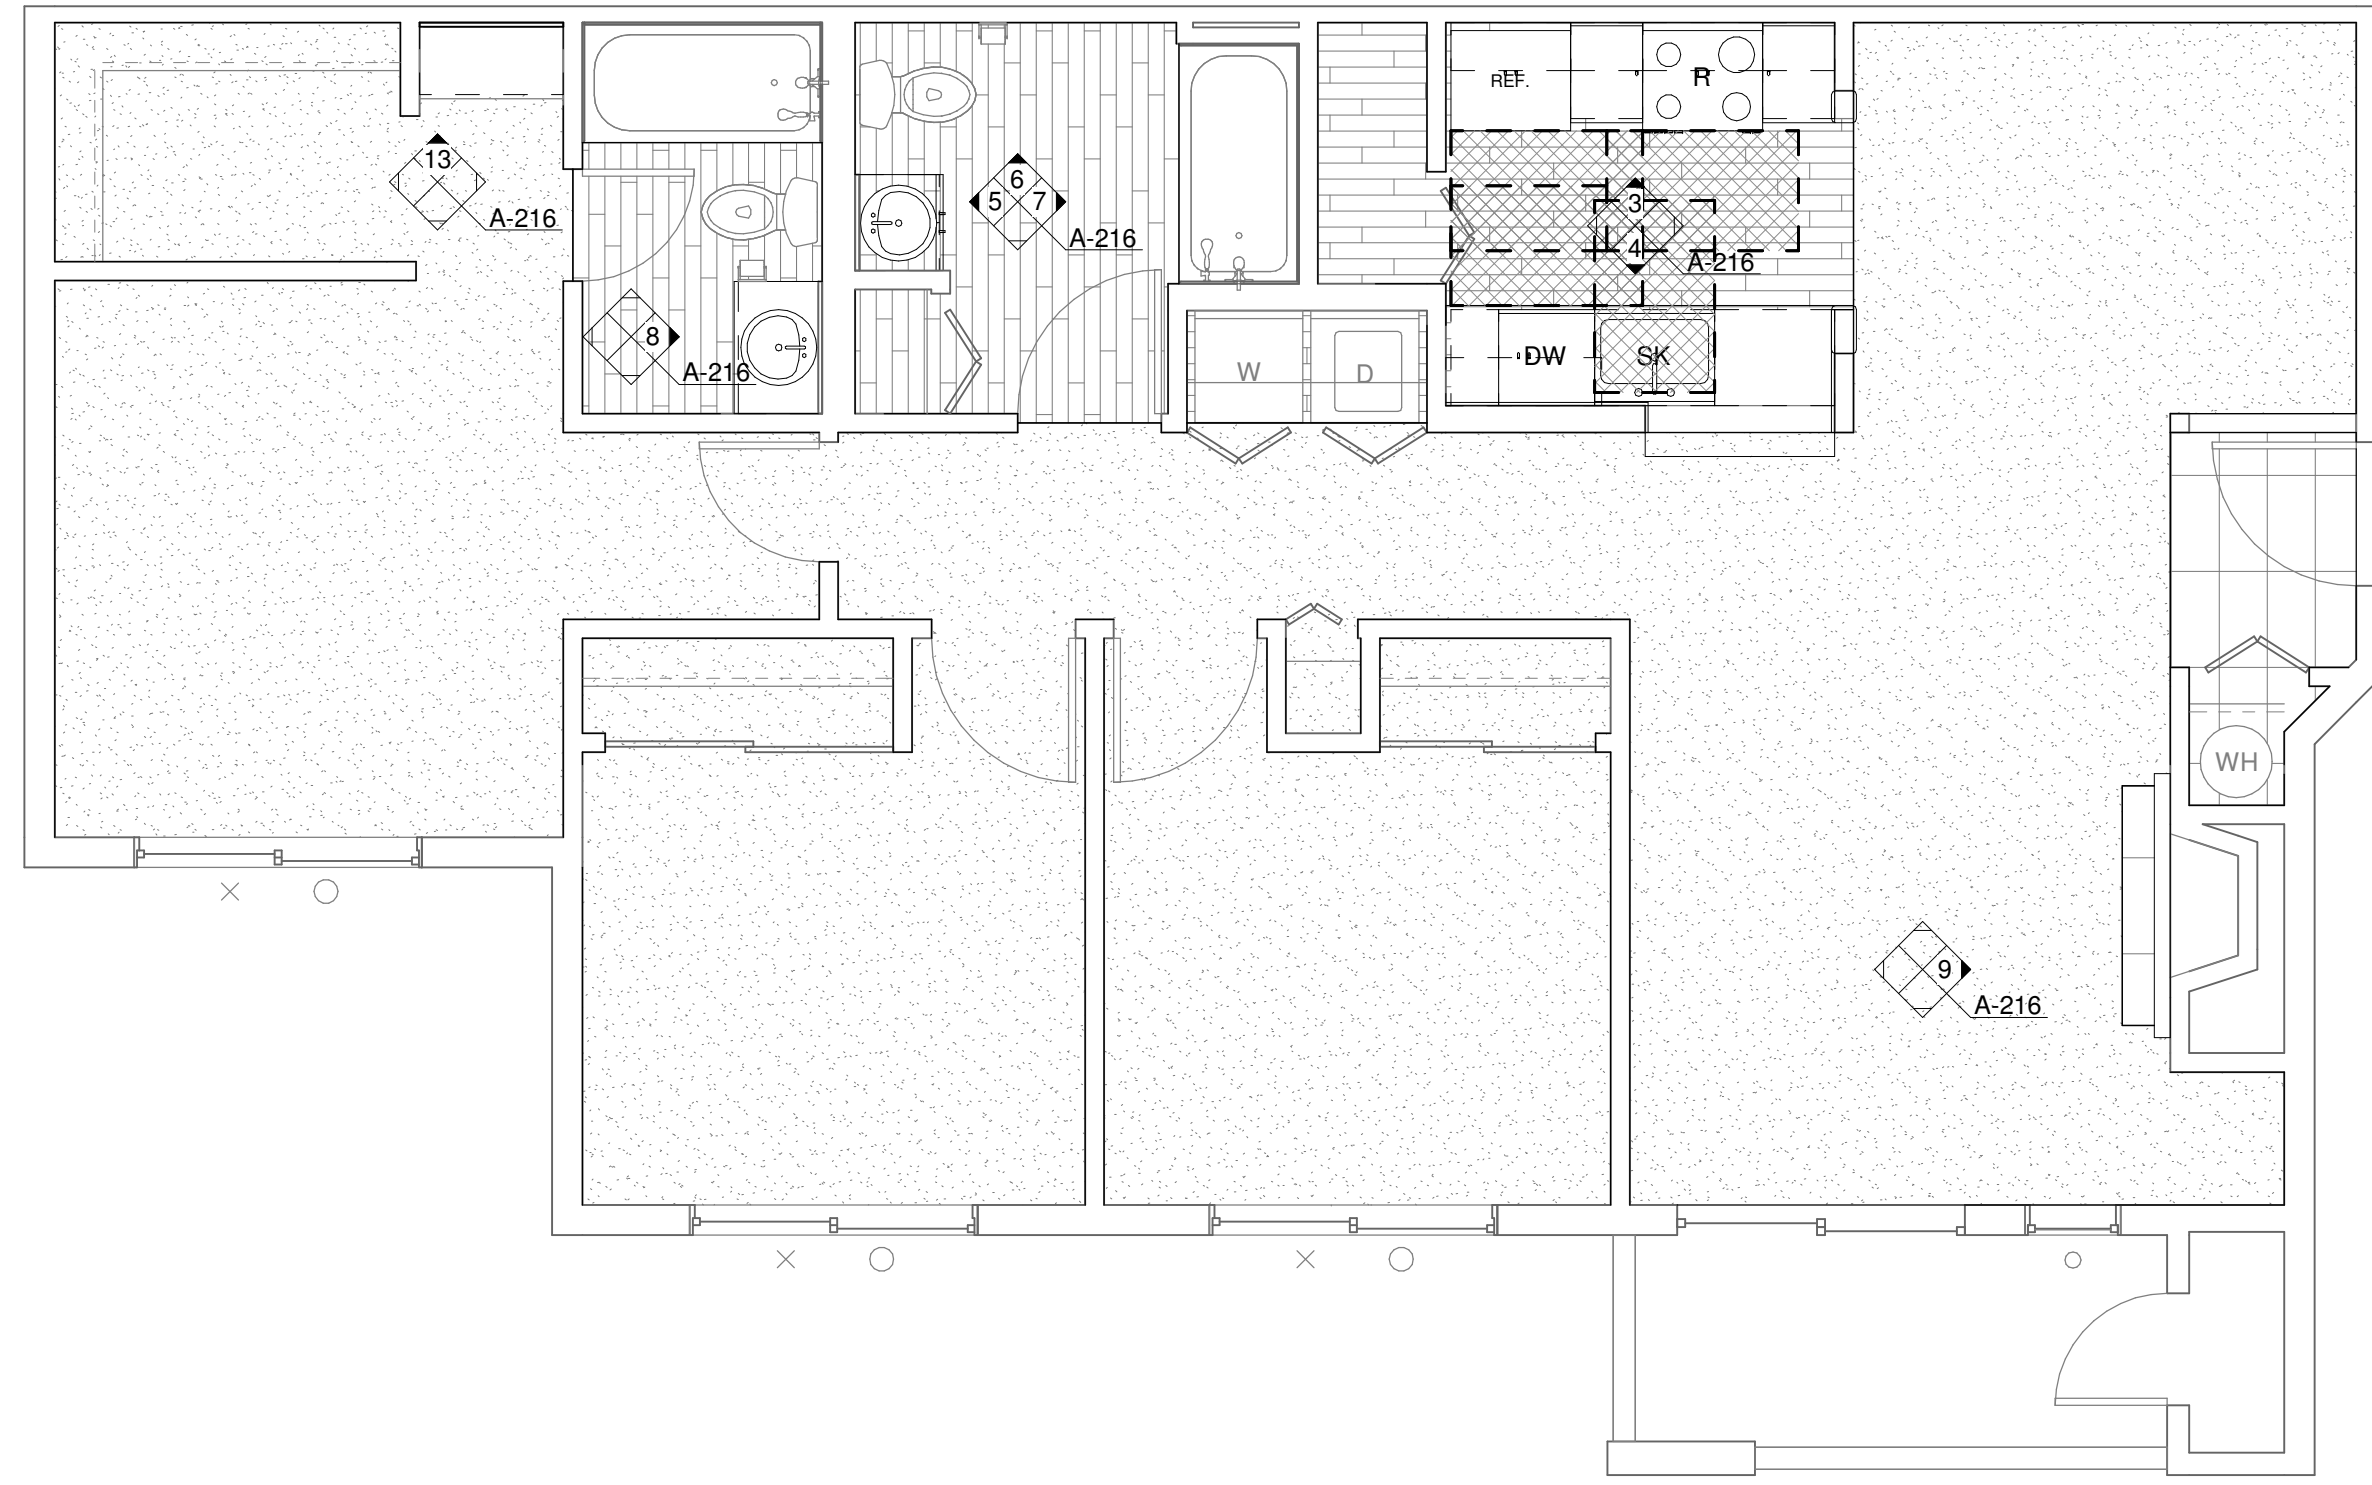

2 ENLARGED UNIT PLAN - 3 BED/2 BATH (TYP)
1/4" = 1'-0"

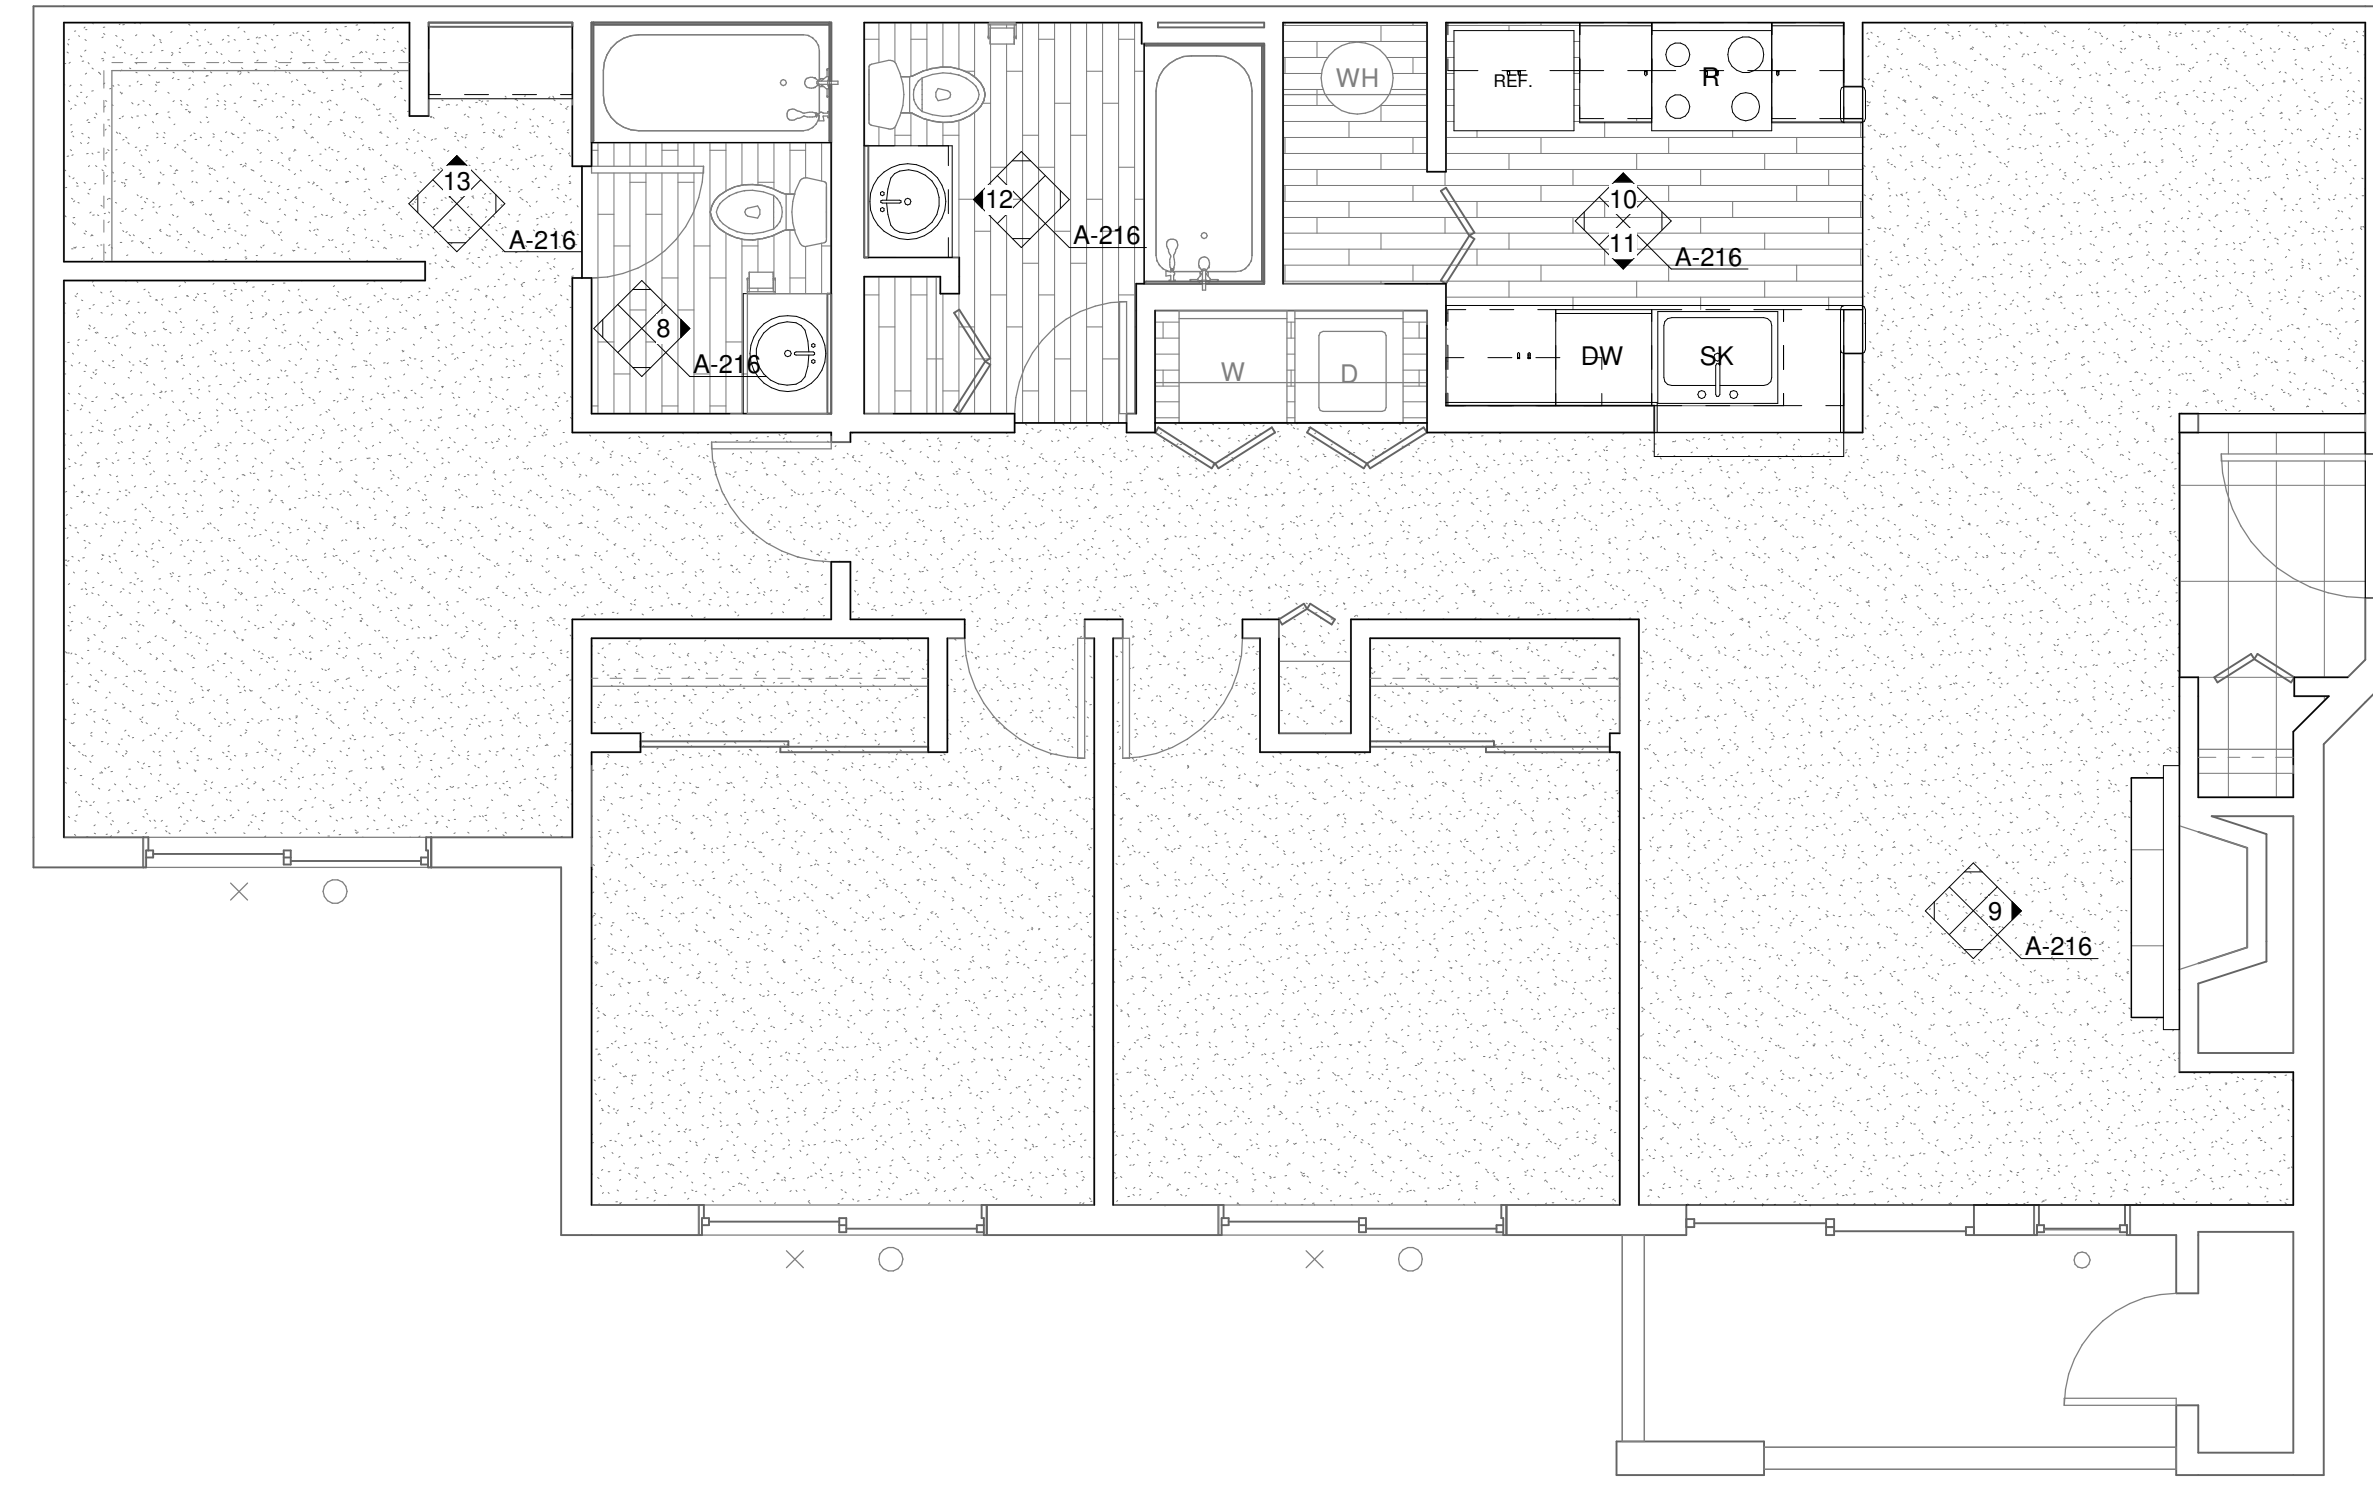

DEMOLITION NOTES

#	DESCRIPTION
1	REPLACE ALL EXISTING FLOORING & BASE AND FIREPLACE HEARTH. PREP FOR NEW FINISH AS REQUIRED.
2	DEMO ALL EXISTING UPPER & LOWER CABINETS AND PLUMBING FIXTURE AT KITCHEN. ALL EXISTING APPLIANCES TO BE REMOVED. PREP WALL AND FLOOR FOR NEW FINISHES.
3	REPLACE EXISTING LIGHT FIXTURES. PREP FOR NEW FIXTURE AS REQUIRED.
4	DEMO ALL EXISTING LOWER CABINET, PLUMBING FIXTURE & MIRROR. PREP FOR NEW FINISHES AS REQUIRED.
5	DEMO HALF WALL AND EXISTING COUNTER TO ACCOMMODATE NEW COUNTER.
6	MEDICINE CABINET TO BE REMOVED AND REPLACED BY OWNER.
7	DEMO EXISTING MANTLE & FIRE PLACE TILE SURROUND. PREP FOR NEW FINISHES. SEE FIREPLACE ELEVATION FOR DETAILS.
8	REMOVE EXISTING COUNTERSHELF AT LIVING ROOM. PATCH & REPAIR WALL AS REQUIRED FOR NEW FINISHES.
9	REPLACE EXISTING SHOWER HEAD, SHOWER CONTROL KNOB, VALVE, AND ASSOCIATED RISER PIPING.
10	SEE DETAIL 1/A-213 FOR BATHTUB CONTROL AND GRAB BAR LOCATIONS FOR BATHROOMS.

KEYNOTES

#	DESCRIPTION
00 00 22	REMOVABLE CABINET, EXTEND FLOORING TO WALL AT BACK OF EACH REMOVABLE CABINET
09 30 13	CERAMIC TILING
11 30 13.A1	RANGE
11 30 13.A3	DISHWASHER
11 30 13.A4	REFRIGERATOR
12 32 00	MANUFACTURED WOOD CASEWORK
12 36 61.19	QUARTZ AGGLOMERATE COUNTERTOPS
22 40 00.A2	LAVATORY/FAUCET
22 40 00.A4	UNDER COUNTER SINK/FAUCET

