


MULTICARE GOOD SAMARITAN HOSPITAL VACUUM PUMP REPLACEMENT

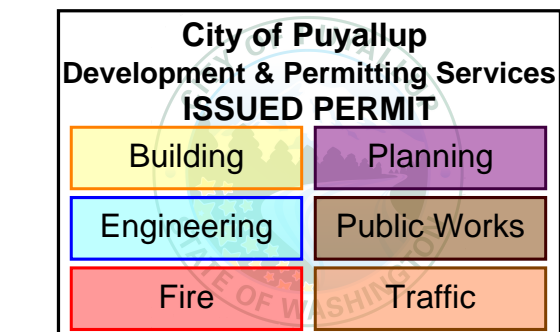

HULTZ BHU
engineers inc
1111 Fawcett Ave Suite 100 Tacoma, WA 98402
Phone: (253) 383-3257 Fax: (253) 383-3283
general@hultzbhu.com Job Number: 21-050

MULTICARE GOOD SAMARITAN HOSPITAL
VACUUM PUMP REPLACEMENT
401 15TH AVE SE, PUYALLUP, WA 98372

PROJECT INFORMATION

OWNER
GOOD SAMARITAN HOSPITAL
PO BOX 1247
PUYALLUP, WA 98371

PROJECT MANAGER: STEVE PRIDEAUX (253) 732-5849
pridest@multicare.org

PROJECT MANAGER
CBRE

CONTACT: STEFANIE DYER (253) 208-0911
sdyer@multicare.org

DESIGN TEAM

ENGINEER
HULTZ BHU ENGINEERS, INC.
1111 FAWCETT AVENUE, SUITE 100
TACOMA, WASHINGTON 98402

MECHANICAL: MICHAEL TAGLES, PE (253) 383-3257
michaelt@hultzbhu.com

ELECTRICAL: NEIL MORSE, PE (253) 383-3257
neilm@hultzbhu.com

DRAWING INDEX

G1.0 COVER SHEET
M0.01 MECHANICAL LEGEND & NOTES
M0.02 MECHANICAL SCHEDULES
M1.01 PARTIAL 1ST FLOOR PLAN - MECHANICAL DEMO
M1.02 ENLARGED PLAN - MECHANICAL ROOM DEMO
M3.01 PARTIAL 1ST FLOOR PLAN - MECHANICAL
M3.02 ENLARGED PLAN - MECHANICAL ROOM
M3.03 MECHANICAL DETAILS

PROJECT DESCRIPTION


BASE BID:
1. REMOVE THE EXISTING MEDICAL VACUUM PLANT EQUIPMENT SERVING THE EXISTING FOREST TOWER AND REPLACE WITH NEW MEDICAL VACUUM PLANT EQUIPMENT.

WORK RESTRICTIONS


1. WORK HOURS SHALL BE 7:00 AM TO 4:30 PM, MONDAY THRU FRIDAY, ONLY.
2. ELECTRICITY AND MEDICAL GAS SYSTEM INTERRUPTIONS REQUIRE 72 HOUR ADVANCE NOTICE AND AGREEMENT BY THE OWNER AS TO THE TIME, AND MAY ONLY OCCUR WITH THE OWNER'S PERMISSION. SUCH INTERRUPTIONS MAY ALSO OCCUR ONLY TWICE DURING THE PROJECT, AND MAY HAVE A MAXIMUM INTERRUPTION OF 2 HOURS PER OCCURRENCE.

PROJECT LOCATION

GOOD SAMARITAN HOSPITAL
401 15TH AVE SE
PUYALLUP, WA 98372

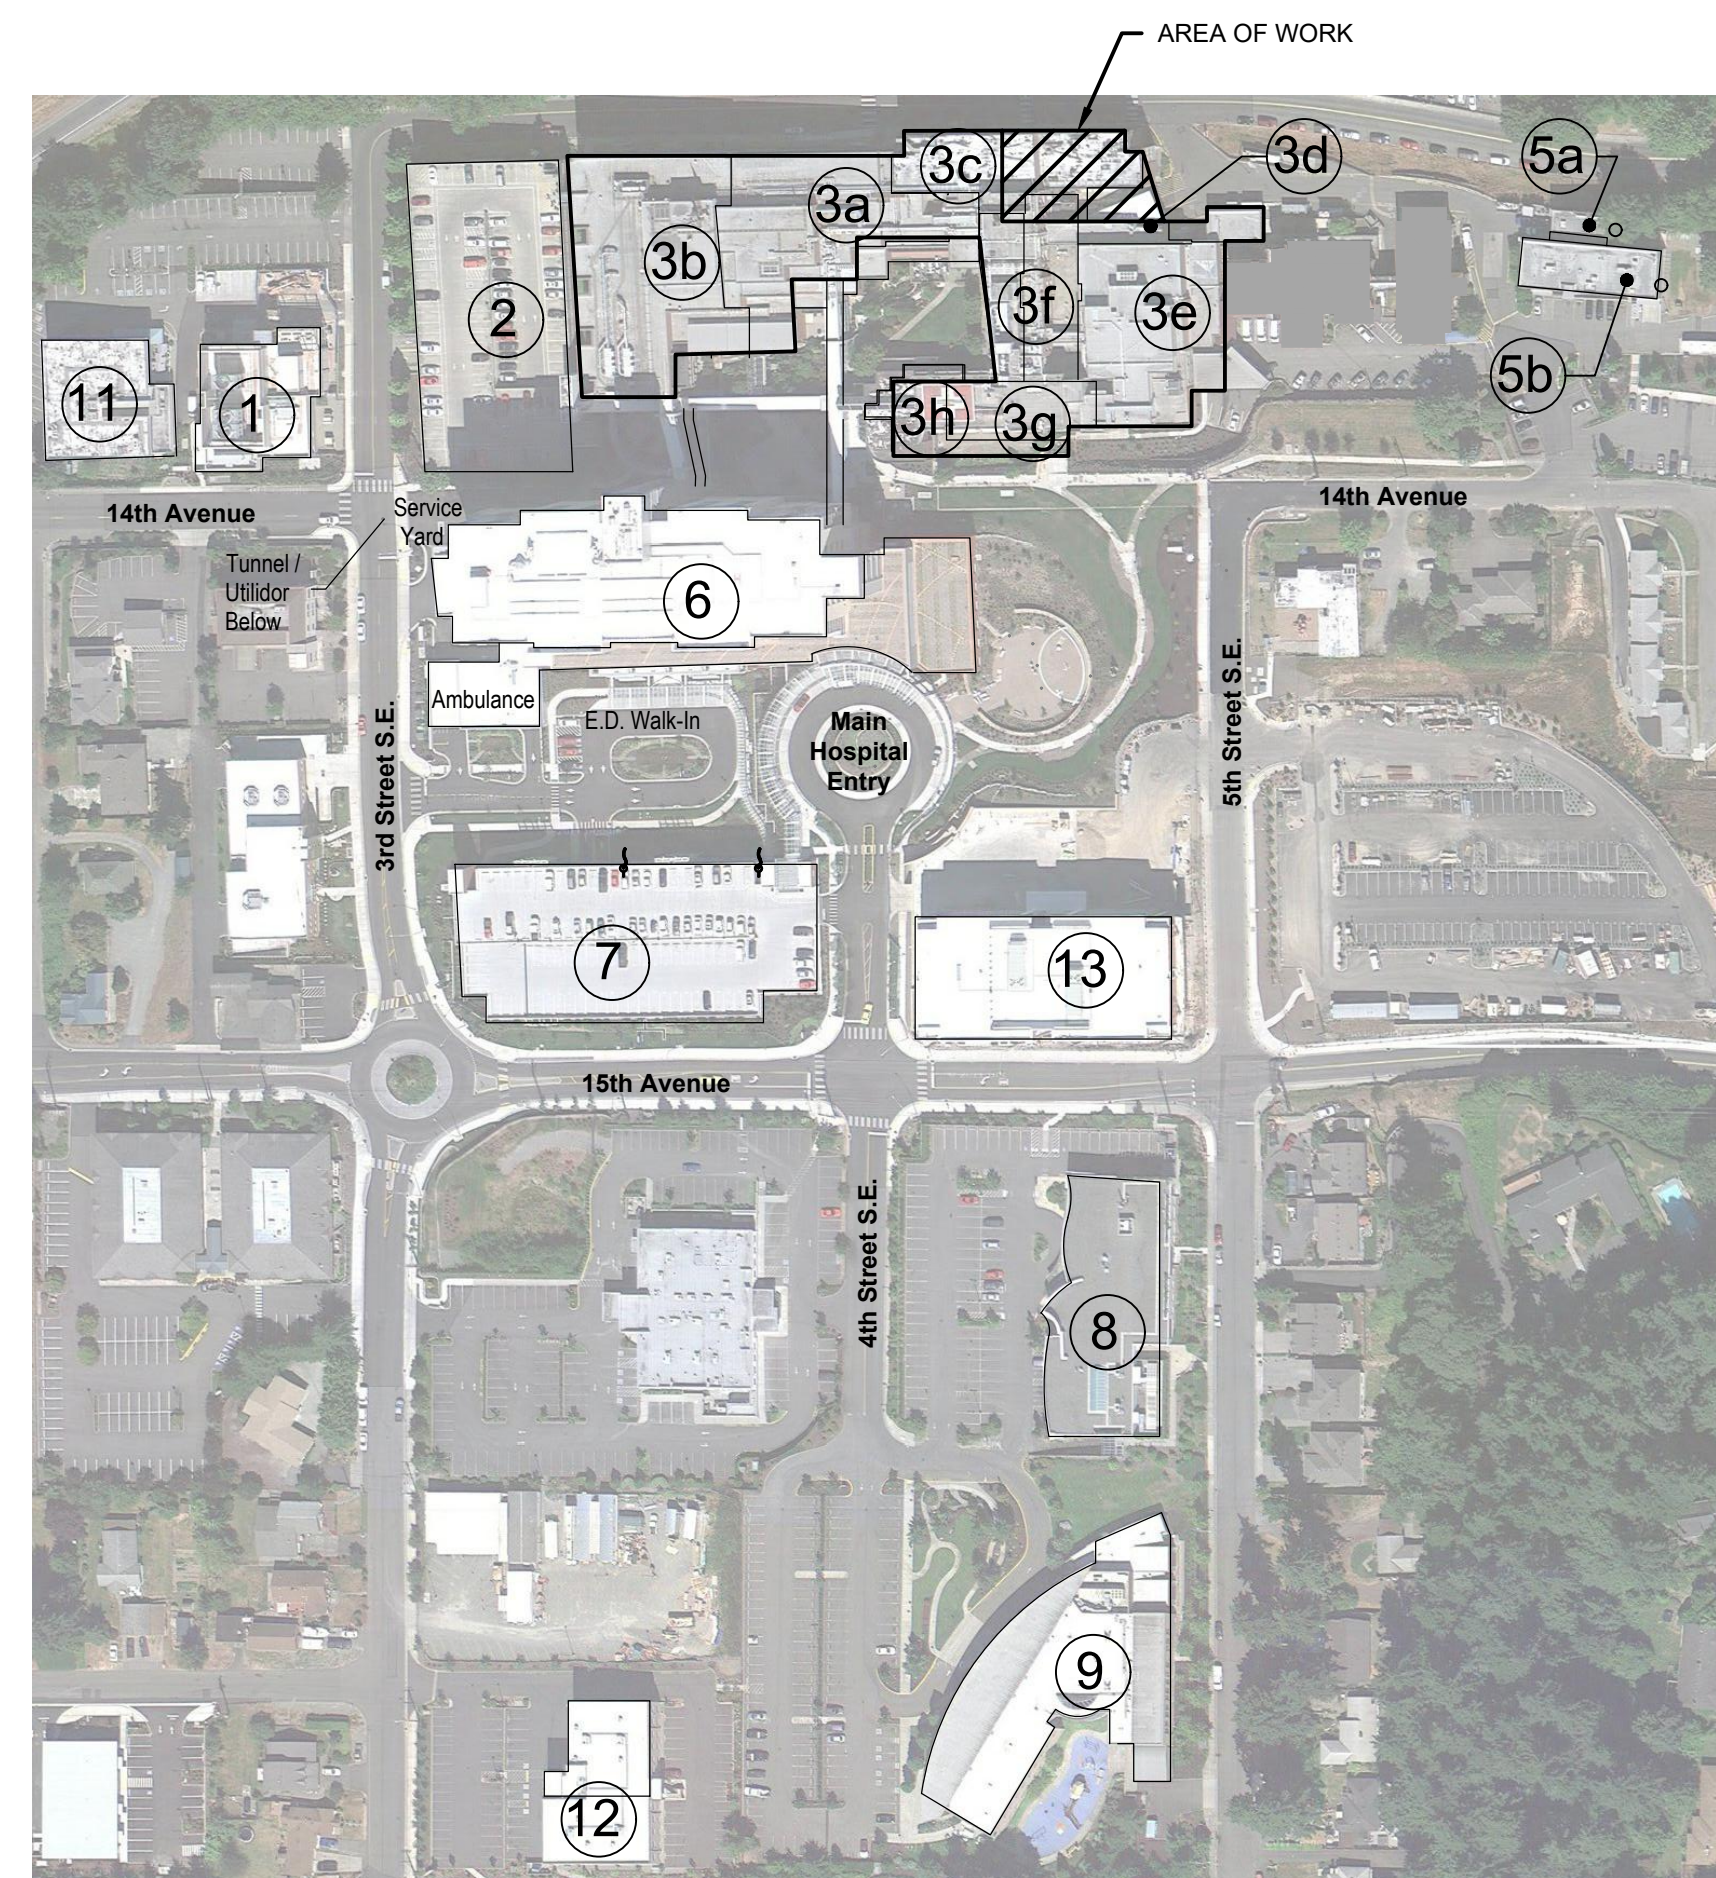


- 1 CENTRAL UTILITY PLANT
- 2 PARKING STRUCTURE 2
- 3a MEADOW (WEST 1)
- 3b MEADOW (WEST 2)
- 3c FOREST (NORTH)
- 3d RIVER (SUPPORT SERVICES)
- 3e RIVER (EAST)
- 3f RIVER (CENTRAL)
- 3g RIVER (SOUTH)
- 3h RIVER (LOBBY)
- 4a N/A
- 4b N/A
- 5a GENERATOR
- 5b FACILITIES
- 6 DALLY TOWER
- 7 PARKING STRUCTURE 1
- 8 CANCER CENTER:
- 9 CHILDREN'S THERAPY UNIT
- 10 NOT SHOWN
- 11 PVMC
- 12 RIEDER BUILDING
- 13 MEDICAL OFFICE BUILDING

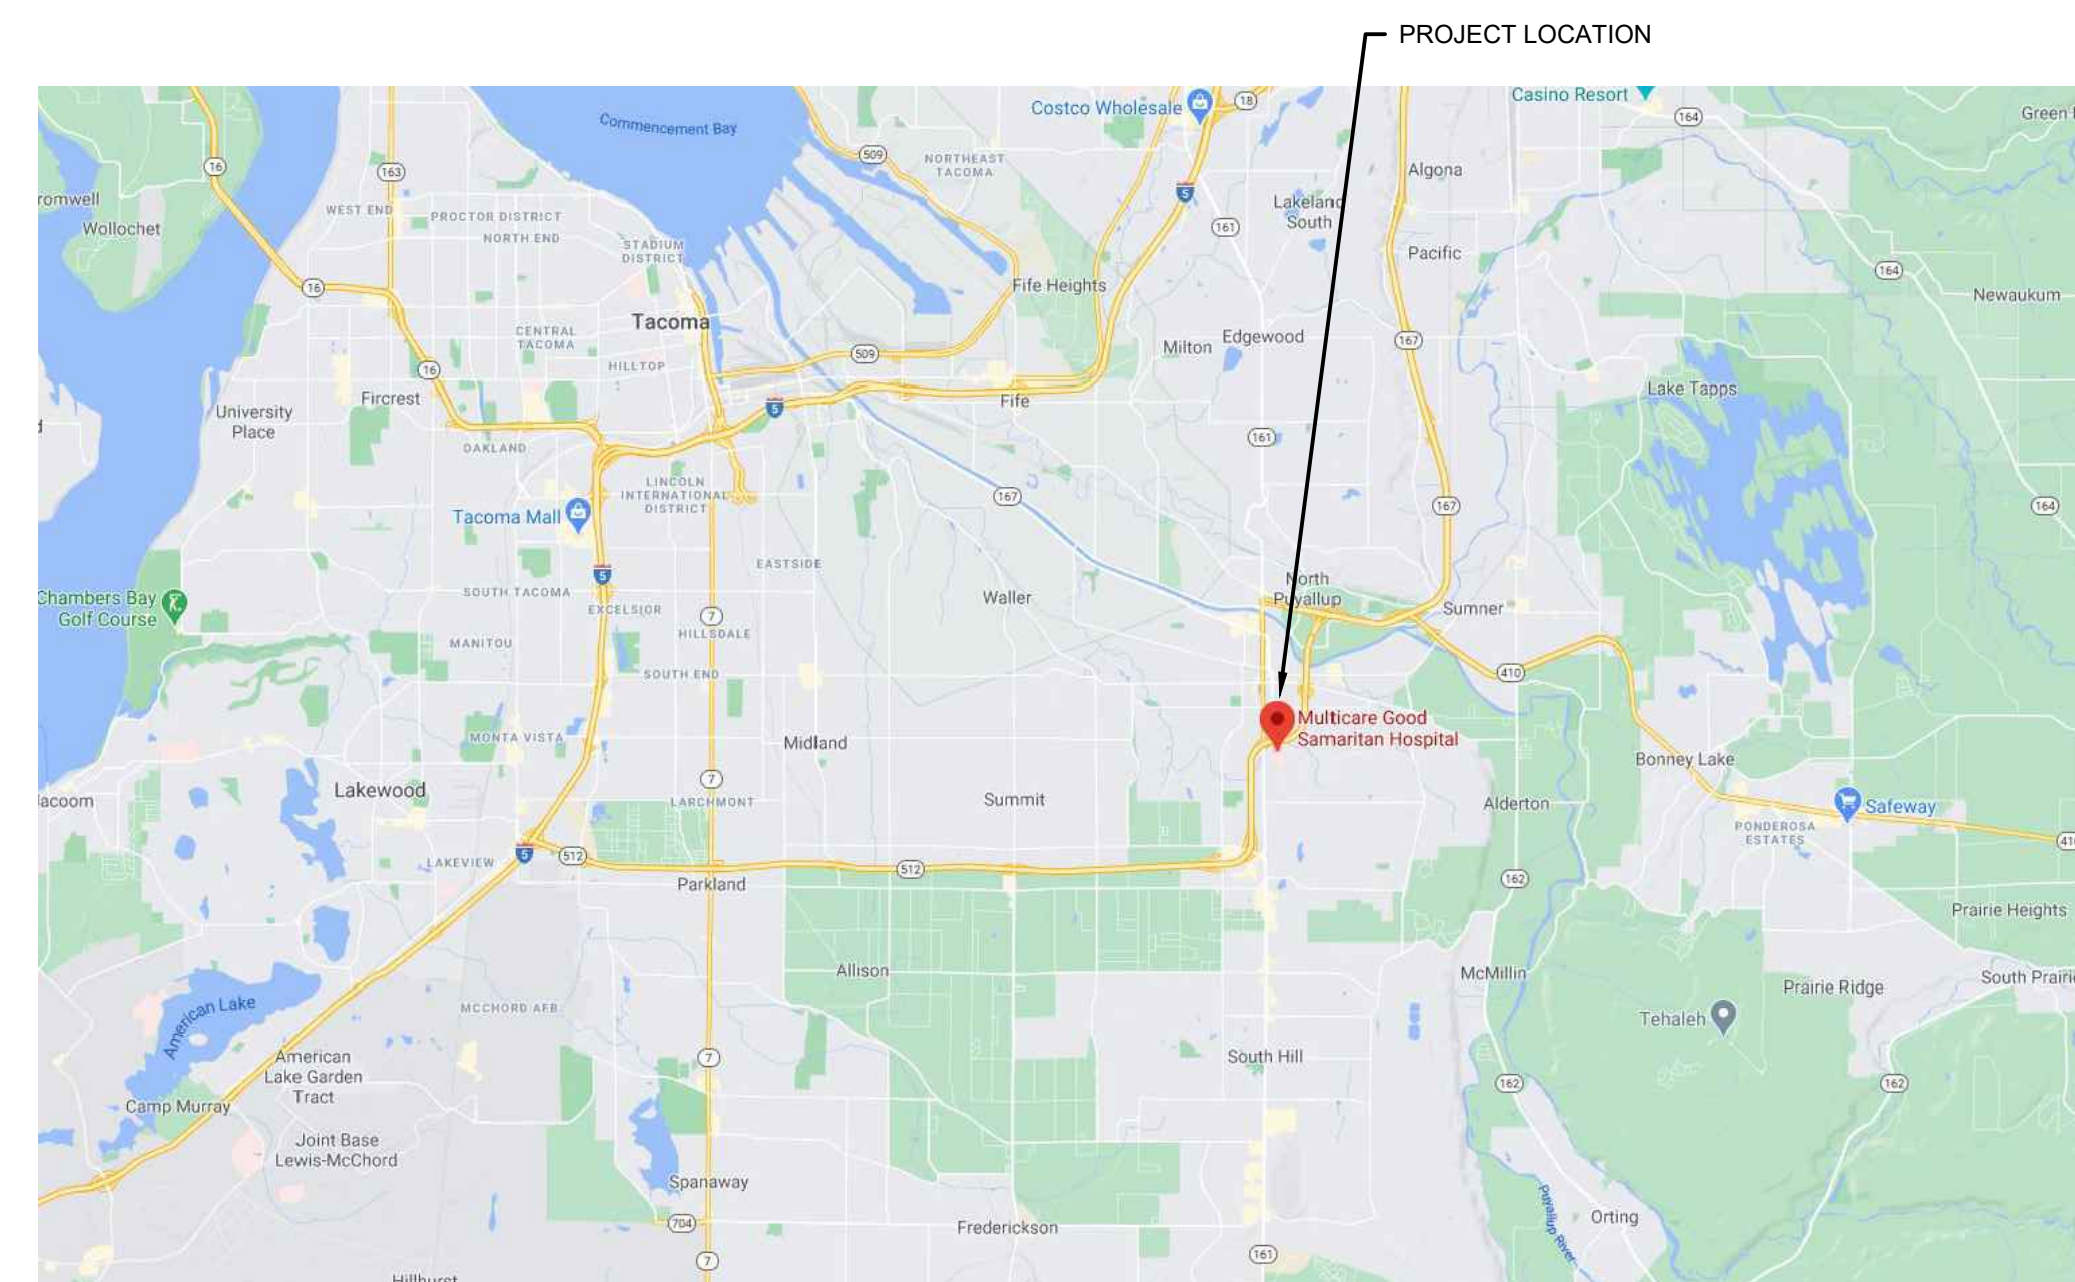

VICINITY MAP

SITE MAP

PERMIT RESUBMITTAL SET 10-14-21

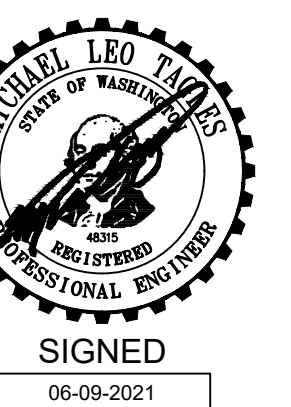

SHEET TITLE: COVER SHEET
DRAWN: MB CHECKED: MT
DATE: 06.09.21 PROJECT NO. 21-050
REVISIONS:

G1.0

0" 1" 2"
SHEET SIZE IS TRUE SCALE WHEN ABOVE LINE MEASURES AS NOTED