



LEVEL 1 EAST FLOOR PLAN  
SCALE 1/8" = 1'-0"

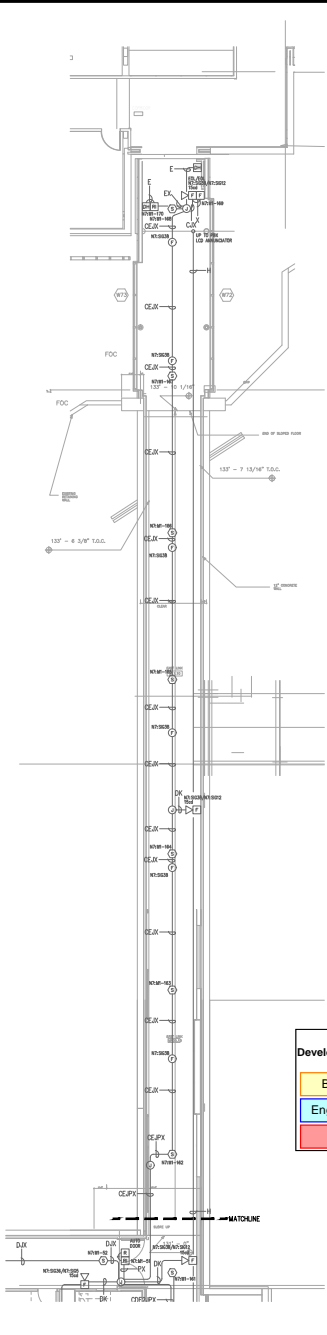

LEVEL 1 EAST LINK FLOOR PLAN  
SCALE 1/8" = 1'-0"

Symbol	Description	Part #	Backbox
[S]	Multicandela Wall Speaker/Strobe - White	4906-9153	2" sq 2.875" deep w/ end ring 4"sq adapter by EC
[S]	Multicandela Ceiling Speaker/Strobe - White	4906-9154	2" sq 2.875" deep w/ end ring 4"sq adapter by EC
[S]	Multicandela Wall Speaker - White	4906-9103	4" sq by EC
[S]	Multicandela Ceiling Speaker - White	4906-9102	4" sq by EC
[S]	Wall Speaker - White	4906-9177	2" sq 2.875" deep w/ end ring 4"sq adapter by EC
[S]	Ceiling Speaker - White	4906-9721	2" sq 2.875" deep w/ end ring 4"sq adapter by EC
[M]	Addressable Manual Station	4999-9000 w/ 2111 100 Cover	4" sq 2 1/8" deep w/ 3 gang cover by EC
[S]	TriAlarm Smoke Sensor	4906-9714 w/ 4906-9702 Base	4" sq by EC
[S]	TriAlarm Heat Sensor	4906-9733 w/ 4906-9702 Base	4" sq by EC
[S]	Heat Detector - 120V	4906-9702 Base ED-2036/EA	4" sq by EC
[S]	TriAlarm Dust Sensor	4906-9750	self-contained
[S]	Remotes LED w/ Test	2096-9896	sq by EC
[S]	Dust Detector Relay	4998-9843	4" sq w/ig & cover by EC
[S]	Beam Smoke Detector - Transistor	BEAM1224	Surface Box w/BEAMSMK Surface
[S]	Monitor ZAM	4906-9101	4" sq 2 1/8" deep w/ 3 gang cover by EC
[S]	Supervised IAM	4906-9001	4" sq w/ig & cover by EC
[S]	Flow Switch	By Others	By Others
[S]	Pressure Switch	By Others	By Others
[S]	Low Air Switch	By Others	By Others
[S]	Tamper Switch	By Others	By Others
[S]	Pretest Indicator Valve	By Others	By Others
[S]	Door Holders	By Others	By Others
[S]	Relay IAM	4996-9002	4" sq 2 1/8" deep w/ self-contained
[S]	Remote Relay	2096-9006	self-contained
[S]	FFT Jack	3584-9001	sq by EC
[S]	FFT Cabinet	2884-9028 w/ 101-2884-9028 handles	23.5" x 23.5" w x 4.0"D
[S]	Fire Control Panel	CEP-4-65-6PS	41" x 29" x 4.3"D
[S]	Printer	4190-9013	Table Top
[S]	LCD Annunciator	4603-9101	6-gang 3.5" deep by EC or RSA-999-5A
[S]	Terminal Cabinet	SBJL0061	17" x 13.5" x 5.5"
[S]	Transponder Panel	4100-9601	58" x 24" x 1.375"
[S]	Transponder Panel	4100-9601	29" x 8.42"
[S]	Fire Alarm Control Unit	4100-9114	58" x 24" x 1.375"
[S]	Network Display Unit	4100-9151	58" x 24" x 1.375"

Letter	Qty	Color/Type	Size	Function
A	2	Red/Orange TFF	16	Zone
C	2	Red/Blue THHN	14	Home/Stroke
D	4	(2) Red(2) Blue THHN	14	Home/Stroke Loop
E	2	Brown/White THHN	14	Door Holders
F	2	Orange THHN	14	Fan Shutdown
H	1	WspParr D975	16	Serial Communication
J	1	WspParr 991	16	Speaker
K	2	WspParr 991	16	Speaker Loop
L	1	WspParr 5220F2	16	Local Network Connection**
M	1	WspParr 5220F2	16	Minimax Transponder**
N	2	WspParr D975	16	Network Connection
P	2	Red/Blue THHN	14	240VDC Power
R	2	Blue/White TFF	16	Remote LED w/ Test
S	2	Pink TFF	14	Fire
T	1	WspParr 991	16	Fire Fighter Telephone
U	1	WspParr D977	16	Printer
X	1	WspParr D975	16	Addressable Data Line

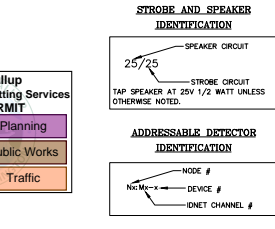

City of Puyallup  
Development & Permitting Services  
**ISSUED PERMIT**

Building	Planning
Engineering	Public Works
Fire	Traffic

REVISION 47 GENERAL NOTES:  
1. EXISTING DEVICE LOCATIONS AND WIRING ARE SHOWN LIGHT AND ARE BASED UPON RECORD DRAWING. CONTRACTOR TO RED LINE AND NOTE ANY AND ALL CHANGES ON THE RECORD DRAWING SET.

**Johnson Controls**  
9605 15th Avenue SW, Suite 100  
Shelton, WA 98106  
PHONE: 206-291-1411  
FAX: 206-291-1500

NO.	DATE	REVISION DESCRIPTION	DESIGNER (INITIALS)	CHECKER (INITIALS)	DATE	BY	DATE	BY
42	8/27/09	ISSUE FOR CONSTRUCTION						
43	8/28/09	ISSUE FOR CONSTRUCTION						
44	8/28/09	ISSUE FOR CONSTRUCTION						
45	8/28/09	ISSUE FOR CONSTRUCTION						
46	8/28/09	ISSUE FOR CONSTRUCTION						
47	8/28/09	ISSUE FOR CONSTRUCTION						

DRAWINGS REVIEWED BY:  
C. McCAMMON  
N. C. McCammon  
N. C. McCammon

FIRE ALARM SYSTEM  
LEVEL 1 EAST FLOOR PLAN  
GOOD SAMARTIAN - PATIENT CARE TOWER

APPROVED BY:  
C. McCAMMON

DRAWN BY:  
C. McCAMMON

DATE:  
8/12/09

STW/PROJECT NUMBER:  
4584131-1/343123501

SHEET NUMBER:  
FA-LEV1-E