

**City of Puyallup
Fire
REVIEWED
FOR
COMPLIANCE**

DDrake
10/31/2022
1:24:12 PM




THE APPROVED CONSTRUCTION PLANS AND ALL ENGINEERING MUST BE POSTED ON THE JOB AT ALL INSPECTIONS IN A VISIBLE AND READILY ACCESSIBLE LOCATION.

Approval of submitted plans is not an approval of omissions or oversight by this office or noncompliance with any applicable regulations of local government. The contractor is responsible for making sure that the building codes and regulations of the local government.

**City of Puyallup
Development & Permitting Services
ISSUED PERMIT**

Building	Planning
Engineering	Public Works
Fire	Traffic

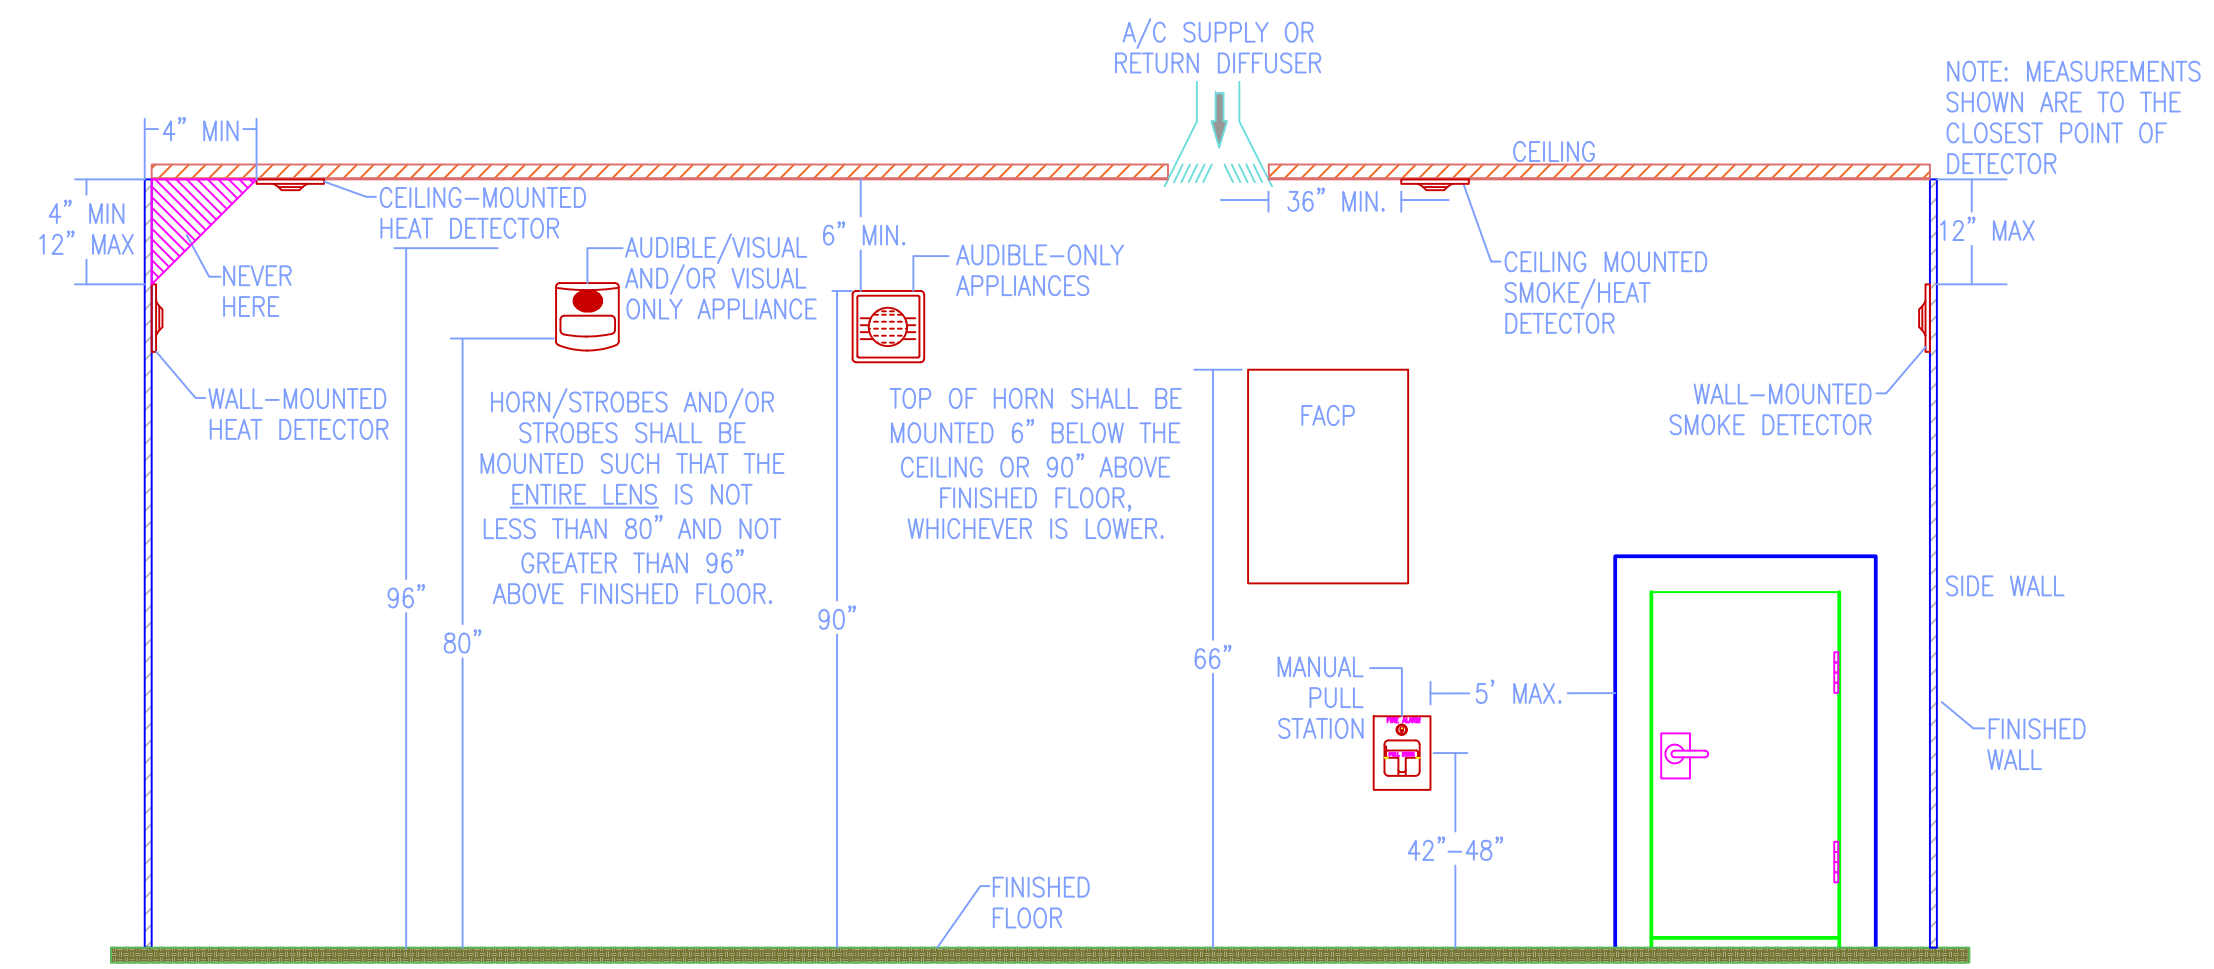


FIRE ALARM DEVICE MOUNTING HEIGHTS

SCALE: NOT TO SCALE

NOTES:

1. LOCATE CEILING MOUNTED HEAT/SMOKE DETECTORS ON THE BOTTOM OF THE DECK/SUSPENDED CEILING (NOT ON BOTTOM OF STRUCTURAL MEMBERS), AND AS INDICATED IN NFPA 72.
2. LOCATE CEILING MOUNTED NOTIFICATION DEVICES ON BOTTOM OF BEAMS OR JOISTS; WITH CLEAR LINE OF SITE IN ALL DIRECTIONS; NO GREATER THAN THIRTY (30) FEET ABOVE THE FINISHED FLOOR; AND AS INDICATED IN NFPA 72.
3. LOCATE CEILING MOUNTED NOTIFICATION DEVICES FLUSH WITH THE SUSPENDED CEILING; ALIGNED WITH LIGHTING, SPRINKLERS, AND OTHER ARCHITECTURAL FIXTURES; WITH CLEAR LINE OF SITE IN ALL DIRECTIONS; NO GREATER THAN THIRTY (30) FEET A.F.F. ; AND AS INDICATED IN NFPA 72.
4. LOCATE WALL MOUNTED NOTIFICATION DEVICES AT 80" A.F.F TO BOTTOM OF BACK BOX.
5. COORDINATE EXACT MOUNTING HEIGHT OF CONTROL PANELS, ANNUNCIATORS, AND POWER SUPPLIES WITH THE GENERAL CONTRACTOR, ELECTRICAL CONTRACTOR AND AHJ PRIOR TO INSTALLATION.
6. MEASURED TO THE OPERABLE PART OF THE PULL STATION.

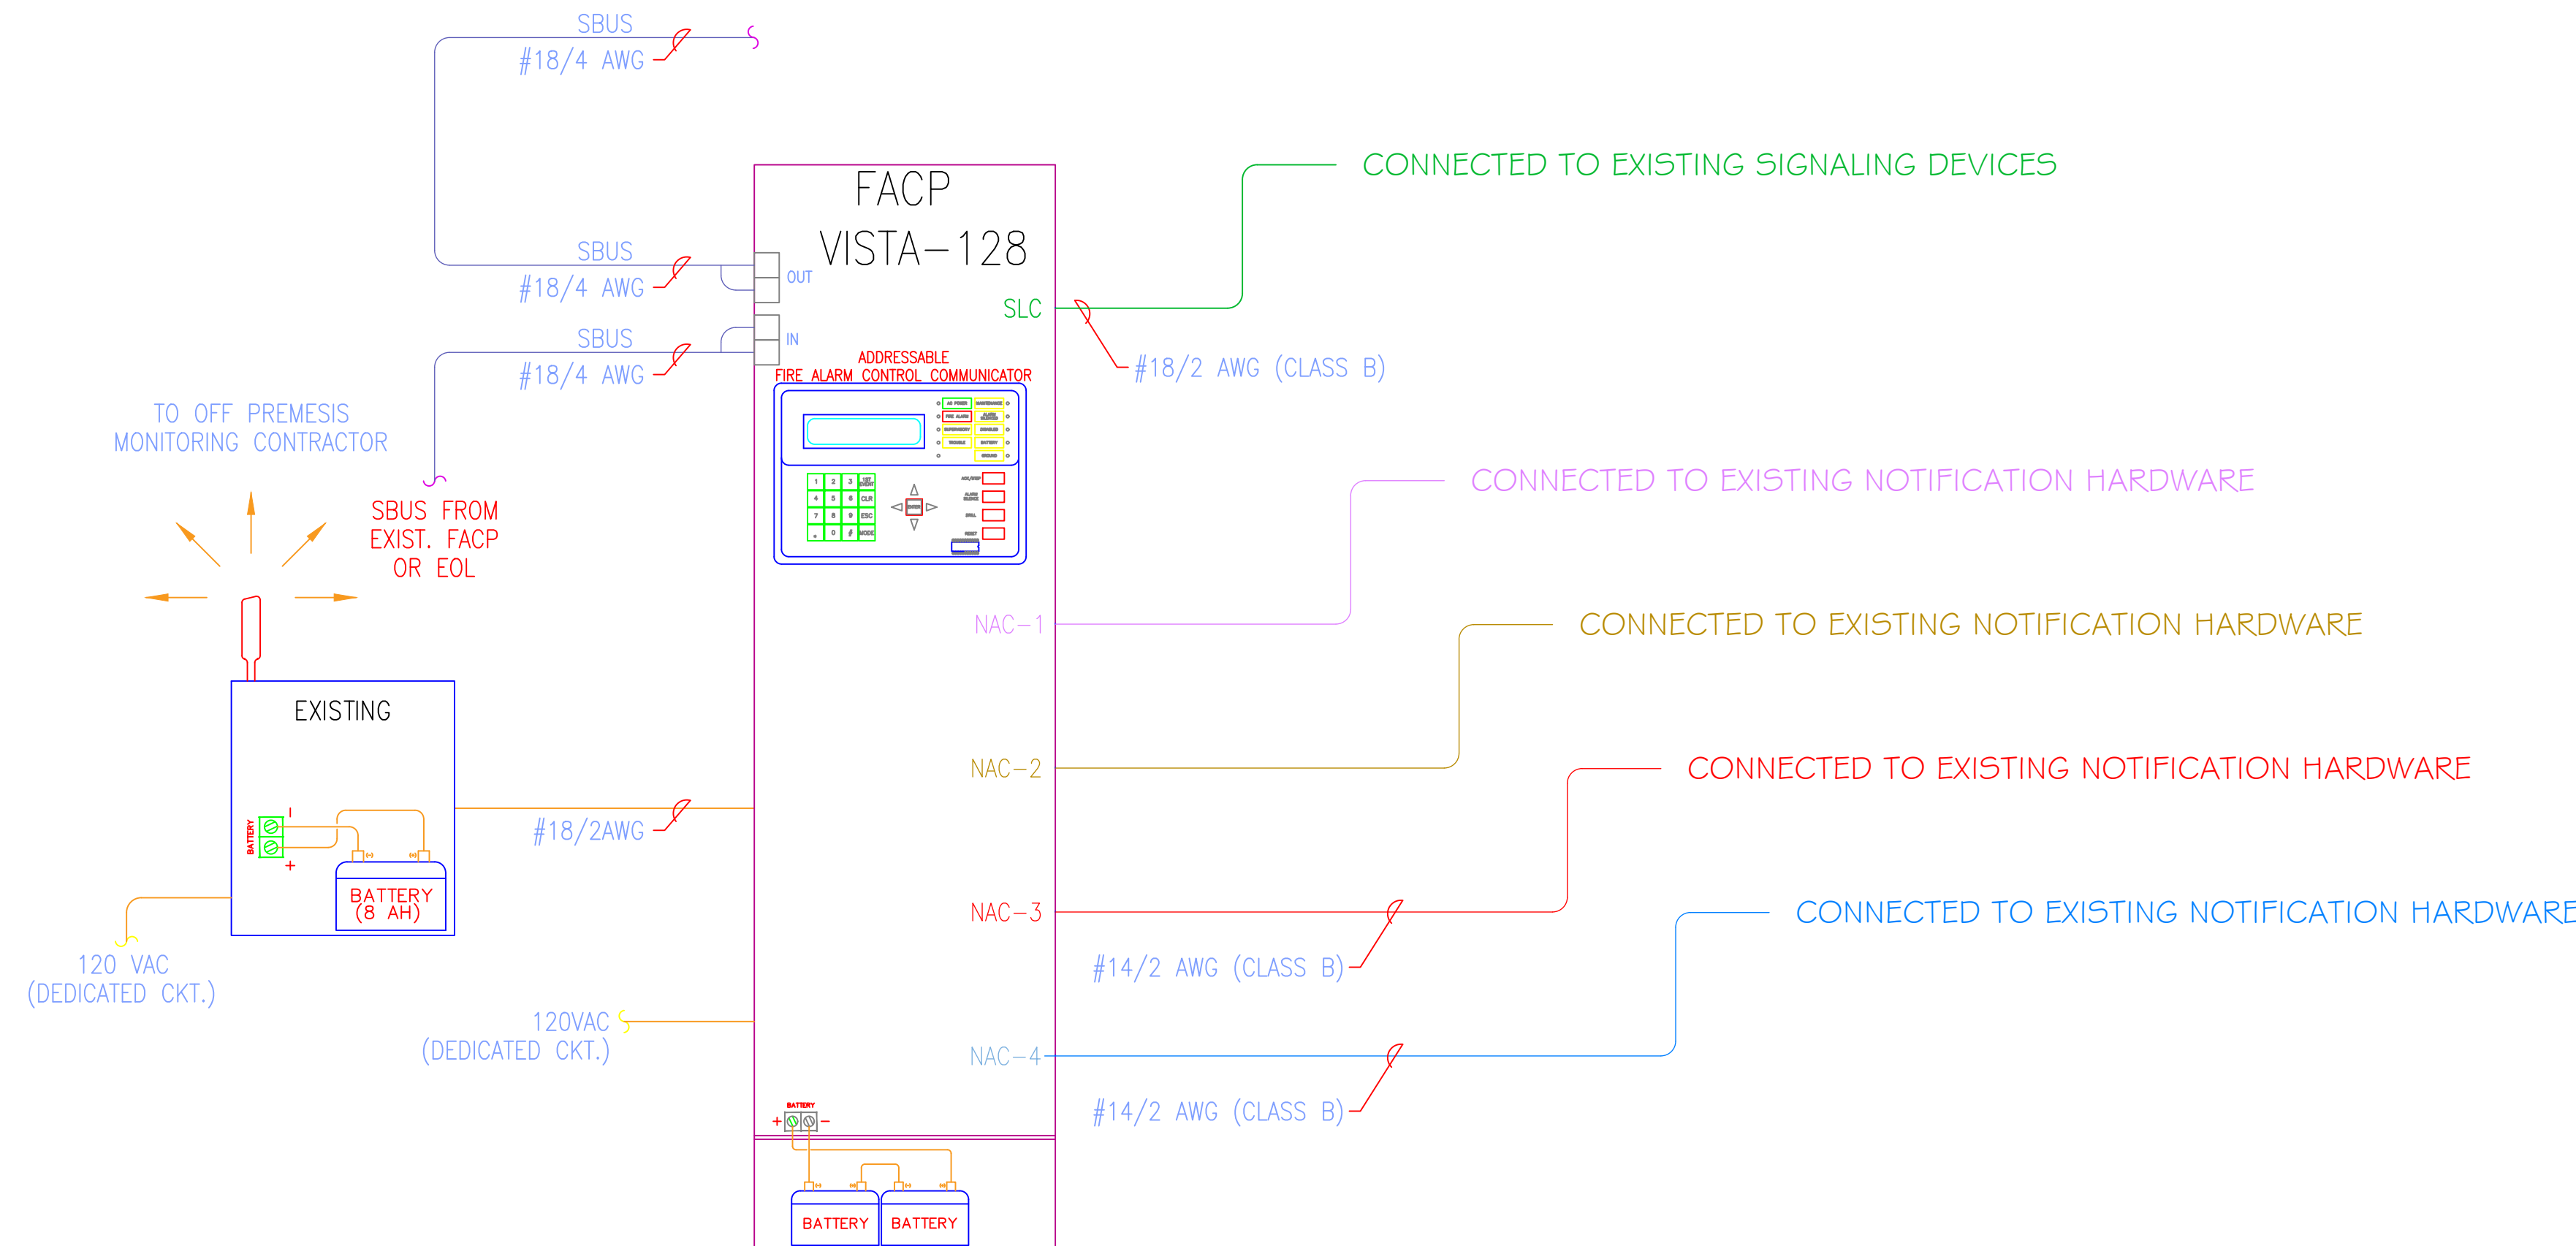

FIRE ALARM RISER DIAGRAM

SCHEMATIC: NO SCALE

4500 3rd AVE. SE., Suite #1
LACEY, WA 98503
800-354-1555
CONTRACTOR'S LIC. NO.-STANLCS92561Z
A DIVISION OF STANLEY CONSUMER SECURITY SOLUTIONS



Rev:	Date:	Description:
A	###/###/###	###

Date:	August 12, 2022
Drawn By:	T.Pennington
Email:	thomas.pennington@sbdinc.com
Job #:	PJ1US.0003453.0001
File Name:	Supper Supplements 1013
DWG Name:	Riser Diagram
Plot Date:	September 21, 2022
Version:	AutoCAD 2023

Project Name: Supper Supplements #1013
4307 S Meridian
Puyallup, WA 98373-5926
Parcel# 1200040449

Sheet Number

RISER