


FRU-22 REPL 1 POLE DISTRIBUTION POLE REPLACEMENT

PRFUP20241401

City of Puyallup
Development & Permitting Services
ISSUED PERMIT

Building	Planning
Engineering	Public Works
Fire	Traffic

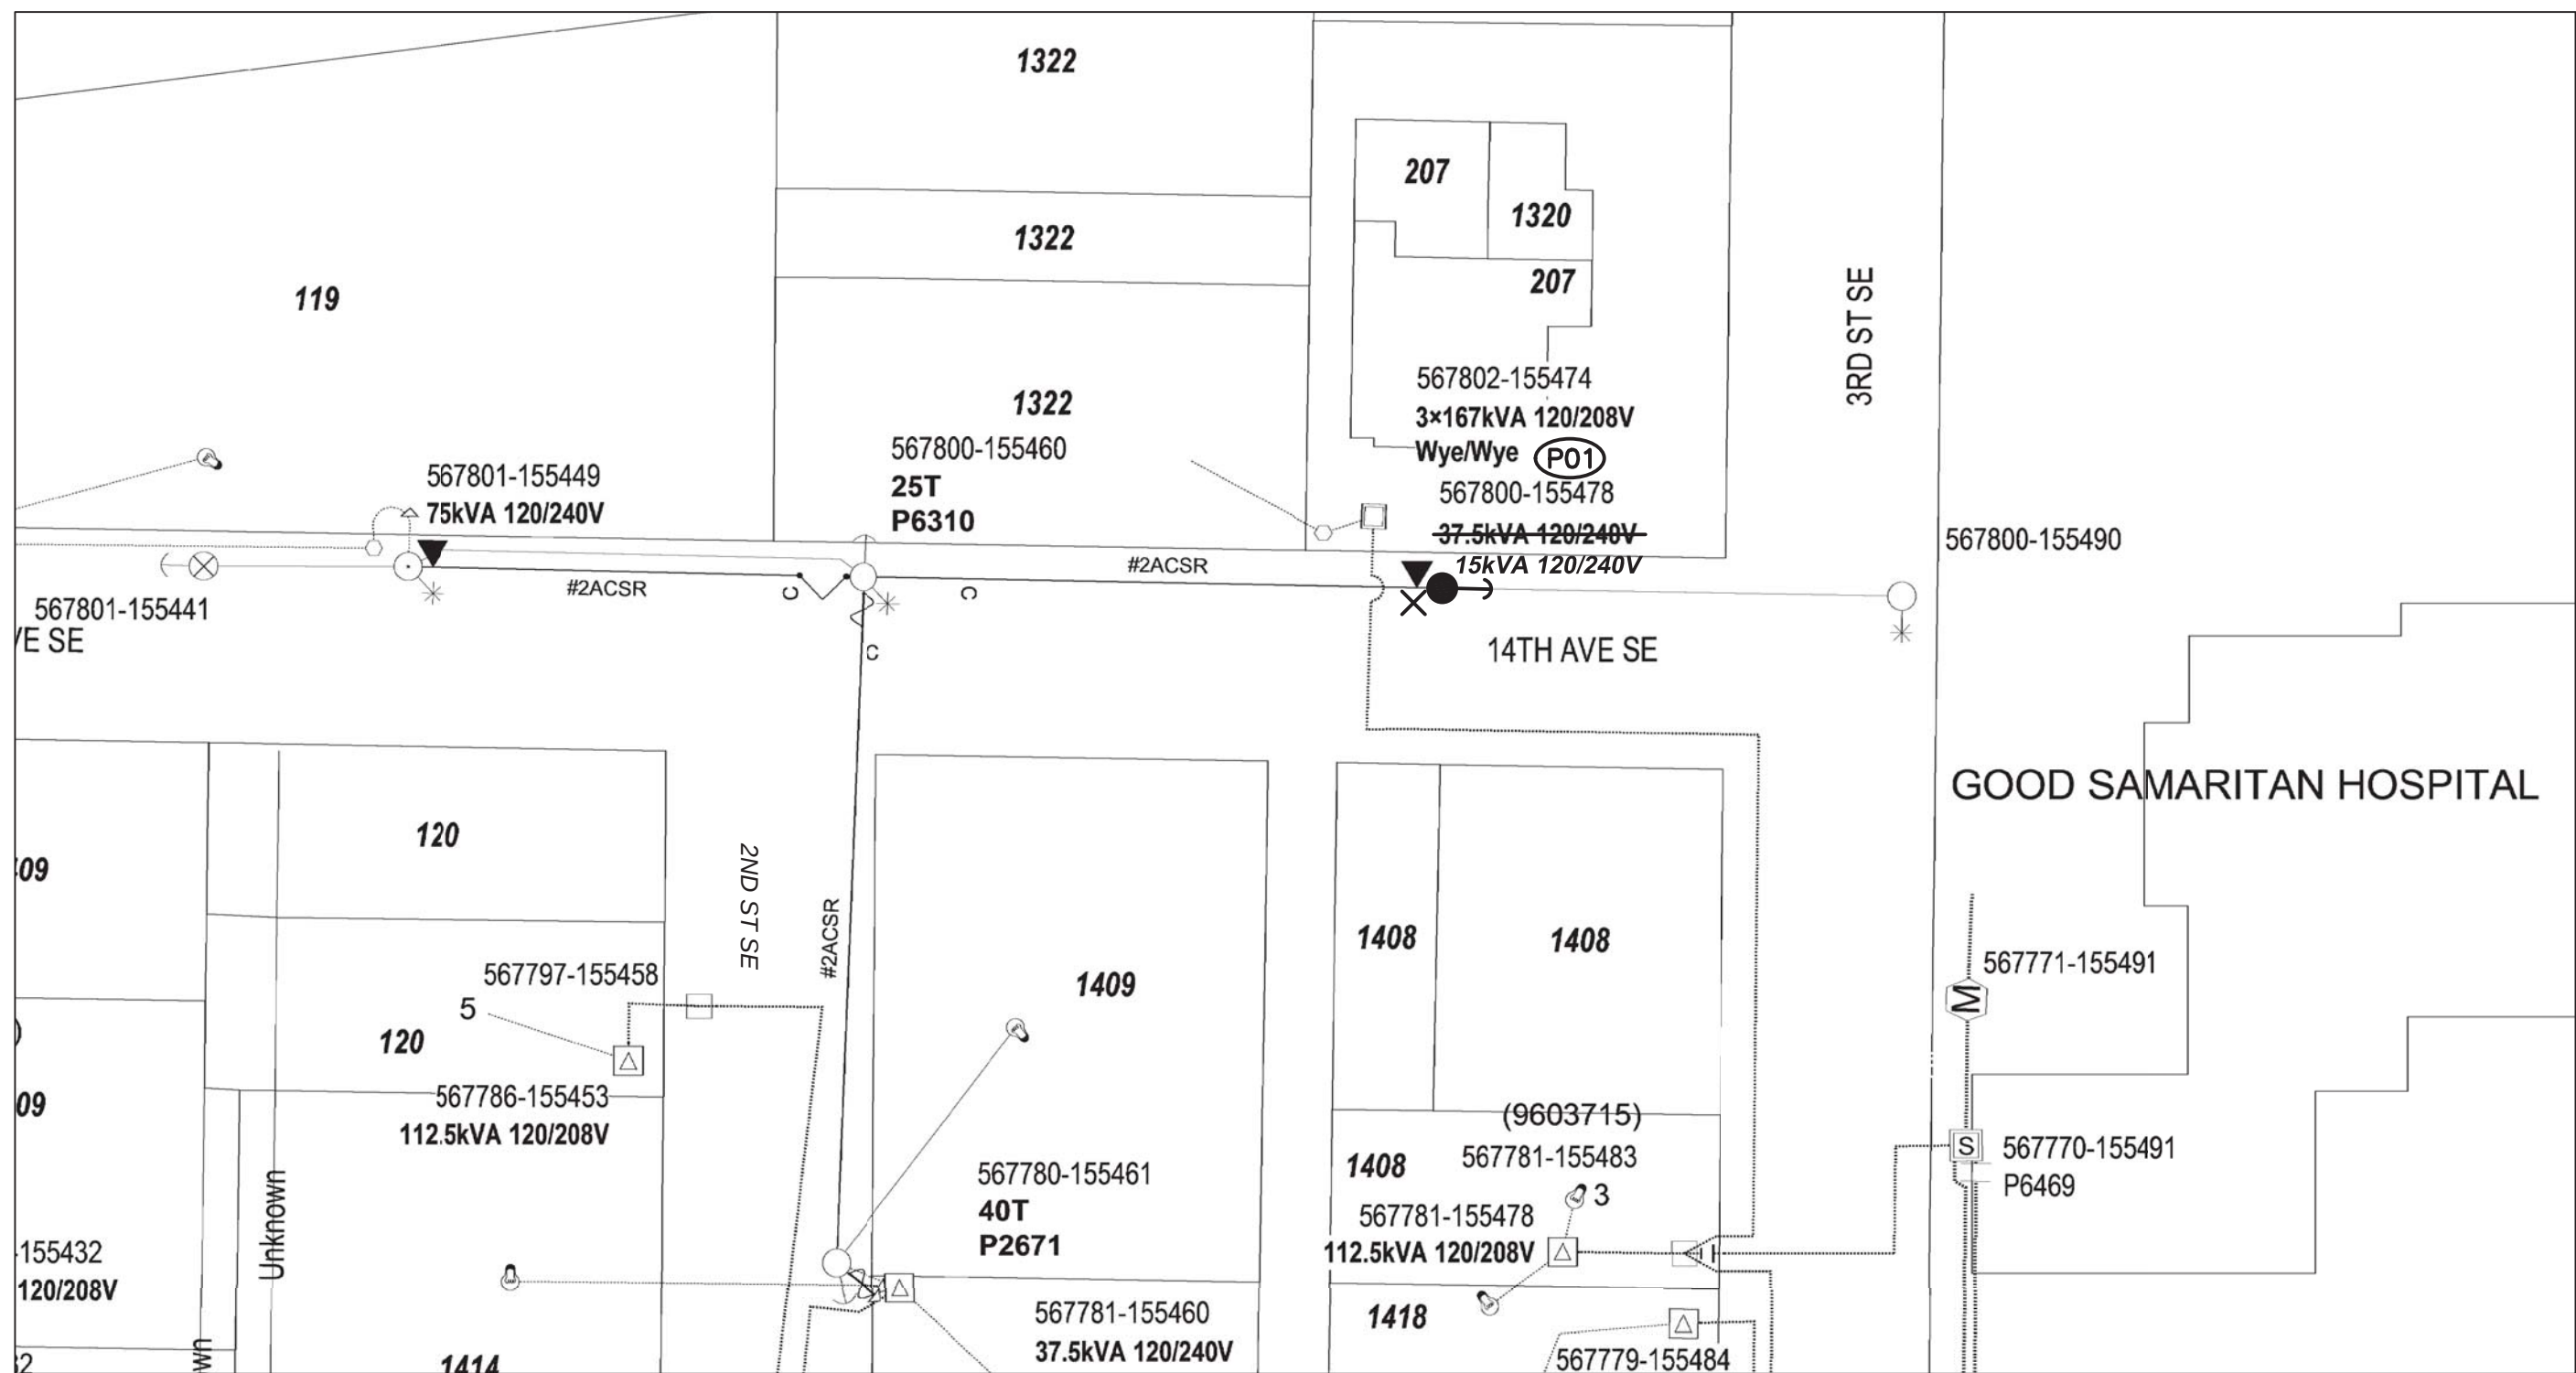

SITE PLAN

1" = 50'

P01: 567800-155478

BRUSH CLEARING REQ'D

-EX 40' CL 3, 1969 POLE TO BE REPLACED

-INST 45' CL 3 (PD453) 6010.1000

-INST 10' #2ACSR PRI & NEUT (DE2115) 6031.1040

-TRANSFER 10' #2ACSR PRI & NEUT (W)

-RM RUSTY 37.5kVA XFMR & L/B C/O

-INST 15kVA 120/240v XFMR (TRFLXF) 6025.1000

-TRANSFER OH TFX SEC

-RM EX RISER

-REMOVE IDLE 4/0 UG TFX SEC: ±35

-CUT & CAP AT BASE OF POLE

-ACTUAL 4/0 UG TFX REMOVED L= _____ BATCH YEAR _____

-ACTUAL TRENCH L= _____

-RETIRE ON WO# 108149065

-INST SINGL HELIX ANC (ANDH1) 6012.1000 (L = 10' E)

-INST 3/8" PRI & NEUT DG'S (GYD3SA)(GYD3SAN) 6013.0100 TO NEW ANC

-TOP POLE ABOVE COMM


-REMOVE POLE STUB AFTER COMM HAS TRANSFERRED

2-81

2-24XR

1-8E

2-129

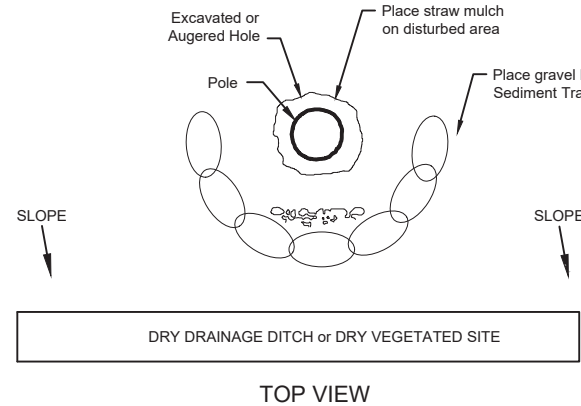

UTILITY POLE EROSION CONTROL DETAIL

Not to scale

Drainage ditches or Dry vegetated sites

All proposed franchise utilities shall be located within a recorded utility easement or in the public right-of-way as determined by the City of Puyallup. The City of Puyallup does not authorize or permit franchise utility work on private property.

Where a curb exists, the lateral offset of all vertical obstructions shall be a minimum of 1.5' from the face of the curb to the face of the vertical obstruction and a minimum of 3' at intersections. Where no curb exists, the lateral offset of all vertical obstructions shall be a minimum of 4' measured from the edge of pavement to the face of the obstruction.

Anchored guy wire shall be installed or retrofit with a minimum 7-feet of overhead sidewalk clearance. The guy-wire shall not obstruct access to any property or to a public or private utility facility. The guy wire shall be anchored in the public right-of-way or within a private utility easement.

A 10" diameter core drill is allowed for potholing. For pothole windows larger than 10" in diameter or trenching completed in existing roadway, the contractor shall restore the pavement by installing the trench patch and then grinding/overlying. All roadway restoration and street patches shall comply with City Standard Detail 01.01.20. Restoration limits and requirements shall be at the discretion of the City.

General

-Return removed materials to the local storeroom or PSE storeroom


OVERHEAD CONSTRUCTION

Poles & Structures

- Poles are to be installed or relocated as staked. Unless otherwise noted, all pole location measurements are from the **roadside face of the pole**.
- All new poles set shall be the class indicated on the sketch, or better. Do not set a lower class pole than specified.
- Install ground plate assembly on all new poles. Install Switch Ground Assembly per standard specification 6014.1000 at new gang operated switch locations.
- Install grid numbers on all new and existing poles as shown on sketch.
- Straighten existing poles as indicated or as necessary.
- Treat all field-drilled poles with copper naphthenate wood preservative.
- Remove old poles after communication companies have transferred off and return to PSE storeroom. Fill and crown pole holes and restore area similar to adjacent landscaping.

Conductors & Equipment

- Transfer all overhead and underground primary, secondary and service conductors and guys to new poles set, unless otherwise indicated on this sketch.
- Transfer existing transformers to new poles unless otherwise indicated on this sketch.
- Use stirrups to connect all overhead and underground primary taps, and all transformers. Install at all sites being worked within the scope of the project where they are currently missing.
- For 12kV construction, always install avian protection with 4/0 Cu covered jumpers and #4 SD aluminum-covered tie-wire (MID 8454500). For 34 kV construction, use bare wire primary jumpers with preformed helical grip ties.
- Apply avian protection devices when required per Standard 6015.2000.
- Apply grit inhibitor on all Ampact, stirrup, and dead-end connections.
- Connect primary taps and transformers to same phase as existing unless otherwise shown on the drawing.
- All neutral connections to be made with solid compression connectors. Connect all pole grounds to common neutral.
- Use Load-interrupter cutouts (with arc shields) on all primary overhead and underground taps with fused protection above 40T.
- Install Wildlife Protectors on all transformers.

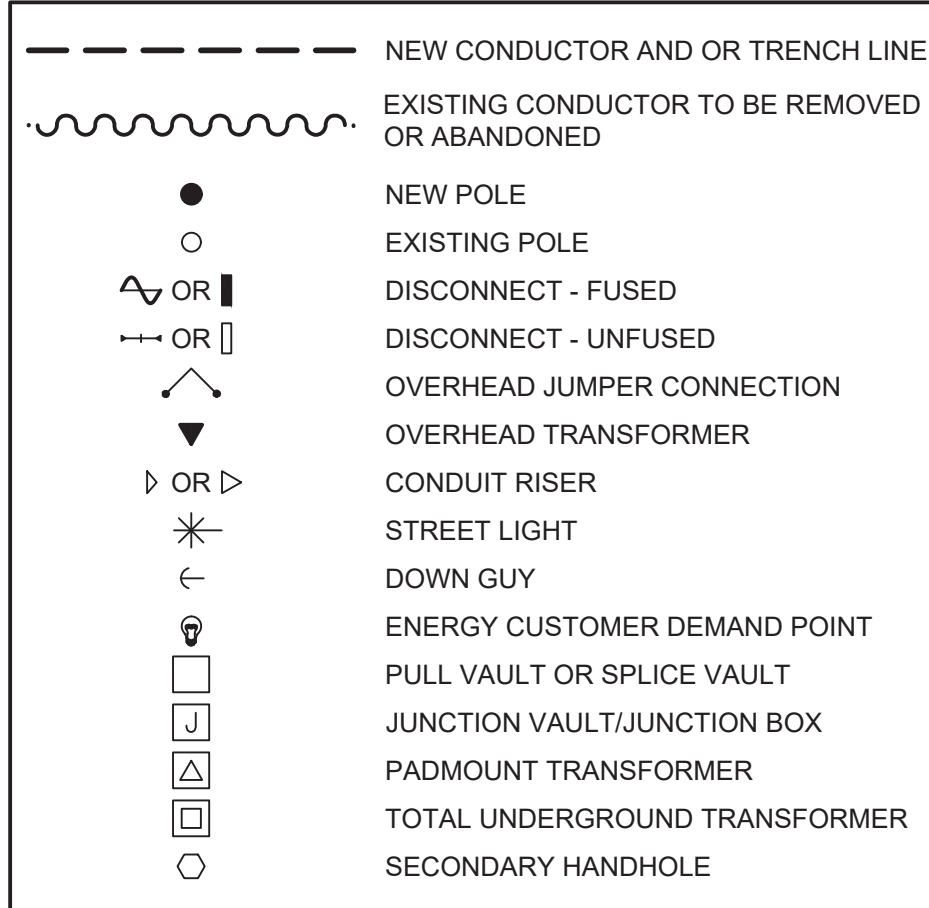

LEGEND

EROSION & SEDIMENT CONTROL REQUIREMENTS

EROSION & SEDIMENT CONTROL SHALL BE PER PSE STANDARD PRACTICE 0150.3200 TECHNIQUES FOR TEMPORARY EROSION & SEDIMENT CONTROL & ANY ADDITIONAL LOCAL JURISDICTION REQUIREMENTS. (LOCAL JURISDICTIONS MAY HAVE ADDITIONAL REQUIREMENTS INCLUDING NOTES DETAILING WHERE EROSION OR SEDIMENT CONTROL STRUCTURES ARE TO BE INSTALLED, CROSS SECTION DETAILS OF THE TYPICAL EROSION STRUCTURES, & SPECIAL REQUIREMENTS FOR WORK IN SENSITIVE AREAS.)

FOREMAN (CHECK BOX WHEN COMPLETED)

- ☐ PSE Equipment LOCKED/SECURED & Work Area left in CLEAN/SAFE Condition.
☐ Grid, Cable, and Switch numbers INSTALLED & VERIFIED.
☐ Field Changes RED-LINED on As-Built.
☐ Material VERIFIED and CHANGES noted on Paperwork.
☐ Total PRIMARY Cable noted on As-Built.
☐ Company IDF's RECORDED in correct location on As-built.
☐ Indicate correct FUSE SIZE on As-built & VERIFY proper PHASE.
☐ Deviations noted on the As-built and their reason.

☐ I certify that the work performed meets PSE's standards and procedures and that all quality requirements are met.

Foreman's Signature _____
Print Name _____ Date _____

PROJECT PHASE	NOTIF#	ORDER#
PWR	Superior	11752087
OH Misc Expense	N/A	593235623
UG Misc Expense	N/A	594156404
OH Xfmr Expense	N/A	583073948
UG Xfmr Expense	N/A	N/A
Removal	N/A	108129341
UG Svc Removal	N/A	108149065
CABLE TV		
PHONE		

Project Manager Contact Information:

Manager: KELLY ULICNY
Cell Phone: 425-429-0949
E-Mail: KELLY.ULICNY@PSE.COM


"Locates Required"	☒ Yes	No
"Outages Required"	☒ Yes	No
"Flagging Required"	☒ Yes	No

REV#	DATE	BY	DESCRIPTION
1			
2			
3			
100			

UTILITIES	COMCAST	LUMEN	GOOD SAMARITAN HOSP.
CONTACT	DARELL VACCA		
PHONE#	206-793-1244		

PSE	PUGET SOUND ENERGY	FRU-22 REPL 1 POLE DISTRIBUTION POLE REPLACEMENT 207 14TH AVE SE, PUYALLUP, WA 98372	INCIDENT N/A	MAOP N/A
DESIGNED BY ASPLUNDH CONSTRUCTION			Gas Order N/A	Elect Order 101139478
			SCALE AS NOTED	PAGE 1 OF 1

Vicinity Map N.T.S.

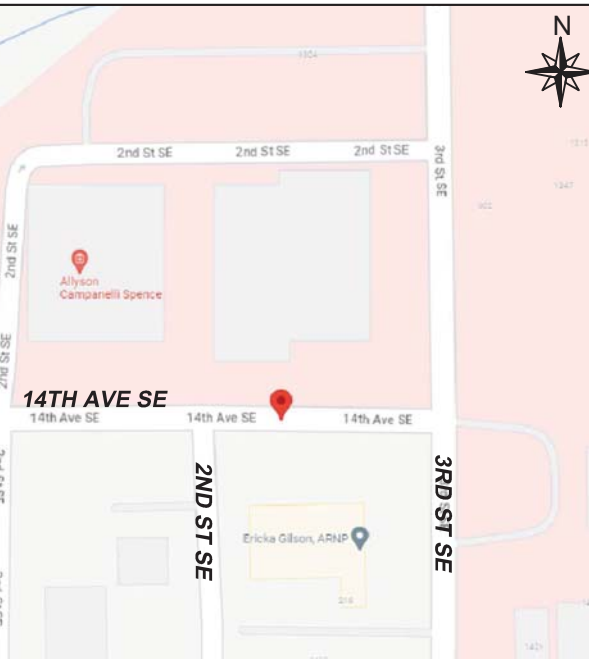

Owner / Developer Contact Info

PSE
ATTN: KELLY ULICNY
425-429-0949 office

For contacts below dial 1-888-CALL PSE (225-5773)

CALL (800) 424-5555

2 BUSINESS DAYS BEFORE YOU DIG

THIS SKETCH NOT TO BE RELIED UPON FOR EXACT LOCATION OF EXISTING FACILITIES

REAL ESTATE/EASEMENT	PERMIT
N/A	PUYALLUP
FUNCTION	CONTACT
PROJECT MGR	K. ULICNY
ENGR - POWER	A. VASQUEZ
ENGR - GAS	
DRAWN BY	A. VASQUEZ
CHECKED BY	T. Plesner
APPROVED BY	D. Wadsworth
FOREMAN #1	
FOREMAN #2	
MAPPING	

POLE TABLE (NEW)

Site #	Grid #	Height	Class	Year	Remarks / Location Ref.
P01	567800-155478	45	3		

POLE RETIREMENT TABLE

SITE #	GRID #	HEIGHT	CLASS	YEAR	TOPPED	RMVD	TEL	TV	FIBER	TRAN	RMVD	ID NUMBER
P01	567800-155478	40	3	1969	☐	☐	☐	☐	☐	☐	☐	