


MULTICARE CTU
402 15TH AVE SE
PUYALLUP, WA
PARCEL# 7790000566

ISSUE LOG:		DESCRIPTION	
DATE	INT	DESCRIPTION	


CONSTRUCTION SET	
DESIGNER:	SCOTT JERKE
ISSUE DATE:	11/18/24
PROJECT #:	FA24129
SYSTEM:	FIRE ALARM
SHEET:	DEVICE LOCATION VIEWS & RISER DIAGRAM
FA101	

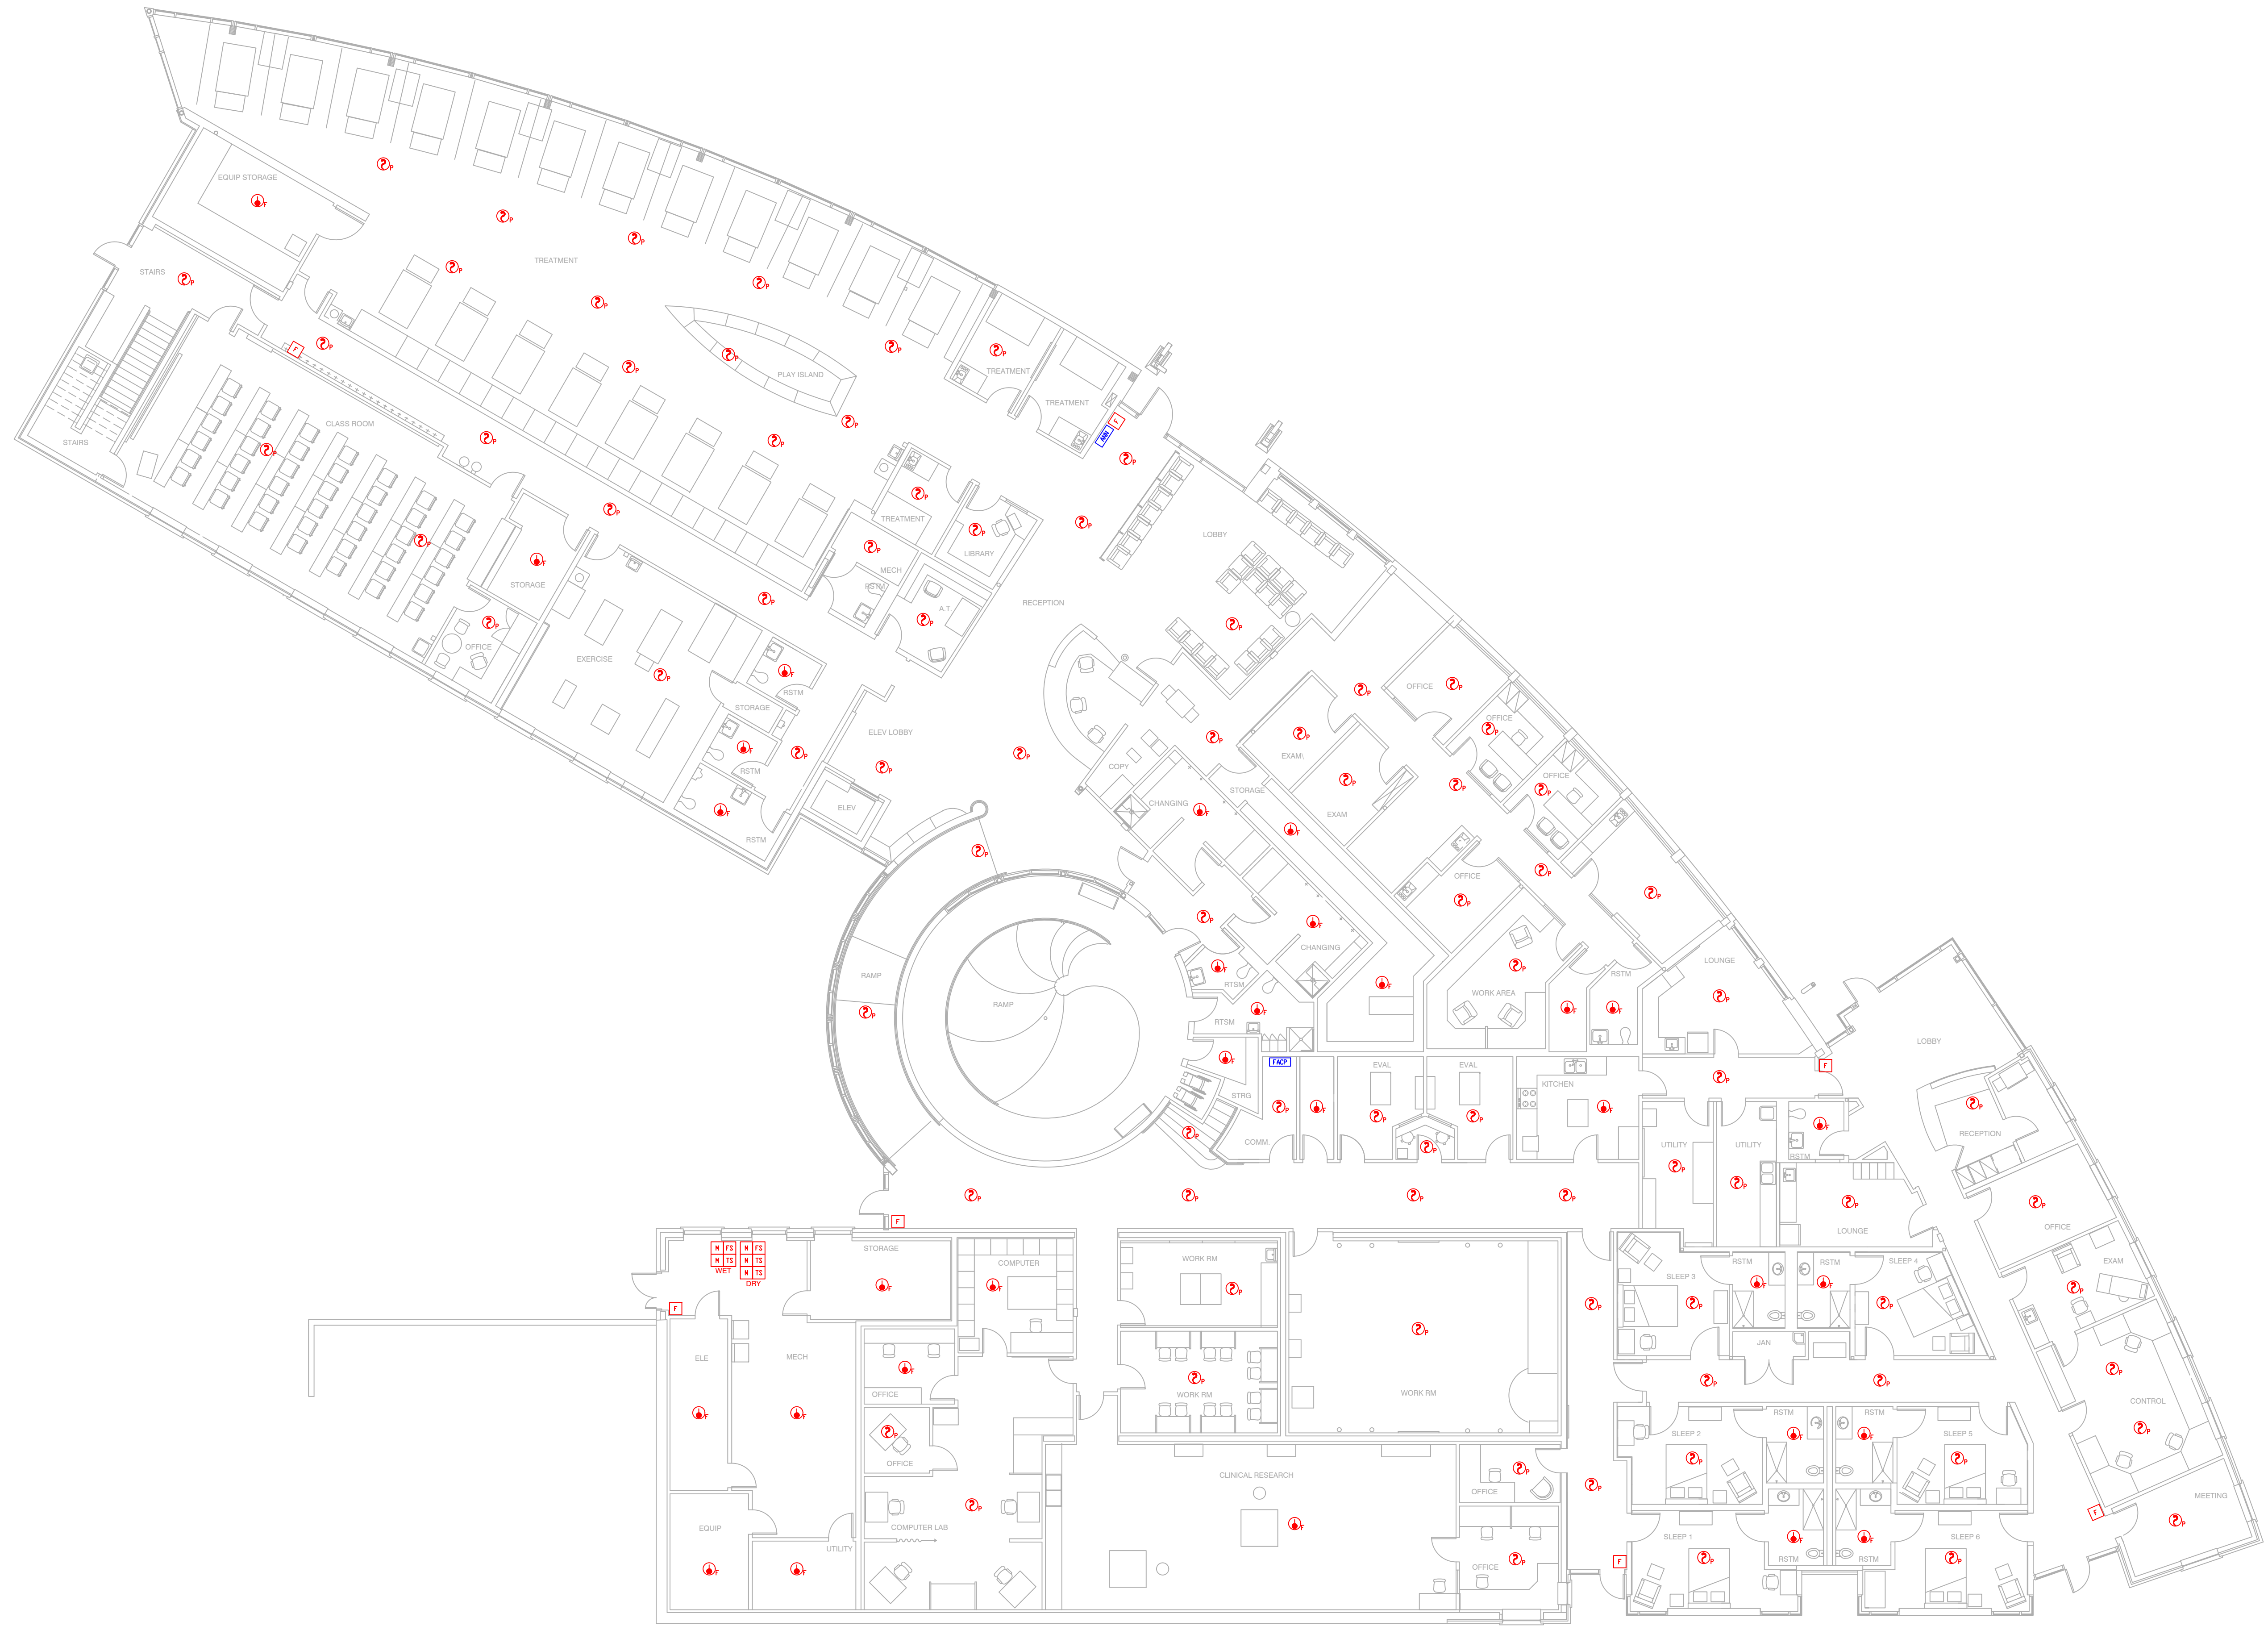

LOUIS LYNN
FIRE ALARM SYSTEMS III
SPECIAL HAZARDS III
WATER BASED SYSTEMS LAYOUT II
CERT #119584
EXP 6/1/25

[Signature]

KEY PLAN

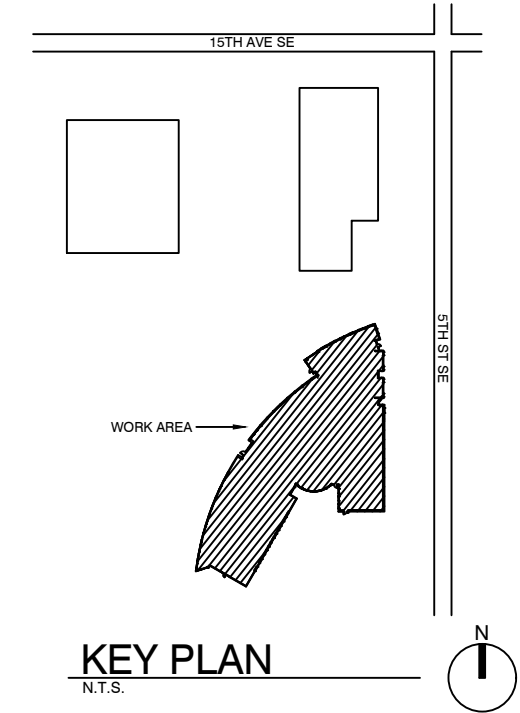

A DEVICE LOCATIONS - FIRST FLOOR PLAN
SCALE: 3/32" = 1'-0"



A



DEVICE LOCATIONS - SECOND FLOOR PLAN

SCALE: 3/32" = 1'-0"

LOUIS LYNN
FIRE ALARM SYSTEMS III
SPECIAL HAZARDS III
WATER BASED SYSTEMS LAYOUT II
CERT #119584
EXP 6/1/25

[Signature]

KEY PLAN

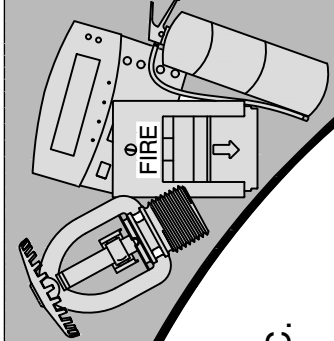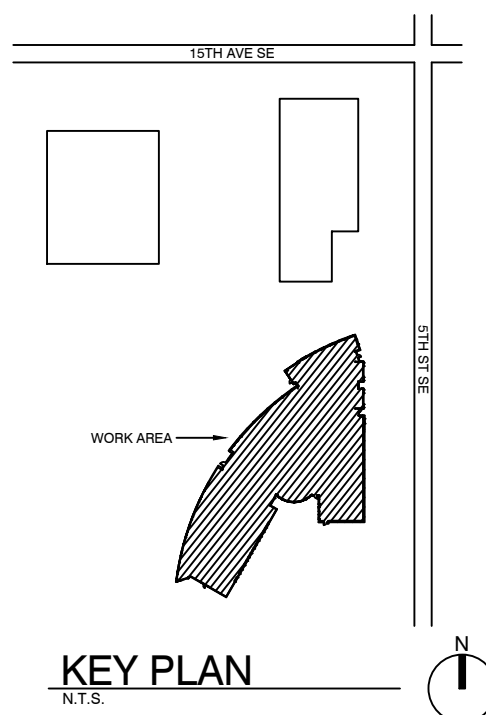

SFS FIRE SYSTEMS INC.
1108 54TH AVE E
TACOMA, WA 98424
(253) 928-1880
SMTHFS981RS

MULTICARE CTU

402 15TH AVE SE
PUYALLUP, WA
PARCEL# 7790000566

ISSUE LOG:		DESCRIPTION	
DATE	INT	DESCRIPTION	

CONSTRUCTION SET

DESIGNER:	SCOTT JERKE
ISSUE DATE:	11/18/24
PROJECT #:	FA24129
SYSTEM:	FIRE ALARM

SHEET:
DEVICE LOCATION
VIEWS & RISER
DIAGRAM

FA102