


CITY OF PUYALLUP
STANDARD NOTES FOR DRAINAGE PLANS

1. All work in City right-of-way requires a permit from the City of Puyallup. Prior to any work commencing, the general contractor shall arrange for a preconstruction meeting at the Development Services Center to be attended by all contractors that will perform work shown on the engineering plans, representatives from all applicable Utility Companies, the project owner and appropriate City staff. Contact Engineering Services to schedule the meeting (253) 841-5568. The contractor is responsible to have their own approved set of plans at the meeting.
2. After completion of all items shown on these plans and before acceptance of the project, the contractor shall obtain a "punch list" prepared by the City's inspector detailing remaining items of work to be completed. All items of work shown on these plans shall be completed to the satisfaction of the City prior to acceptance of the water system and provision of sanitary sewer service.
3. All materials and workmanship shall conform to the Standard Specifications for Road, Bridge, and Municipal Construction (hereinafter referred to as the "Standard Specifications"), Washington State Department of Transportation and American Public Works Association, Washington State Chapter, latest edition, unless superseded or amended by the City of Puyallup City Standards for Public Works Engineering and Construction (hereinafter referred to as the "City Standards").
4. A copy of these approved plans and applicable city developer specifications and details shall be on site during construction.
5. Any revisions made to these plans must be reviewed and approved by the developer's engineer and the Engineering Services Staff prior to any implementation in the field. The City shall not be responsible for any errors and/or omissions on these plans.
6. The contractor shall have all utilities verified on the ground prior to any construction. Call 811 at least two working days in advance. The owner and his/her engineer shall be contacted immediately if a conflict exists.
7. Any structure and/or obstruction which require removal or relocation relating to this project, shall be done so at the developer's expense.
8. During construction, all existing and newly installed drainage structures shall be protected from sediments.
9. All storm manholes shall conform to City Standard Detail No. 02.01.01. Flow control manhole/oil water separator shall conform to City Standard Detail No. 02.01.06 and 02.01.07.
10. Manhole ring and cover shall conform to City Standard Detail 06.01.02.
11. Catch basins Type I shall conform to City Standard Detail No.02.01.02 and 02.01.03 and shall be used only for depths less than 5 feet from top of the grate to the invert of the storm pipe.
12. Catch basins Type II shall conform to City Standard Detail No.02.01.04 and shall be used for depths greater than 5 feet from top of the grate to the invert of the storm pipe.
13. Cast iron or ductile iron frame and grate shall conform to City Standard Detail No.02.01.05. Grate shall be marked with "drains to stream". Solid catch basin lids (square unless noted as shall conform to WSDOT Standard Plan B-30.20-04 (Olympic Foundry No. SM60 or equal). Vaned grates shall conform to WSDOT Standard Plan B-30.30-03 (Olympic Foundry No. SM60V or equal).
14. Stormwater pipe shall be only PVC, concrete, ductile iron, or dual walled Polypropylene pipe.
 - a. The use of any other type shall be reviewed and approved by the Engineering Services Staff prior to installation.
 - b. PVC pipe shall be per ASTM D3034, SDR 35 for pipe size 15-inch and smaller and F679 for pipe sizes 18 to 27 inch. Minimum cover on PVC pipe shall be 3.0 feet.
 - c. Concrete pipe shall conform to the WSDOT Standard Specifications for concrete underdrain pipe. Minimum cover on concrete pipe shall not less than 3.0 feet.
 - d. Ductile iron pipe shall be Class 50, conforming to AWWA C151. Minimum cover on ductile iron pipe shall be 1.0 foot.
 - e. Polypropylene Pipe (PP) shall be dual walled, have a smooth interior and exterior corrugations and meet WSDOT 9-05.24(1). 12-inch through 30-inch pipe shall meet or exceed ASTM F2736 and AASHTO M330, Type S, or Type D. 36-inch through 60-inch pipe shall meet or exceed ASTM F2881 and AASHTO M330, Type S, or Type D. Testing shall be per ASTM F1417. Minimum cover over Polypropylene pipe shall be 3-feet.
15. Trenching, bedding, and backfill for pipe shall conform to City Standard Detail No. 06.01.01.
16. Storm pipe shall be a minimum of 10 feet away from building foundations and/or roof lines.
17. All storm drain mains shall be tested and inspected for acceptance as outlined in Section 406 of the City of Puyallup Sanitary Sewer System Standards.
18. All temporary sedimentation and erosion control measures, and protective measures for critical areas and significant trees shall be installed prior to initiating any construction activities.

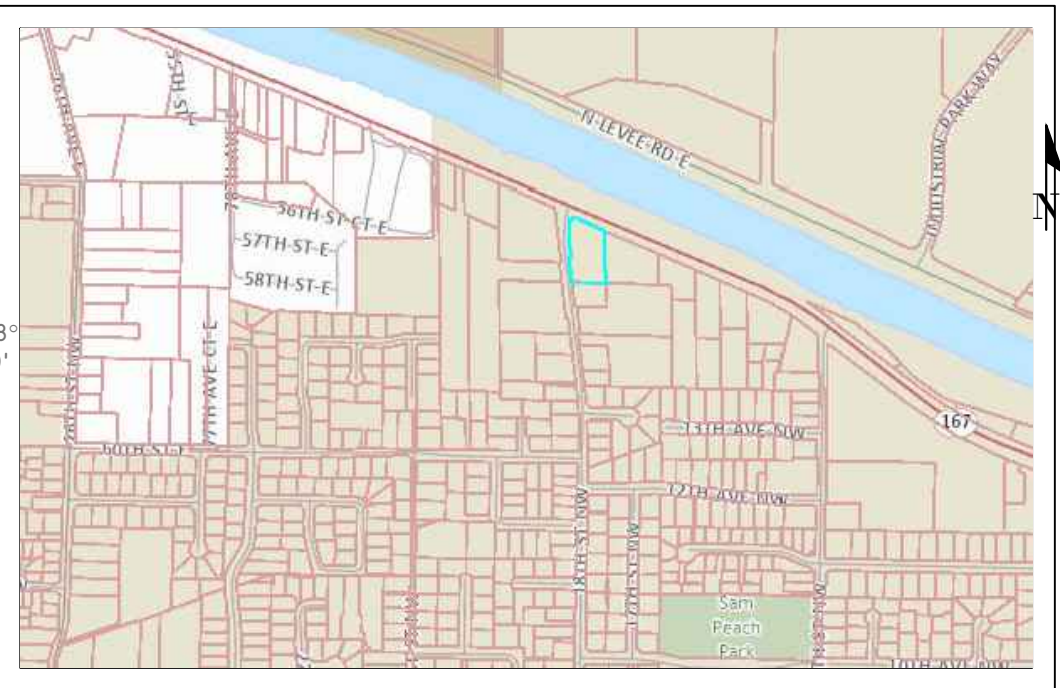

SEE C2 FOR DRAINAGE SITE PLAN
SEE C3 FOR NOTES AND DETAILS

Revisions:


C1
COVER/TESC

2024-11-13: Updated for City of Puyallup comments

Scale: 1" = 20'

Legend Auto Parking


Site Address: 1720 River Road
Jurisdiction: Puyallup
Parcel No.: 042020-8065
Applicant: Legend Auto
Permit No.: PRCCP20231662
Interlaken Project No.: SEA-23-100

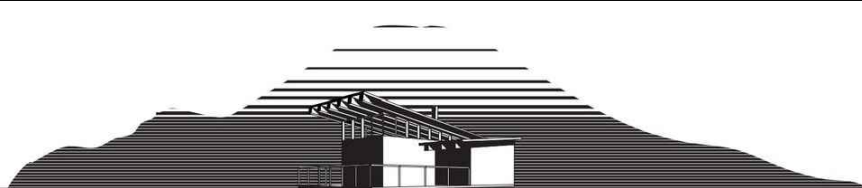


Interlaken Engineering and Design, PLLC
Seattle, WA | (206) 470-9572

www.interlakenengineering.com



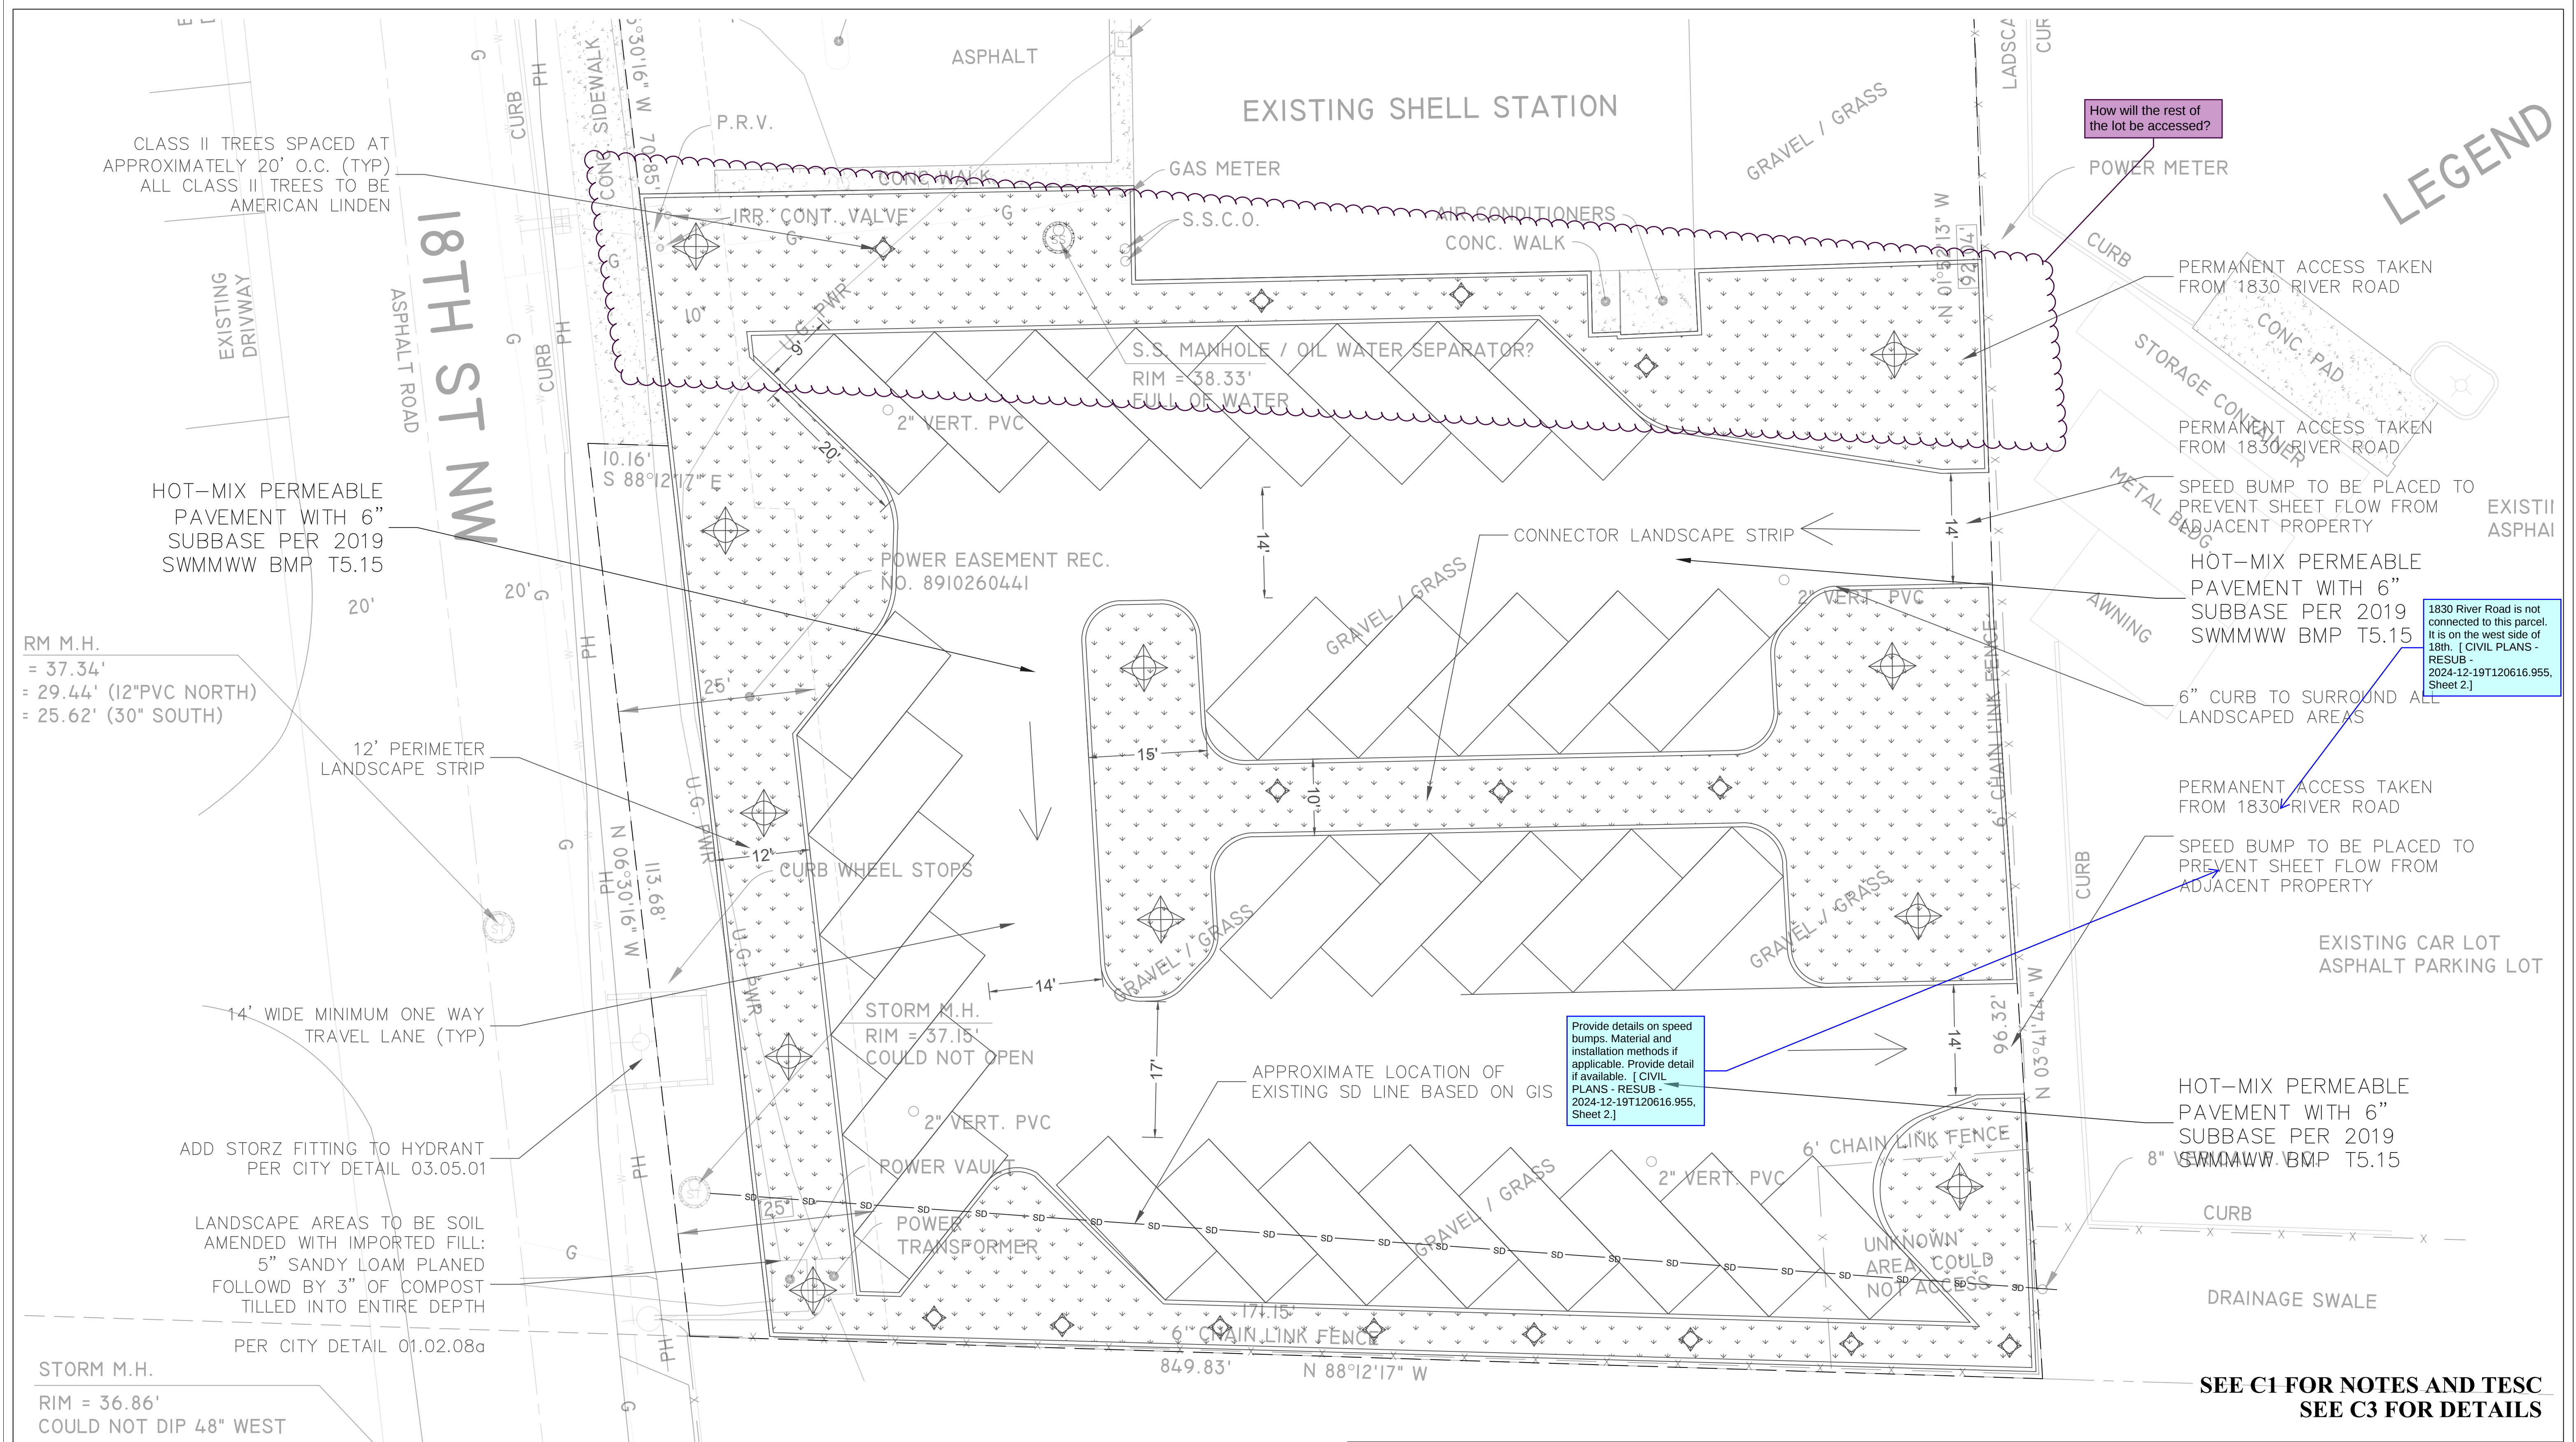

PLANTING SCHEDULE					
CLASS	COMMON NAME	BOTANICAL NAME	QUANTITY	INSTALLATION SIZE	PLANTING METHOD
II	AMERICAN LINDEN	TILIA AMERICANA 'BOULEVARD'	15	1.5" CALIPER OR GREATER	STANDARD DETAIL 01.02.07
III/IV	RIVER BIRCH	BETULA NIGRA	11	1.5" CALIPER OR GREATER	STANDARD DETAIL 01.02.07

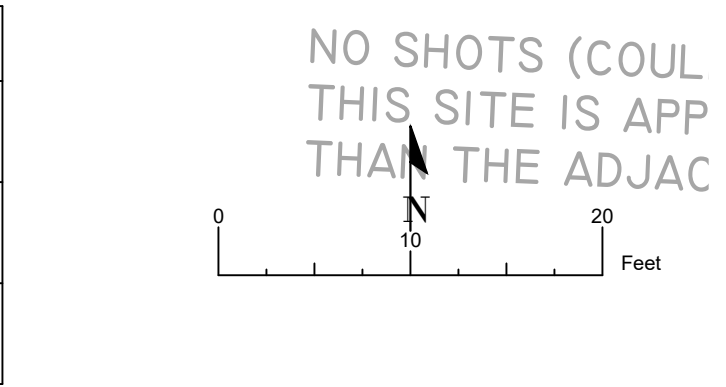









Legend Auto Parking
Site Address: 1720 River Road
Jurisdiction: Puyallup
Parcel No.: 042020-8065
Applicant: Legend Auto
Permit No.: PRCCP20231662
Interlaken Project No.: SEA-23-100

Interlaken Engineering and Design, PLLC
Seattle, WA | (206) 470-9572
www.interlakenengineering.com

Revisions:

2024-11-13: Updated for City of Puyallup comments

C2
Drainage Site Plan
Scale: 1" = 10'

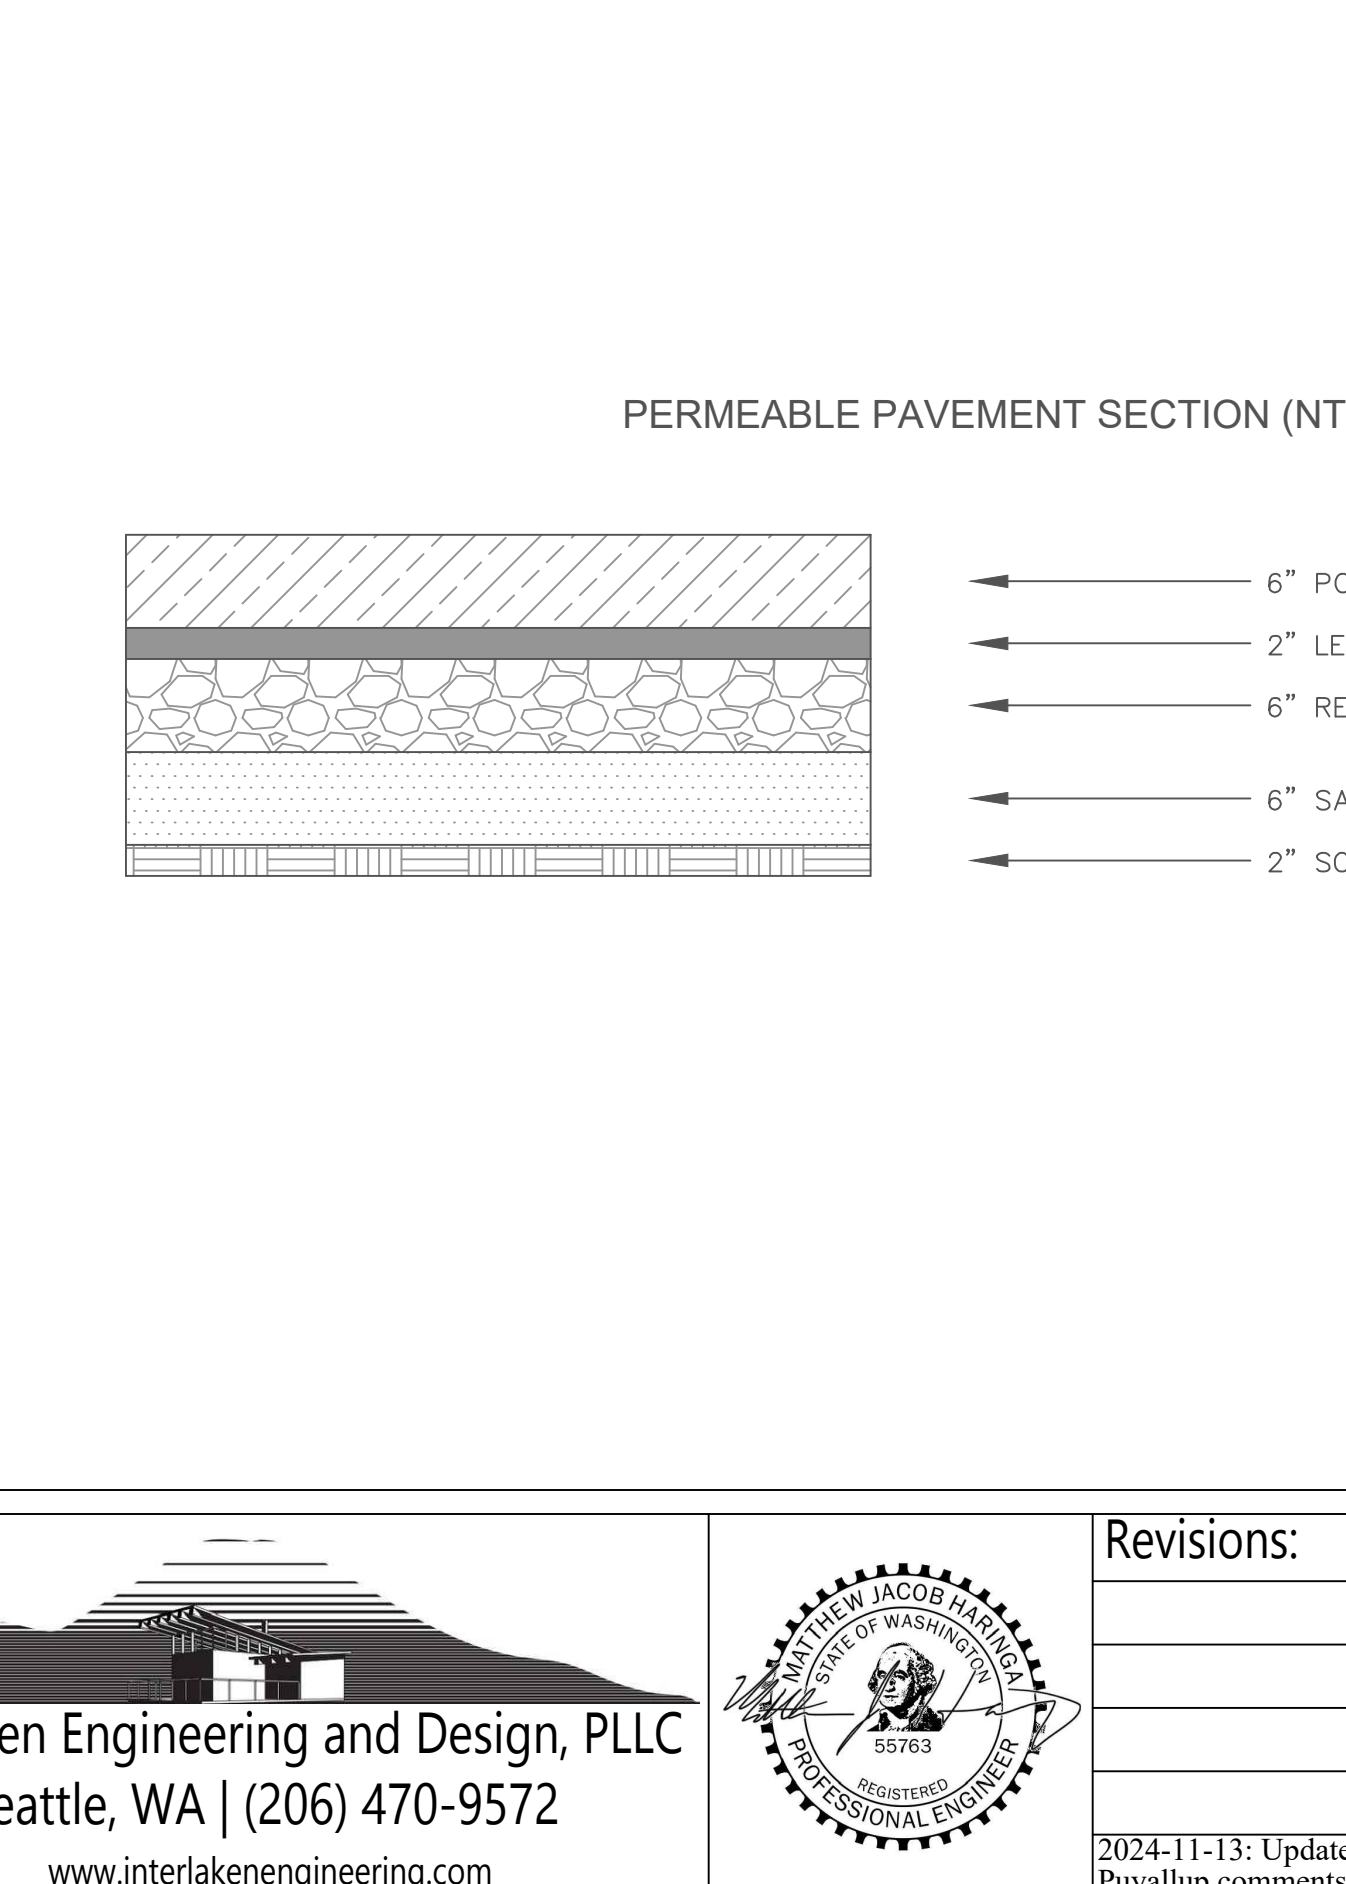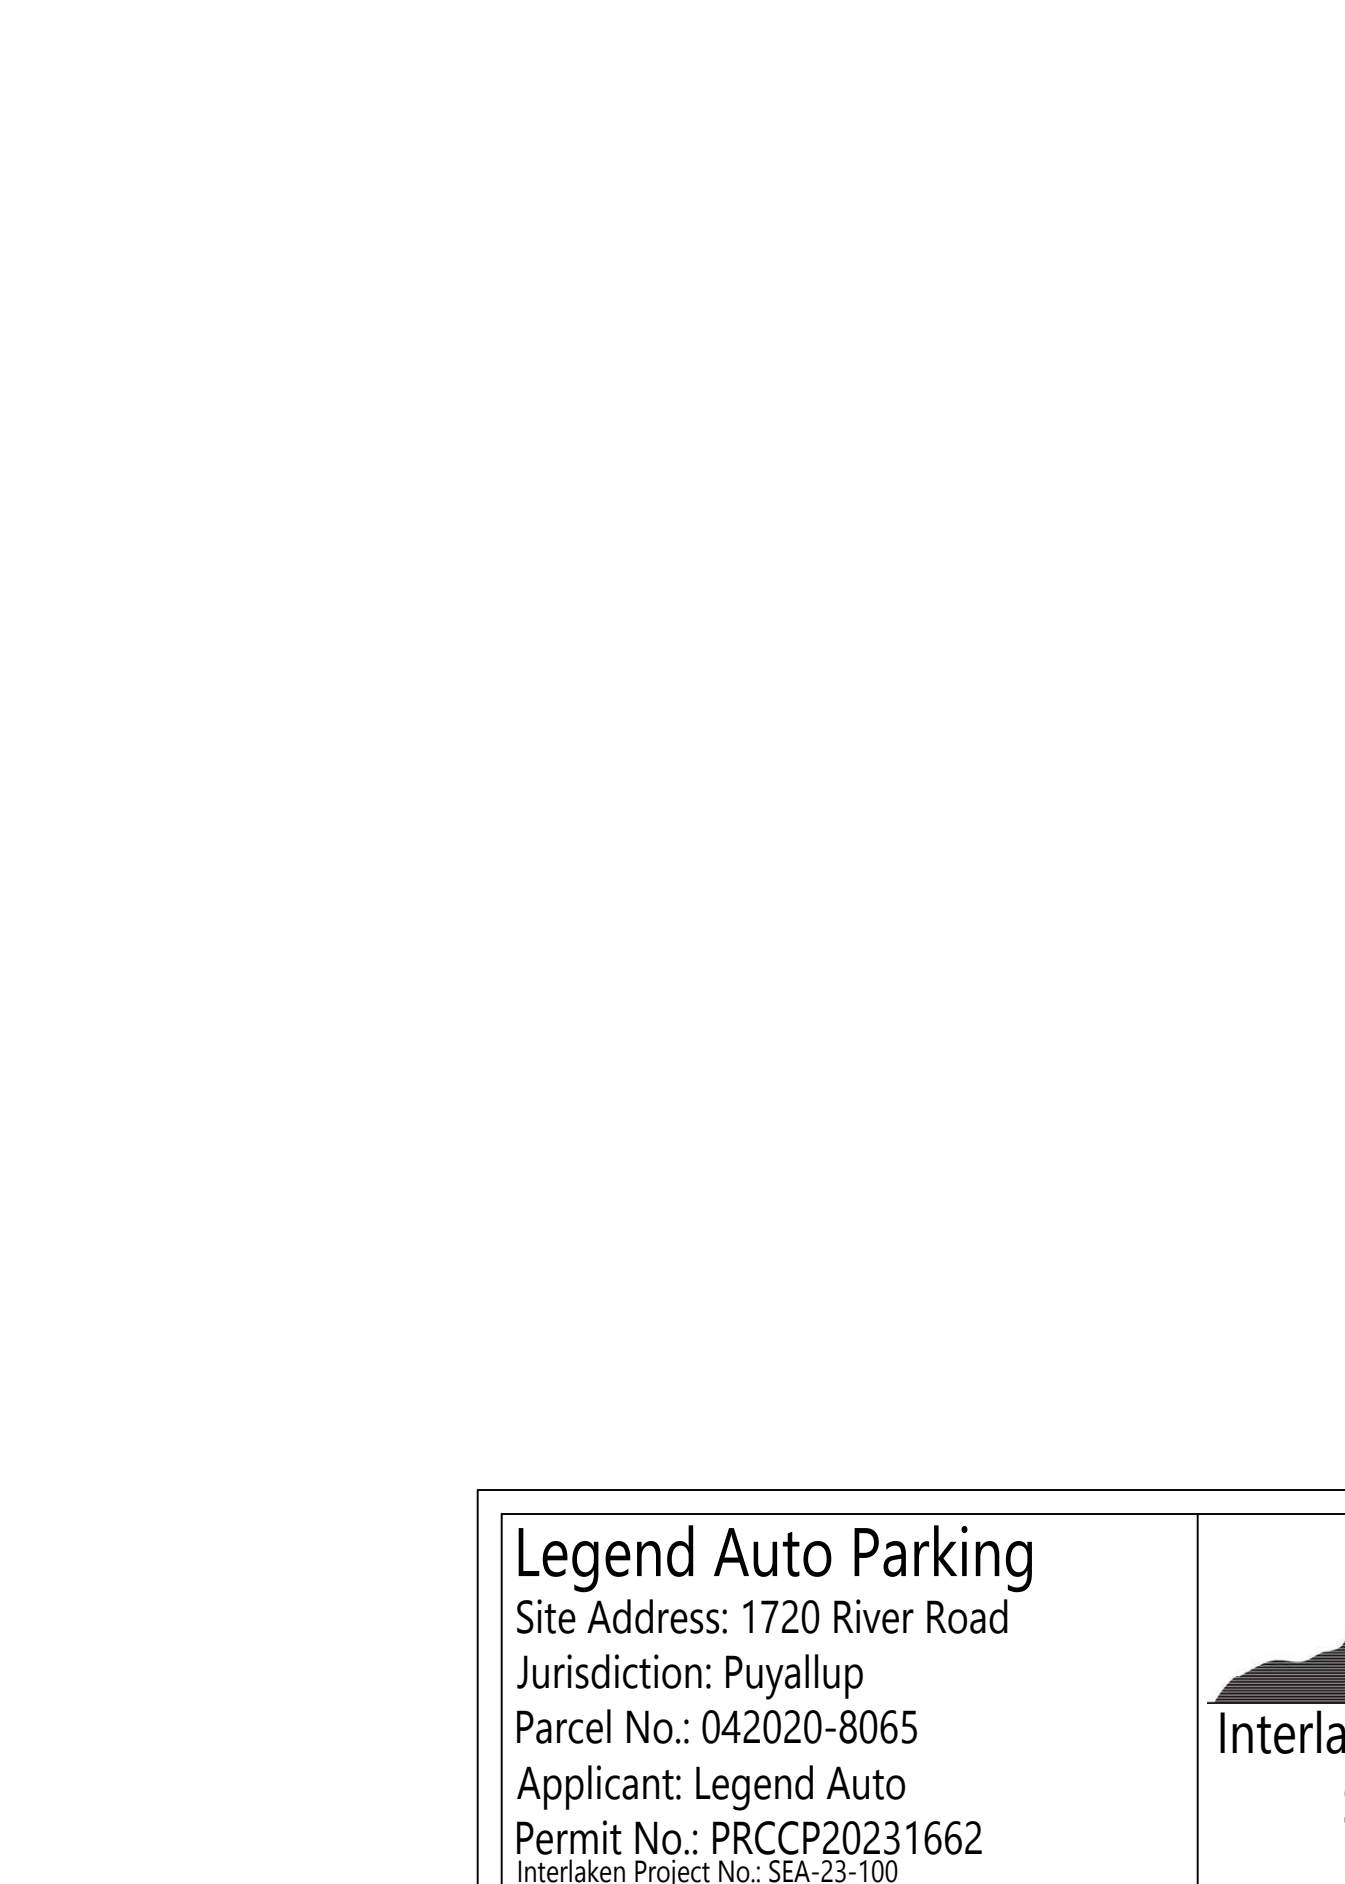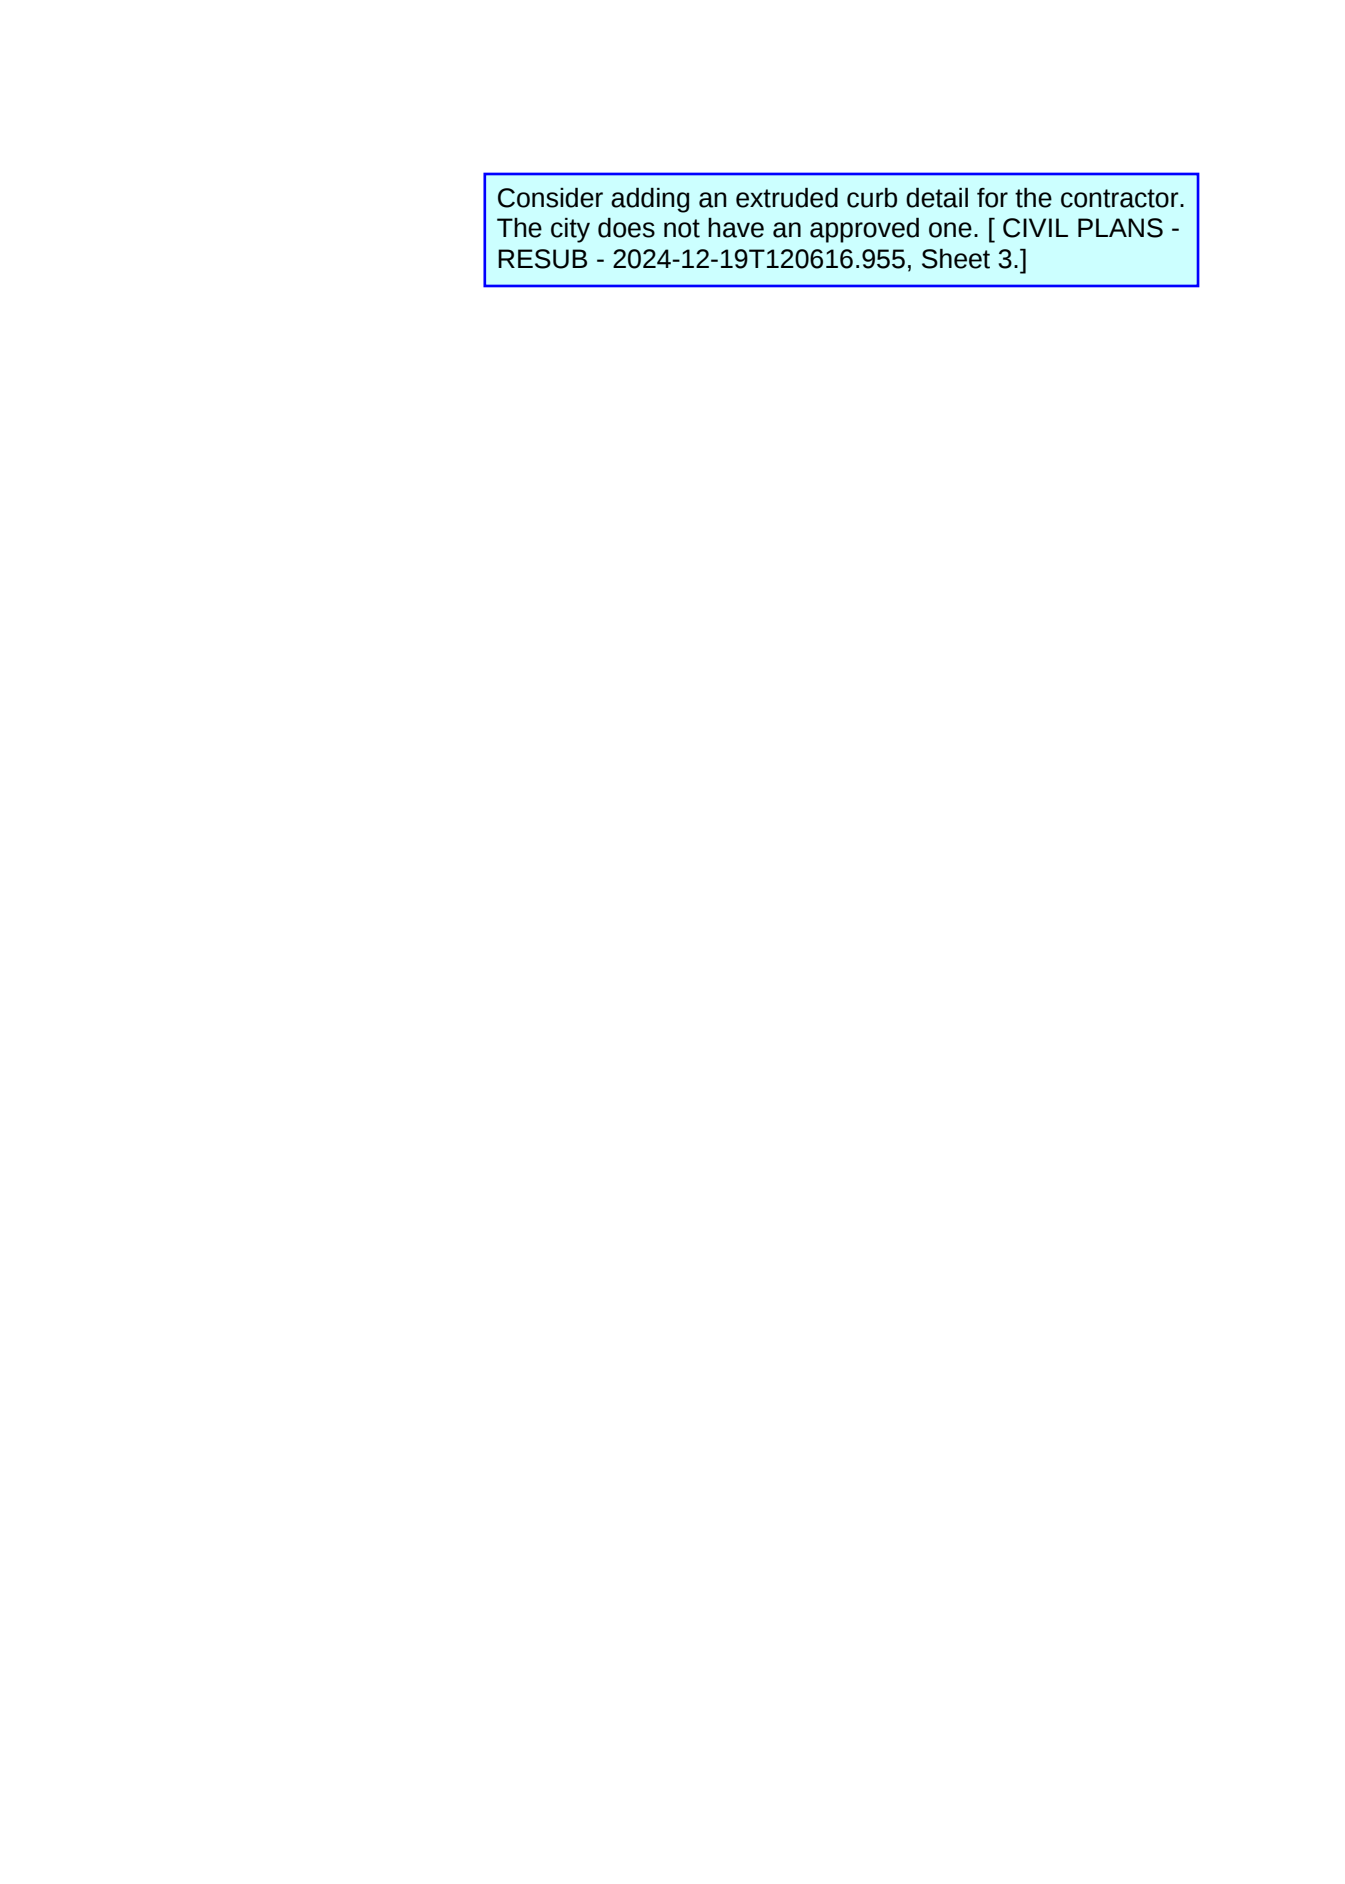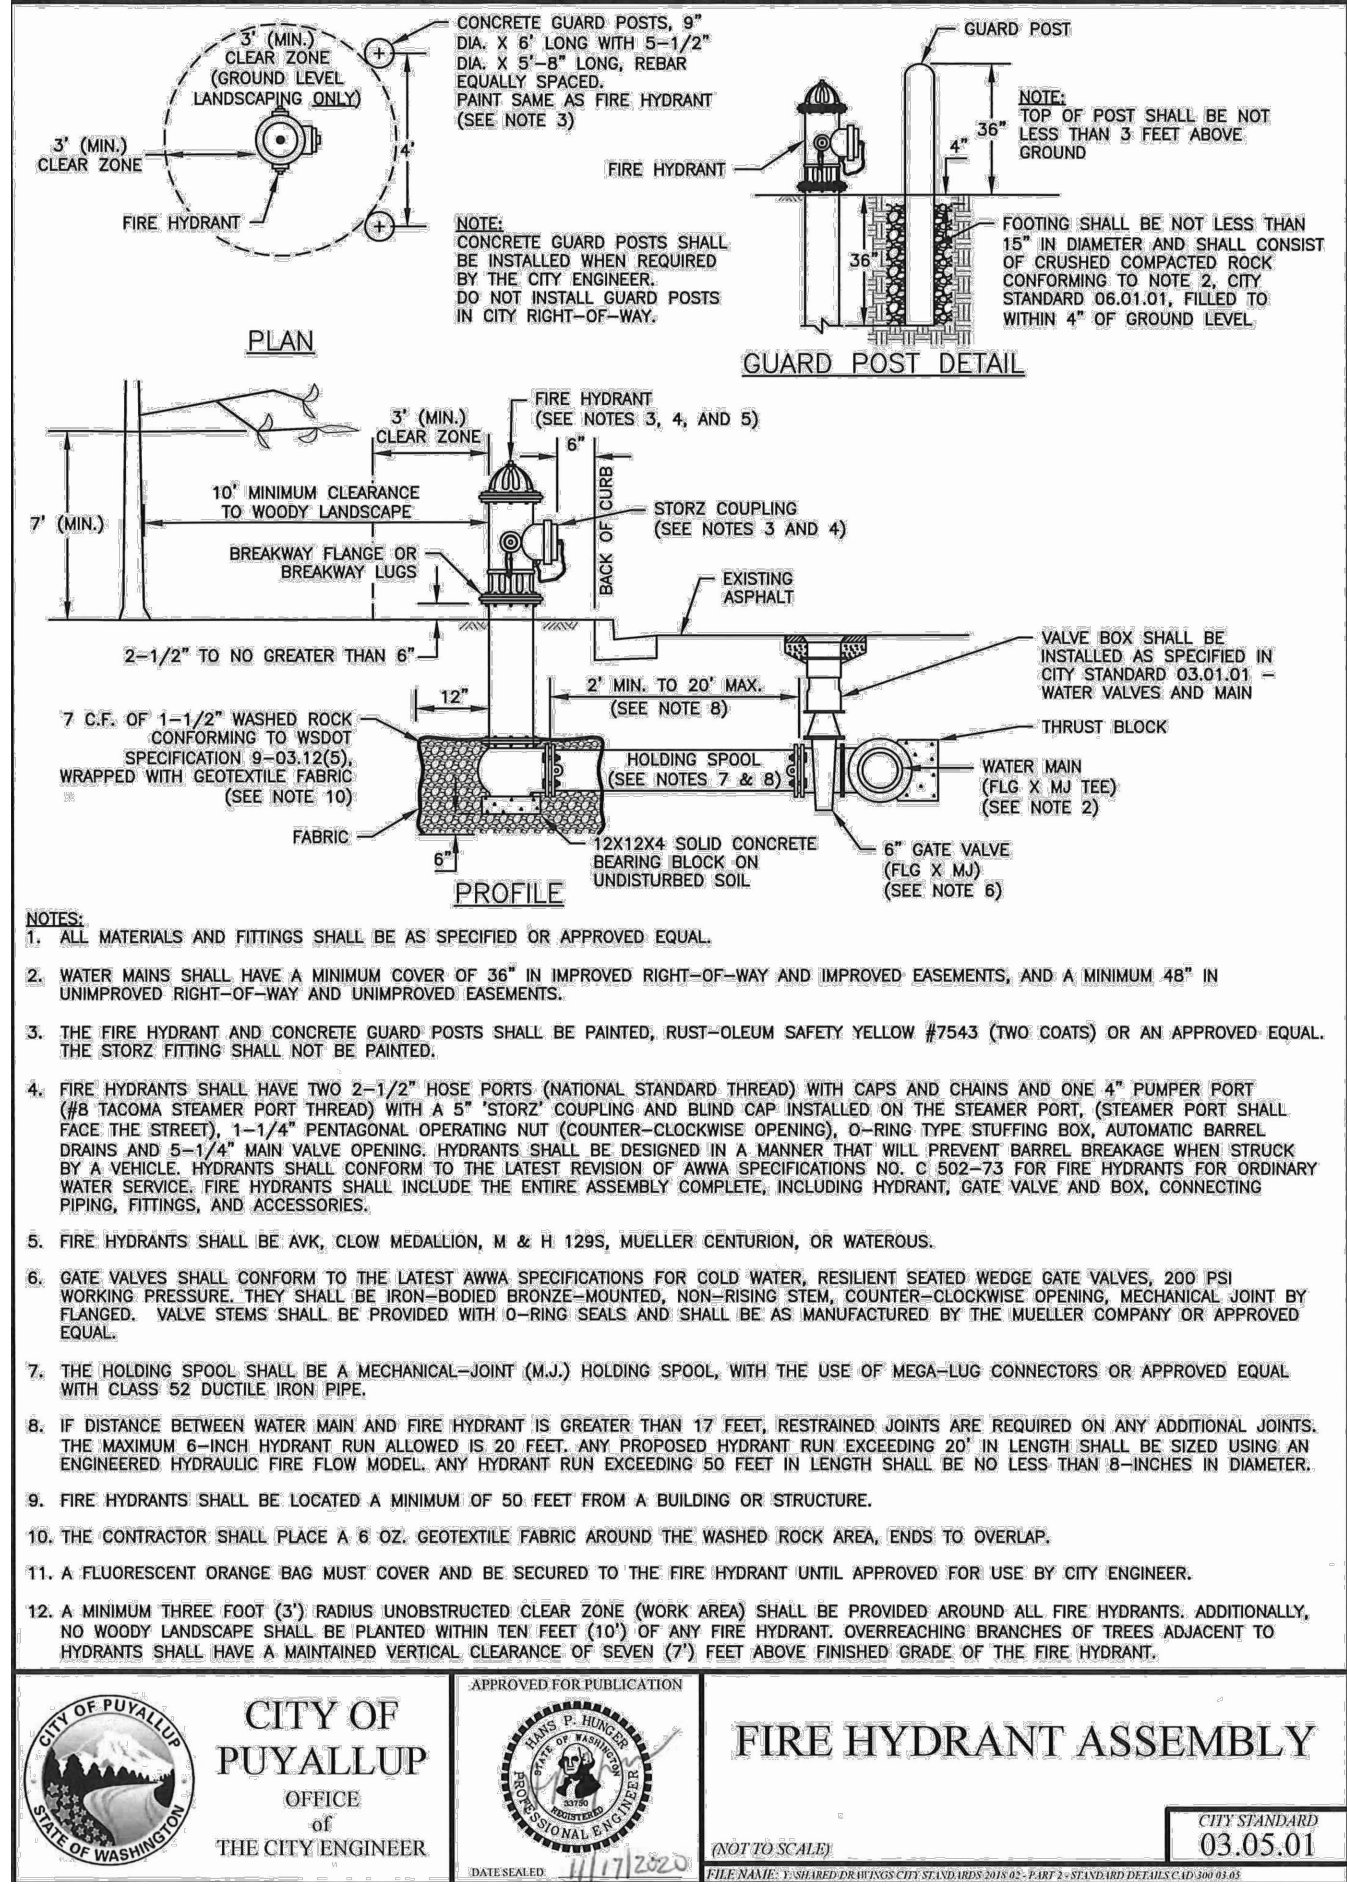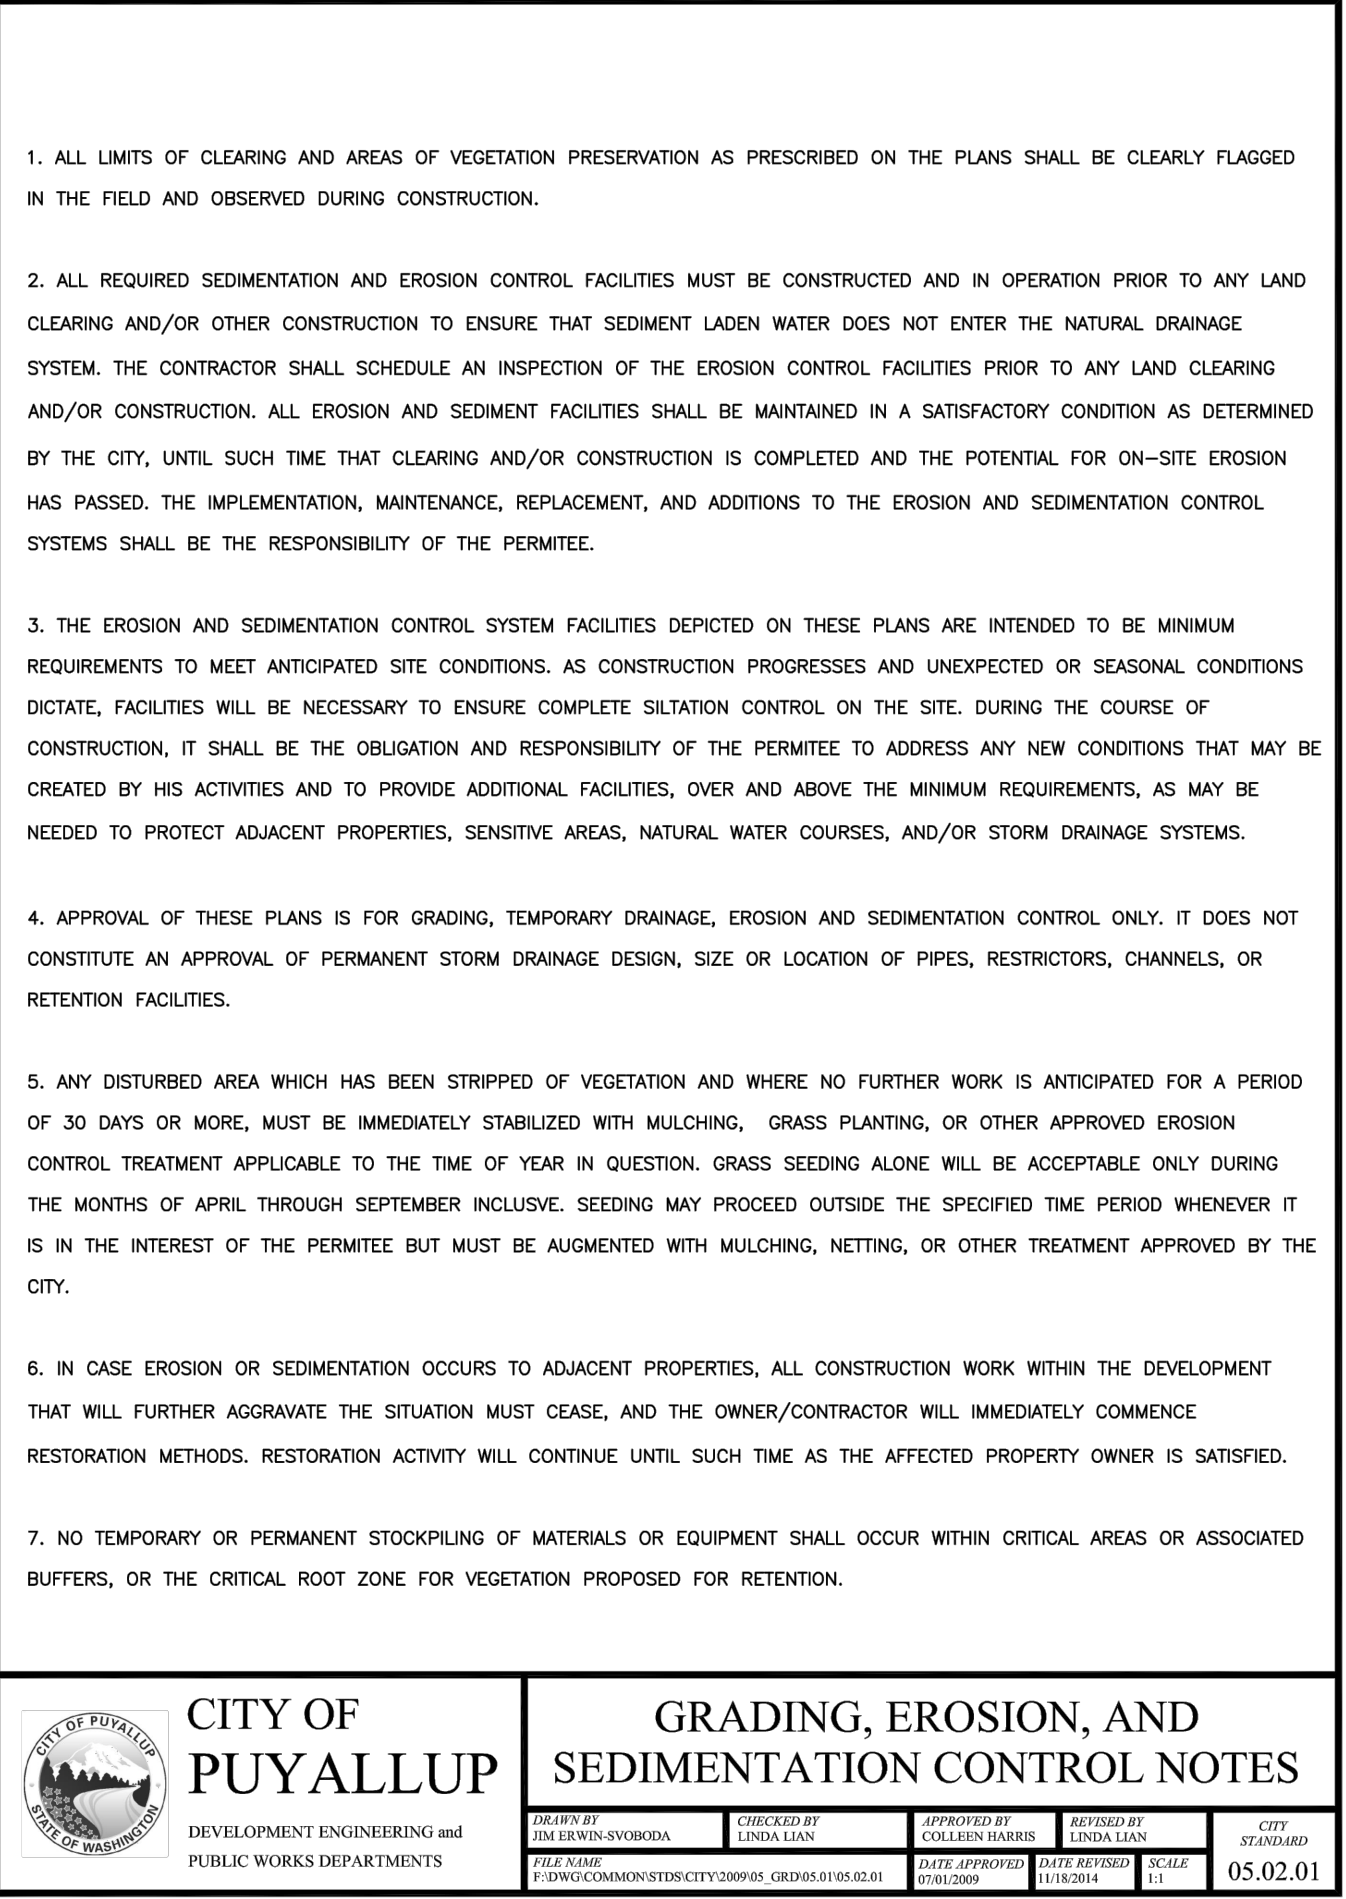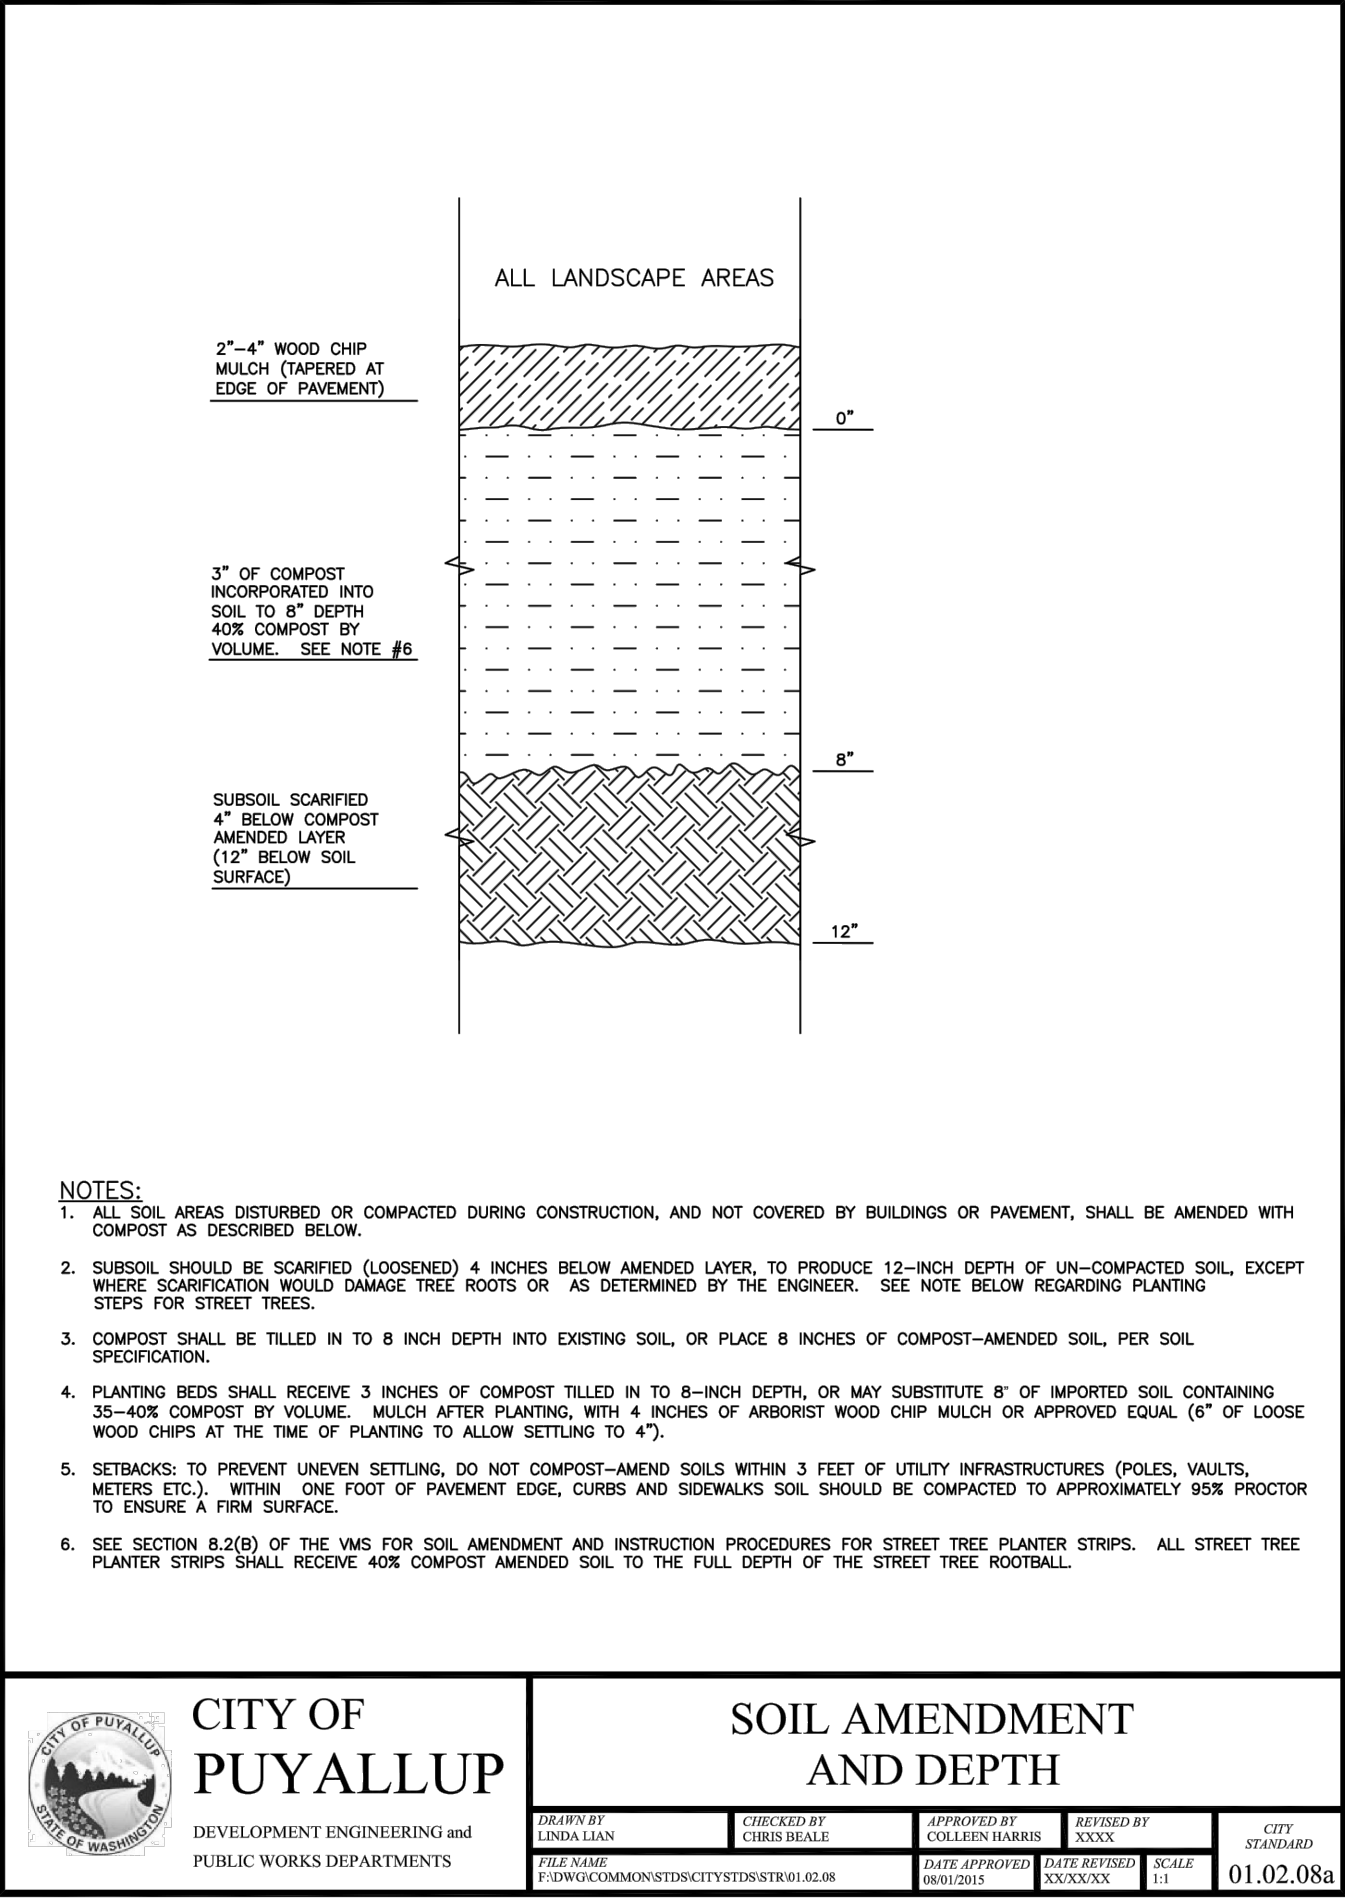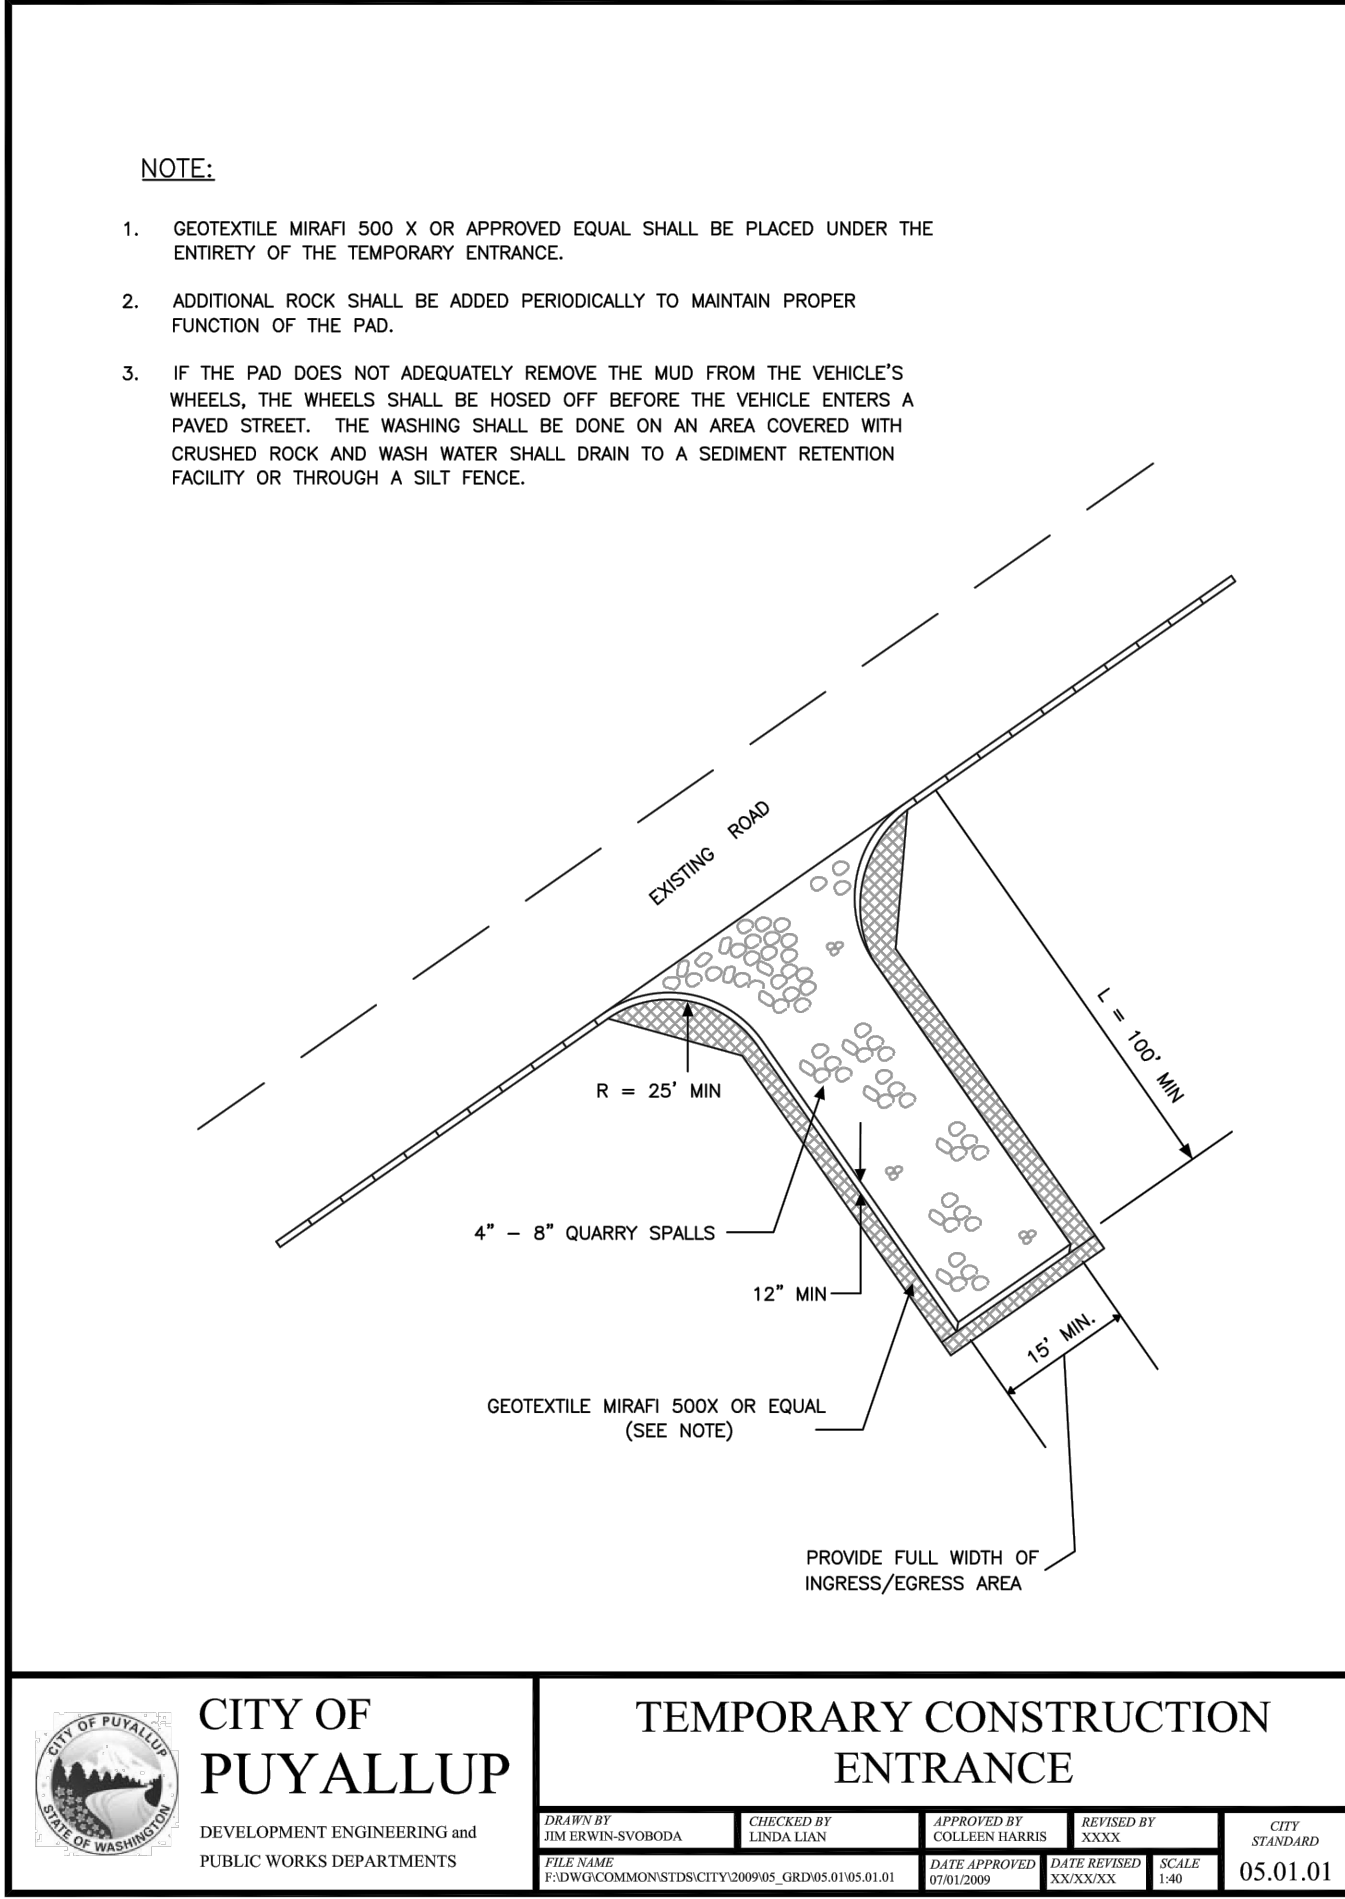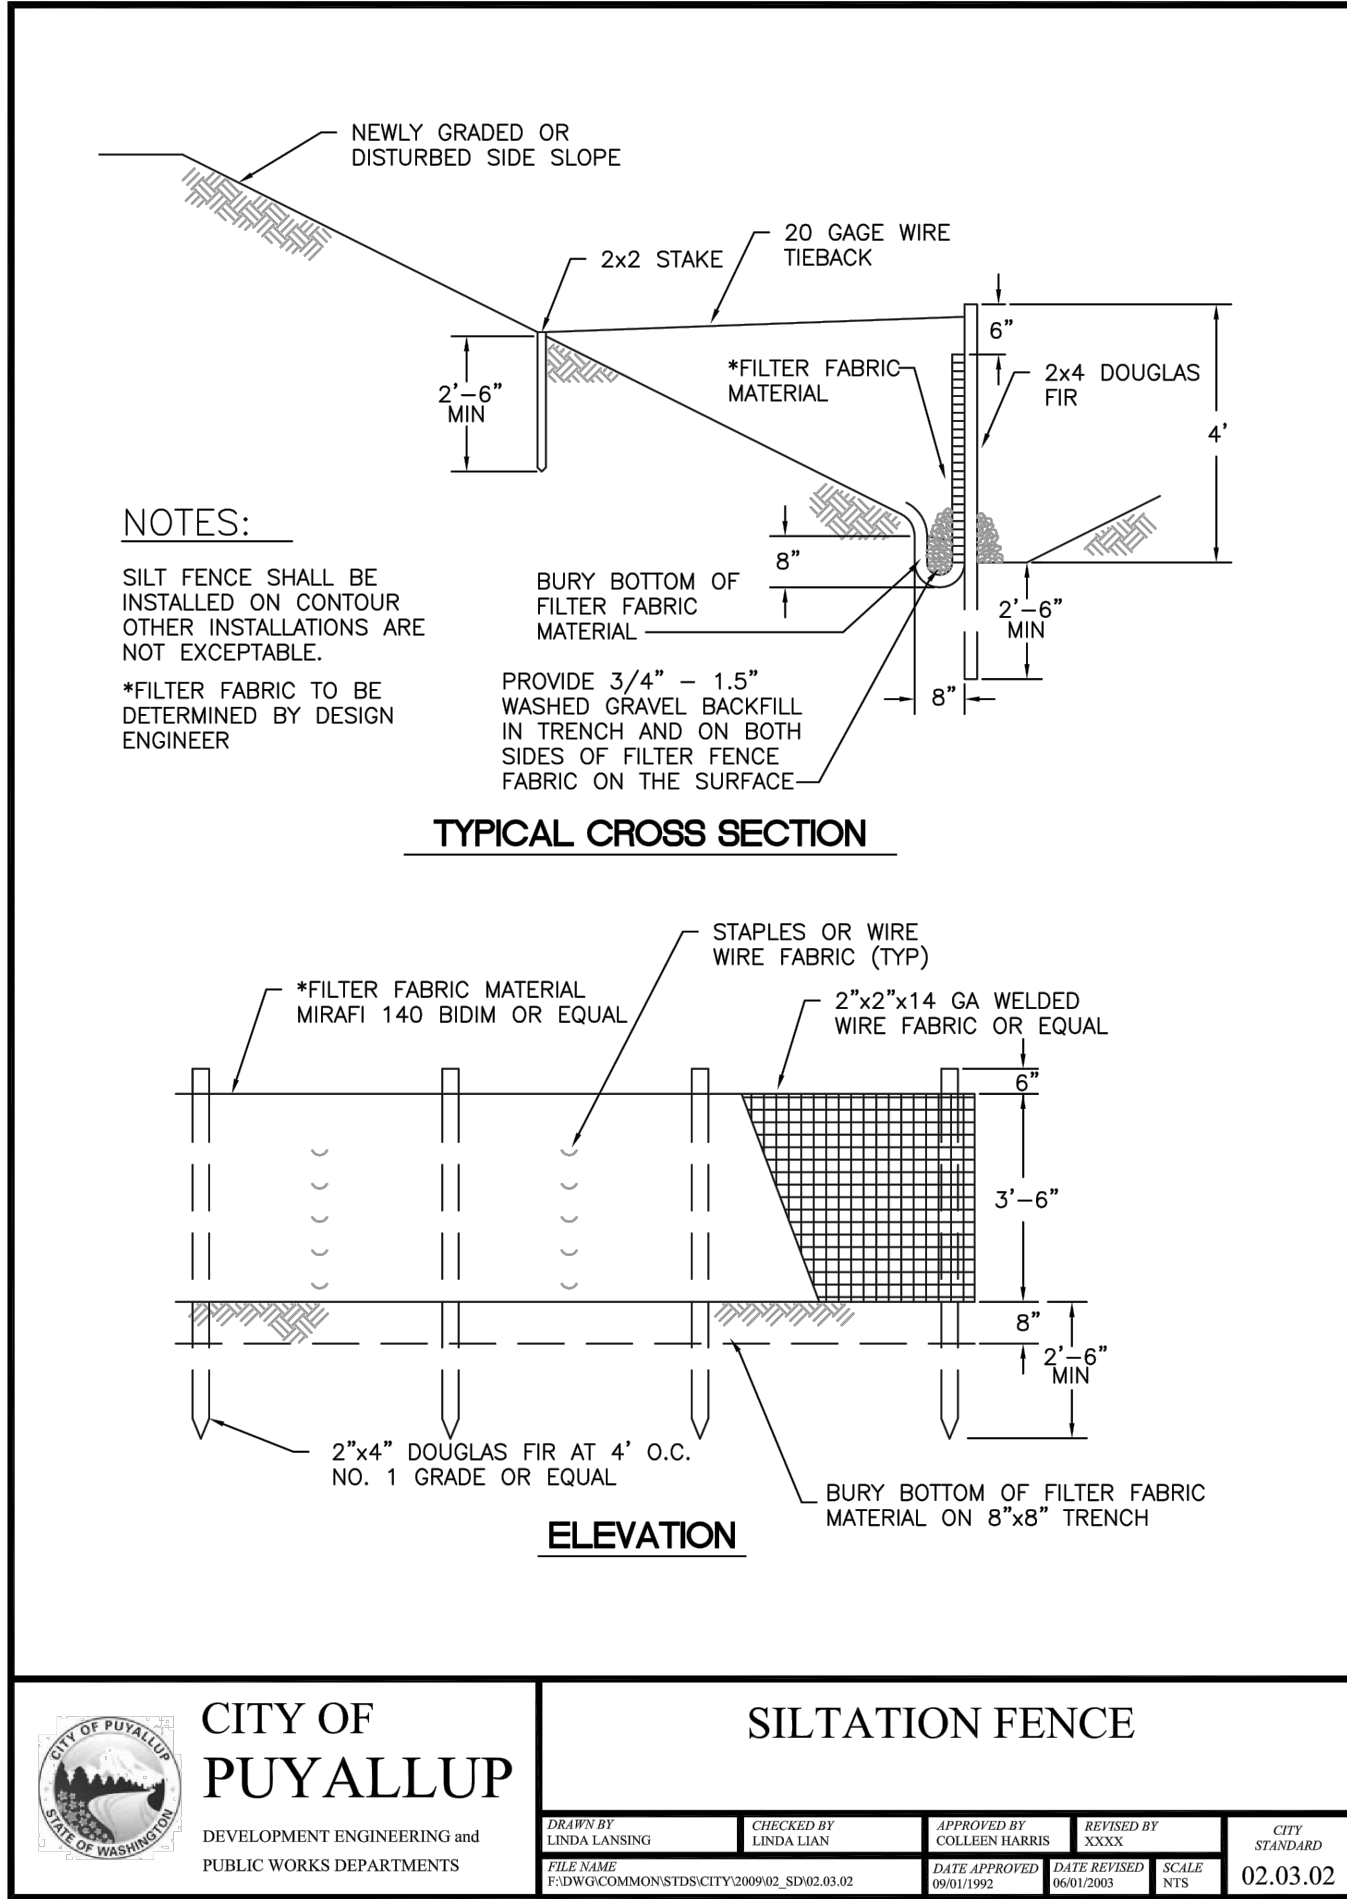

Legend Auto Parking

Site Address: 1720 River Road

Jurisdiction: Puyallup

Parcel No.: 042020-8065

Applicant: Legend Auto


Permit No.: PRCCP20231662

Interlaken Project No.: SEA-23-100

Interlaken Engineering and Design, PLLC

Seattle, WA | (206) 470-9572

www.interlakenengineering.com

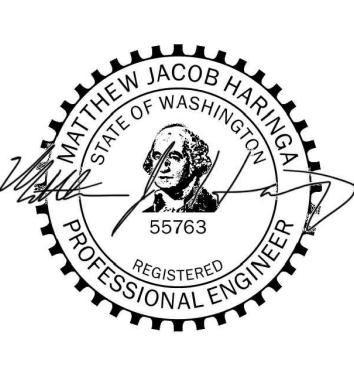

Revisions:	
2024-11-13: Updated for City of Puyallup comments	

C3

Details

Scale: As Noted