


\\corporate.gannettfleming.com\BCE\Drawings\2024\2419240263A_Drawing\Electrical\ELECTRICAL SHEETS\241924-263_E-101a.dwg last edited: 12/22/23 12:05pm by jmh49g

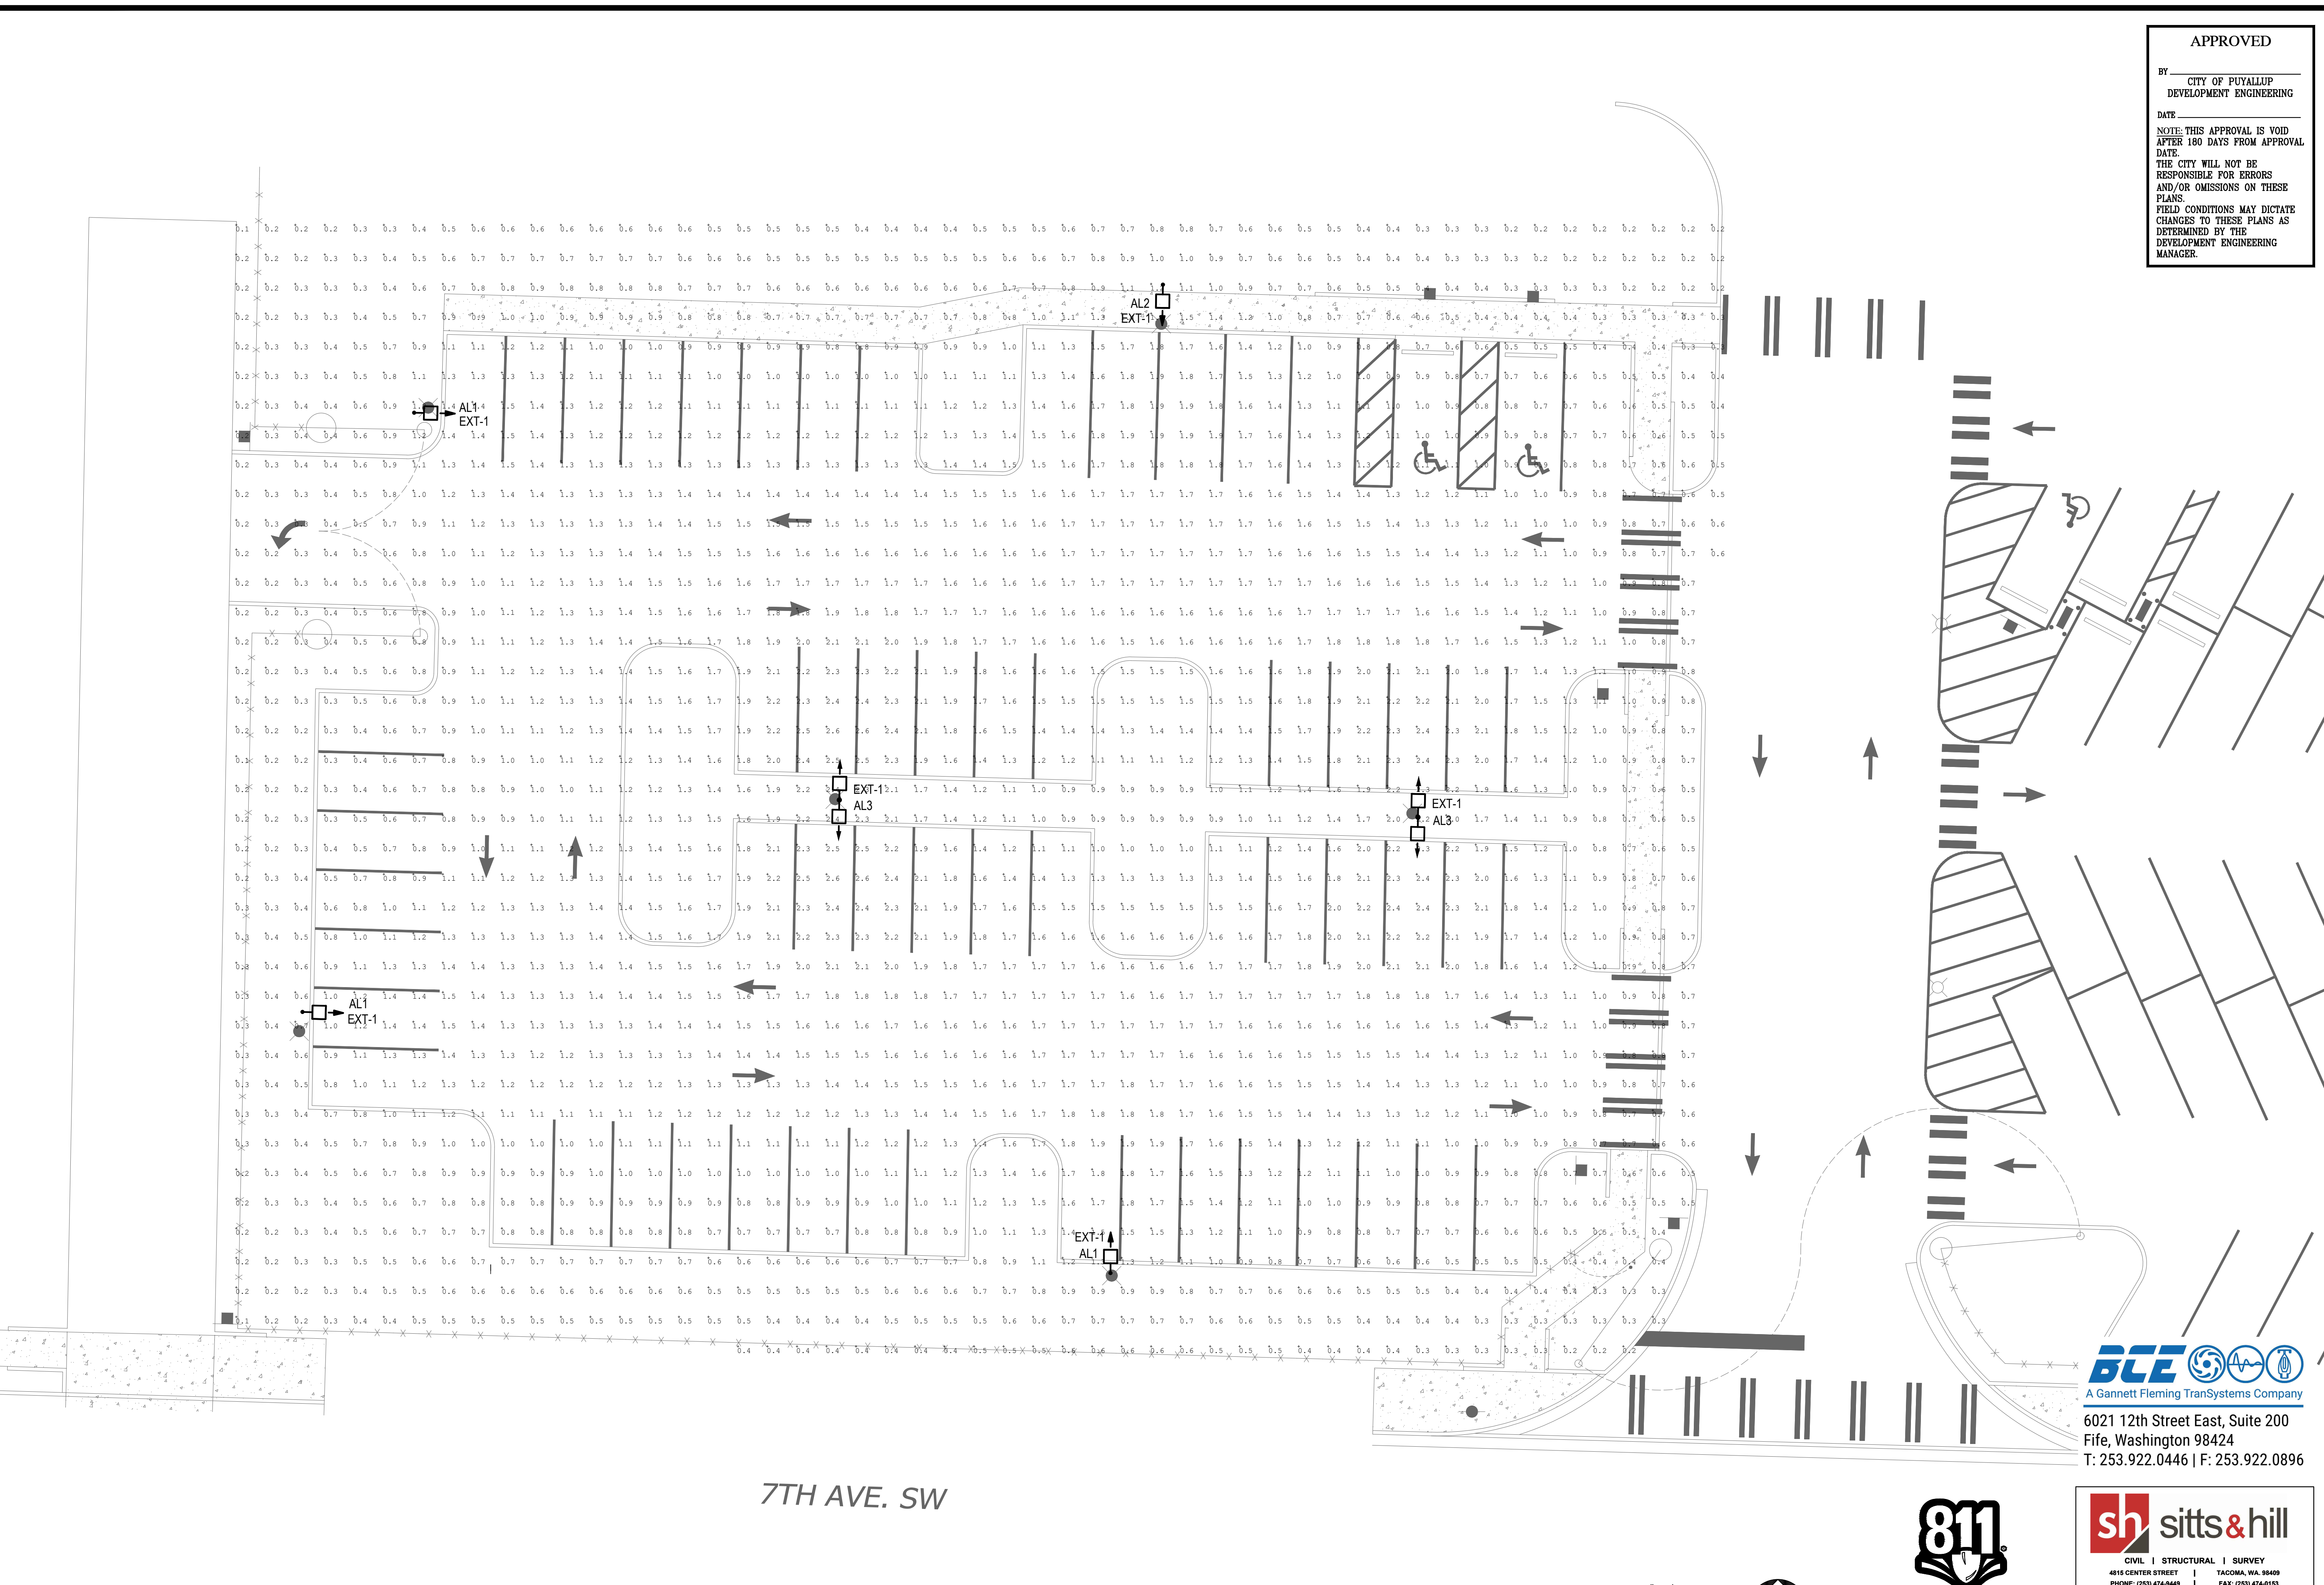

APPROVED
BY: CITY OF PUYALLUP
DEVELOPMENT ENGINEERING
DATE: _____
NOTE: THIS APPROVAL IS VOID
AFTER 180 DAYS FROM APPROVAL
DATE.
THE CITY WILL NOT BE
RESPONSIBLE FOR ERRORS
AND/OR OMISSIONS ON THESE
PLANS.
FIELD CONDITIONS MAY DICTATE
CHANGES TO THESE PLANS AS
DETERMINED BY THE
DEVELOPMENT ENGINEERING
MANAGER.

REVISIONS

NO.	DESCRIPTION	DATE

APPROVALS

DESIGNED BY	DRAWN	CHECKED	DATE	SCALE
EM	JL	EM	08/01/2024	AS NOTED

PREPARED BY: **sh** **sitts & hill**
CIVIL | STRUCTURAL | SURVEY
4815 CENTER STREET | TACOMA, WA 98409
PHONE: (253) 774-9449 | FAX: (253) 474-0153
http://www.sittshill.com


PREPARED FOR:
PUYALLUP SCHOOL DISTRICT
323 12TH ST NW
PUYALLUP, WA 98374

PROJECT:
**SPARKS STADIUM
EVENT PARKING LOT**
PUYALLUP, WASHINGTON 98371
SHEET TITLE:
ELECTRICAL SITE PLAN
SHEET NO.
E-101a

PROJECT NO.
19474

EVENT PARKING LAYOUT DESIGN OPTION 6 - LIGHTING CALCULATIONS
SCALE: 1"=10'

7TH AVE. SW

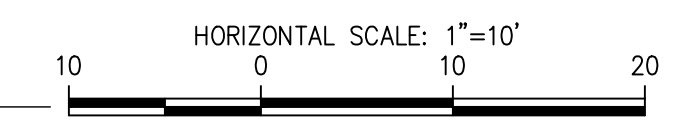

BCE
A Gannett Fleming TransSystems Company
6021 12th Street East, Suite 200
Fife, Washington 98424
T: 253.922.0446 | F: 253.922.0896

sh **sitts & hill**
CIVIL | STRUCTURAL | SURVEY
4815 CENTER STREET | TACOMA, WA 98409
PHONE: (253) 474-9449 | FAX: (253) 474-0153
http://www.sittshill.com

Project No.: 19474	Project Mgr.: RCH
Proj. Engineer: SAJ	Proj. Drafter: SAJ

04.08.2025 CITY PERMIT SET SUBMITTAL