


PRSG20260951

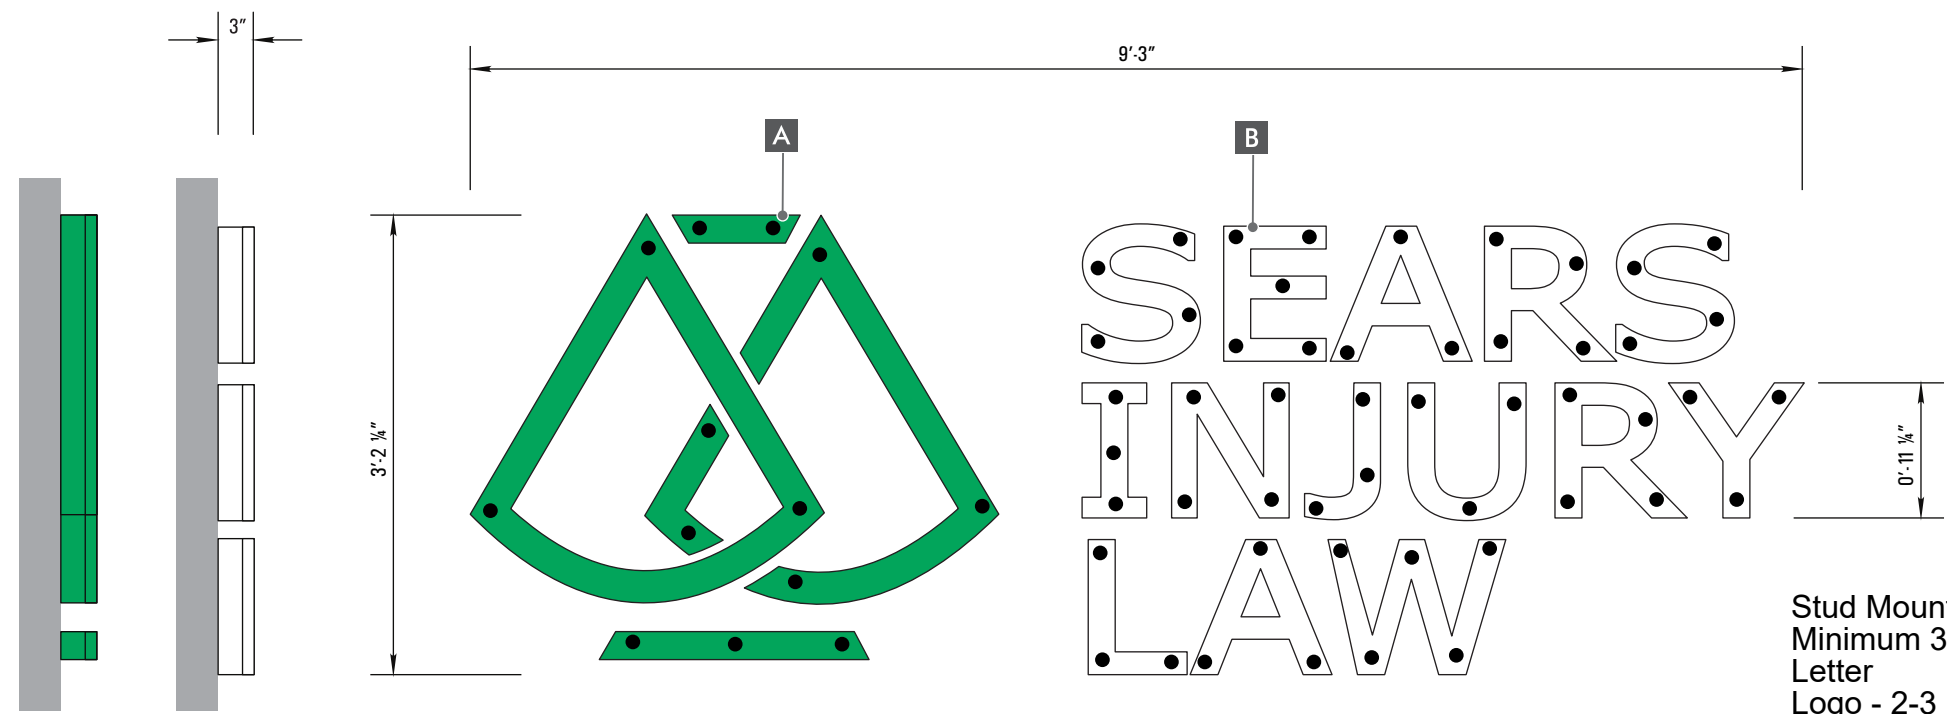

2 S/F ILLUMINATED DISPLAY
WEST ELEVATION

SCALE: 3/4" = 1'-0"


Stud Mounted
Minimum 3-4 per
Letter
Logo - 2-3 per piece

FABRICATION SPECIFICATIONS		
A	PAN CHANNEL LIGHTING	WHITE LED
	FACE COLOR	WHITE #7328
	VINYL COLOR	3630-156 VIVID GREEN
	TRIM CAP COLOR	MATCH 3630-156
	RETURN COLOR	MATCH 3630-156
B	PAN CHANNEL LIGHTING	WHITE LED
	FACE COLOR	WHITE #7328
	TRIM CAP COLOR	WHITE
	RETURN COLOR	WHITE

SCOPE OF WORK:

MANUFACTURE ILLUMINATED PAN CHANNEL LETTERS AND LOGO.

FRONT LIT LED LETTER- REMOTE POWER SUPPLY

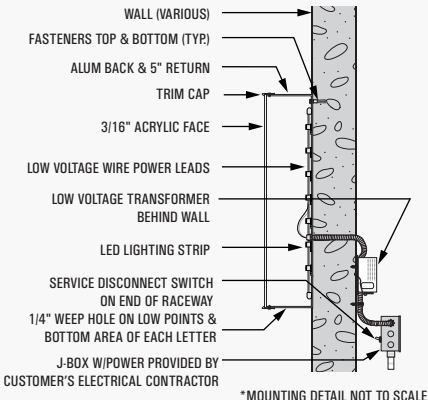


Approval of submitted plans is not an approval of omissions or oversights by this office or non compliance with any applicable regulations of local government. The contractor is responsible for making sure that the building complies with all applicable codes and regulations of the local government.

The approved construction plans, documents, and all engineering must be posted on the job at all inspections in a visible and readily accessible location.

Full sized legible color plans are required to be provided by the permittee on site for inspection.

Separate Electrical Permit is required with the Washington State Department of Labor & Industries.
<https://lni.wa.gov/licensing-permits/electrical/electrical-permits-fees-and-inspections>
or call for Licensing Information: 1-800-647-0982

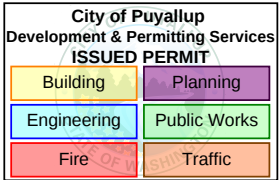

City of Puyallup
Building
REVIEWED
FOR
COMPLIANCE

SKinnear
07/24/2026
3:35:24 PM



ART SUPERIMPOSED ON PHOTO- SHOWN AT APPROXIMATE RELATIVE SCALE



Seattle
828 Valentine Ave SE Suite D
Pacific, WA 98047
253-442-6534

This drawing was created to assist you in visualizing our proposal. The original ideas herein are the property of YESCO. Permission to copy or revise this drawing can only be obtained thru a written agreement with YESCO.

© 2013 YESCO LLC
All rights reserved
www.yesco.com

CLIENT:
SEARS INJURY LAW

ADDRESS:
507 31ST AVE SW

CITY / STATE / ZIP:
PUYALLUP, WA

ACCOUNT EXECUTIVE:
JAMIE GORHAM

DESIGNER:
CD

ORIGINAL DATE:
6.1.26

CUSTOMER APPROVAL

Client Signature / Date

Landlord Signature / Date

ELECTRICAL NOTE

NOTE: UNLESS OTHERWISE NOTED, ELECTRICAL RUNS OR FINAL ELECTRICAL CONNECTION CHARGES ARE NOT INCLUDED. ILLUMINATED DISPLAYS WILL BE WIRED FOR 120 VOLT POWER UNLESS OTHERWISE INDICATED.

IF VOLTAGE IS NOT 120 PLEASE INDICATE YOUR VOLTAGE HERE
VOLTS AMPS

UL NOTE
YESCO IS A UL RECOGNIZED MANUFACTURER

THIS SIGN IS INTENDED TO BE INSTALLED IN ACCORDANCE WITH THE REQUIREMENTS OF ARTICLE 600 OF THE NATIONAL ELECTRICAL CODE AND / OR OTHER APPLICABLE LOCAL CODES. THIS INCLUDES PROPER GROUNDING AND BONDING OF THE SIGN.

REVISIONS

DATE	REVISION	DESIGNER

PRODUCTION READY

JOB ORDER 218398

SOY NUMBER:

SOY-144648

DESIGN NUMBER:

OPY-79775