


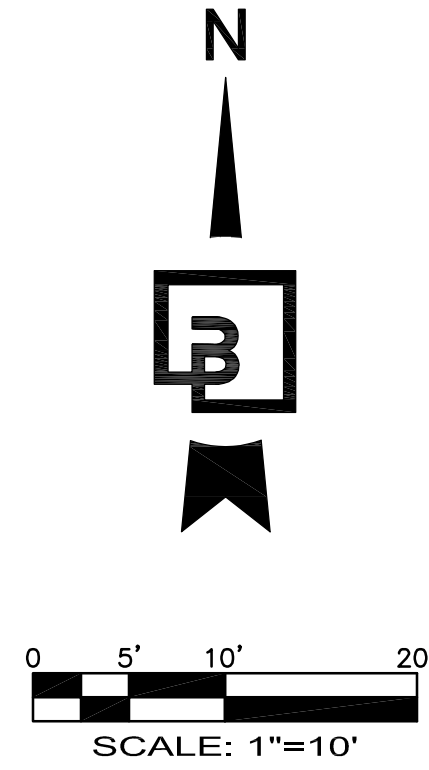


SITE PLAN
FOR
PUYALLUP OFFICE BUILDING
A PORTION OF THE NW 1/4 OF THE W 1/2 OF SEC 09, TWP 19 NORTH, RGE 4
EAST, W.M. CITY OF PUYALLUP, PIERCE COUNTY WASHINGTON

B-21-0867

The applicant is responsible to coordinate water service requirements with Fruitland Mutual Water Company.

SFR Demo Permit: B-17-0780
Garage Demo Permit: B-17-0781
Civil Permit: E-21-0374

Demo Permit B-17-0780 has not been finalized!

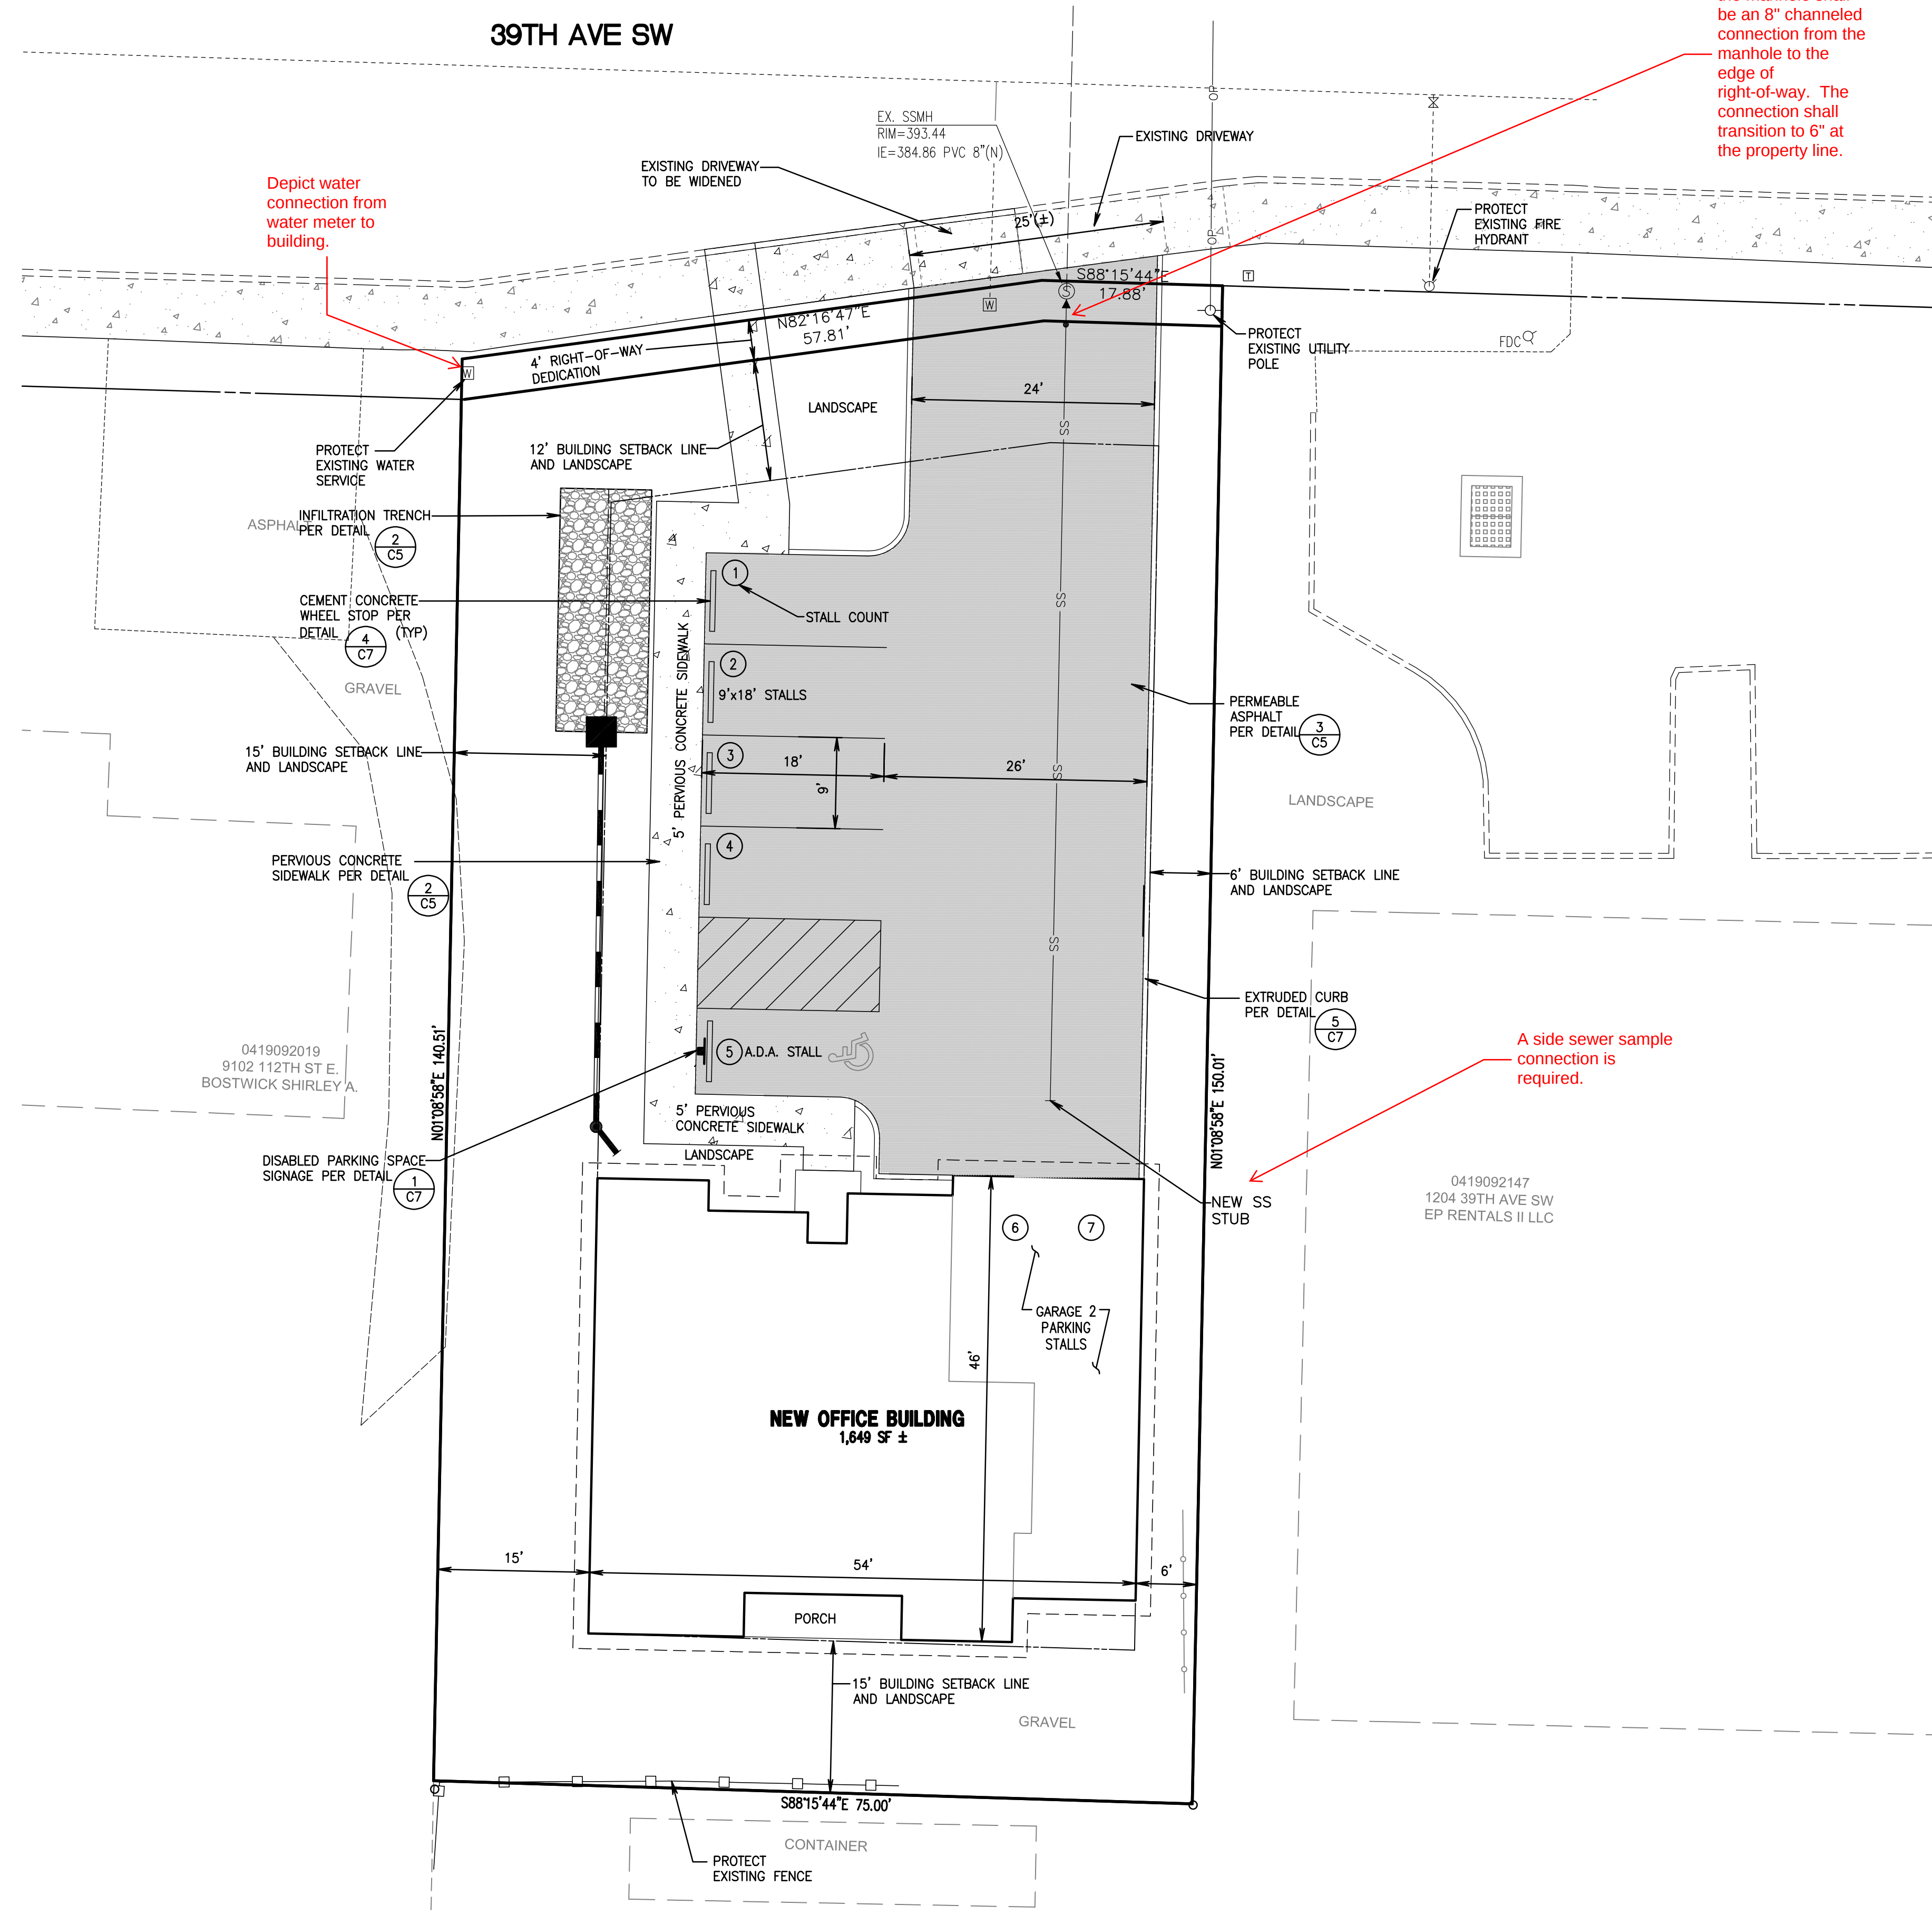


Revision	No.	Date	By	Chd.	Appr.

Title:


PRESIDENTIAL HOMES
1212 39TH AVENUE SW
PUYALLUP, WA 98373

For:

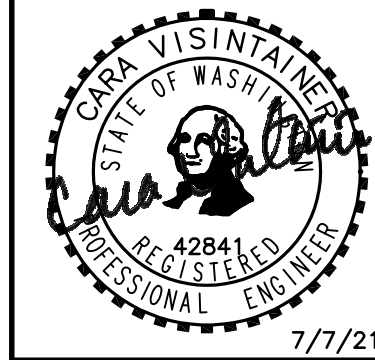

Scale:	Horizontal	Vertical
1"=10'	1"=10'	NA
Designed	CMV	CMV
Drawn	CMV	CMV
Checked	CMV	CMV
Approved	CMV	CMV
Date	7/7/21	7/7/21

Barghausen Consulting Engineers, Inc.
18215 72nd Avenue South
Kent, WA 98032
425.251.6222
barghausen.com

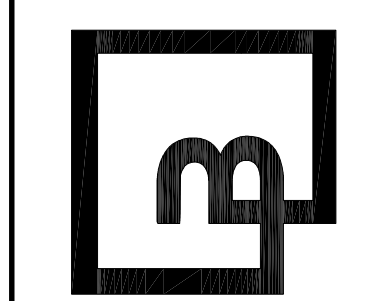

Job Number	21545
Sheet	C4 of 9