




1. Horn/strobes required to all sync. 2. All required maintenance and inspections to be complete prior to inspection. 3. Fire Alarm System to be 100% code compliant prior to inspection. 4. See Permit Conditions.

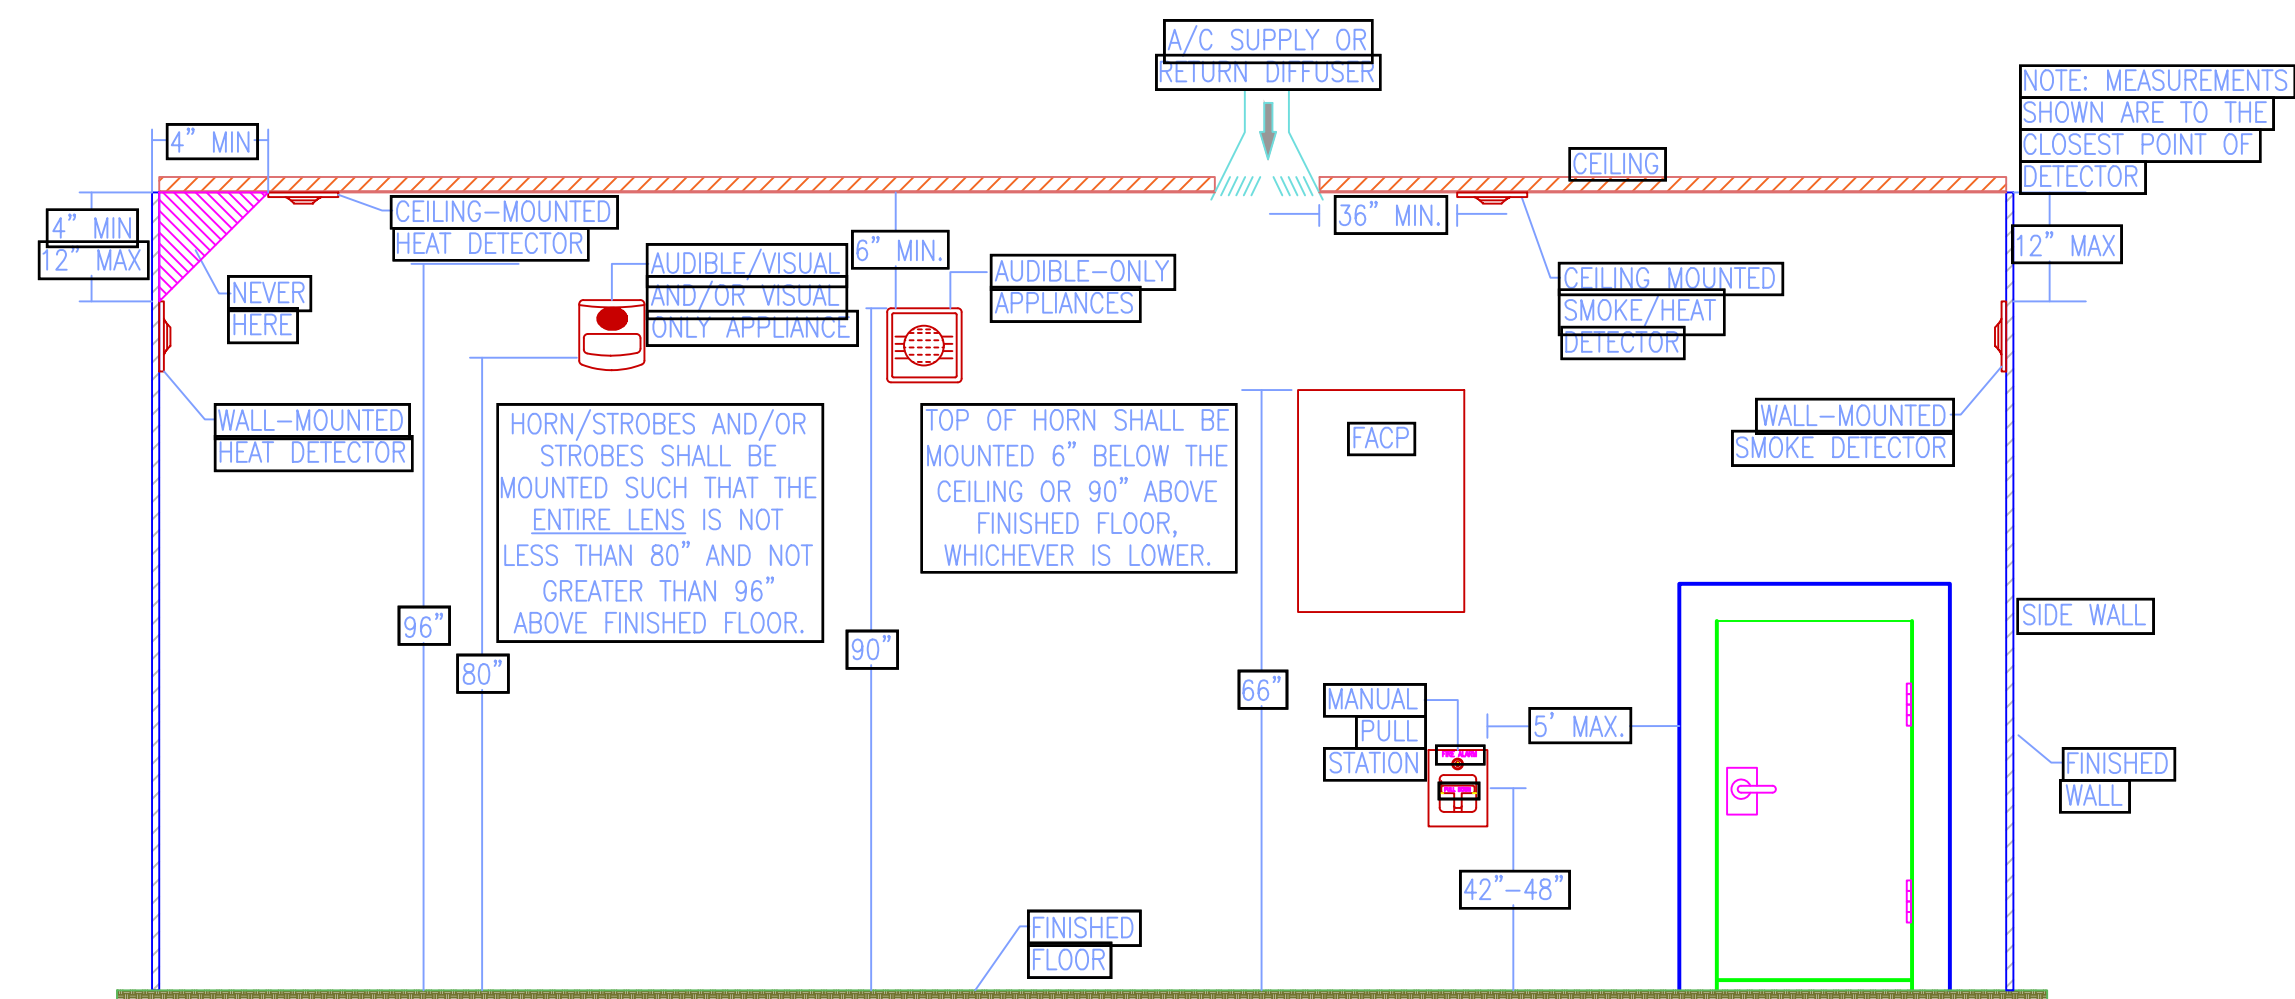


FIRE ALARM DEVICE MOUNTING HEIGHTS

SCALE: NOT TO SCALE


NOTES:

1. LOCATE CEILING MOUNTED HEAT/SMOKE DETECTORS ON THE BOTTOM OF THE DECK/SUSPENDED CEILING (NOT ON BOTTOM OF STRUCTURAL MEMBERS), AND AS INDICATED IN NFPA 72.
2. LOCATE CEILING MOUNTED NOTIFICATION DEVICES ON BOTTOM OF BEAMS OR JOISTS; WITH CLEAR LINE OF SITE IN ALL DIRECTIONS; NO GREATER THAN THIRTY (30) FEET ABOVE THE FINISHED FLOOR; AND AS INDICATED IN NFPA 72.
3. LOCATE CEILING MOUNTED NOTIFICATION DEVICES FLUSH WITH THE SUSPENDED CEILING; ALIGNED WITH LIGHTING, SPRINKLERS, AND OTHER ARCHITECTURAL FIXTURES; WITH CLEAR LINE OF SITE IN ALL DIRECTIONS; NO GREATER THAN THIRTY (30) FEET A.F.F. ; AND AS INDICATED IN NFPA 72.
4. LOCATE WALL MOUNTED NOTIFICATION DEVICES AT 80" A.F.F TO BOTTOM OF BACK BOX.
5. COORDINATE EXACT MOUNTING HEIGHT OF CONTROL PANELS, ANNUNCIATORS, AND POWER SUPPLIES WITH THE GENERAL CONTRACTOR, ELECTRICAL CONTRACTOR AND AHJ PRIOR TO INSTALLATION.
6. MEASURED TO THE OPERABLE PART OF THE PULL STATION.

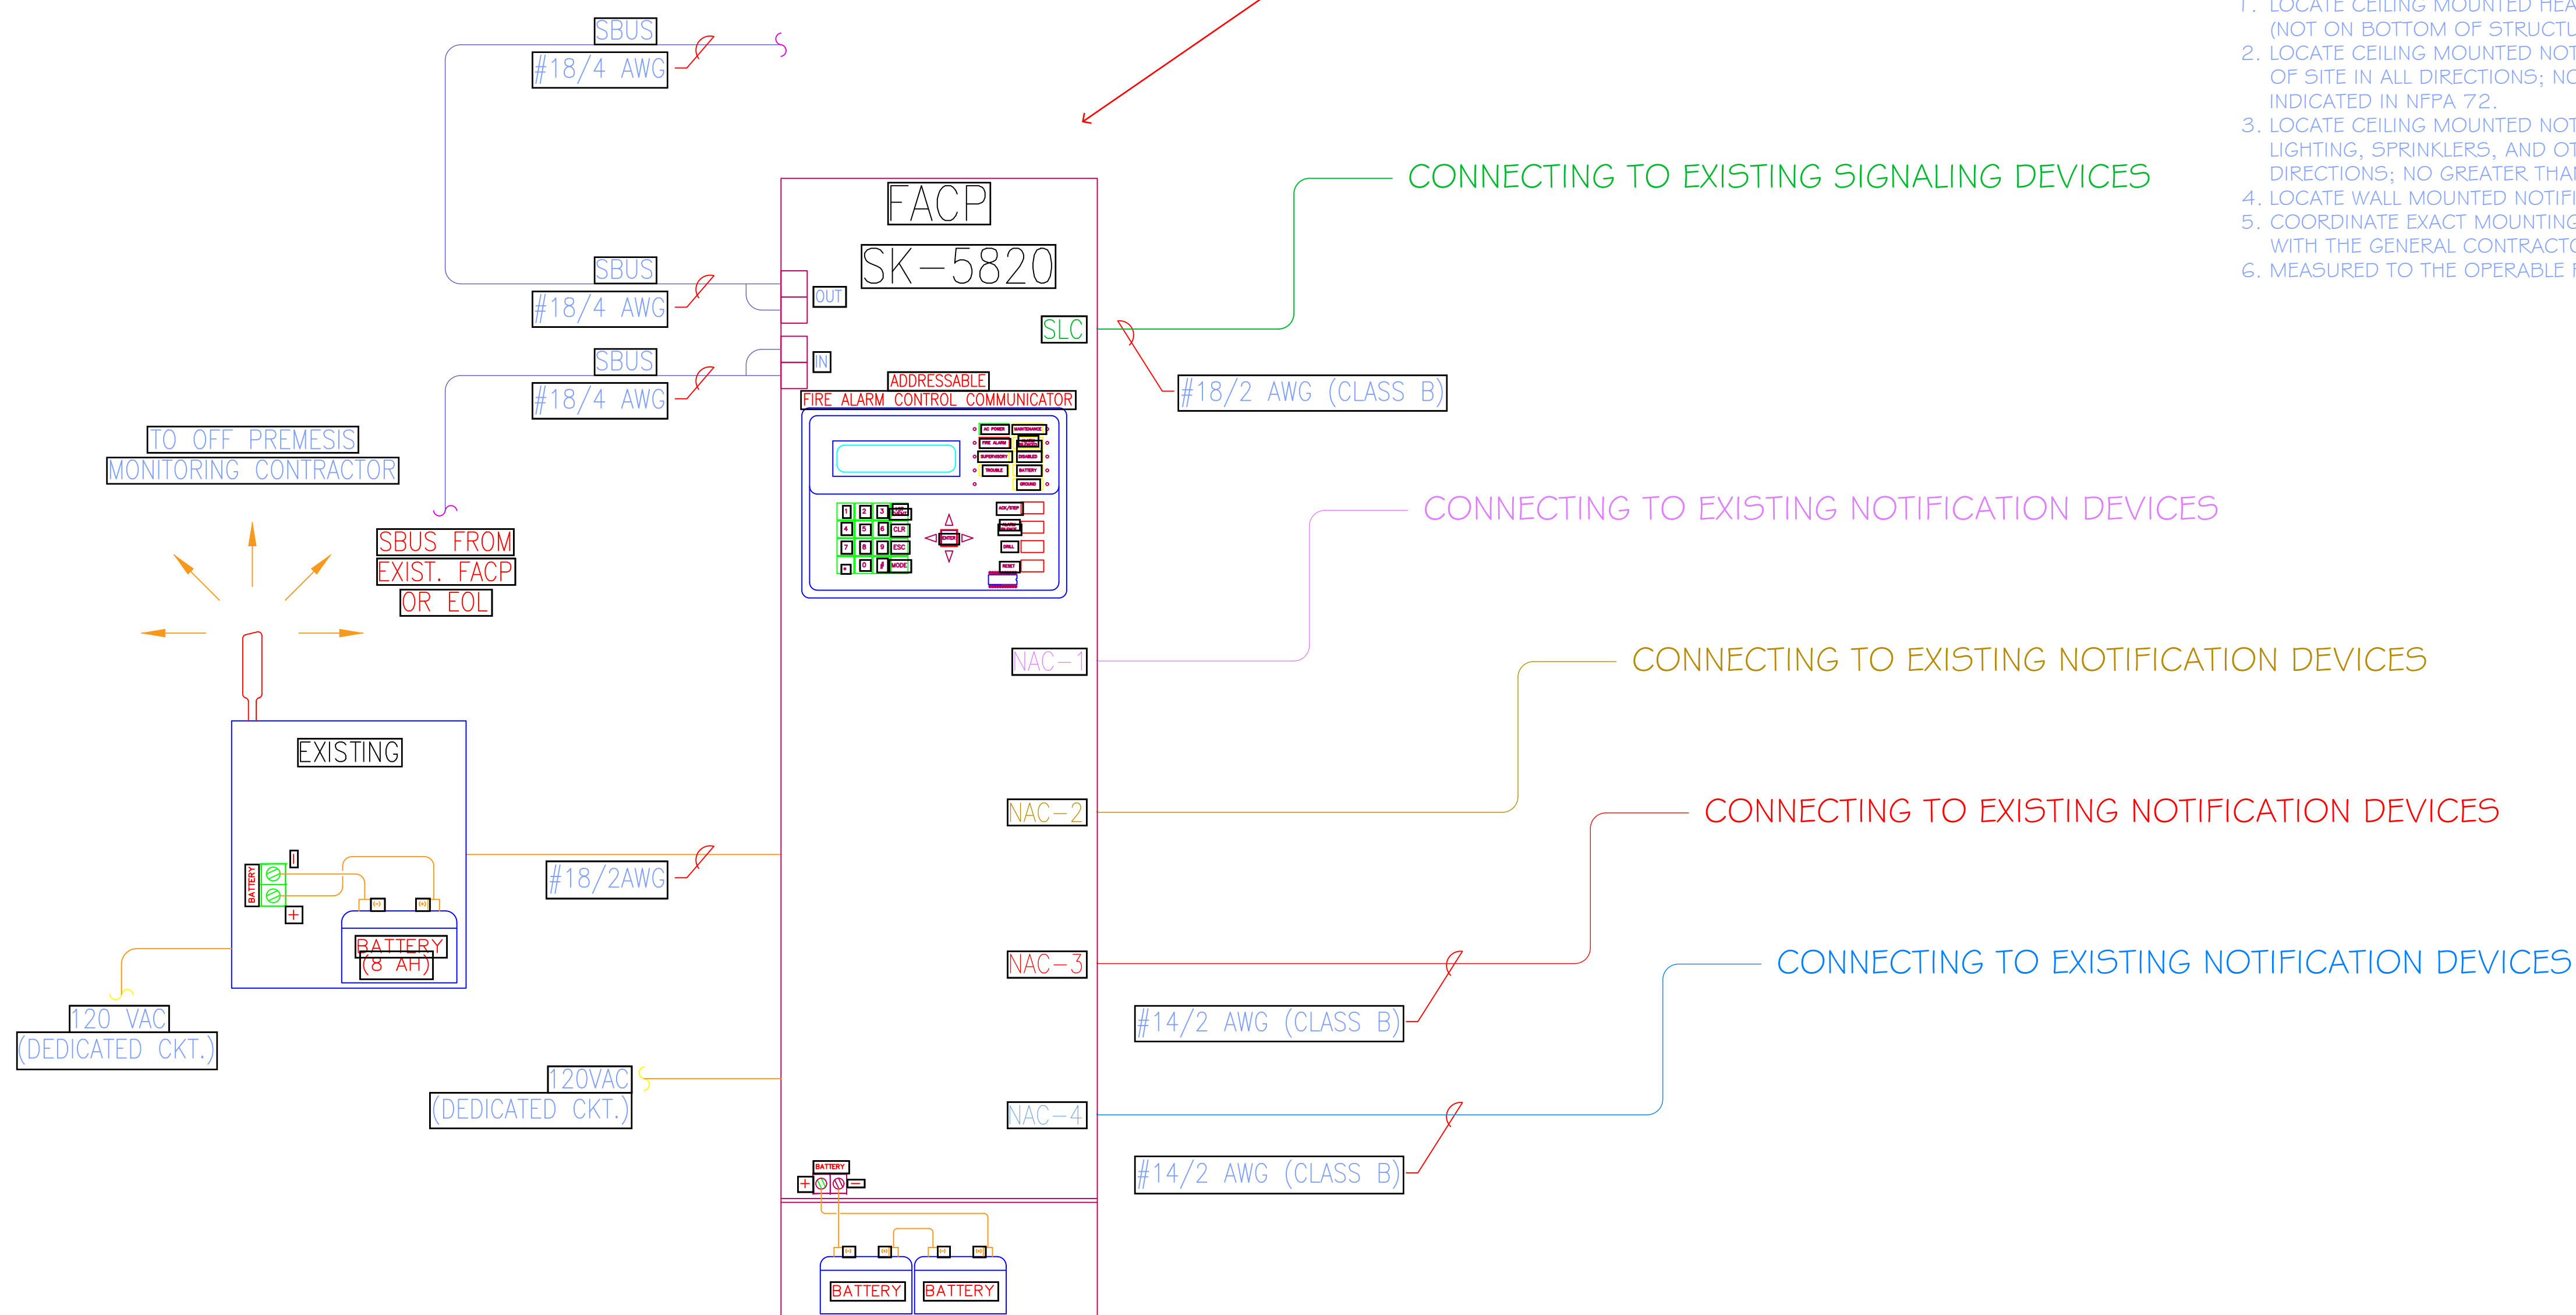

FIRE ALARM RISER DIAGRAM


SCHEMATIC: NO SCALE

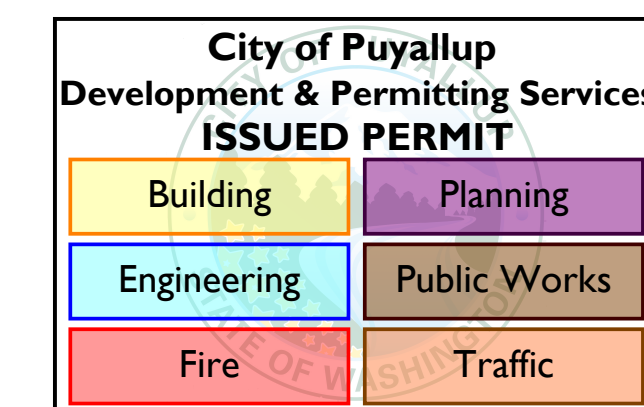

THE APPROVED CONSTRUCTION PLANS AND ALL ENGINEERING MUST BE POSTED ON THE JOB AT ALL INSPECTIONS IN A VISIBLE AND READILY ACCESSIBLE LOCATION.

Approval of submitted plans is not an approval of omissions or oversight by this office or noncompliance with any applicable regulations of local government. The contractor is responsible for making sure that the building complies with all applicable building codes and regulations of the local government.

City of Puyallup  
Fire  
REVIEWED  
FOR  
COMPLIANCE  
DDrake  
03/21/2022  
6:54:11 AM

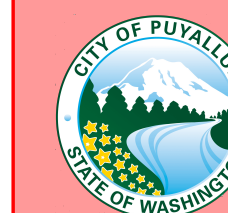

4500 3rd AVE. SE., Suite #1  
LACEY, WA 98503  
800-354-1555  
CONTRACTOR'S LIC. NO. STANLIC925M2  
A DIVISION OF STANLEY SECURITY SOLUTIONS



Date:	Rev:	Description:
March 7, 2022	A	###/###/###
Drawn By:		
email:		
Job #:		
File Name:		
DWG Name:		
Plot Date:		
Version:		

Project Name: Life Care Center of South Hill  
2508 7th ST. SE  
Puyallup, WA 98374  
Parcel # 0419032026

Sheet Number

RISER