

LUMINAIRE SCHEDULE

CALLOUT	SYMBOL	DESCRIPTION	LAMP	BALLAST	MOUNTING	MODEL	INPUT WATTS	VOLTS	NOTES
P1E	—	LED STRIP 4" SOLID REFLECTOR 4000K, INTEGRAL OCCUPANCY SENSOR, STEP DIM TO 40%, 1000 LUMEN INTEGRAL BATTERY	(1) 31.4W LED, 4000K, 3856 LUMENS	STEP DIM W/BATTERY	SURFACE	PHILIPS DAY-BRITE, FSW 4 40L 840 UNV SDIM LSXR10 EMLED	31.4	MULTIPLE	PARKING GARAGE, EMERGENCY. FIXTURE TO BE MOUNTED NO HIGHER THAN 10-FT TO BOTTOM OF FIXTURE. SUSPEND FIXTURE WITH CABLE AS NEEDED. SET TIMER DELAY TO 20 MINUTES. WHEN UNOCCUPIED, DIM TO 40%, RAMP UP TO 100% WHEN OCCUPIED.
R1	•	4 INCH LED DOWNLIGHT, 1500 LUMENS, 0-10V DIM, 80 CRI, 3000K, COMFORT CLEAR TRIM, WHITE FLANGE, NON IC RATED	(1) 16.8W LED 3000K, 80CRI	0-10V	CEILING	PHILIPS LIGHTOLIER P4R A, P4R DL 15 830 CC Z10 U	16.8	120V 1P 2W	HALLWAY, SITE
Z1	•	EXTERIOR 4" WALL CYLINDER DOWNLIGHT	(1) 9.5W LED 4000K	0-10V	WALL	DMF DC4MMWMD07GA0000040XX	9.5	120V 1P 2W	EXTERIOR WALL
Z2	▲	EXTERIOR WALL PACK	(1) 10W LED 3000K	STANDARD	WALL	RAB LIGHTING WPLED10Y	10	120V 1P 2W	EXTERIOR WALL
Z3	•	EXTERIOR ENTRY LIGHT	(1) 15W LED 4000K	DIMMING	WALL	TROY RLM RS-16-LED 1540 XXX C OG XX	15	120V 1P 2W	EXTERIOR WALL

Day-Brite P1E
Linear
Fluorescent replacement
4" x 4" x 1/2"

Day-Brite P1E Fluorescent LED replacement is a high performing fixture with a long life span. It is designed to be a drop-in replacement for standard fluorescent fixtures. It is available in a variety of configurations and is compatible with standard ballasts.

Lightolier R1
Downlighting
4" x 4" x 1/2"

Provides a contemporary LED ceiling light with the actual and reflected colors. Offers a wide range of finishes and is available in a variety of configurations. It is compatible with standard ballasts.

LUMINAIRE SCHEDULE

SCALE: 1" = 20'

M Series Cylinder Z1
4" Wall Mount

Integrated Dimmer allows for dimming to 40% during operation with the sensor.


Compatible with standard ballasts.

WPLED10Y Z2
RAB

Technical Specifications:
- Power: 10W
- Voltage: 120V
- Lumens: 1000
- Color Temp: 3000K


North Coast Z3

MEET BEYOND A TYPE IN EXTERIOR GARAGE ENTRY. NO NEED FOR AN OCCUPANCY SENSOR (TIMER AND SENSING).

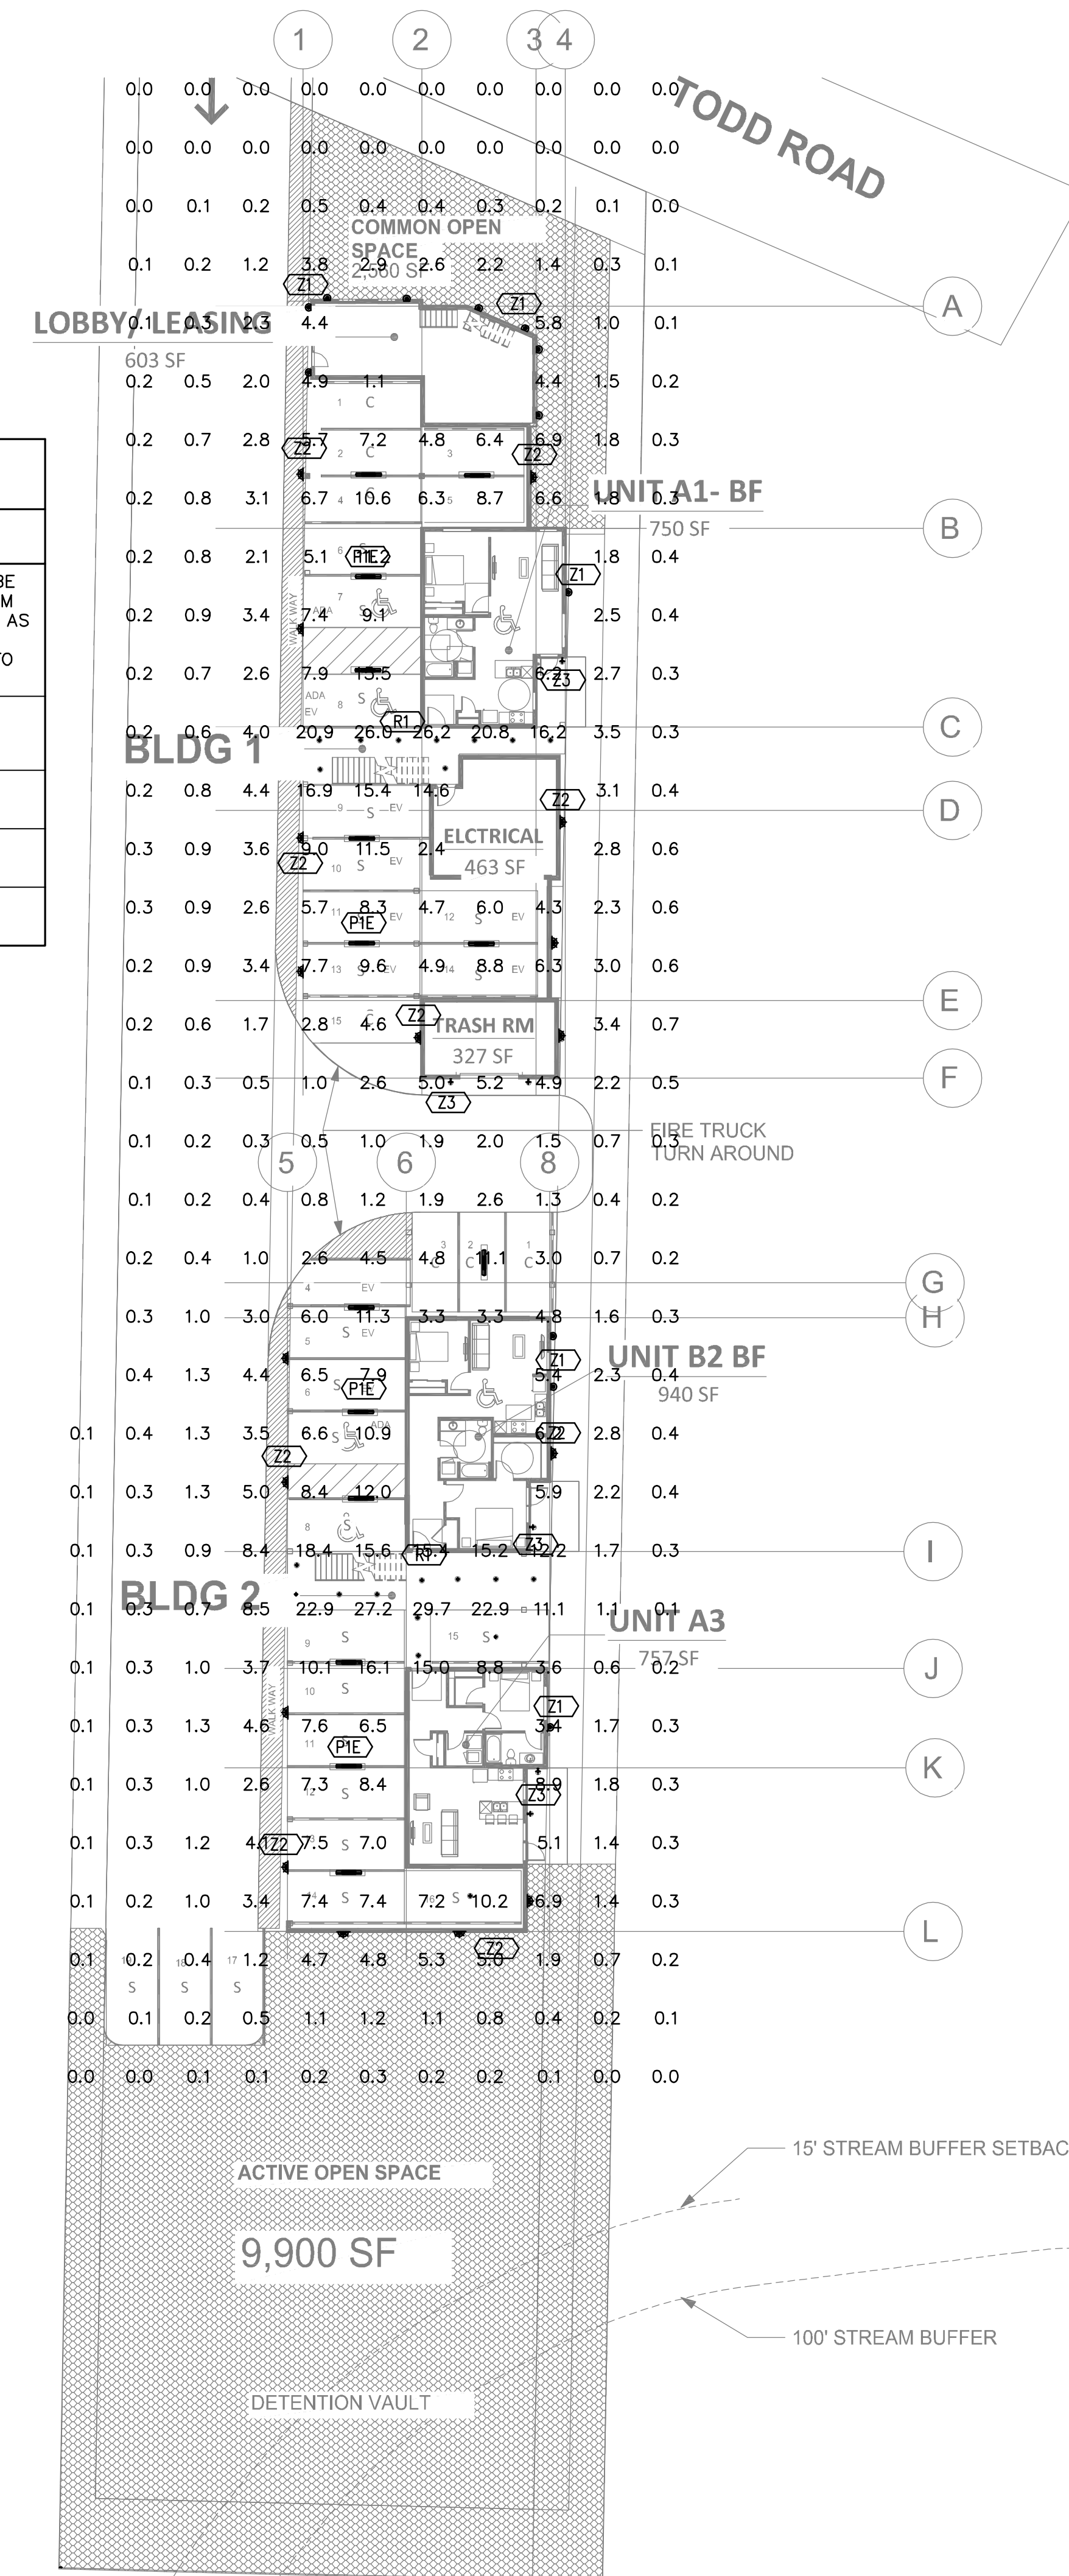

SITE PLAN - PHOTOMETRICS

SCALE: 1" = 20'

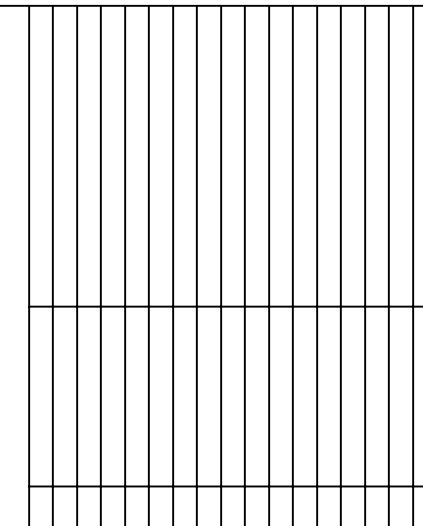

PUYALLUP MULTIFAMILY
AMERIPRIDE LENDING LLC
212 TODD ROAD NE, PUYALLUP WA

veer
ARCHITECTURE PLLC

10655 NE 4th ST
Suite 700
Bellevue, WA 98004
T 425.401.6828
www.VeerArchitecture.com

SITE PLAN - LIGHTING

E1.00