

BY _____
CITY OF PUYALLUP
DEVELOPMENT ENGINEERING

DATE _____

NOTE: THIS APPROVAL IS VOID
AFTER 180 DAYS FROM APPROVAL
DATE.


THE CITY WILL NOT BE
RESPONSIBLE FOR ERRORS
AND/OR OMISSIONS ON THESE
PLANS.

FIELD CONDITIONS MAY DICTATE
CHANGES TO THESE PLANS AS
DETERMINED BY THE
DEVELOPMENT ENGINEERING
MANAGER.


PROPOSED FEATURES

 36 PROPOSED CONTOUR
 GRADE BREAK
 FLOW LINE


KEY NOTES

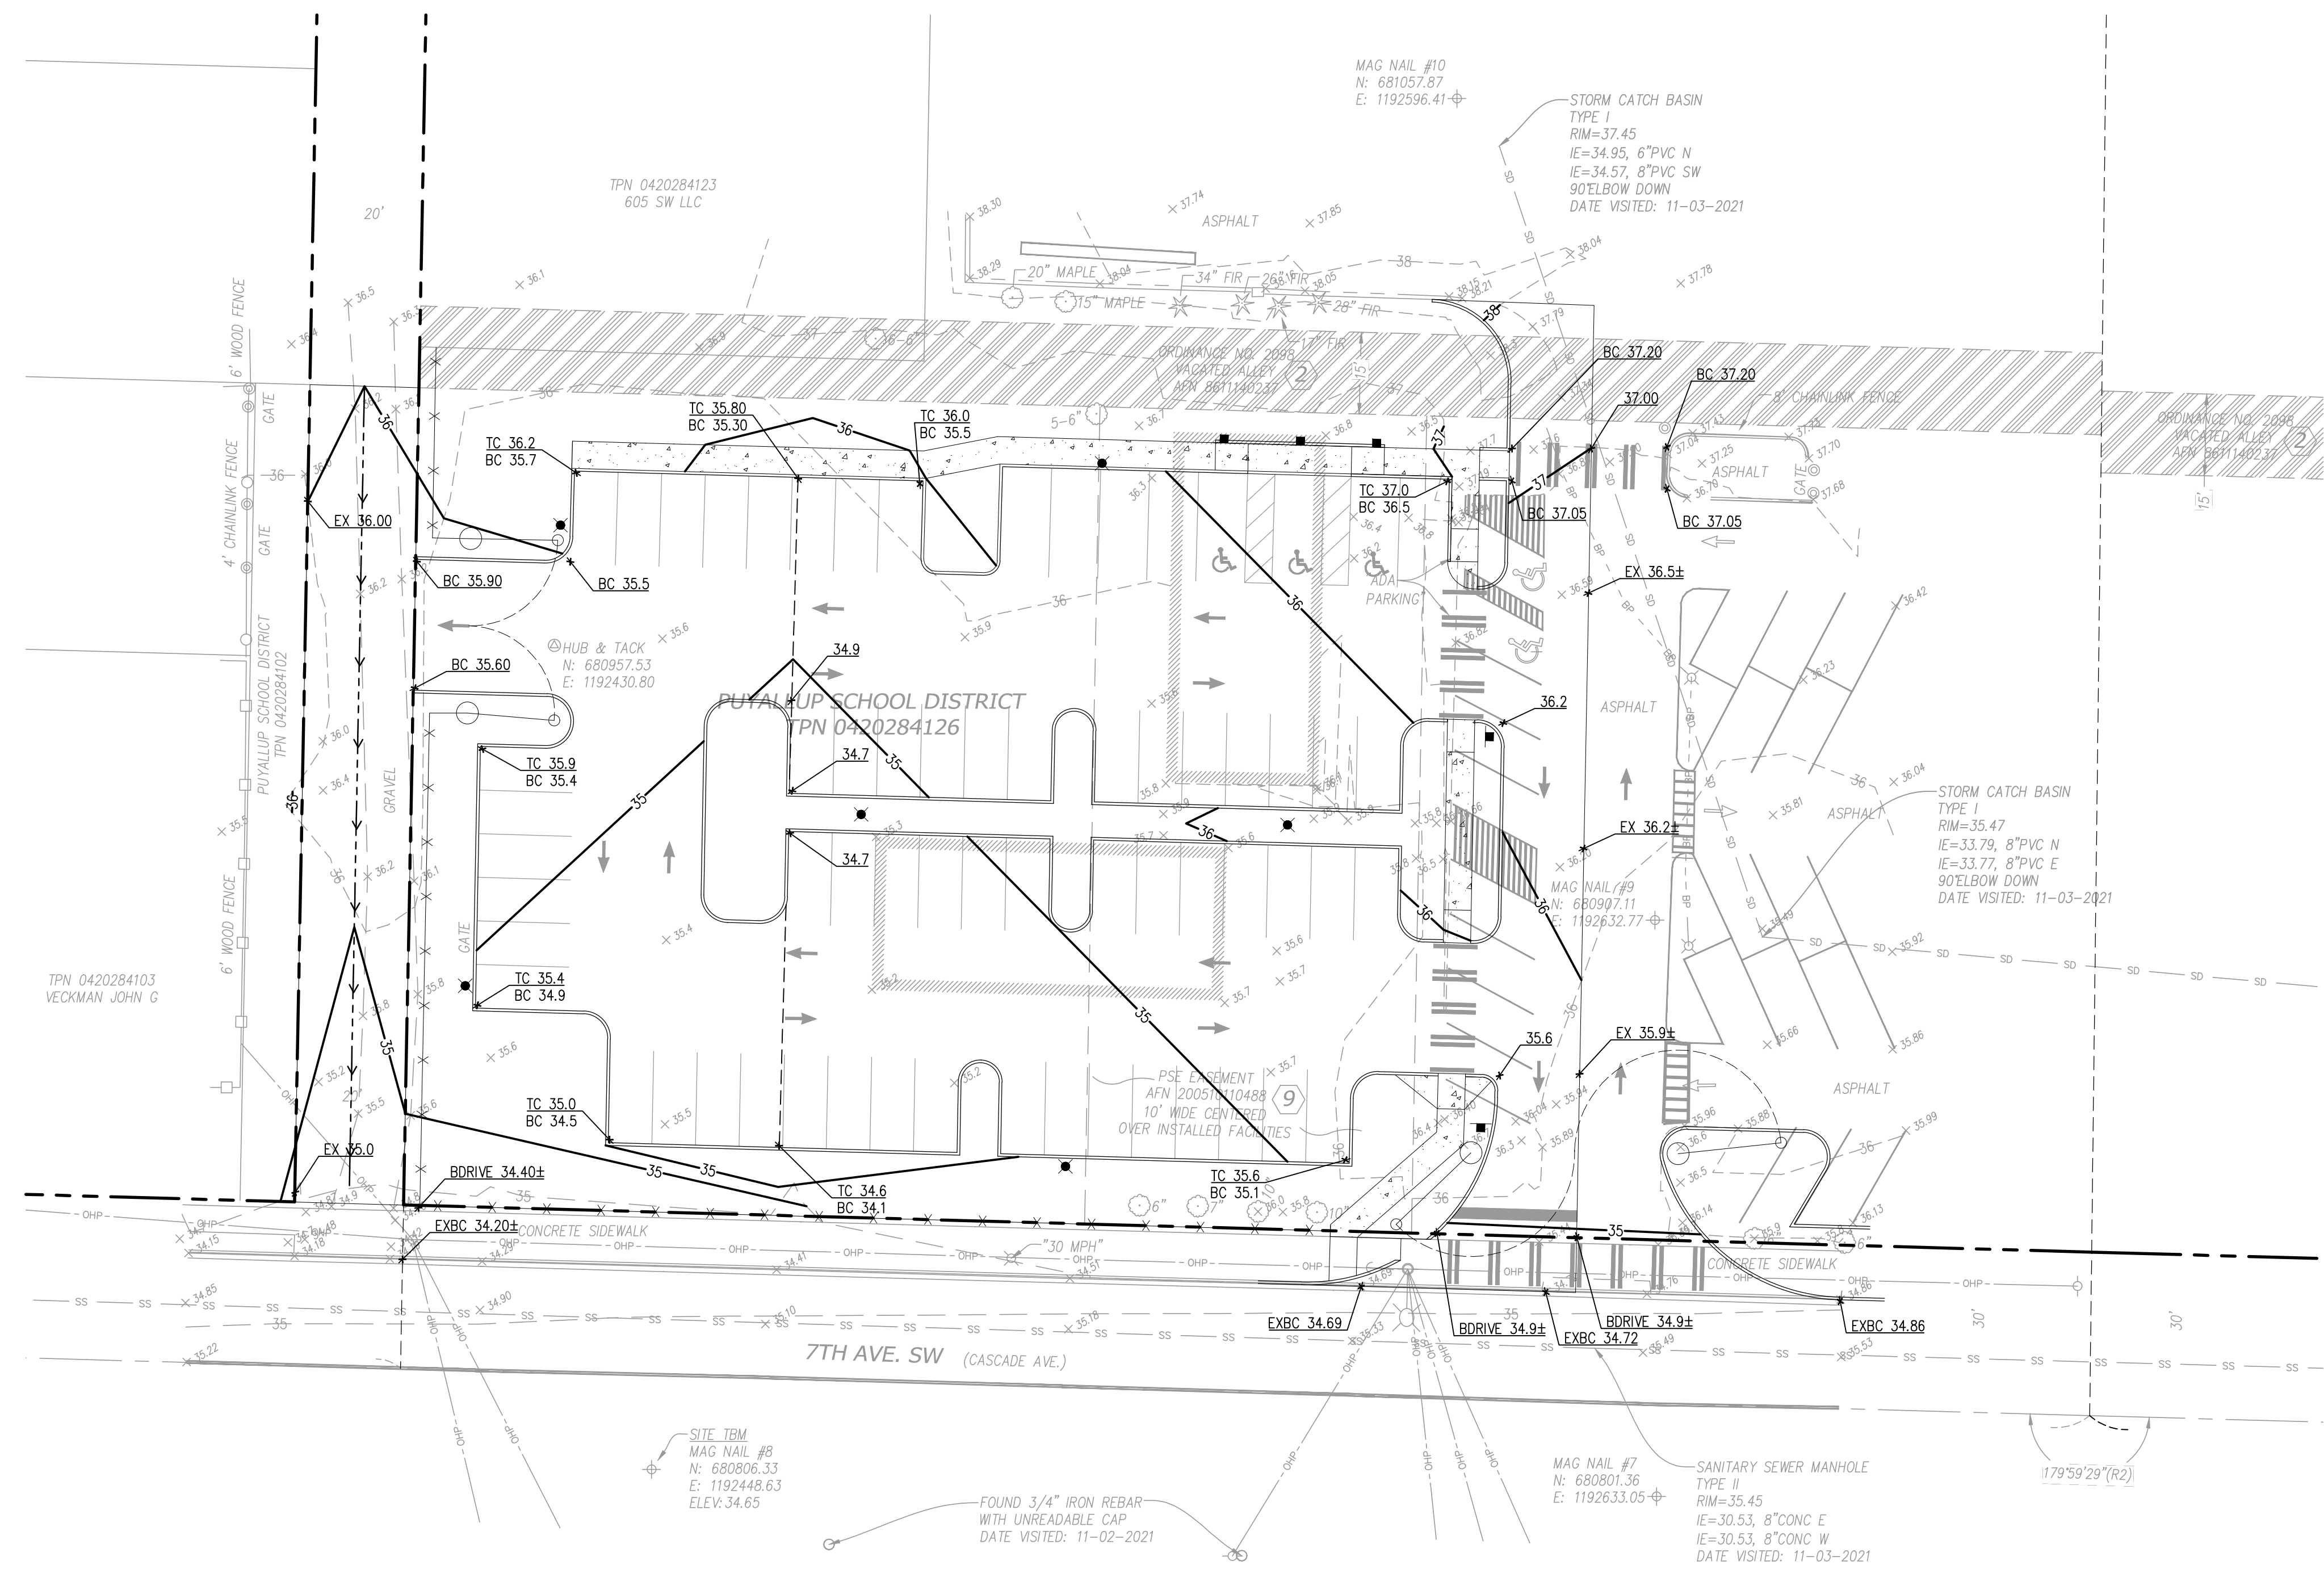

SCALE: 1"=20'

 

DESIGNED	RCH
DRAWN	KLK
CHECKED	RCH
DATE	09/13/2024
SCALE	AS NOTED

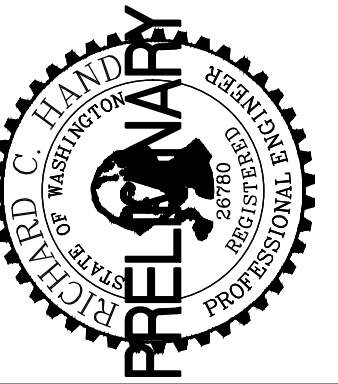

PUYLLUP SCHOOL DISTRICT
323 12TH ST NW
PUYALLUP, WA 98374

STARKS STADIUM

EVENT PARKING LOT

PUYALLUP, WASHINGTON 98371

SHEET TITLE

GRADING AND DRAINAGE PLAN

C3.0
PROJECT NO. 19474

C:\19400\19474\Drawings\19474 - c3 Oss.dwg last edited: 09/19/24 9:01am by: KreischerK