




Scale: 1 inch= 80 Ft.






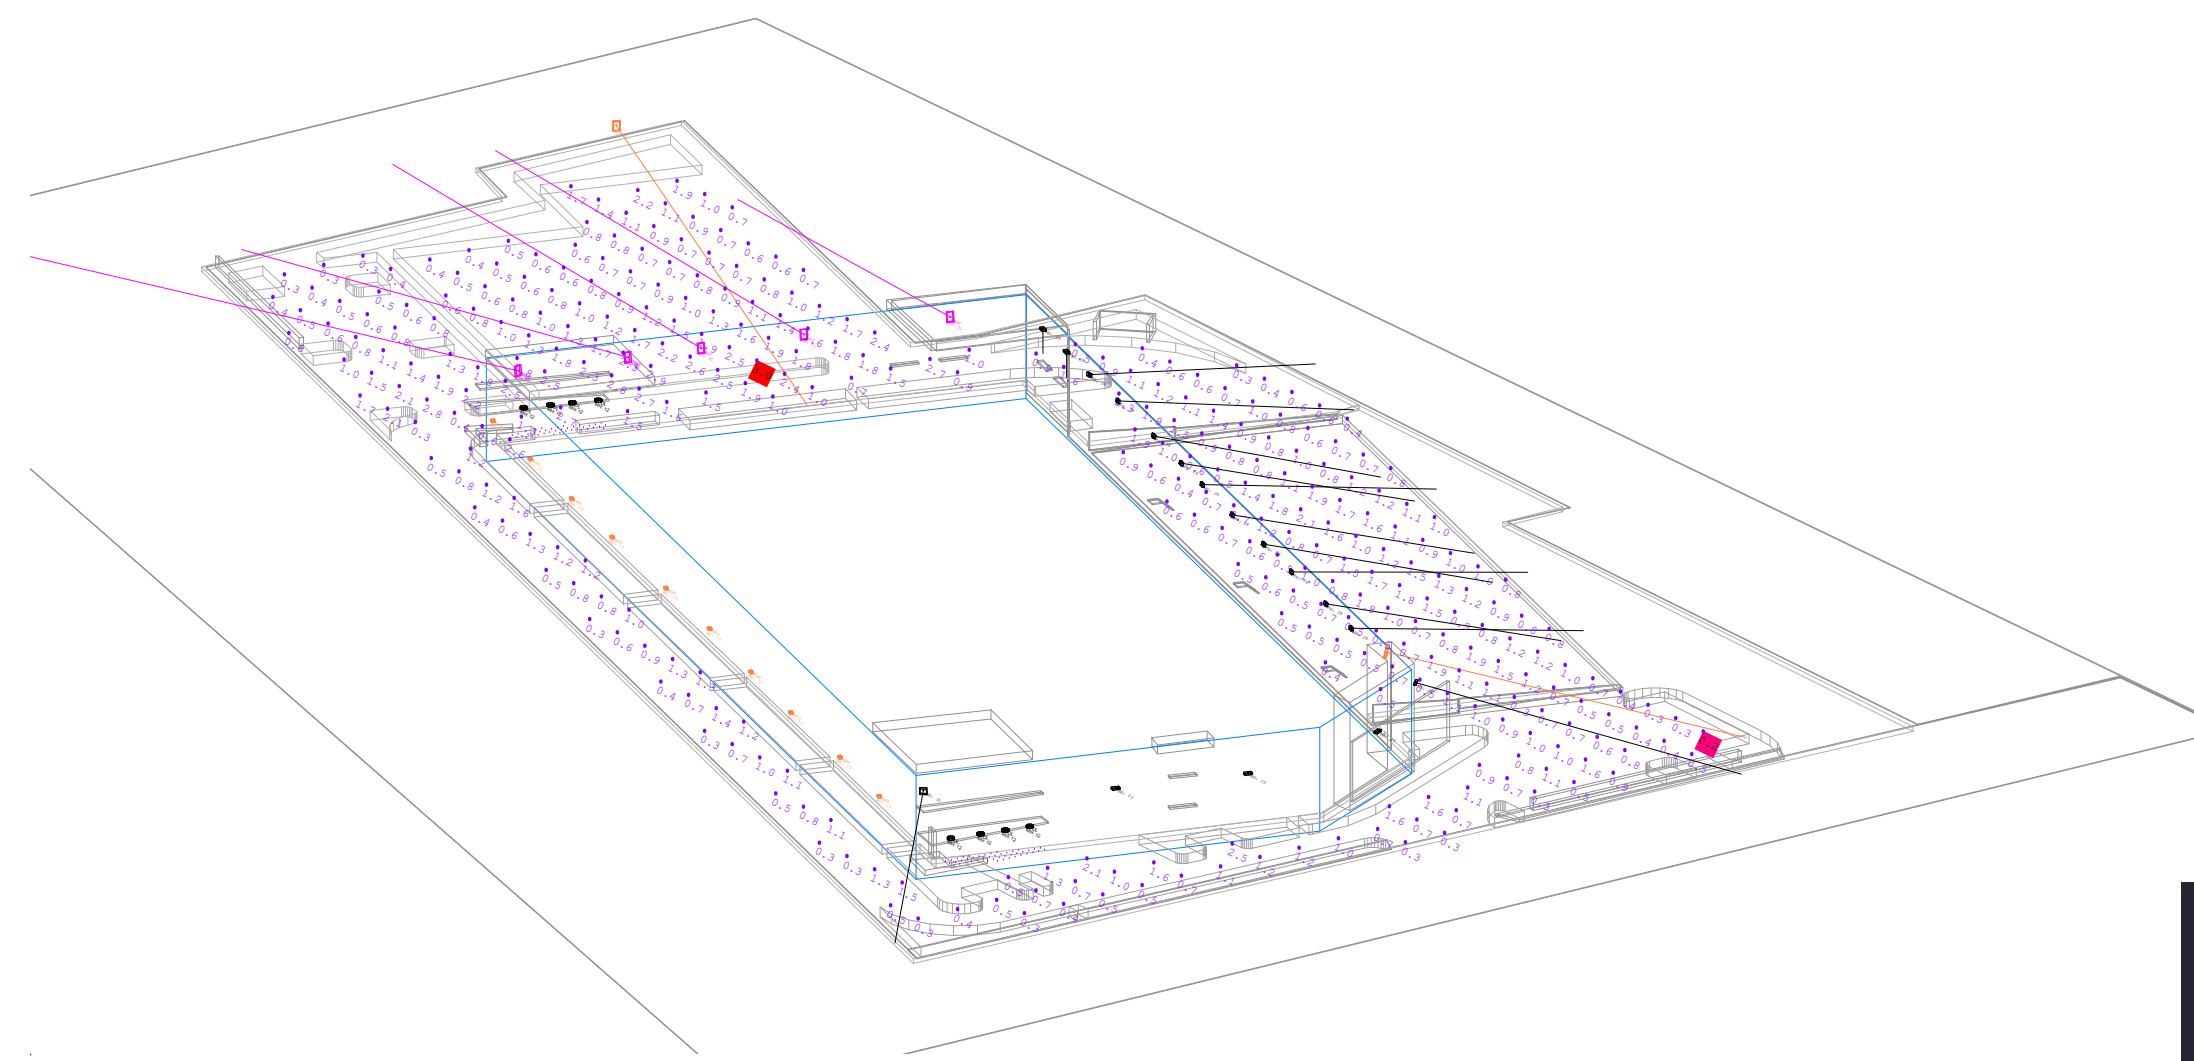


Scale: 1 inch= 80 Ft.

LIGHT MEASURED ON THE GROUND

Calculation Summary							
Label	CalcType	Units	Avg	Max	Min	Avg/Min	Max/Min
bdlg entry1	Illuminance	Fc	6.44	7.8	4.6	1.40	1.70
bdlg entry2	Illuminance	Fc	6.58	8.4	2.6	2.53	3.23
PARKING DRIVE AND LOADING	Illuminance	Fc	1.04	3.0	0.2	5.20	15.00

Luminaire Schedule								
Symbol	Qty	Description	Tag	MH	LLF	Luminaire Lumens	Luminaire Watts	[MANUFAC]
□	11	RSXF1 LED P2 40K SP		28, 31	0.910	9728	72.95	Lithonia Lighting
□	10	WDGE2 LED P2 40K 70CRI T2M	WM4	15	0.910	2326	18.9815	Lithonia Lighting
○	8	JSF 13IN 18LM 40K 90CRI	DL	12	0.910	1905	20.2	Juno Lighting
		MVOLT 2T WH						
□	5	WDGE3 LED P3 70CRI RFT 40K		23, 28	0.910	10145	71.6952	Lithonia Lighting
□	2	RSXF3 LED P4 40K AWFD	P	20, 31	0.910	40262	311.92	Lithonia Lighting
□	5	RSXF3 LED P4 40K NFL	WMF	31	0.900	39770	311.92	Lithonia Lighting
□	1	RSXF2 LED P3 40K WFL		31	0.900	20461	149.98	Lithonia Lighting

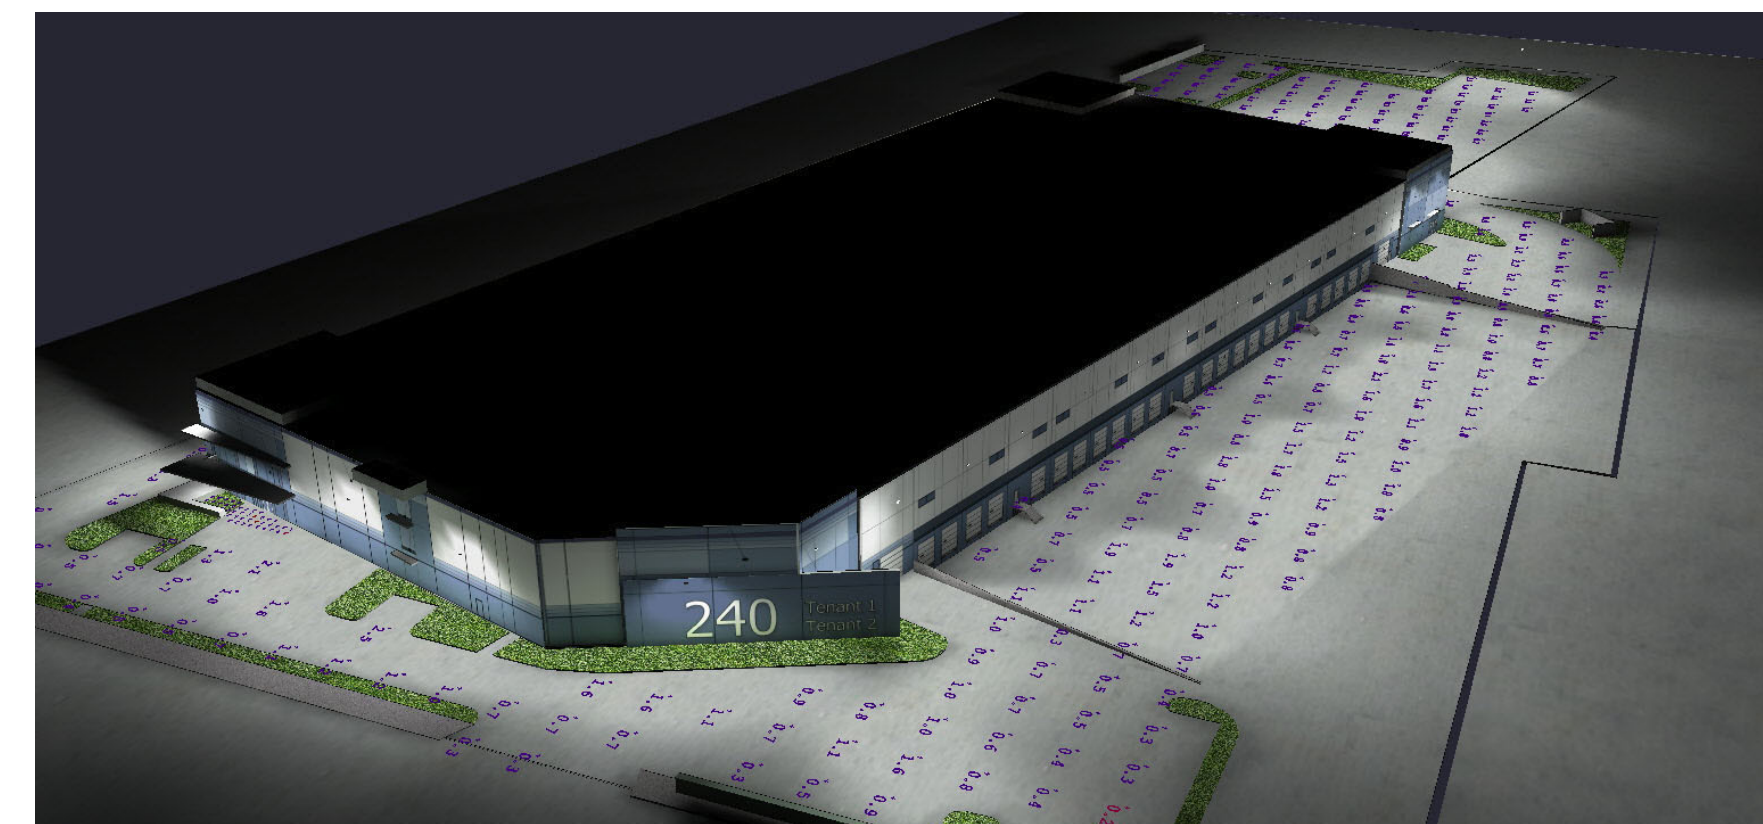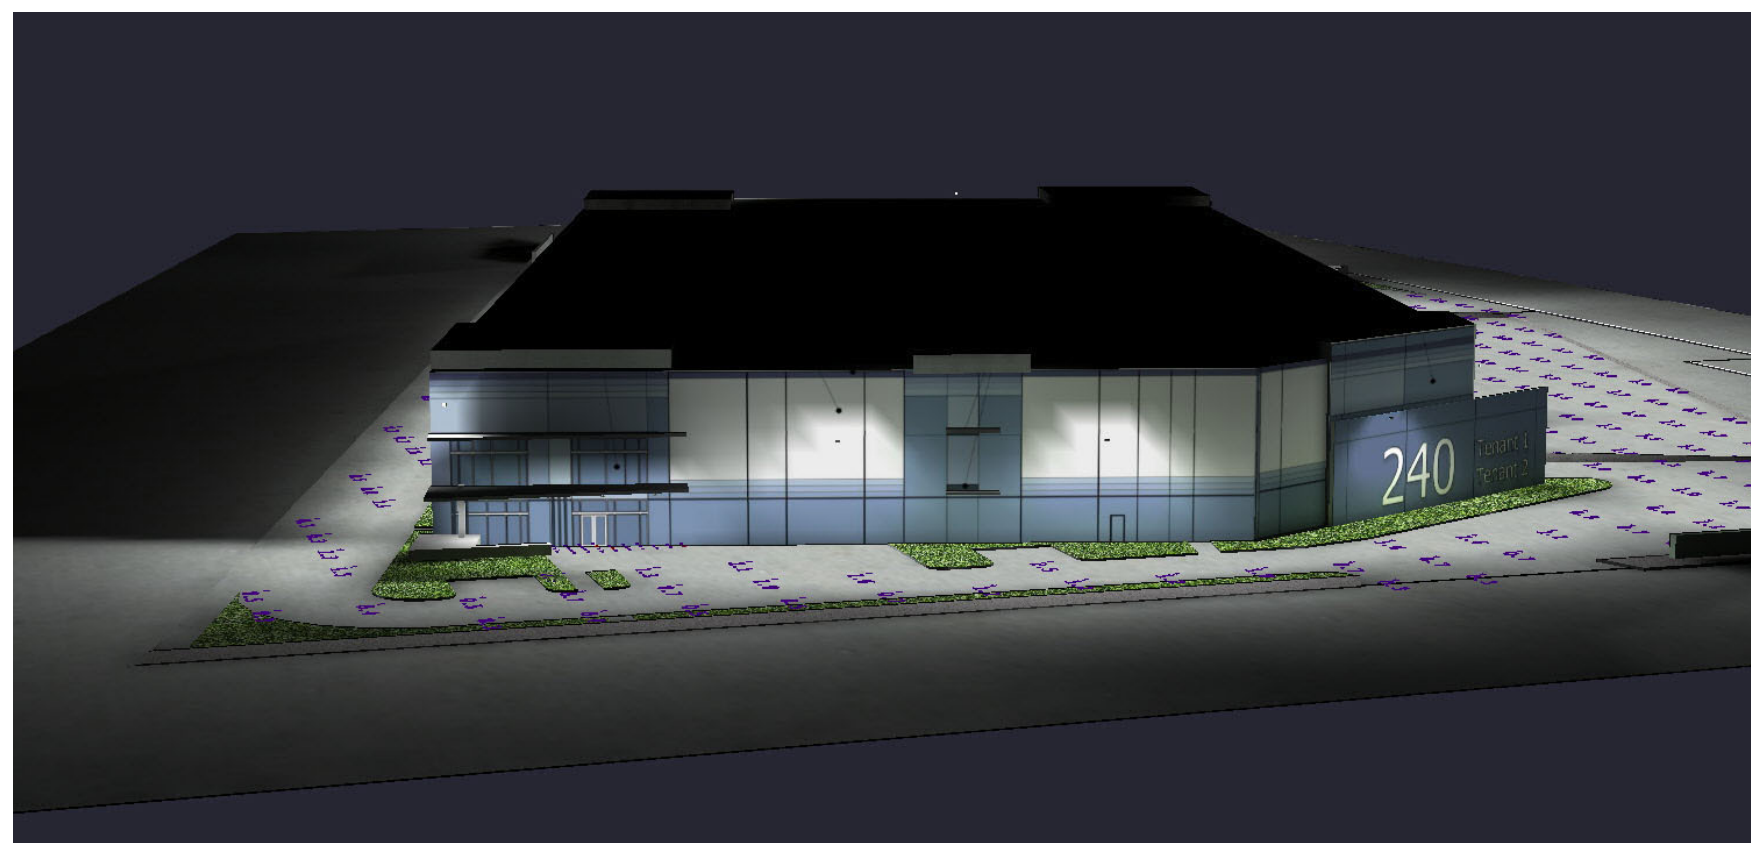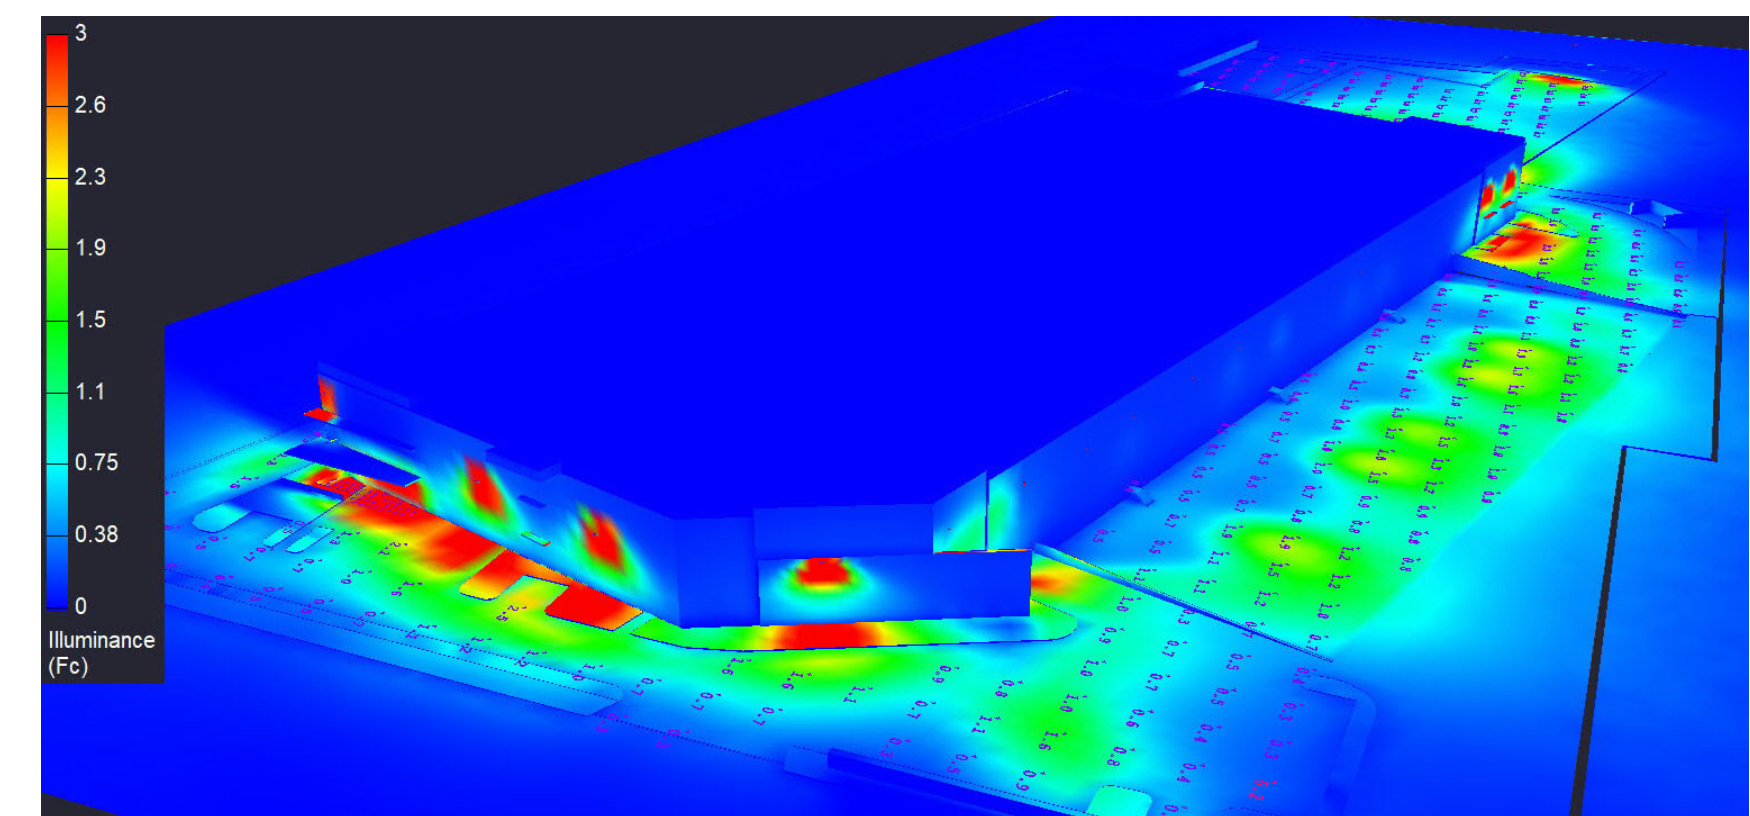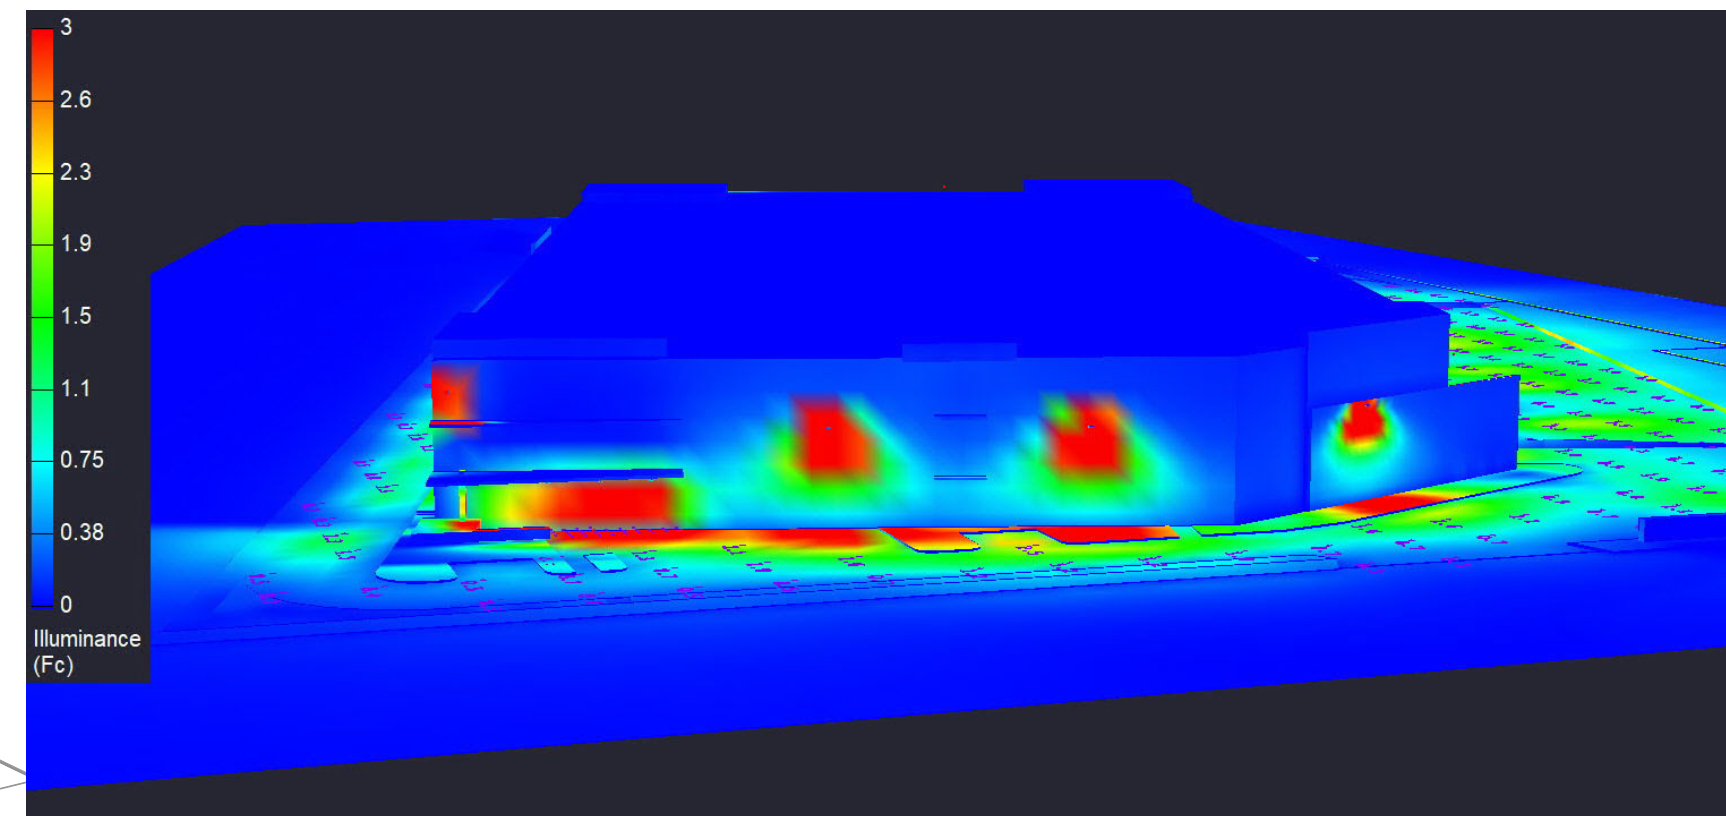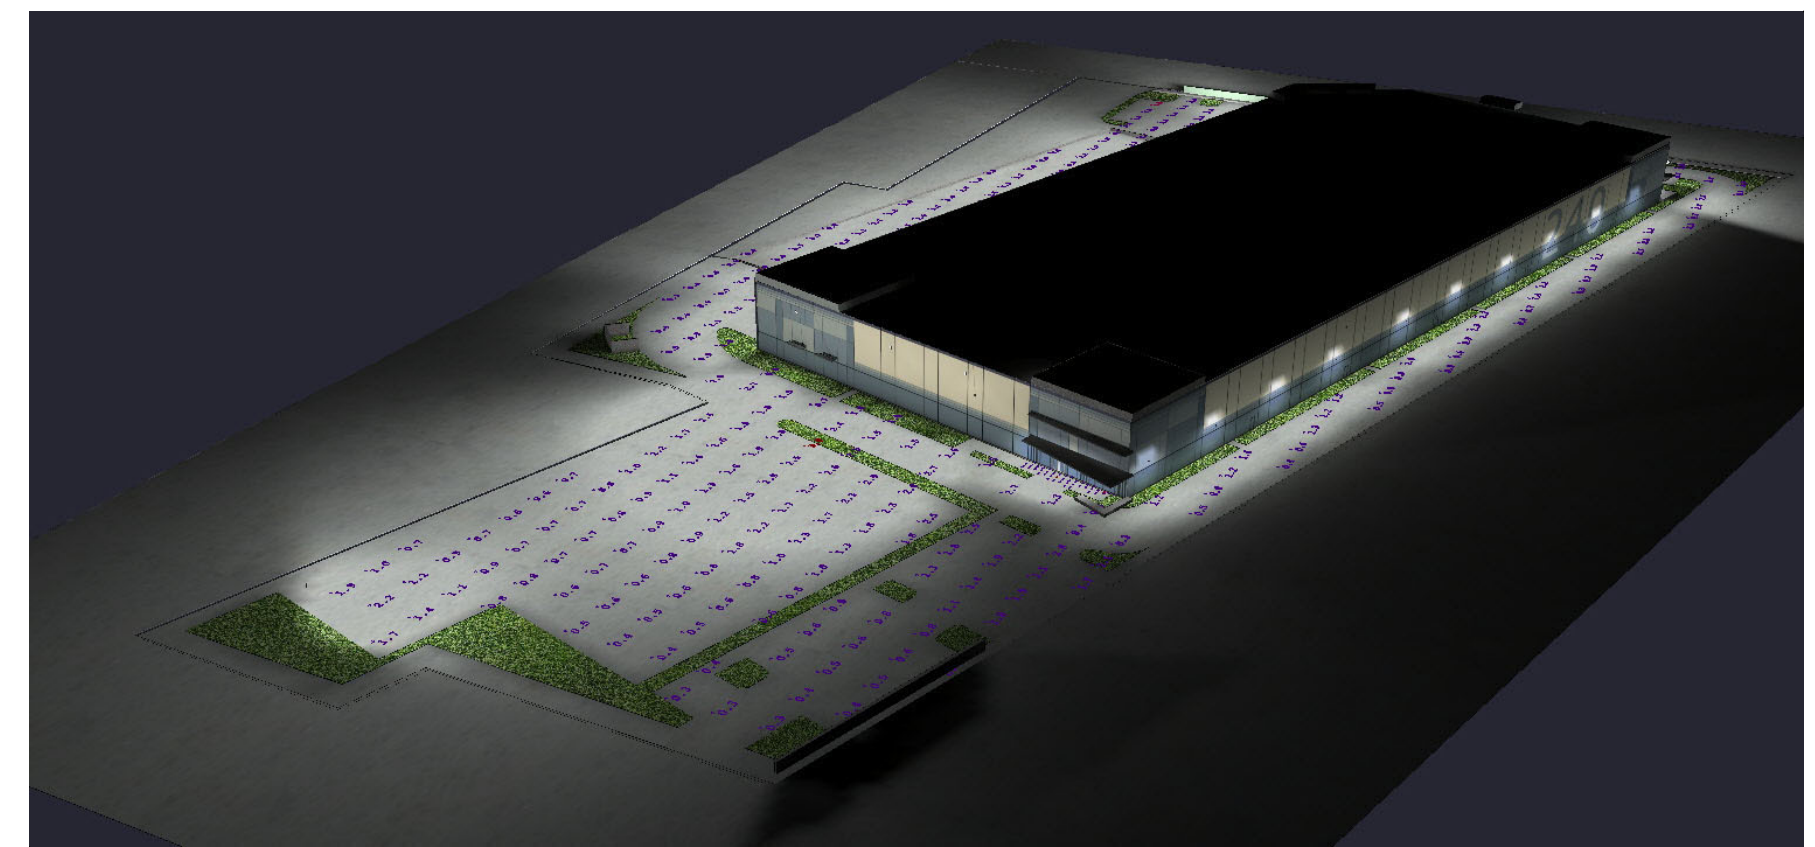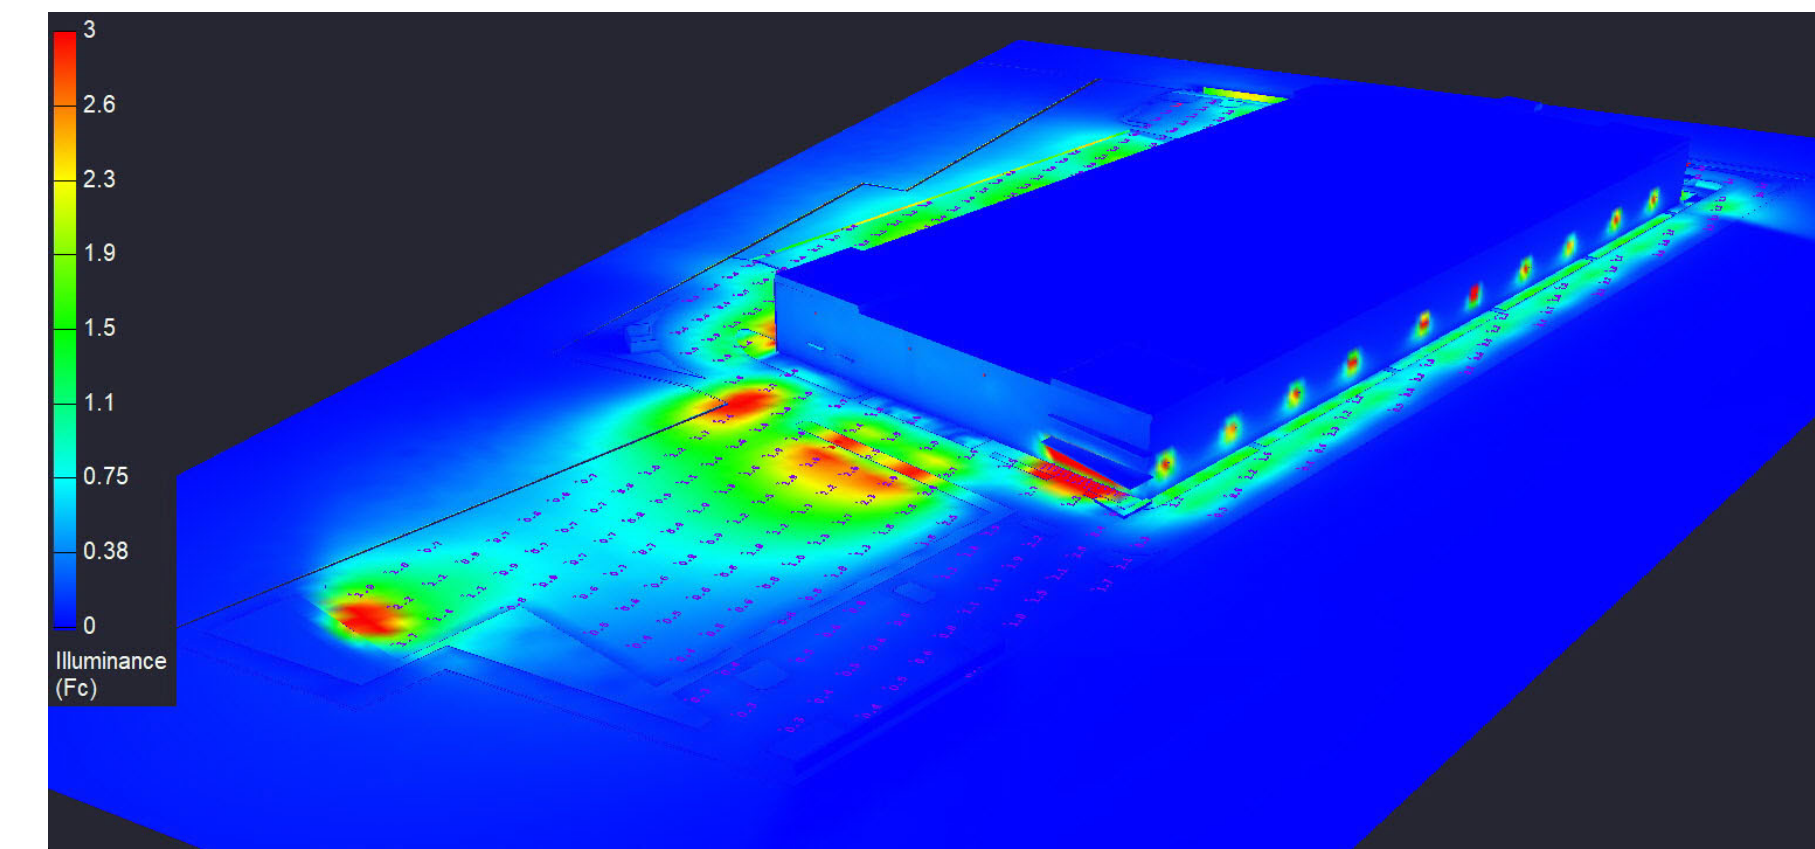

THE LIGHTING GROUP

Comments

Comments here

Drawn By: LMG

Checked By:

Date: 10/24/2022

Scale: NONE

CREF3 PUYALLUP OWNER LLC
REVISED SITE LIGHTING CALCS